

VA Northern Indiana Health Care System  
Ft. Wayne - Campus  
2121 Lake Avenue  
Ft. Wayne, Indiana 46805

*Project Title:* **Interior Halls & Walls**



Project Number: 610A4-11-149

## INDEX OF SHEETS:


C-101	COVER SHEET
A-101	FLOOR PLAN - 1ST & 2ND Floors
A-102	FLOOR PLAN - 3RD & 4TH Floors
A-103	FLOOR PLAN - 5TH Floor & BASEMENT
A-104	RCP 1ST FLOOR
A-105	RCP 2ND FLOOR
A-106	RCP 3RD FLOOR
A-107	RCP 4TH FLOOR
A-108	RCP 5TH FLOOR & BASEMENT
A-201	FINISH PLAN 1ST & 2ND FLOOR
A-202	FINISH PLAN 3RD & 4TH FLOOR
A-203	FINISH PLAN 5TH FLOOR & BASEMENT
A-204	FINISH SCHEDULE
A-301	REFLECTED CEILING PLAN 1ST & 2ND FLOOR
A-302	REFLECTED CEILING PLAN 3RD & 4TH FLOOR
A-303	REFLECTED CEILING PLAN 5TH FLOOR & BASEMENT

## ABBREVIATIONS & LEGEND:

AFF. Above Finished Floor  
App. Approximate  
¢. Center Line  
dia. Diameter  
(E) Existing  
(F) Existing  
Max. Maximum  
Min. Minimum  
(N) New  
NEMA, National Electrical Manufacturers Association.  
o.c. On Center  
Ø. Diameter  
O.S.B. Oriented Strand Board  
P.S.I. Pounds per square inch

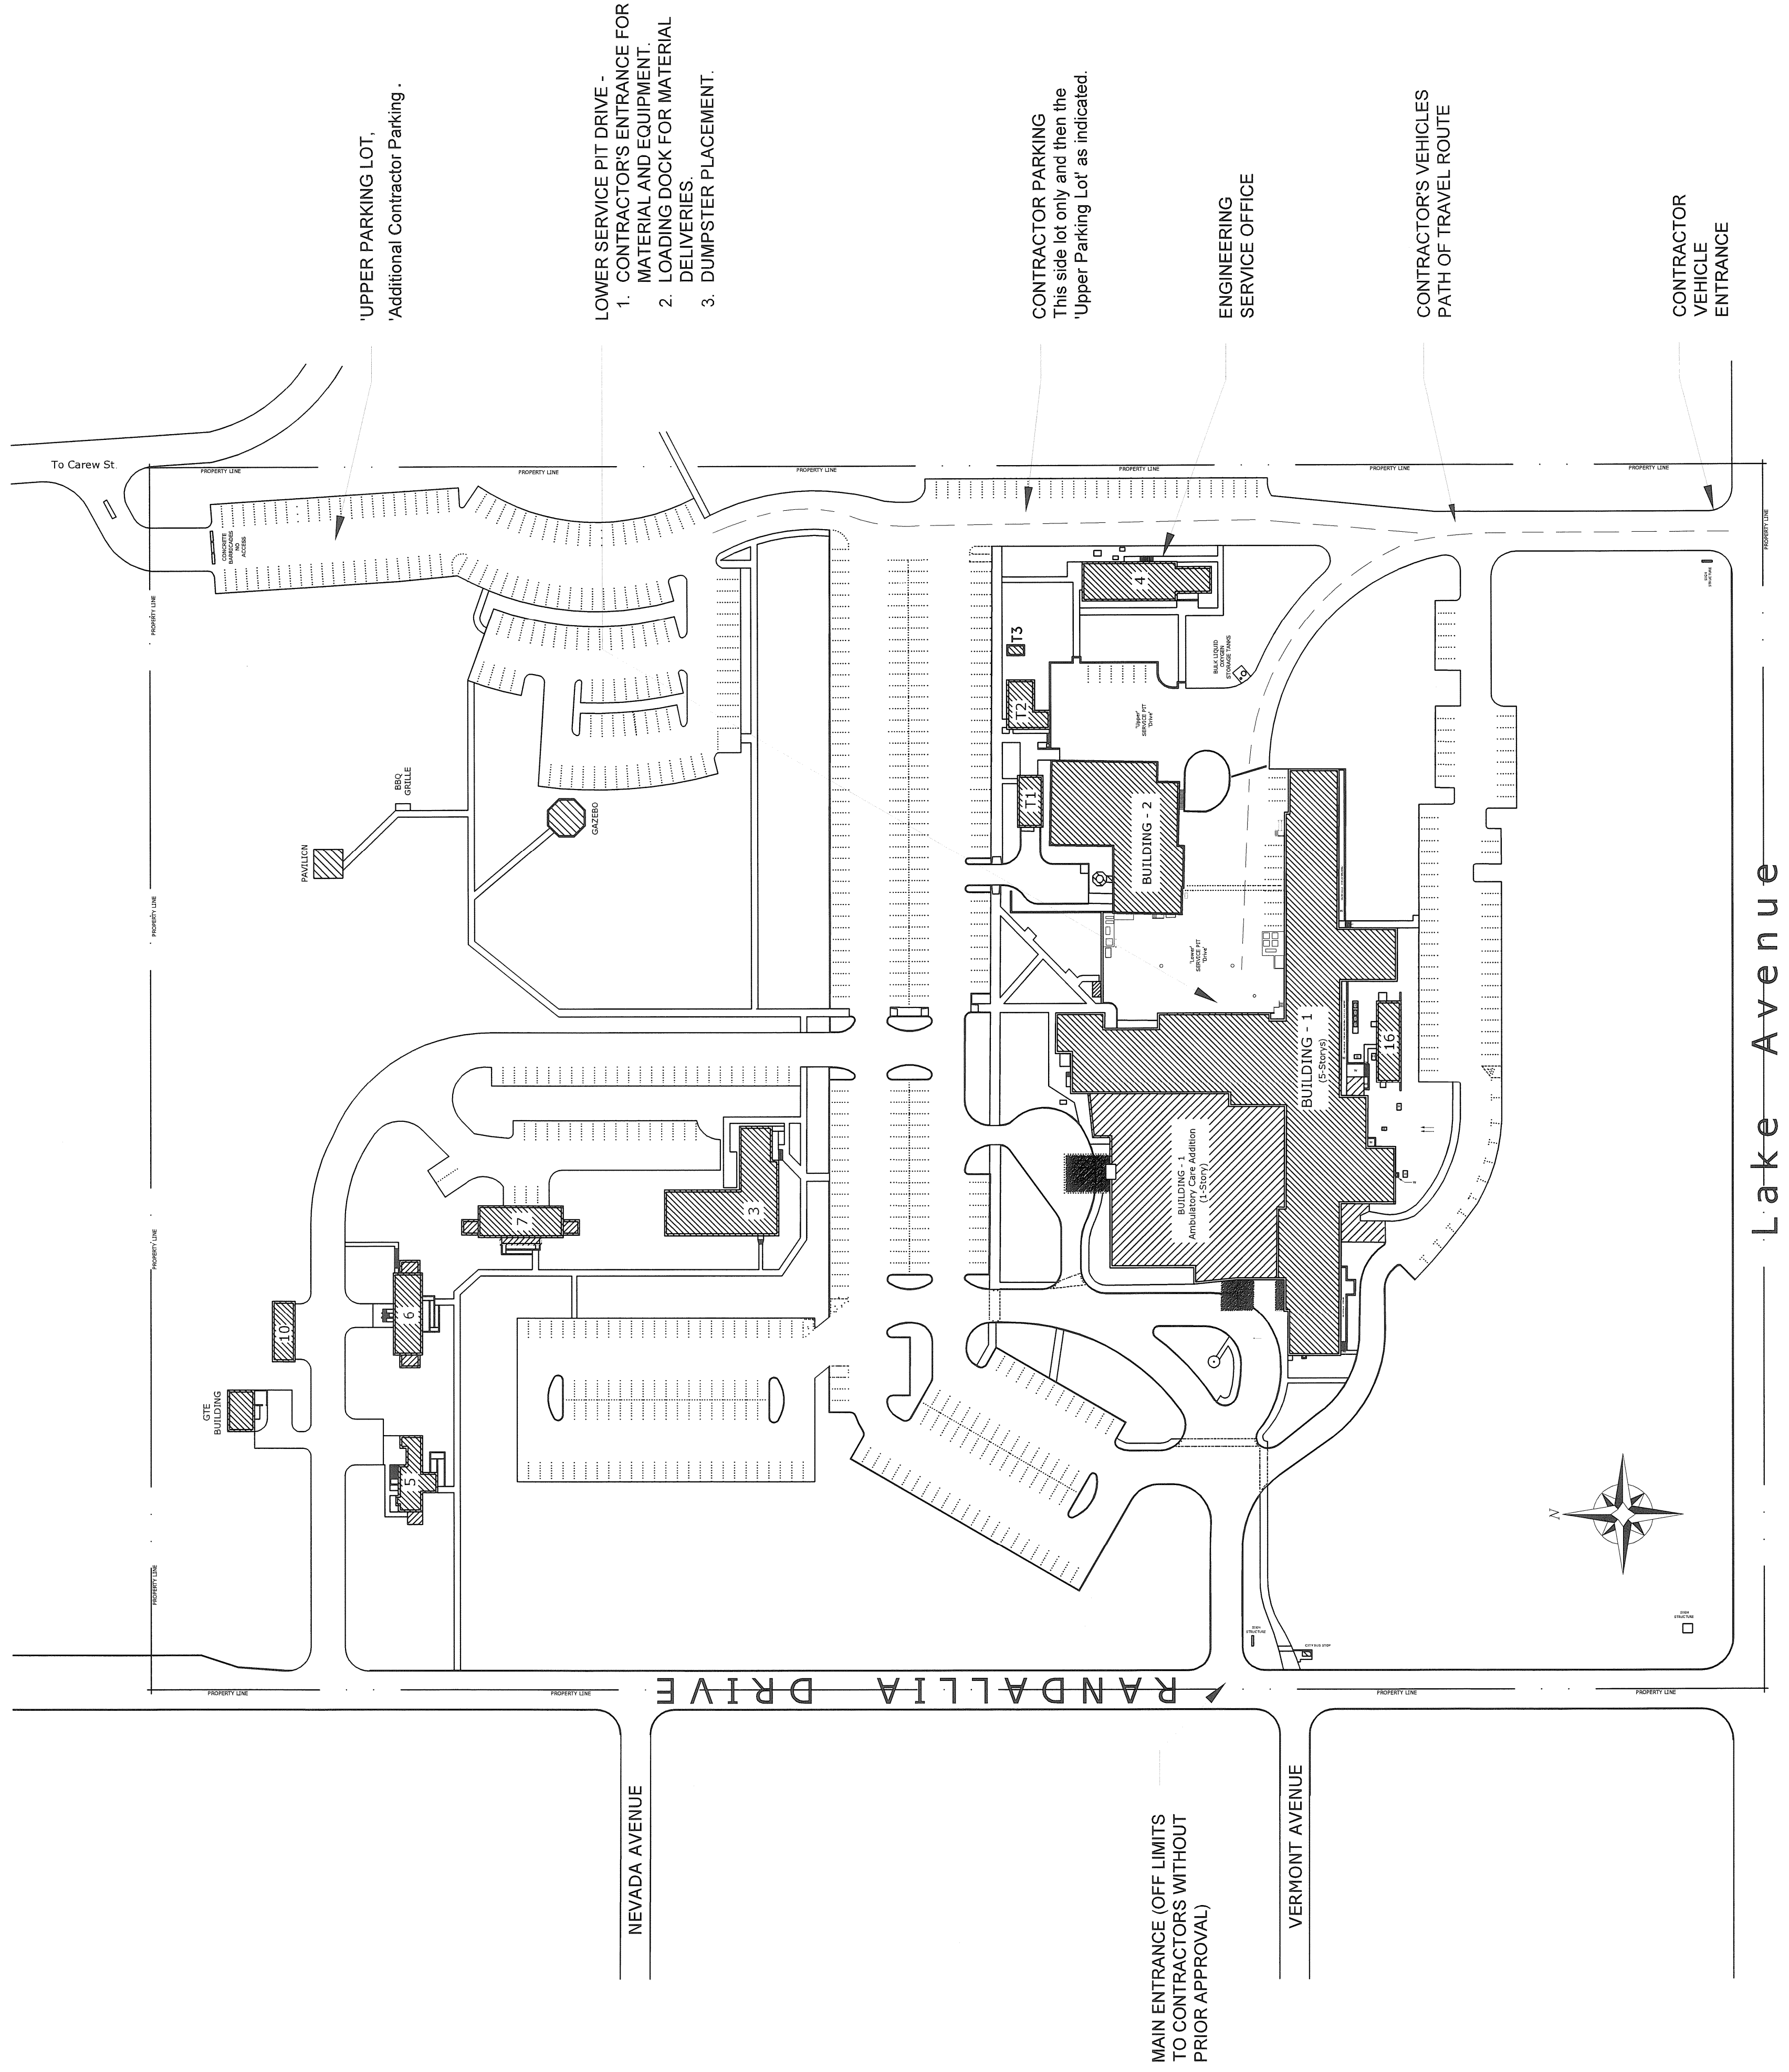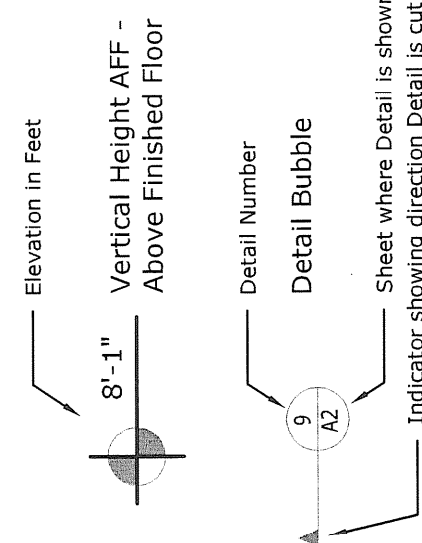

1 GENERAL SITE PLAN  
NOT TO SCALE

<p>VA Northern Indiana Health Care System,  Fort Wayne  2121 Lake Avenue  Fort Wayne, IN 46805</p>			
<p>Project Number  610A4-11-149</p>		<p>Project Title  INTERIOR HALLS &amp; WALLS</p>	
<p>Building Number  B-1</p>		<p>Drawing Number  C-101</p>	
<p>Drawing Title  COVER SHEET</p>		<p>Location  VANIHCs, Ft. Wayne, IN</p>	
<p>Approved: Medical Center Director  Daniel D. Hinkle, FAHE</p>		<p>Date  8 AUG. 2011</p>	
<p>Approved: Associate Director for Operations  Heidi Hinkle</p>		<p>Checked  CDA</p>	
<p>Approved: Engineering Services  Charles Applewhite</p>		<p>Drawn  VM</p>	
<p>Approved: _____</p>		<p>Dwg. - of -</p>	