

A

B

C

D

E

F

G

H

A

B

C



D

E

F





G

H

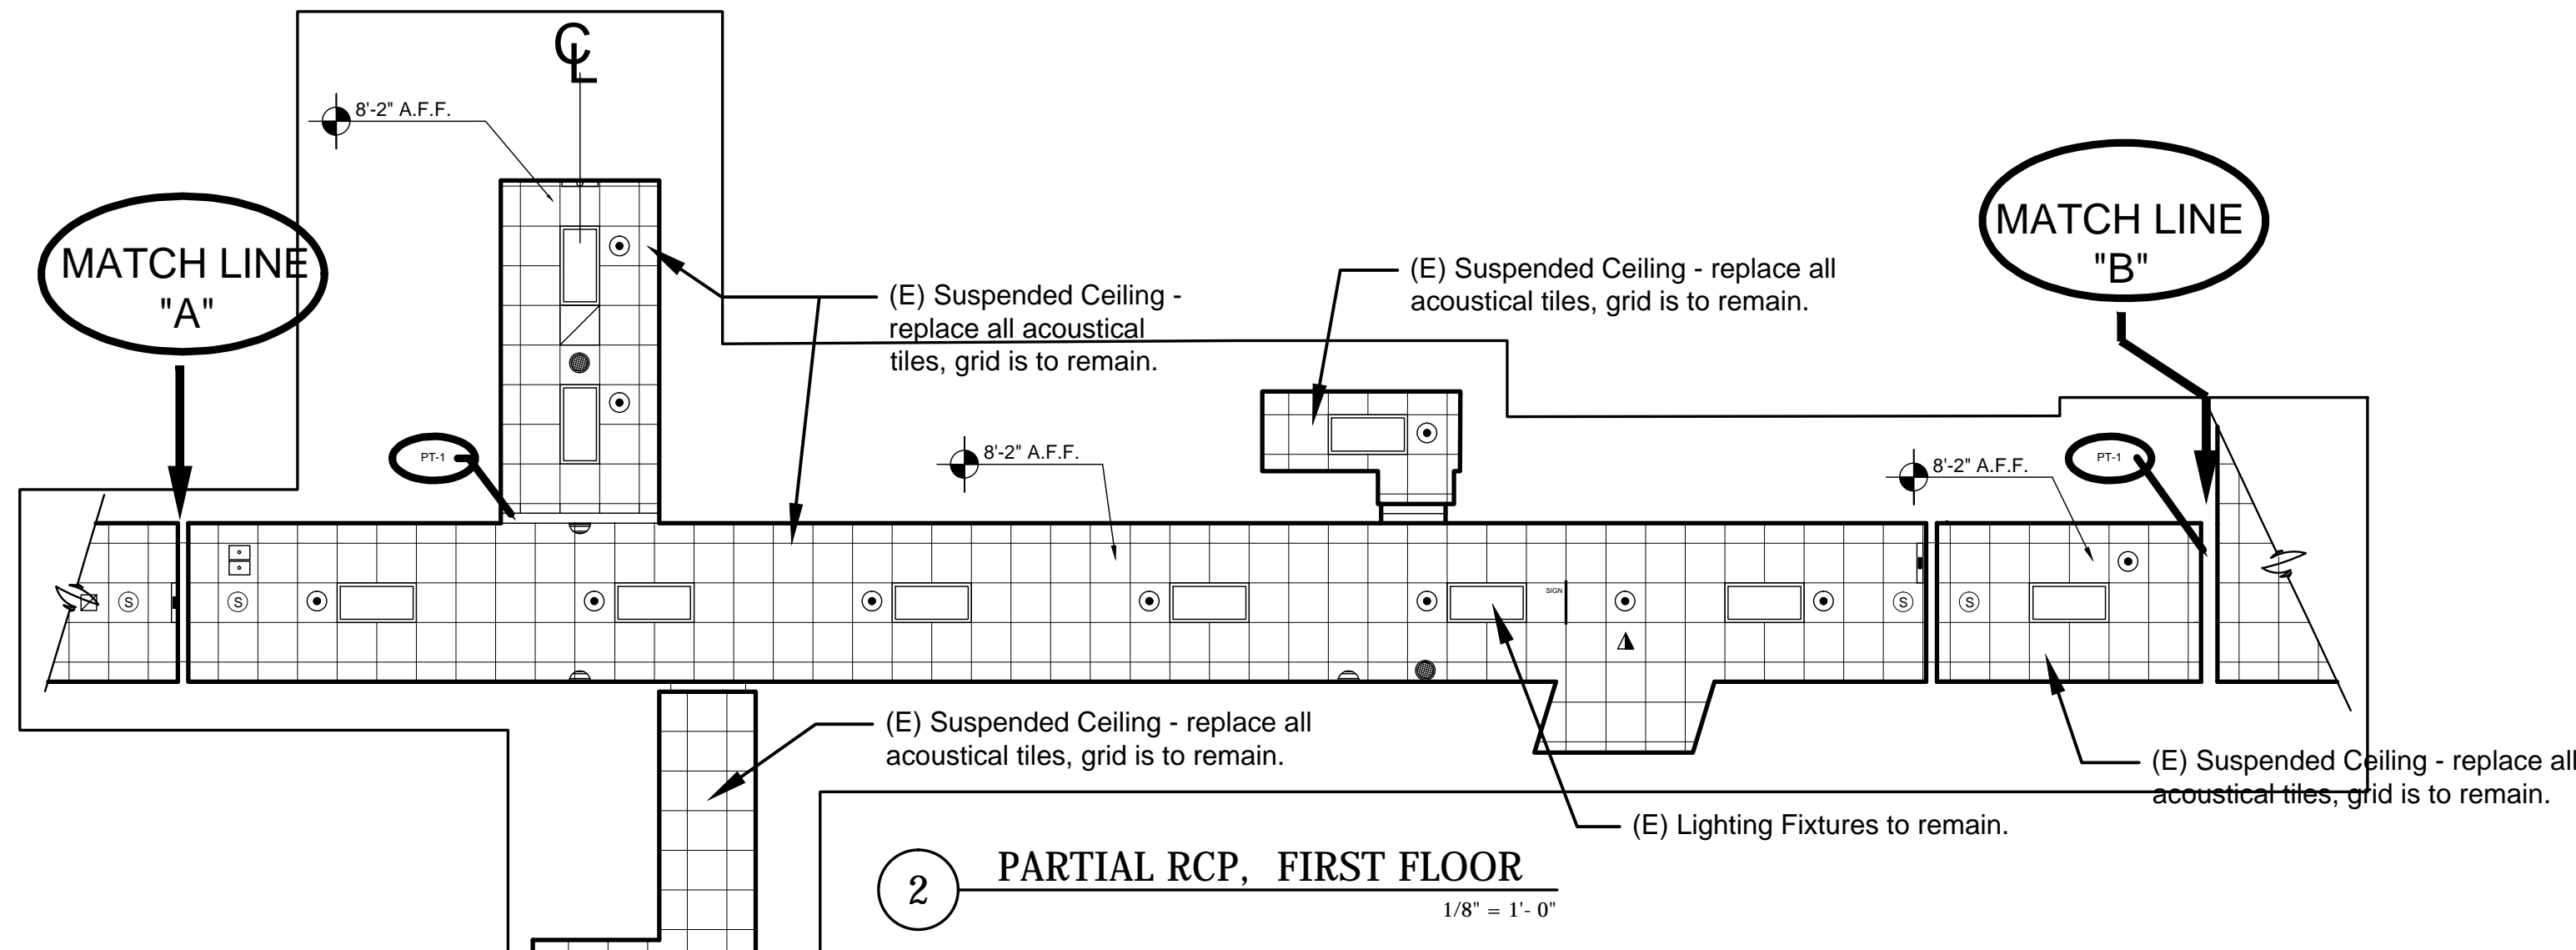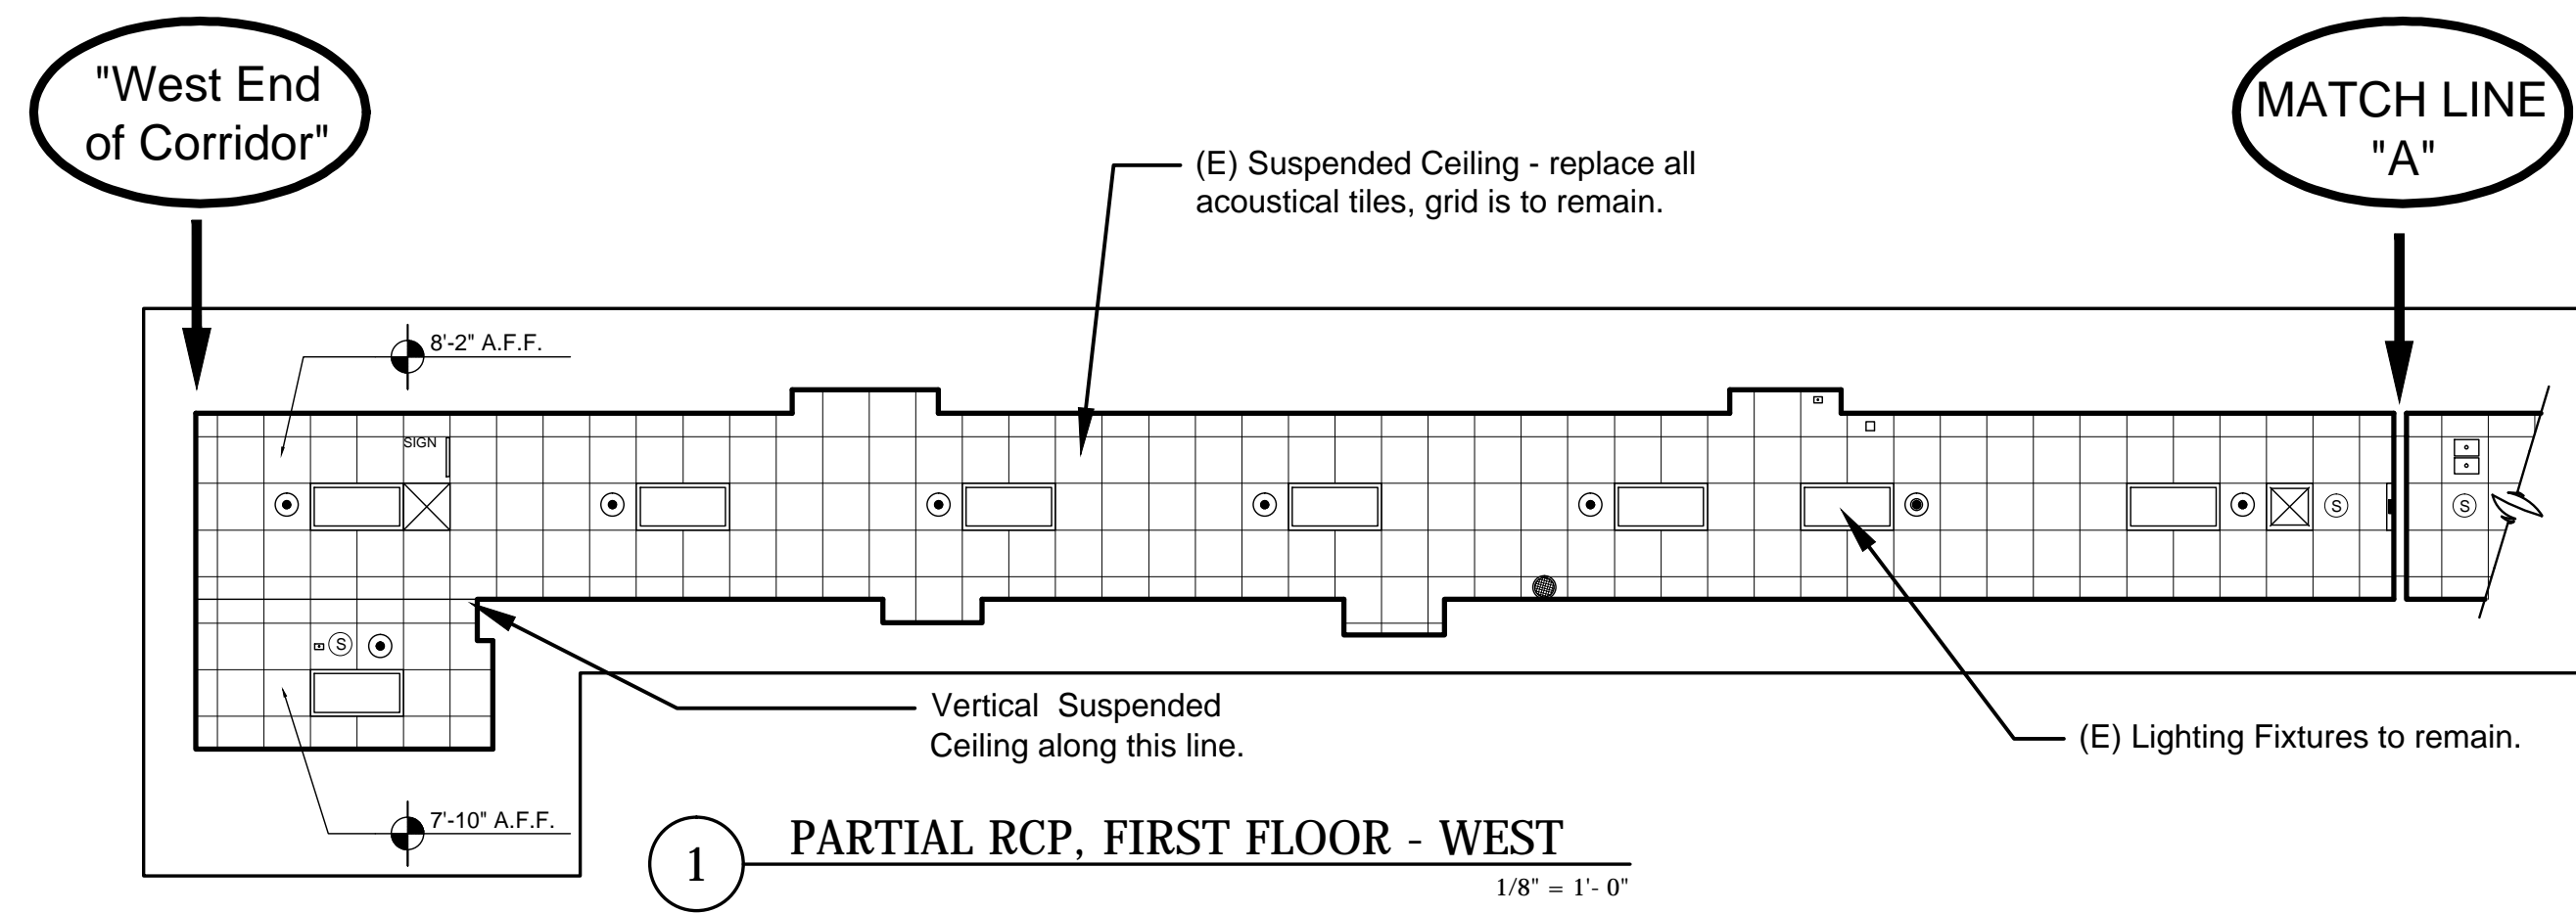

- CEILING DEMOLITION PLAN GENERAL NOTES:
1. DISMOUNT AND RETAIN CEILING MOUNTED ITEMS INCLUDING EXISTING LIGHTING FIXTURES. PRESERVE THESE ITEMS FOR RE-INSTALLATION (I.E. EXIT LIGHTS, ESCUTCHEONS, BEAUTY RINGS, SIGNS, CURTAIN/CURTAIN TRACK, SMOKE DETECTORS, CAMERAS, SPEAKERS, ETC.). WORK INVOLVING EXIT LIGHTS, SPEAKERS, SMOKE DETECTORS, CAMERAS SHALL BE COORDINATED WITH THE COTR AND MUST REMAIN IN OPERATION THROUGHOUT THE DURATION OF THE PROJECT.
 2. REMOVE AND DISPOSE OF CEILING TILES. EXISTING CEILING GRID TO REMAIN UNALTERED AND UNDAMAGED. REPAIR CEILING GRID AS NEEDED.
 3. MIRRORS, DIFFUSERS, AND RETURN GRILLES SHALL REMAIN UNDAMAGED AND UNALTERED.
 4. EXISTING LIGHTING FIXTURES TO REMAIN. FOLLOW LOCKOUT/TAGOUT PROCEDURES. PROVIDE TEMPORARY LIGHTING AS NEEDED.
 5. ALL WORK SHALL BE PERFORMED IN CONFORMANCE WITH THE LATEST VERSION OF NEC.

RCP LEGEND	
	AC RETURN
	2' x 4' EXISTING FIXTURE
	SPRINKLER HEAD
	CAN DOWNLIGHT
	NURSE CALL LIGHT
	CEILING/GRID HUNG SIGNAGE
	SMOKE DETECTOR
	EXIT SIGN
	CEILING OUTLET
	METER
	SPEAKER
	S.S. PLATE
	GLOBE MIRROR
	GLOBE MIRROR
	MOTION DETECTOR
	ANTENNA
	FLUORESCENT TUBES/NEG. PRESSURE
	CONDUIT
	AIR RETURN

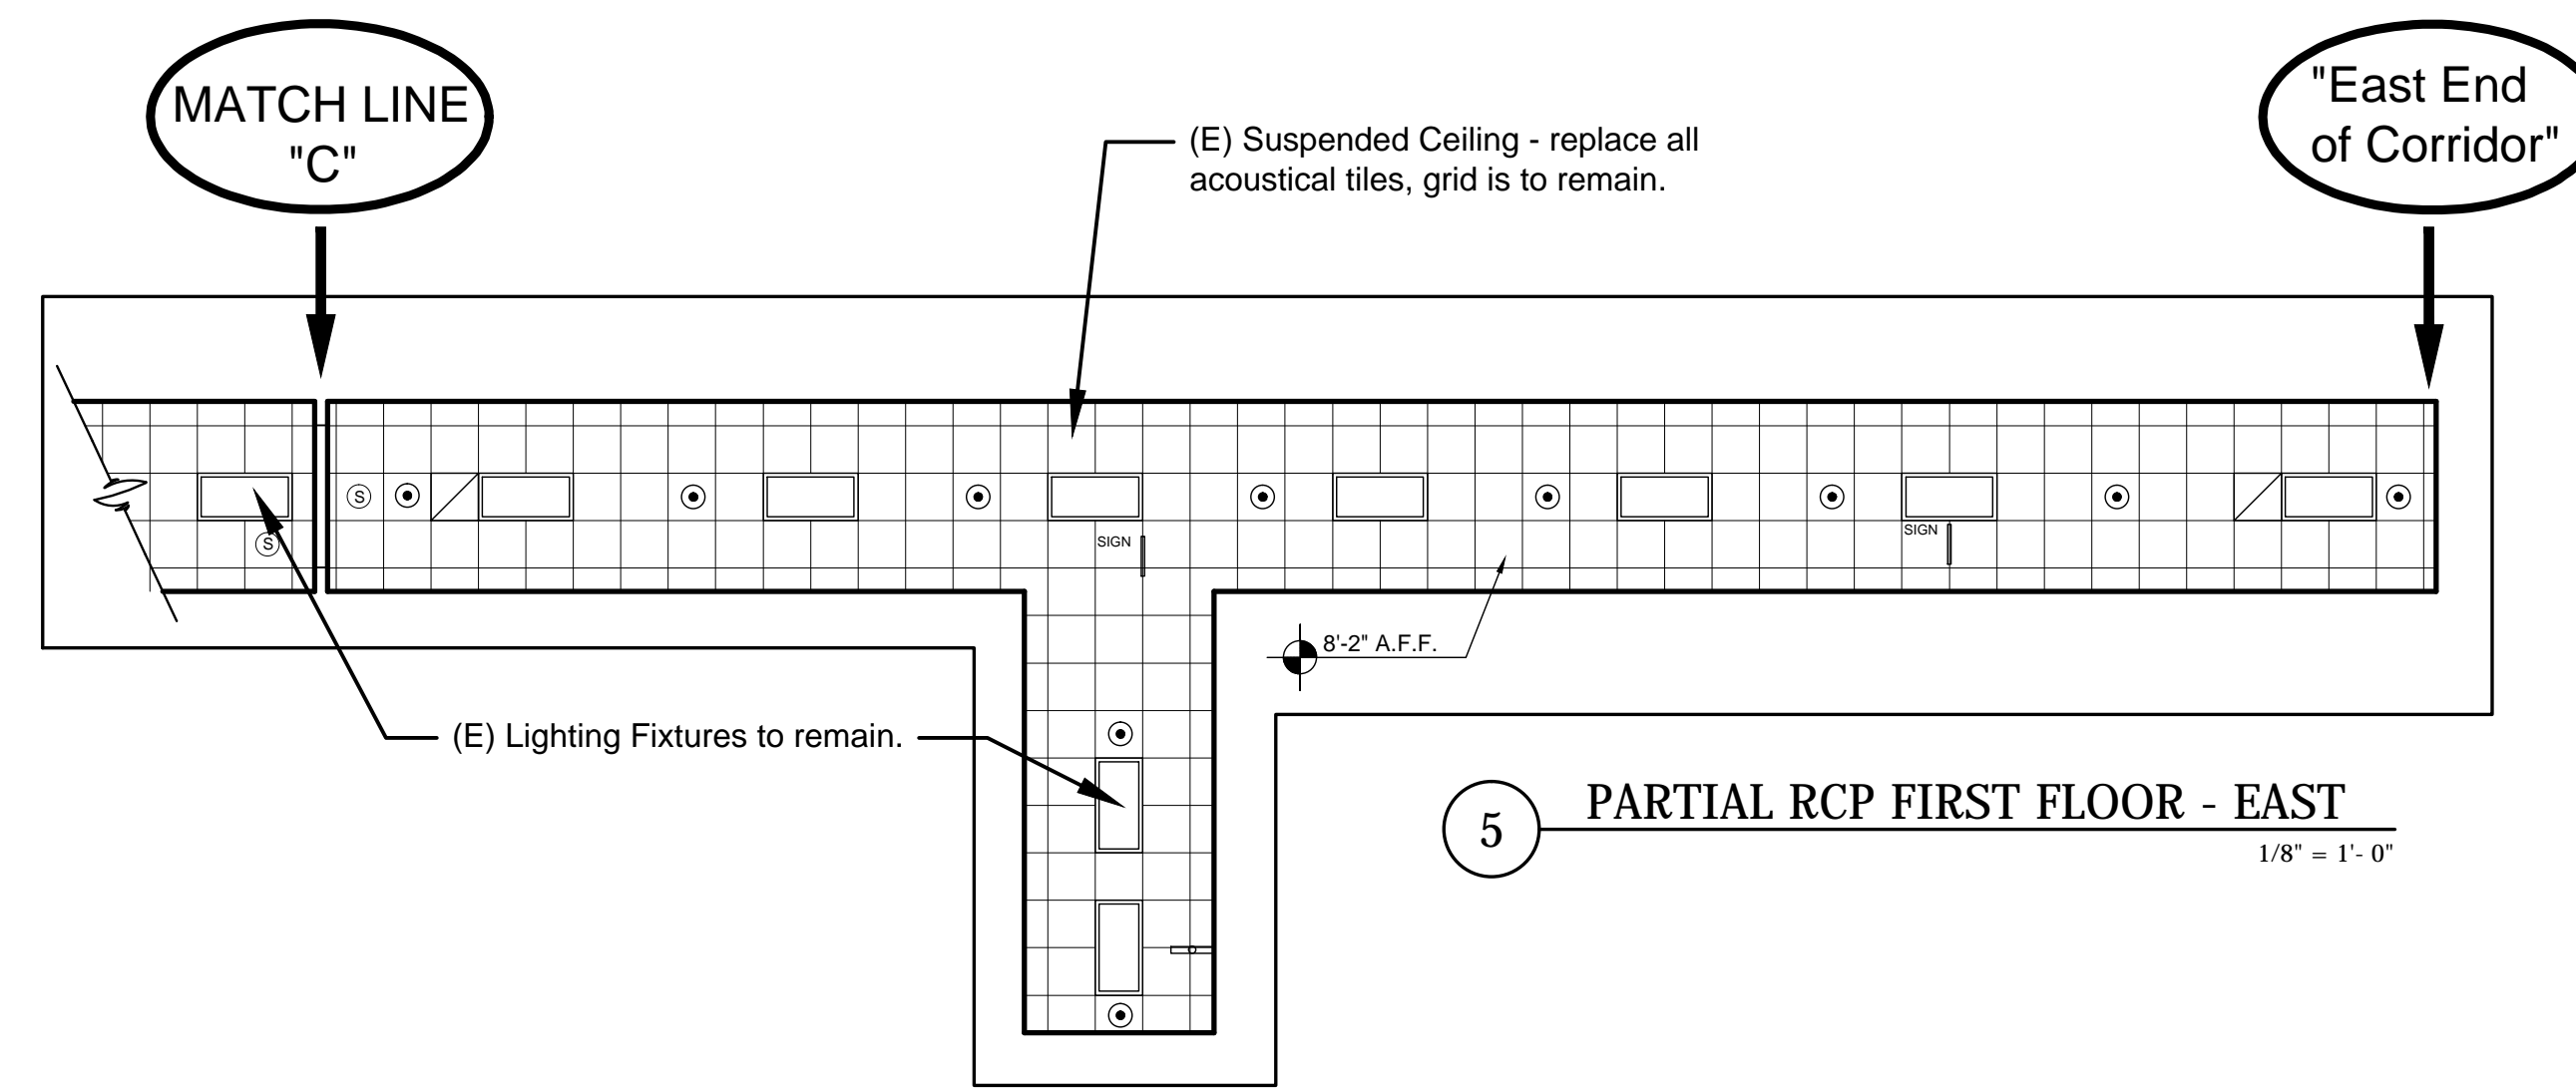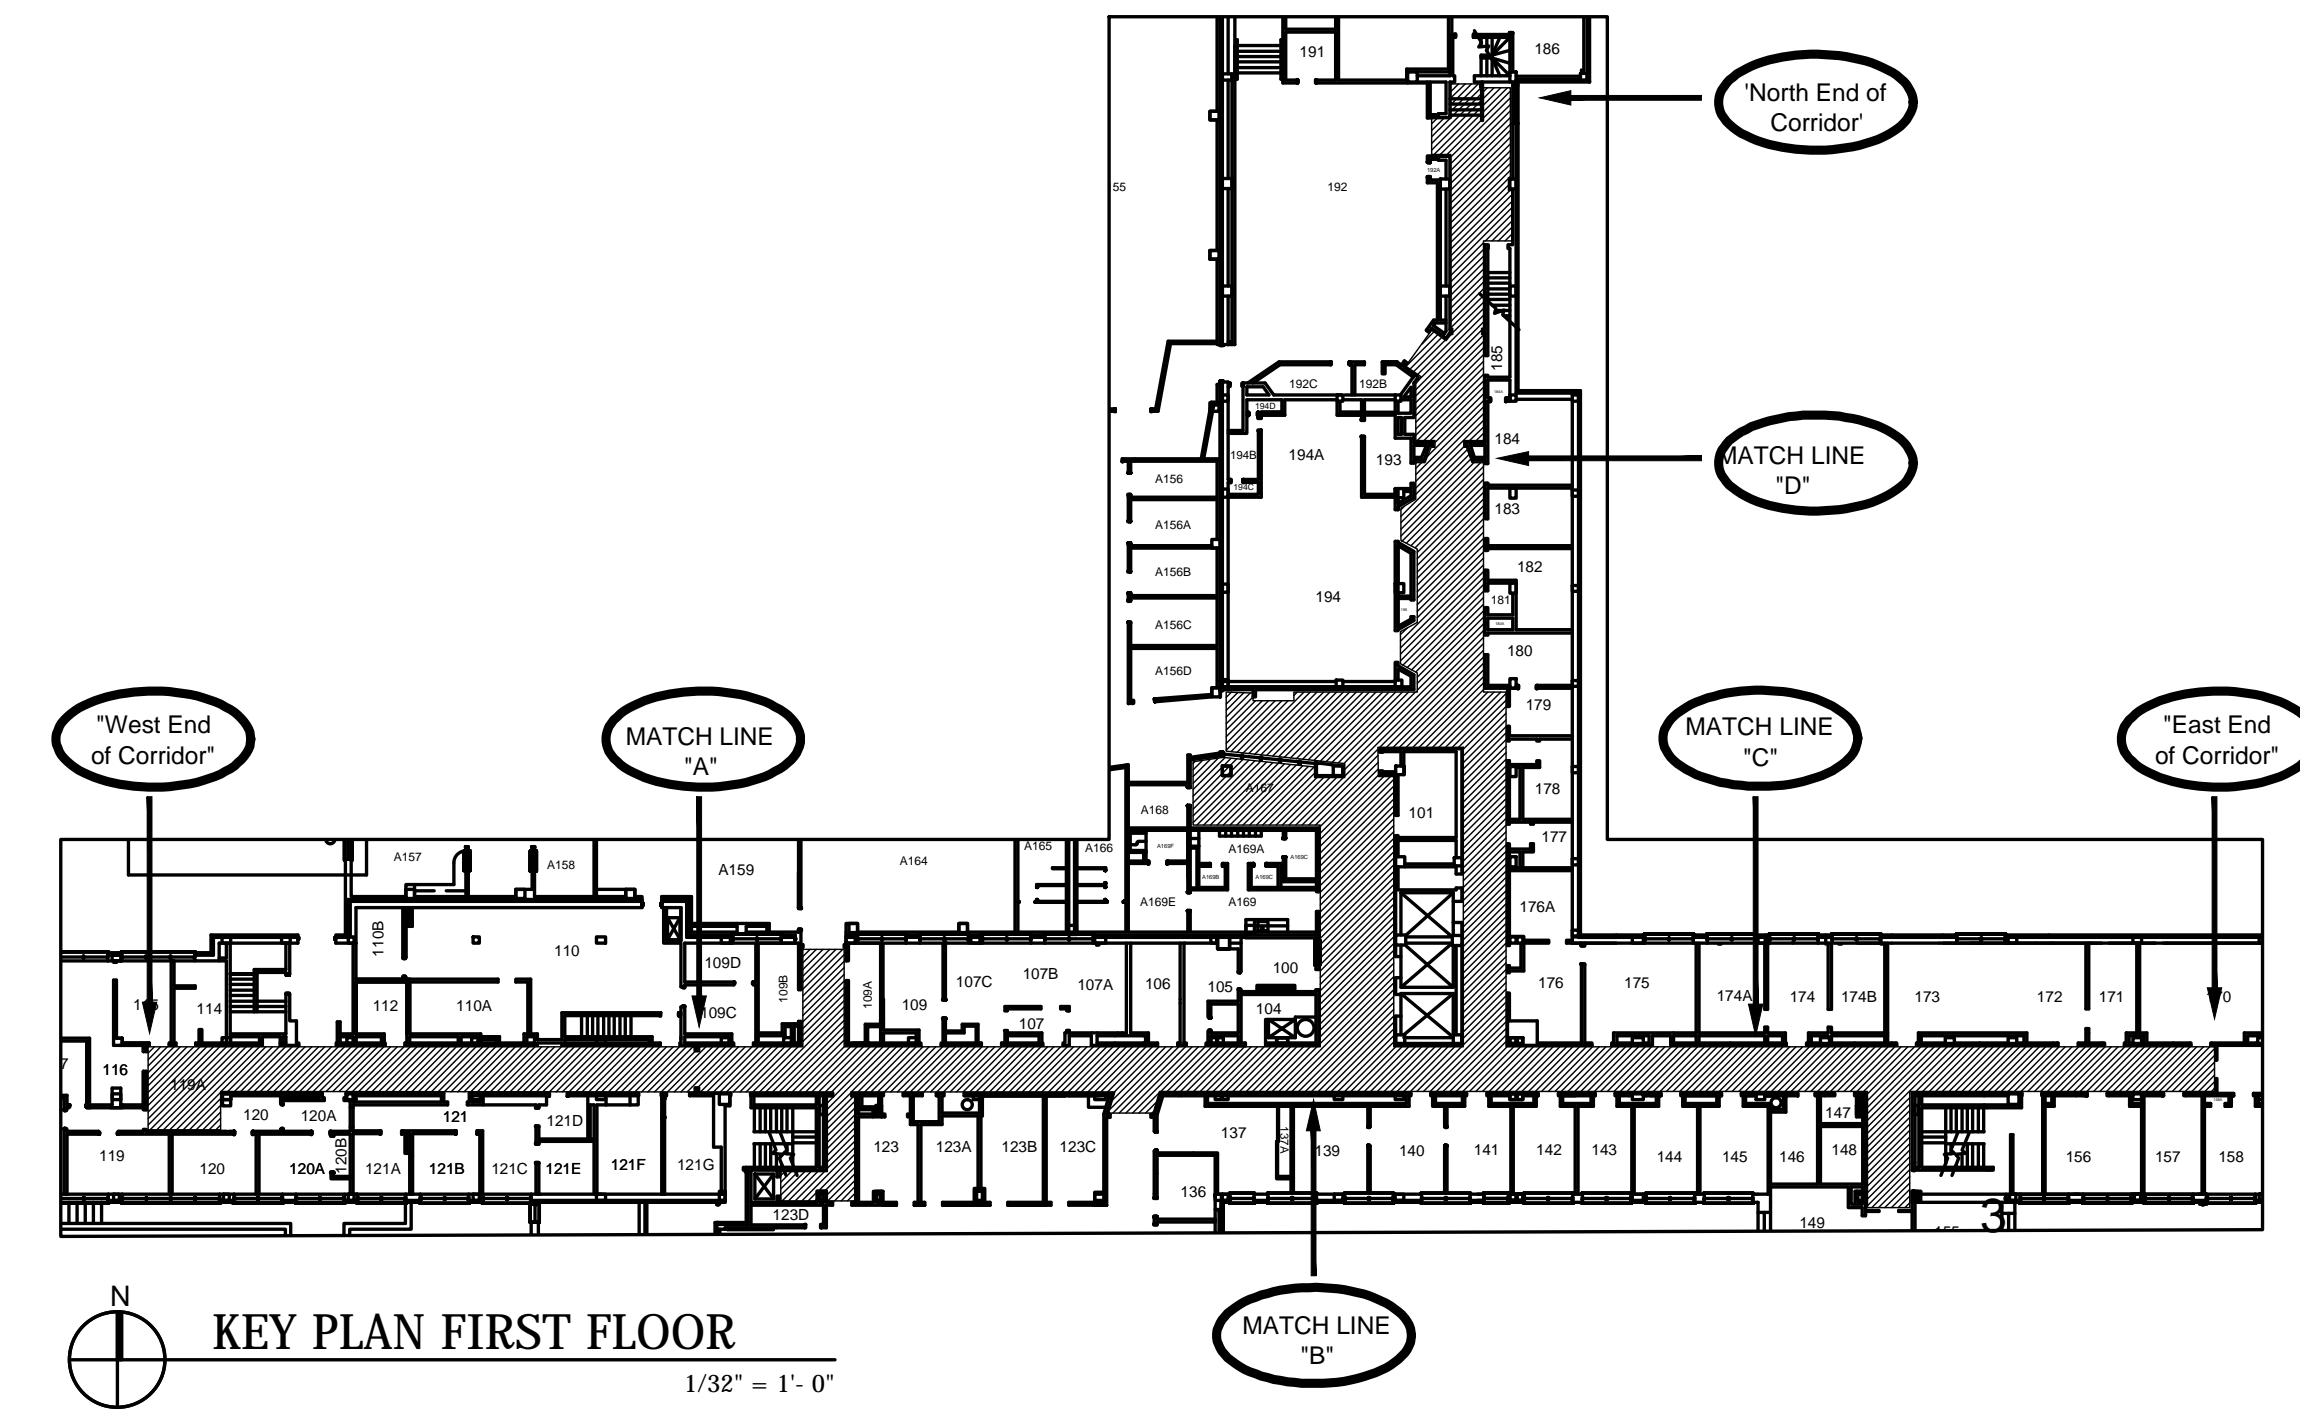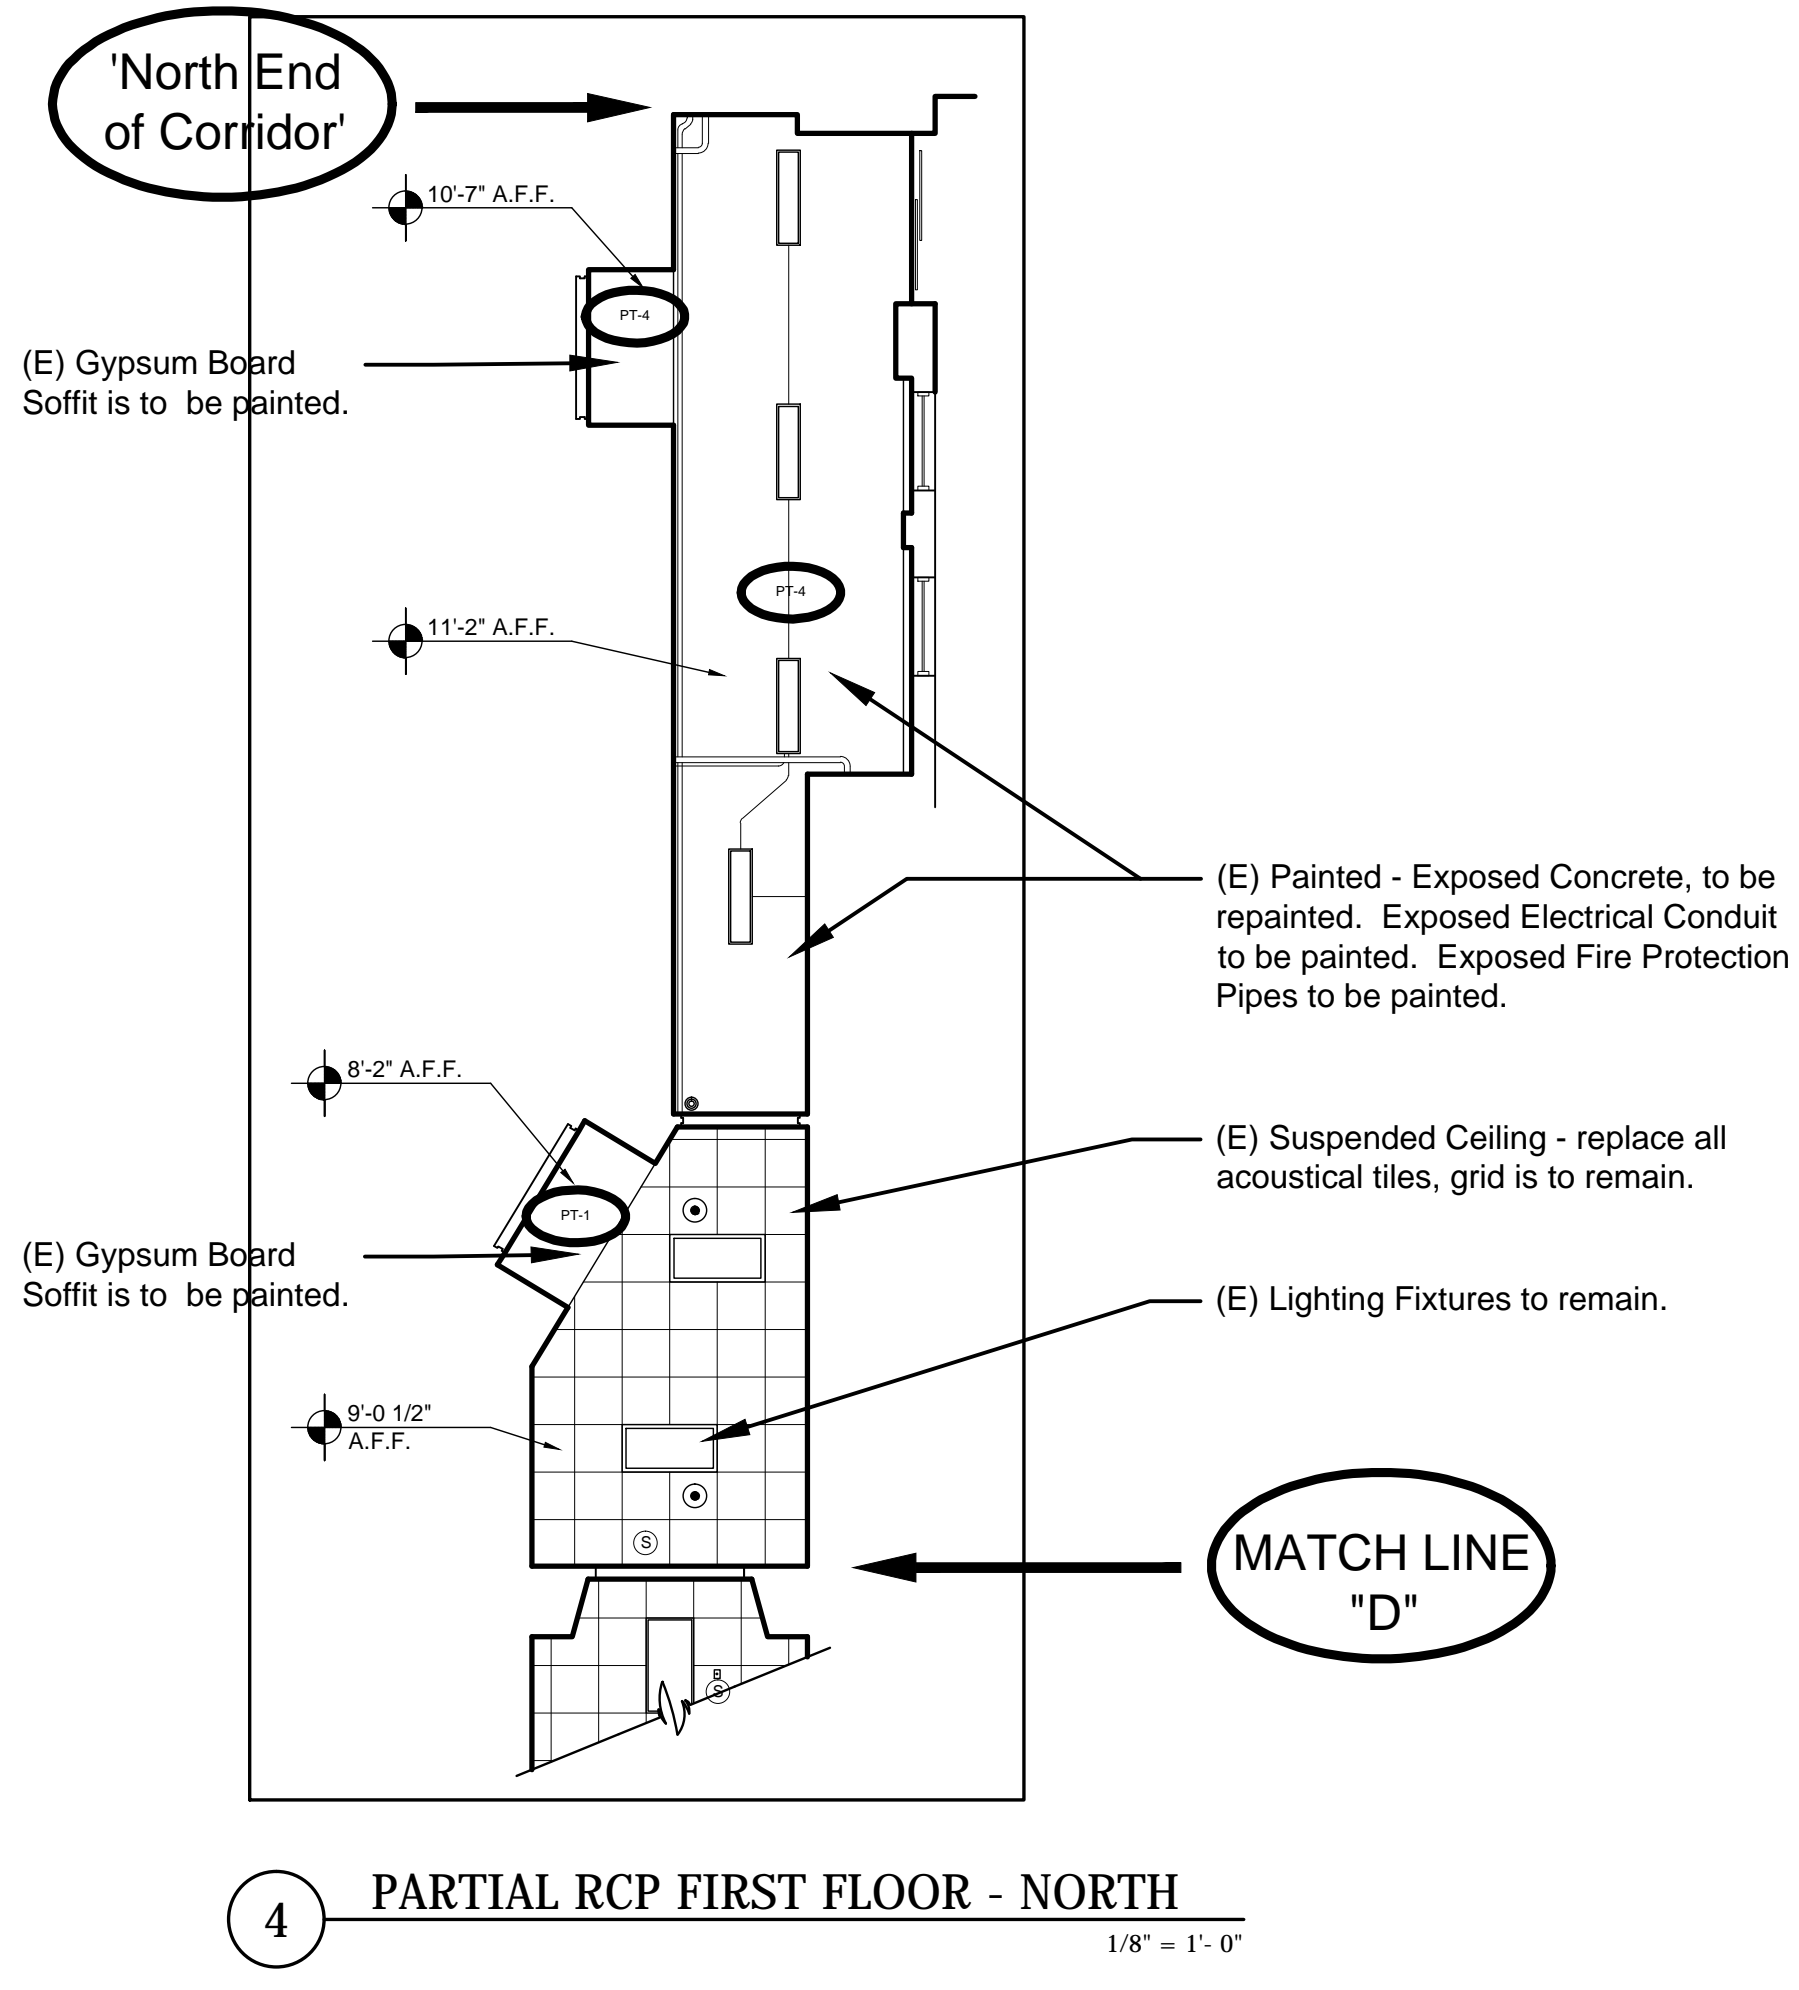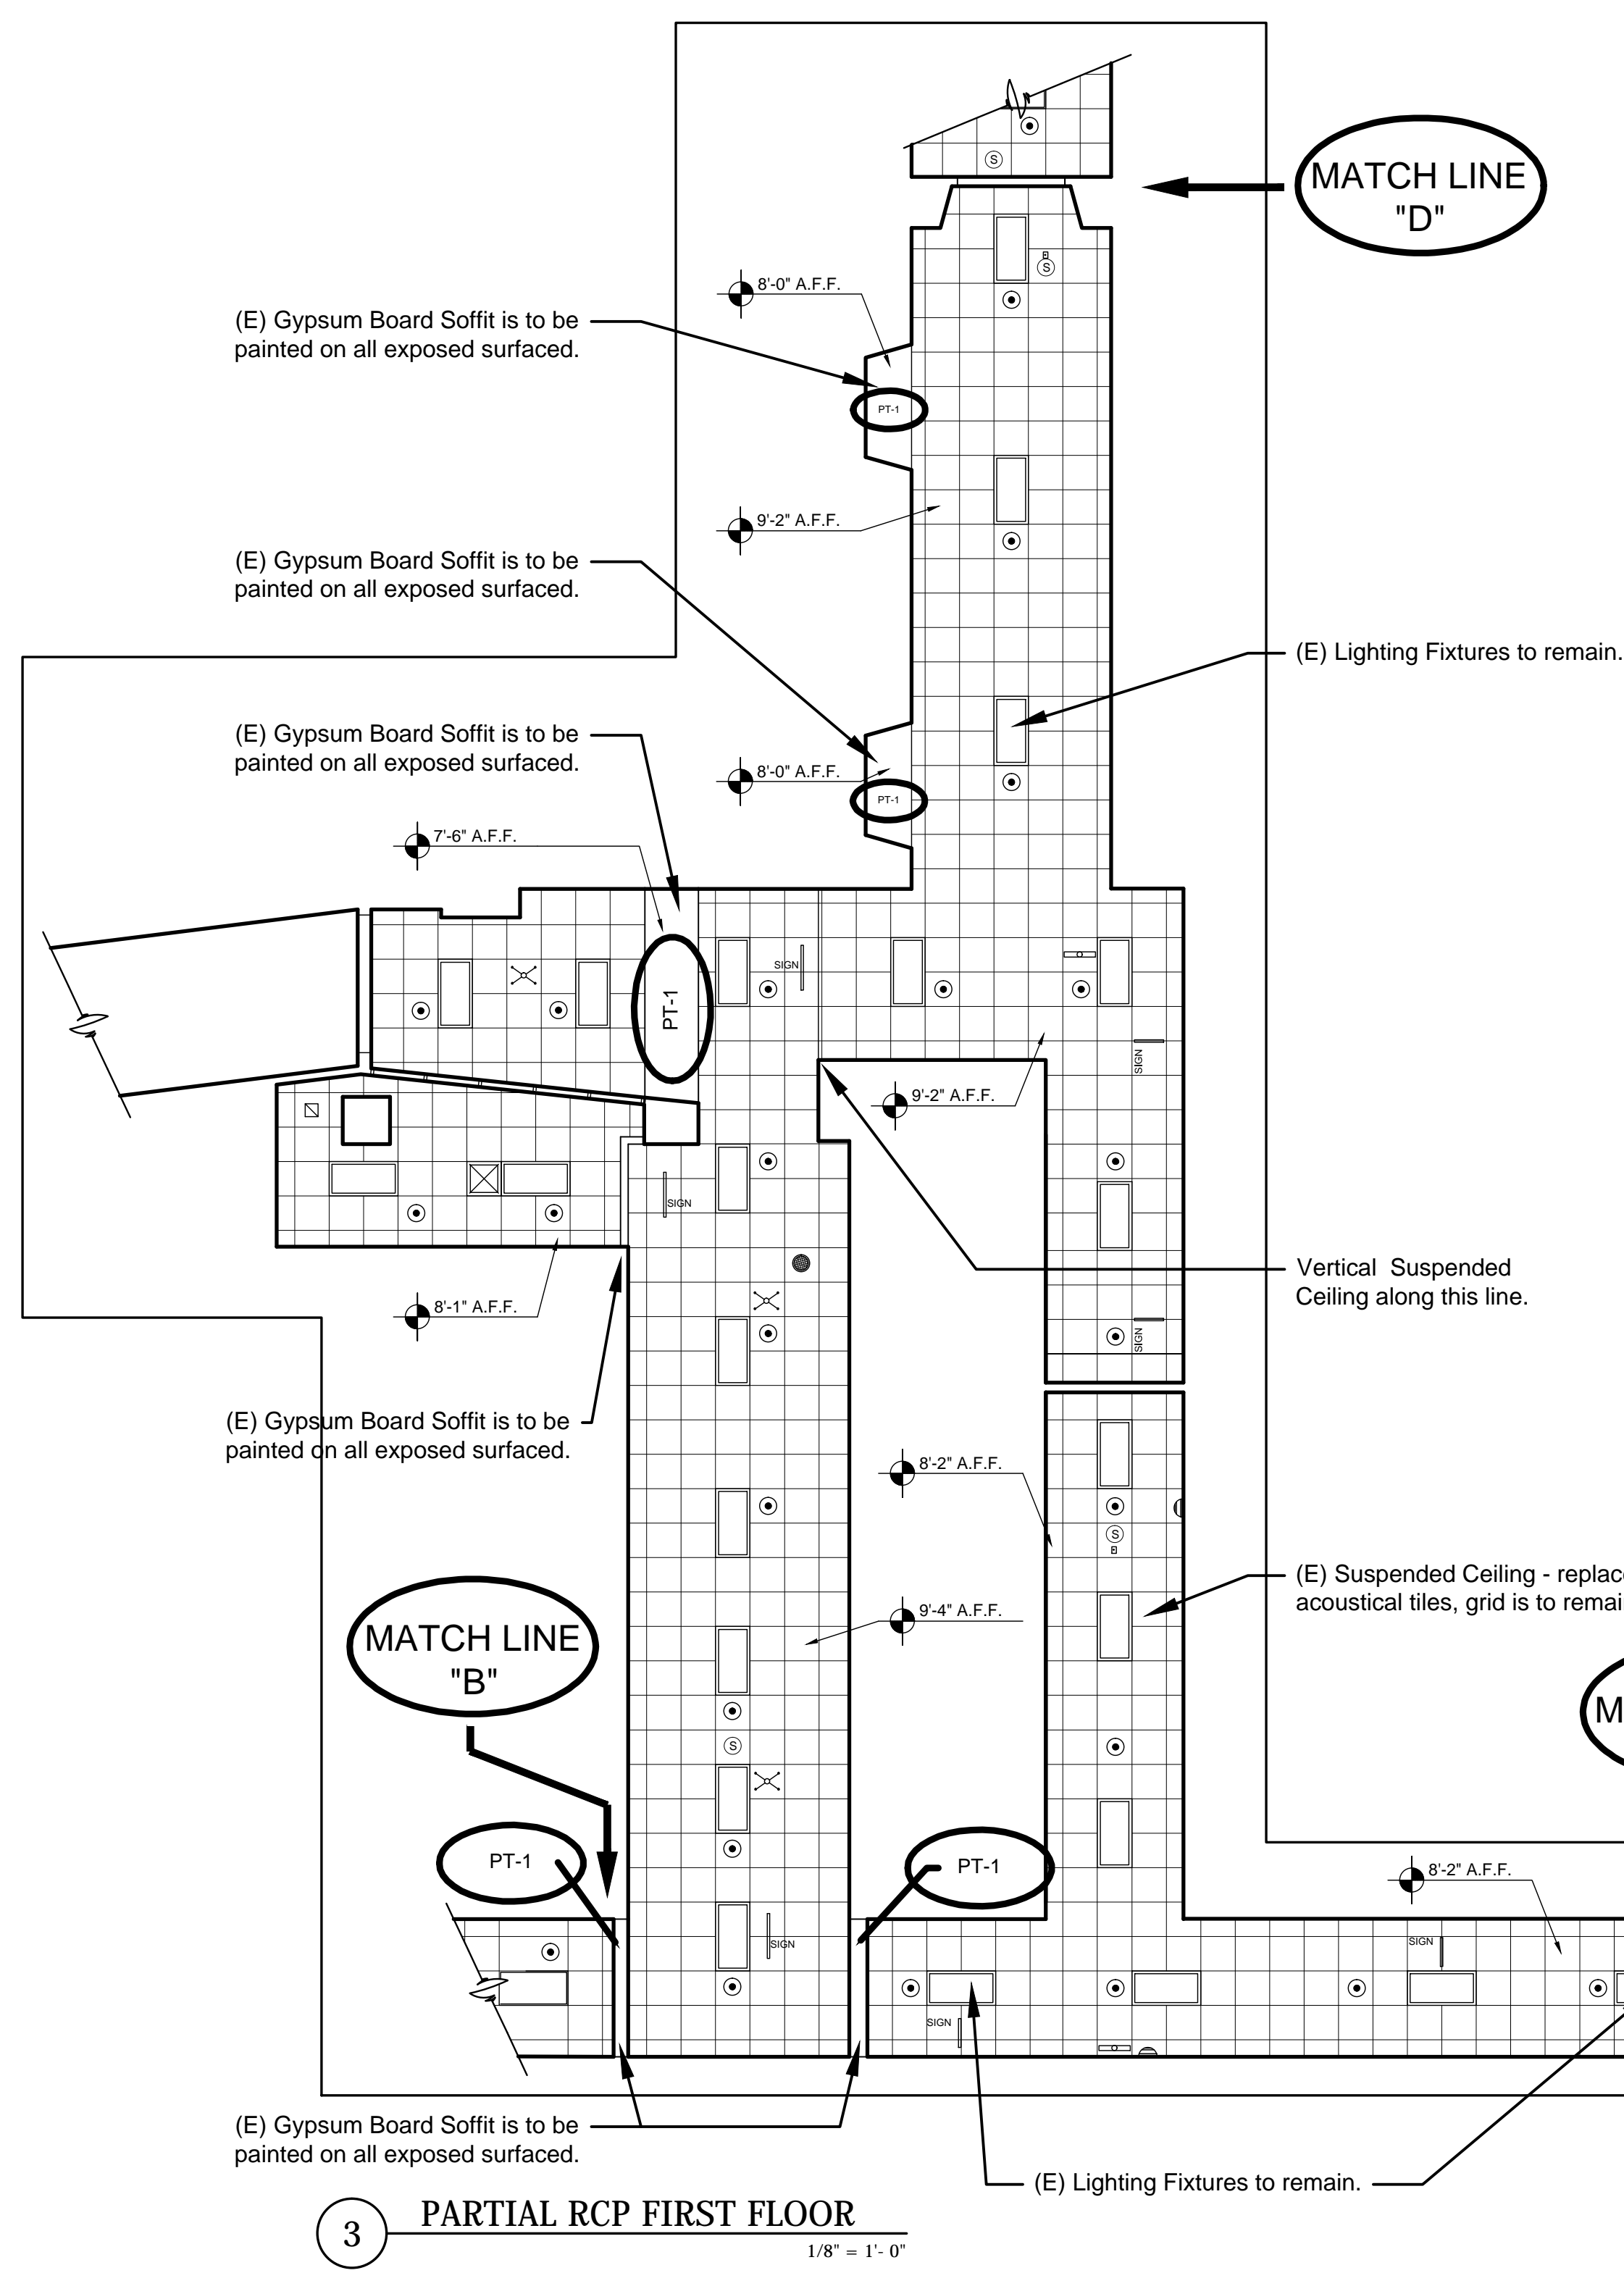

Revisions:		Date:	VA Northern Indiana Health Care System, Fort Wayne 2121 Lake Avenue Fort Wayne, IN 46805		Approved: Medical Center Director Daniel D. Hendee, FACHE	Approved: Project Director	Drawing Title REFLECTED CEILING PLAN - 1st Floor		Project Title Interior Halls and Walls		Project Number 610A4-11-149		
					Approved: Associate Director for Operations Helen Rhodes				Location VA NIHCS, Fort Wayne, IN		Building Number 1		
					Approved: Engineering Service Charles Applewhite				Date 08/05/2011	Checked CDA	Drawn VM	Drawing Number A-104	
												Dwg. 4 of 12	