


Revisions	Date

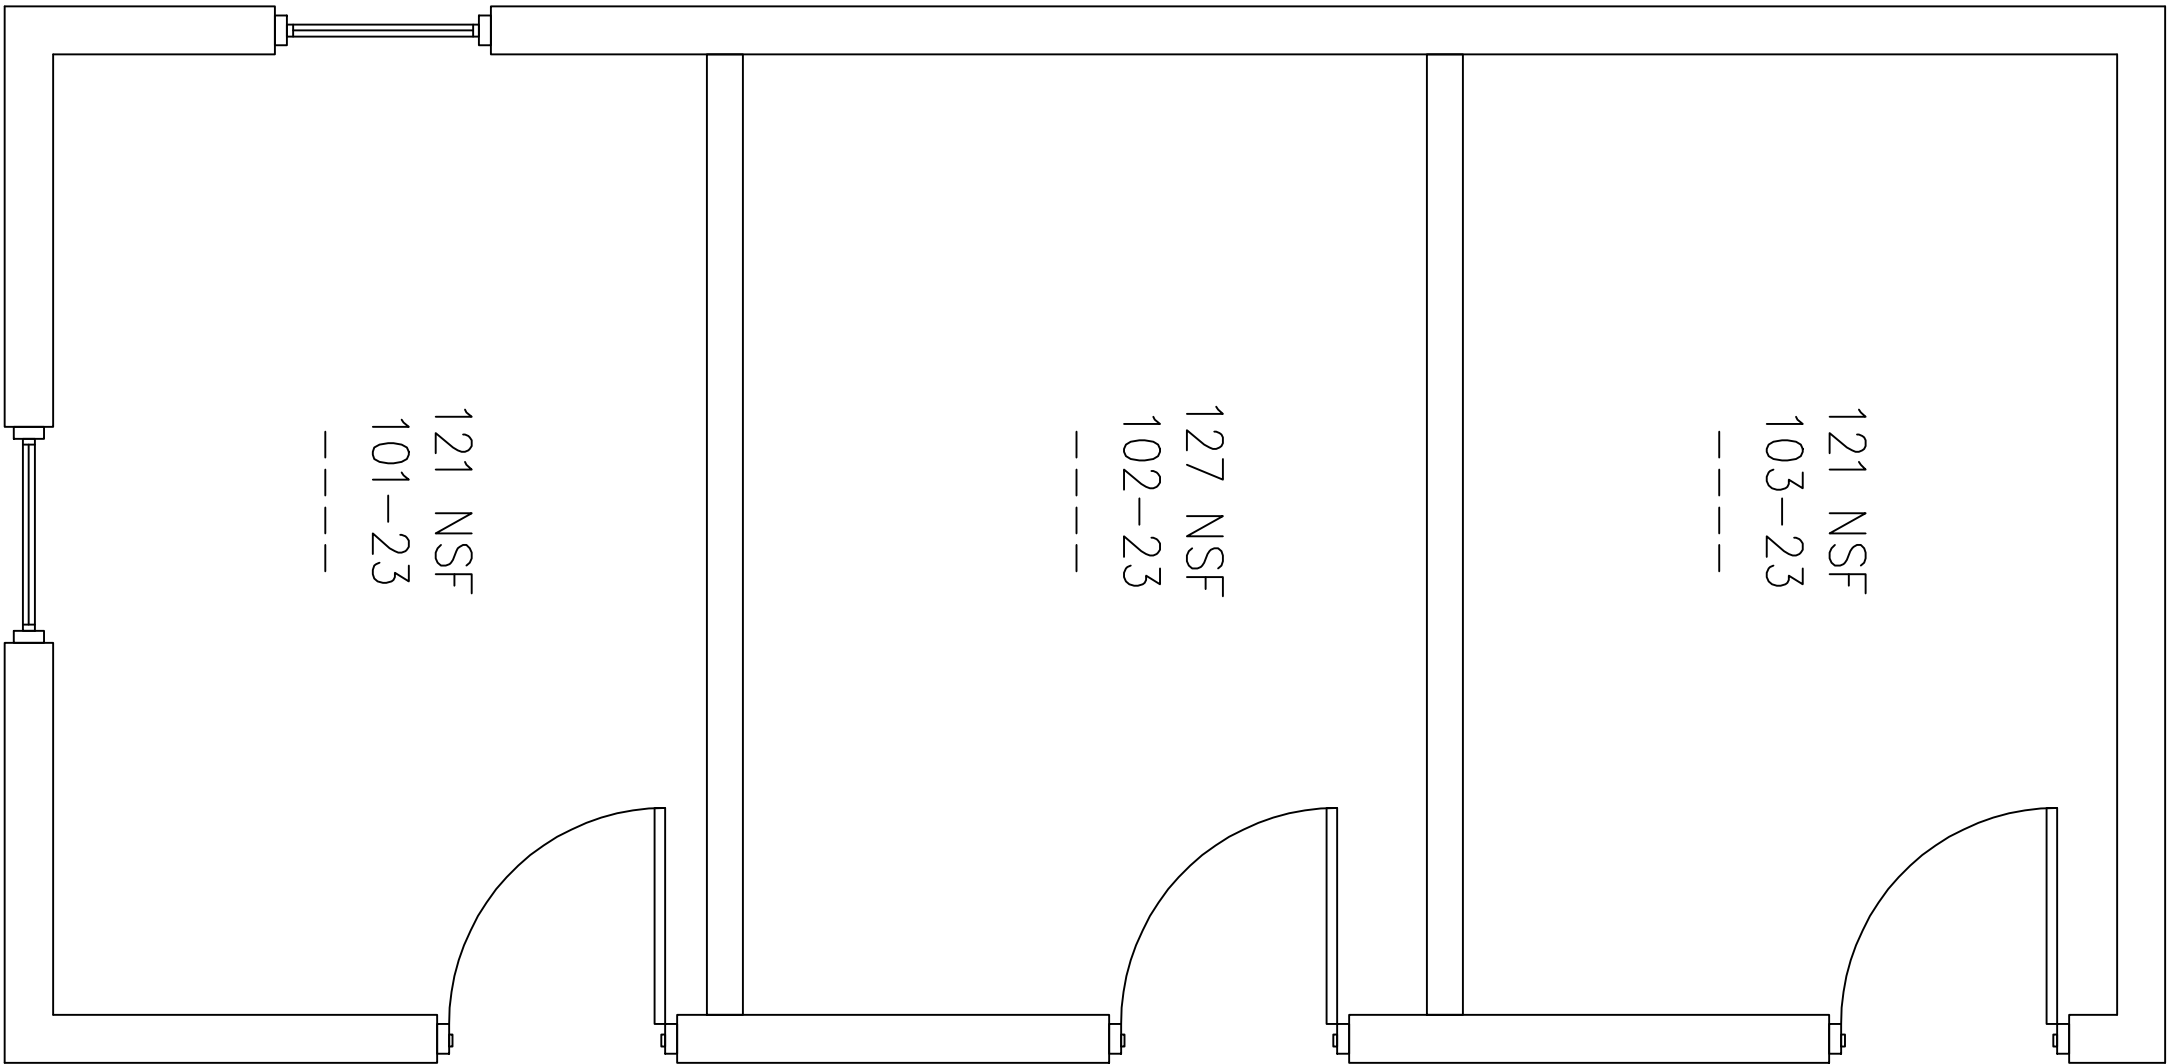

FLOOR PLAN
SCALE: 3/8" = 1'-0"



Drawing Title		FLAMMABLE STORAGE	
Project Title		ARCHITECTURAL	
Approved: Project Section Chief			
Approved: Service Chief			
Approved: Facility Director			
Location: JAMES A. HALEY VETERANS' HOSPITAL 13000 BRUCE B. DOWNS BLVD. JANNA, FLORIDA 33812			
Drawn	MWK	Date	06/20/06
Checked		Project No.	
Building Number	23	DRAWING NO.	23-AS101
File Number		Desg. of	

