

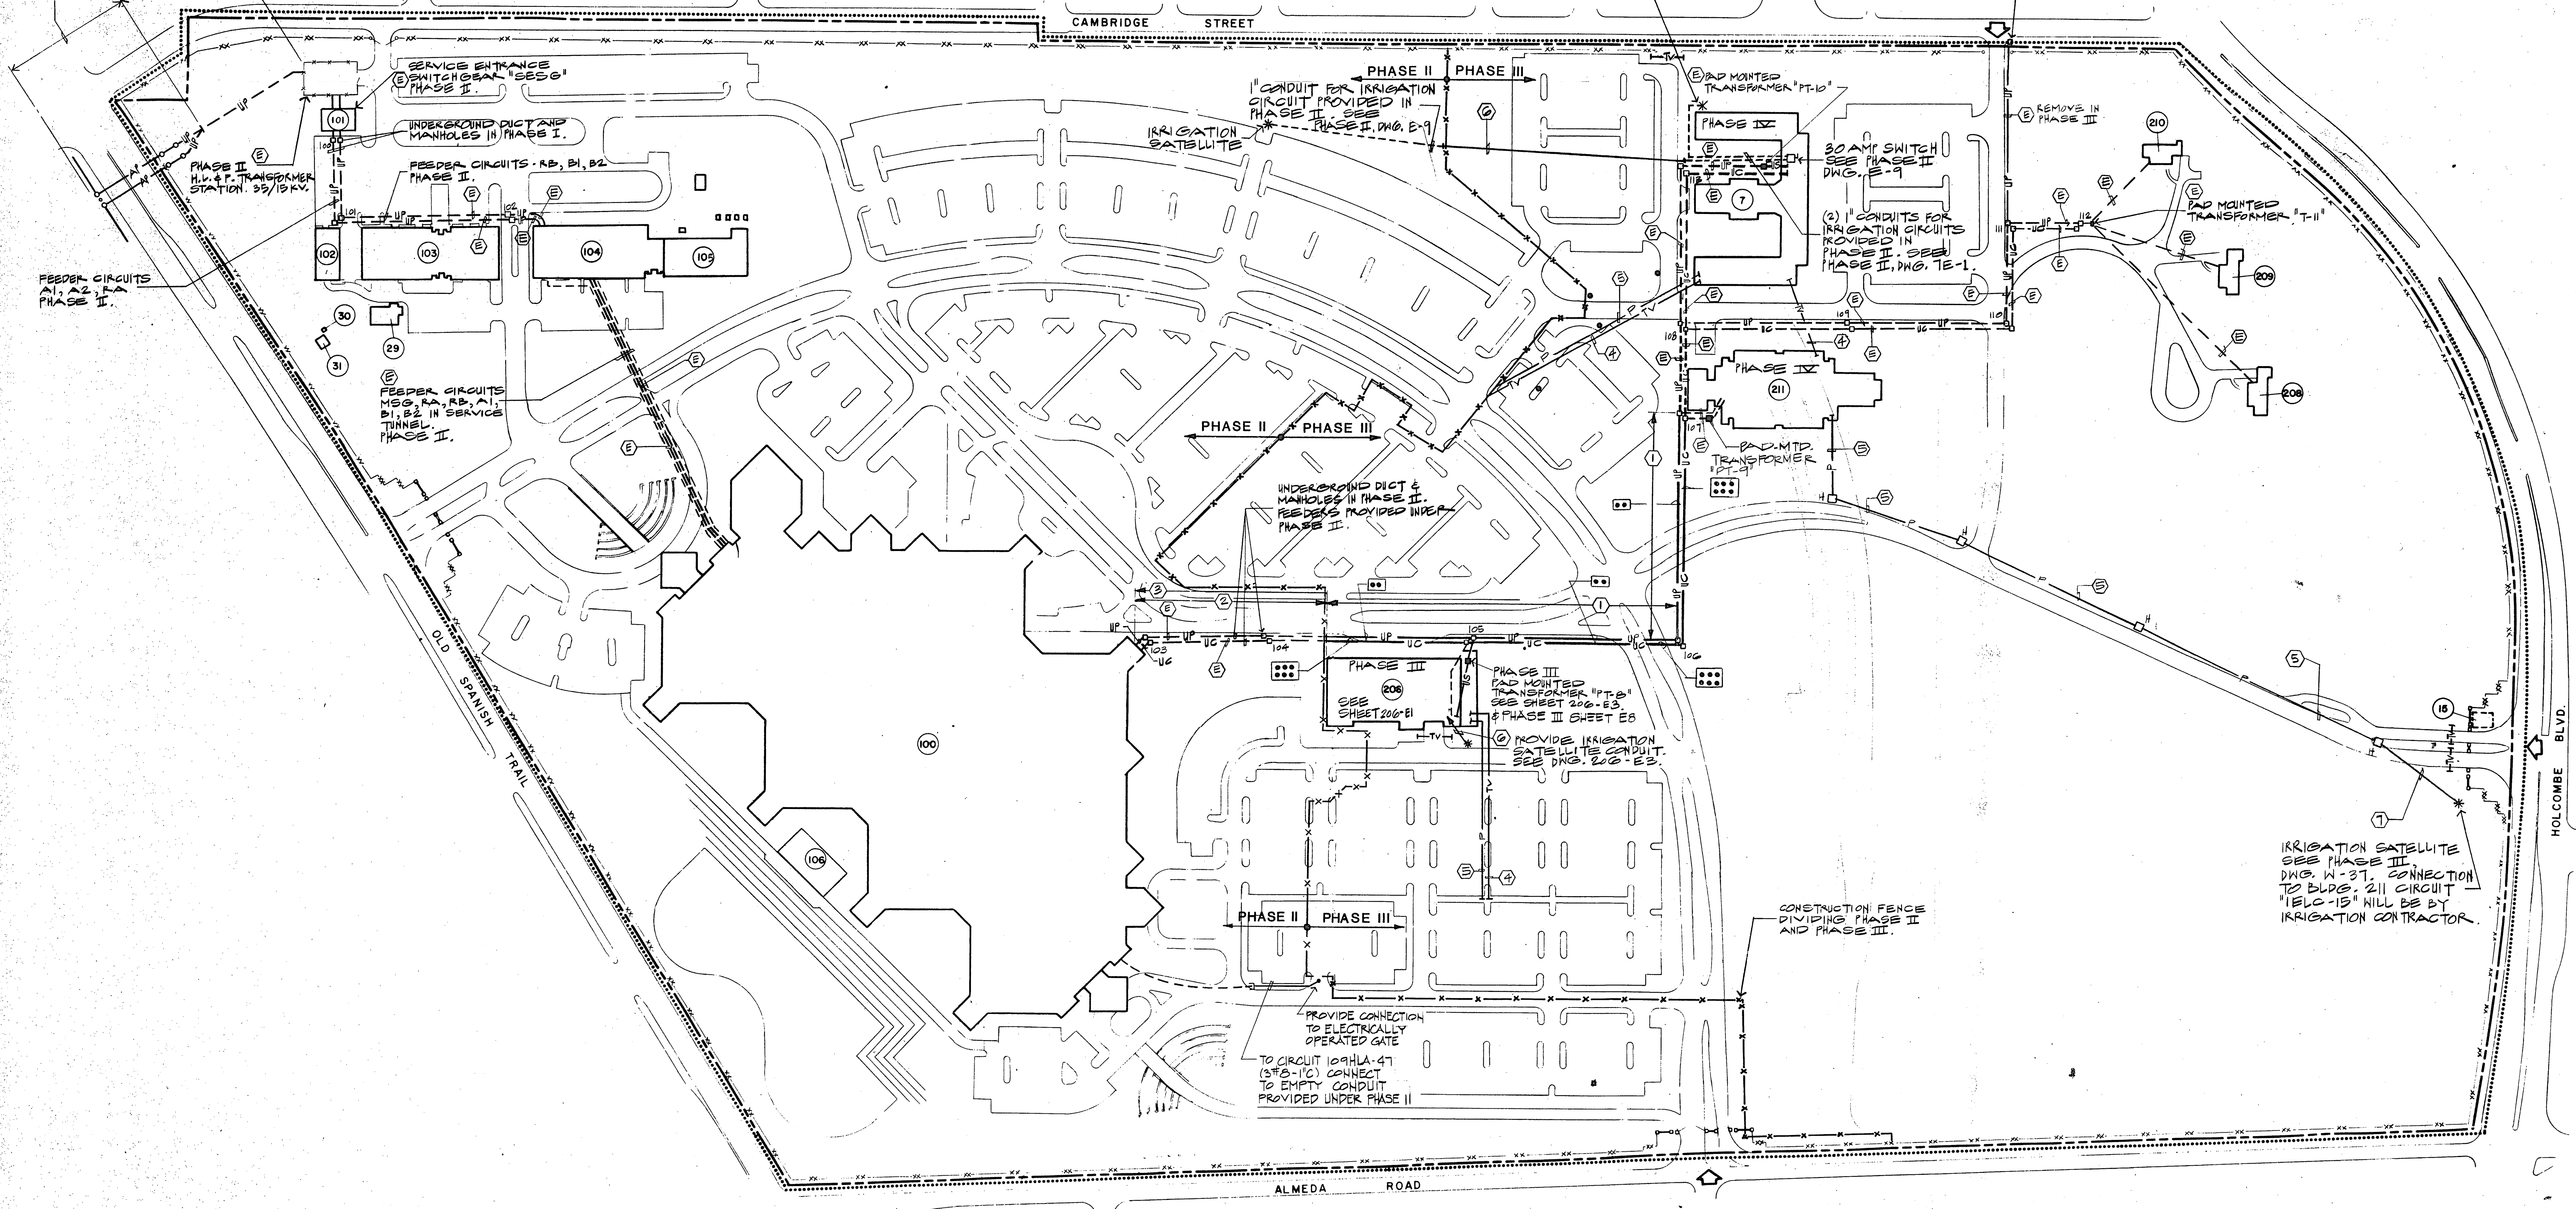


GENERAL LEGEND

FENCE w/GATE  
CONSTRUCTION FENCE w/GATE  
PERMANENT FENCE w/GATE  
BUILDING NO.  
BUILDING  
BUILDING TO BE REMOVED  
PAVEMENT TO BE REMOVED (P-100)  
EDGE OF PAVEMENT  
CONCRETE PAVEMENT  
CONTRACTOR'S ACCESS  
PROPERTY LINE  
CONSTRUCTION LIMITS

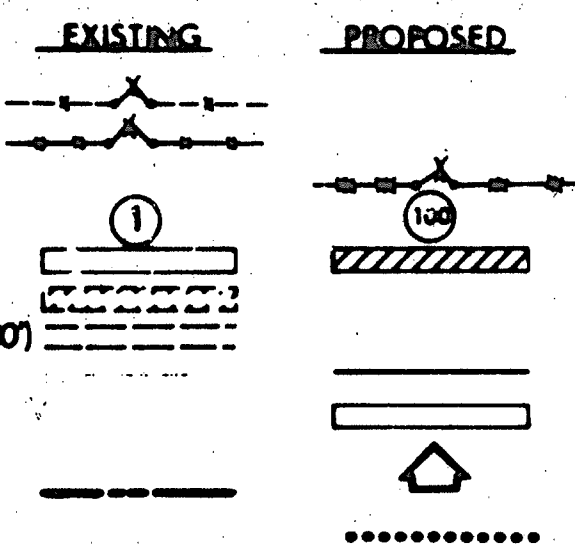

NOTES THIS SHEET ONLY			
NOTE	DESCRIPTION	NOTE	DESCRIPTION
1	UNDERGROUND DUCT, MANHOLES AND FEEDER CABLES IN PHASE III SEE PROFILE LINE "C" SHEETS E-5 AND E-6.	4	EMPTY DIRECT BURIED UNDERGROUND NON-METALLIC COMMUNICATIONS CONDUIT TO BE PROVIDED IN ADDITION TO NOTES NO. 1 AND 2.
2	UNDERGROUND DUCT AND MANHOLES INDICATED (E) PROVIDED IN PHASE II CONSTRUCTION.	5	1" EMPTY DIRECT BURIED NON-METALLIC RIBBON CONDUIT TO SUPPORT CCTV CONDUIT SYSTEM AND IRRIGATION CIRCUITS.
3	15 KV PRIMARY FEEDER CABLE PROVIDED IN PHASE III.	6	PROVIDE A 1" EMPTY CONDUIT WITH FILL WIRE 2' BELOW GRADE. TERMINATE EACH END OF CONDUIT WITH GATED BUSHING FOR FUTURE CONDUIT EXTENSION IN PHASE II. CIRCUITRY WILL BE PROVIDED BY IRRIGATION CONTRACTOR.
		7	PROVIDE A 1" EMPTY CONDUIT WITH FILL WIRE 2' BELOW GRADE. TERMINATE EACH END OF CONDUIT WITH GATED BUSHING. CIRCUITRY WILL BE PROVIDED BY IRRIGATION CONTRACTOR.

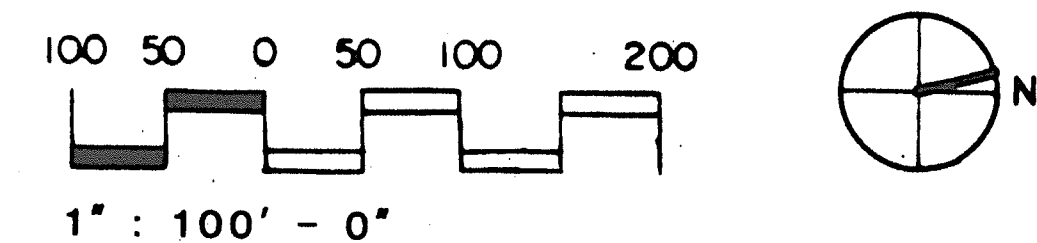

PHASE III

Drawing Title NEW WORK SITE PLAN		Project Title REPLACEMENT / MODERNIZATION MEDICAL CENTER		Date 2 JAN 1987
Approved Project Director <i>A. C. Rappaport</i>		Project No. 580-040		Drawing No. E-4
Building Number SITE		Checked MH	Drawn JG	Location VAMC HOUSTON, TEXAS
Structural and Civil Mechanical and Electrical		WALTER P. MOORE AND ASSOCIATES, INCORPORATED YANDELL & MILLER, INC. AND 3D/INTERNATIONAL		Veterans Administration

3D/INTERNATIONAL AND STONE, MARRACCINI AND PATTERSON  
3D/I • SMP A JOINT VENTURE HOUSTON, TEXAS  
1900 WEST LOOP SOUTH, SUITE 200 HOUSTON, TEXAS 77027 TELEPHONE (713) 871-7000