

VA MEDICAL CENTER LIQUID OXYGEN TANK SITE PREP

Fargo, North Dakota

Project Number: 437-11-155

GENERAL
X1 COVER SHEET

CIVIL
C1 CIVIL DEMOLITION GRADING/PAVING/DETAILS

MECHANICAL

P1 LIQUID OXYGEN TANK DEMOLITION AND REMODELING PLANS

ELECTRICAL

E1 SITE PLAN - ELECTRICAL DEMOLITION AND ELECTRICAL REMODELING

GENERAL NOTES:

CONTRACTOR SHALL PROTECT ALL PROPERTY PINS. PROPERTY PINS DESTROYED OR DISTURBED SHALL BE REPLACED AT CONTRACTORS EXPENSE.

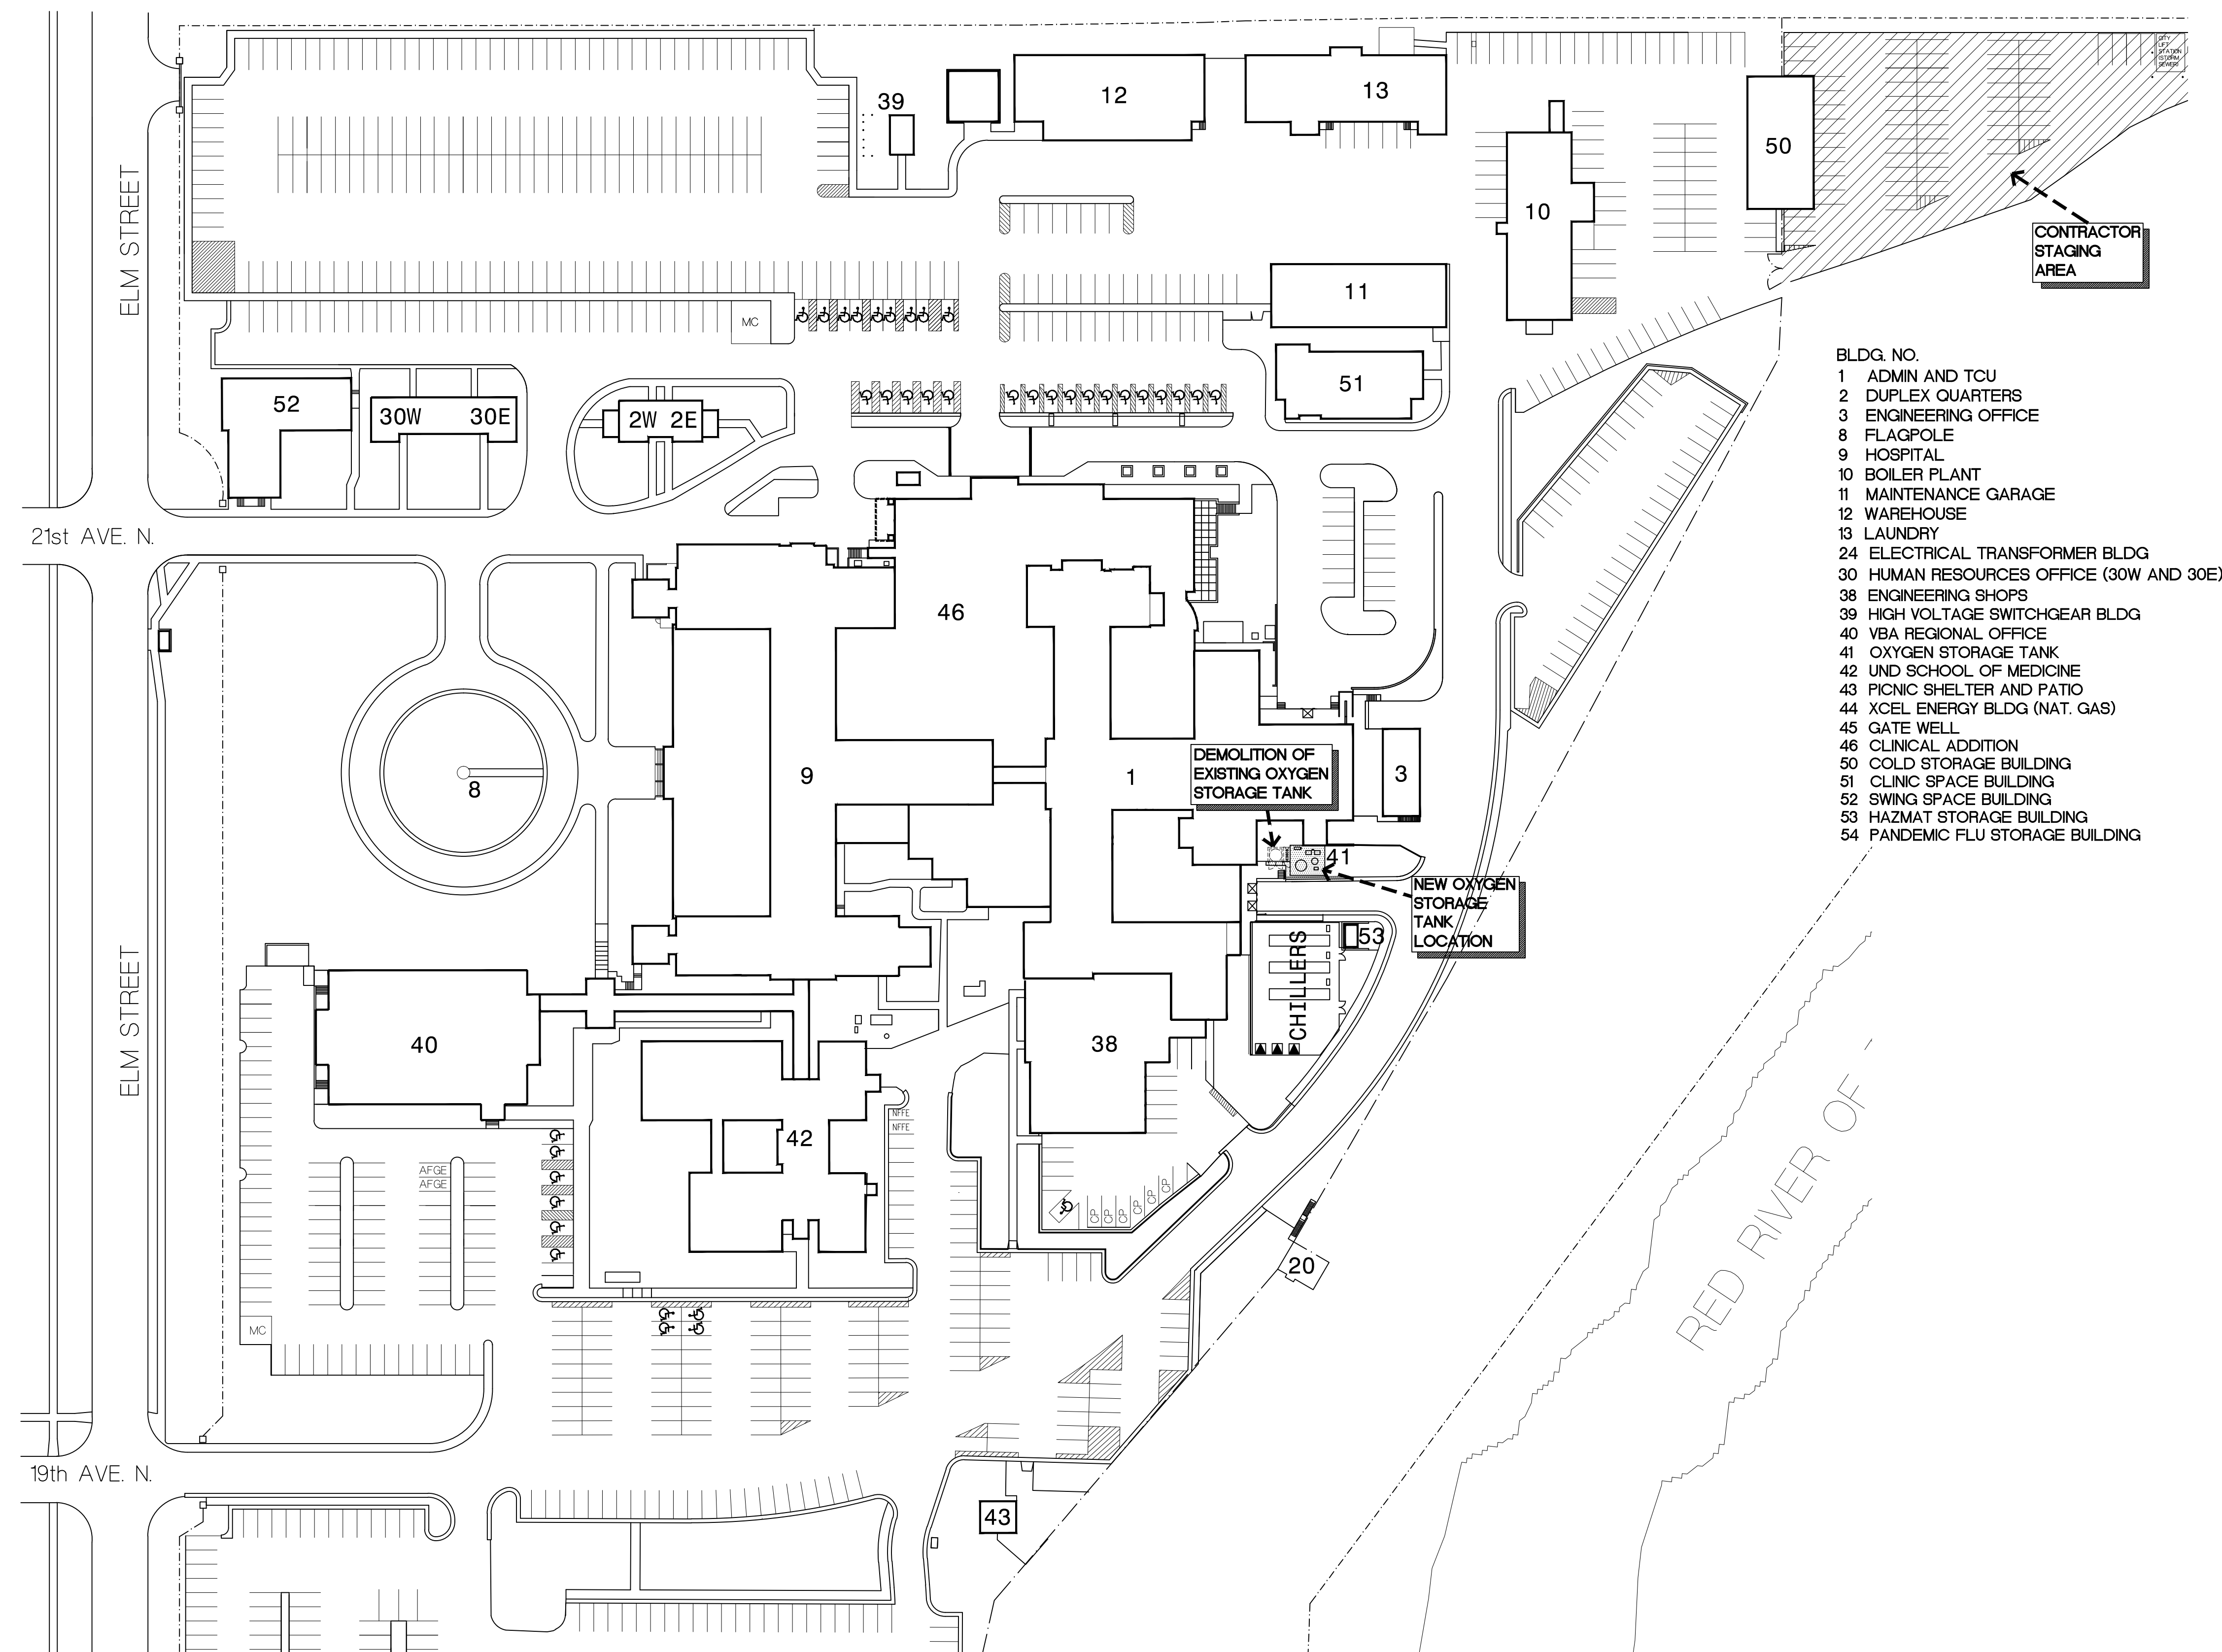
CONTRACTOR SHALL LOCATE ALL UTILITIES PRIOR TO CONSTRUCTION. NORTH DAKOTA ONE CALL WILL ONLY LOCATE THEIR MAINS AND WILL NOT LOCATE PRIVATE UTILITIES ON THE SITE. THE VA IS NOT RESPONSIBLE FOR LOCATING ANY ON SITE UTILITIES.

ALL PAVEMENT MARKED FOR DEMOLITION SHALL BE FULL DEPTH SAW CUT.

ALL GRASSED AREAS DISTURBED BY CONSTRUCTION SHALL HAVE TOPSOIL (6" DEPTH), GRADED, SEEDED, AND HYDRO-MULCHED.

CONTRACTOR SHALL PROTECT THE EXISTING LIQUID OXYGEN TANK AND CONTROLS UNTIL THE NEW PAD, EQUIPMENT, AND CONTROLS ARE INSTALLED AND OPERATIONAL.


CONTRACTOR IS RESPONSIBLE FOR GENERAL TRAFFIC CONTROL TO ALLOW FOR PUBLIC ACCESS THROUGH THE PROJECT SITE. CONTRACTOR SHALL PROVIDE ADEQUATE SIGNAGE FOR PUBLIC SAFETY AND TRAFFIC CONTROL. CONTRACTOR IS RESPONSIBLE FOR KEEPING THE EAST LOADING DOCK OPEN FOR DAILY DELIVERIES.







KEY TO SITE PLAN

-  CONTRACTOR STAGING AREA. SHARED WITH VA AND OTHER CONTRACTORS.
-  CONSTRUCTION AREA

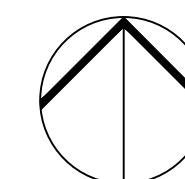   SITE PLAN



 <div>Dept. of Veterans Affairs Medical Center 2101 Elm Street North Fargo, ND 58102</div>		 <div>IMAGE GROUP INC. 403 CENTER AVENUE, SUITE 300 NOORHEAD, MN 55650</div>		 <div>ONE BUILDING SYSTEMS CONSULTANTS Fargo, ND • Grand Forks, ND • Minneapolis, MN 701.280.0500 • 701.775.2594 • 651.361.8728</div>		 <div>MECHANICAL • ELECTRICAL • CIVIL 550 7th St N, SUITE 300 FARGO, ND 58102 PHONE: 701.476.6236 FAX: 701.476.6240</div>		IMAGE GROUP INC. Architecture & Interiors OBERMILLER NELSON ENGINEERING, Mechanical Engineers MBN ENGINEERS, Civil & Electrical Engineers		I hereby certify that this plan specification, or report was prepared by me or under my direct supervision, and that I am duly Registered Architect under the laws of the State of North Dakota.  Date 8/05/2011 Reg. No. 378		Drawing Title COVER SHEET		Project Title VA MEDICAL CENTER LIQUID OXYGEN TANK SITE PREP		Date AUGUST 5, 2011 Scale 1"=60'-0"		Drawing No. X1 Dwg 1 of 4	Department of Veterans Affairs
Revisions		Date						VA Project No. 437-11-155		Contract No. VA263-P-1217 VA263-C-		Designed By RM		Checked By RM		Drawn By KS			
										Building No. SITE		AutoCAD File Name COVER		Location VA MEDICAL CENTER FARGO, ND					