

DEPARTMENT OF VETERANS AFFAIRS



WILKES-BARRE, PENNSYLVANIA

PLUMBING UPGRADE, PHASE 2

PROJECT NO. 693-11-119

LIST OF DRAWINGS

GENERAL

(1 of 55) 1-I1 COVER SHEET
(2 of 55) 1-I2 KEY PLAN

ARCHITECTURAL

(3 of 55) 1-A1 BUILDING 1 FIRST FLOOR WEST/CENTER ARCHITECTURAL PLANS
(4 of 55) 1-A2 BUILDING 1 SECOND FLOOR WEST/CENTER ARCHITECTURAL PLANS
(5 of 55) 1-A3 BUILDING 1 FIFTH FLOOR WEST/CENTER AND EAST ARCHITECTURAL PLANS
(6 of 55) 1-A4 BUILDING 1 BASEMENT, FIRST, SECOND, THIRD, AND FOURTH FLOOR NORTH ARCHITECTURAL PLANS

ICRA

(7 of 55) 1-ICRA1 BUILDING 1 FIRST FLOOR WEST/CENTER ICRA PLANS
(8 of 55) 1-ICRA2 BUILDING 1 SECOND FLOOR EAST/CENTER ICRA PLANS
(9 of 55) 1-ICRA3 BUILDING 1 FIFTH FLOOR WEST/CENTER AND EAST ICRA PLANS
(10 of 55) 1-ICRA4 BUILDING 1 NORTH BASEMENT, FIRST, SECOND, THIRD, AND FOURTH FLOOR ICRA PLANS


PLUMBING

(11 of 55) 1-P1 PLUMBING SYMBOLS, ABBREVIATIONS, SCHEDULES, AND NOTES
(12 of 55) 1-P2 FACILITY KEY PLAN AND SCOPE OF WORK
(13 of 55) 1-P3 BUILDING 1 BASEMENT NORTH, EAST, AND WEST PLUMBING PLANS
(14 of 55) 1-P4 BUILDING 1 BASEMENT AMBULATORY CARE ADDITION PLUMBING PLAN
(15 of 55) 1-P5 BUILDING 1 BASEMENT BOILER PLANT/WAREHOUSE PLUMBING PLANS
(16 of 55) 1-P6 BUILDING 27 CLC FIRST FLOOR PLUMBING PLAN
(17 of 55) 1-P7 BUILDING 1 FIRST FLOOR NORTH, AMBULATORY CARE, AND WEST/CENTER PLUMBING PLANS
(18 of 55) 1-P8 BUILDING 1 CENTER/EAST AND BUILDING 27 CLC SECOND FLOOR PLUMBING PLANS
(19 of 55) 1-P9 BUILDING 1 SECOND FLOOR NORTH AND AMBULATORY CARE ADDITION PLUMBING PLANS
(20 of 55) 1-P10 BUILDING 1 THIRD FLOOR EAST AND BUILDING 27 CLC THIRD FLOOR PLUMBING PLANS
(21 of 55) 1-P11 BUILDING 1 THIRD FLOOR CENTER, NORTH AND AMBULATORY CARE ADDITION PLUMBING PLANS
(22 of 55) 1-P12 BUILDING 1 FOURTH FLOOR EAST AND BUILDING 27 CLC FOURTH FLOOR PLUMBING PLANS
(23 of 55) 1-P13 BUILDING 1 FOURTH FLOOR WEST, AMBULATORY CARE ADDITION AND NORTH PLUMBING PLANS
(24 of 55) 1-P14 BUILDING 1 FIFTH FLOOR PLUMBING PLANS
(25 of 55) 1-P15 BUILDING 1 EIGHTH FLOOR WEST/CENTER PLUMBING PLANS
(26 of 55) 1-P16 BUILDING 1 THIRTEENTH FLOOR PLUMBING PLANS

(27 of 55) 1-P17 PLUMBING DETAILS
(28 of 55) 1-P18 PLUMBING DETAILS
(29 of 55) 1-P19 AUTOMATIC CONTROL SYSTEMS, SCHEMATICS, AND SEQUENCE OF OPERATION
(30 of 55) 1-P20 PLUMBING SCHEDULES
(31 of 55) 1-P21 BUILDING 1 PLUMBING RISER DIAGRAM
(32 of 55) 1-P22 BUILDING 1 NORTH PLUMBING RISER DIAGRAM
(33 of 55) 1-P23 BUILDING 1 MIXING VALVE STATION ENLARGED PLANS
(34 of 55) 1-P24 BUILDING 1 MIXING VALVE STATION ENLARGED PLANS
(35 of 55) 1-P25 BUILDING 1 NORTH MIXING VALVE STATION ENLARGED PLANS
(36 of 55) 1-P26 BUILDING 1, NORTH, AMBULATORY CARE, AND BUILDING 27 CLC WATER SERVICE DETAILS
(37 of 55) 1-P27 TOILET ROOM FIXTURE AND FINISH DATA
(38 of 55) 1-P28 FILTER DATA

ELECTRICAL

(39 of 55) 1-E1 ELECTRICAL SYMBOLS AND ABBREVIATIONS
(40 of 55) 1-E2 BUILDING 1 BOILER PLANT BASEMENT AND MEZZANINE ELECTRICAL PLANS
(41 of 55) 1-E3 BUILDING 1 EQUIPMENT EMERGENCY POWER PARTIAL ONE - LINE DIAGRAM AND SCHEDULES
(42 of 55) 1-E4 BUILDING 1 BASEMENT AND FIRST FLOOR ELECTRICAL PLANS
(43 of 55) 1-E5 BUILDING 1 SECOND AND THIRD FLOOR ELECTRICAL PLANS
(44 of 55) 1-E6 BUILDING 1 FOURTH AND FIFTH FLOOR ELECTRICAL PLANS
(45 of 55) 1-E7 BUILDING 1 SIXTH AND SEVENTH FLOOR ELECTRICAL PLANS
(46 of 55) 1-E8 BUILDING 1 EIGHTH AND NINTH FLOOR ELECTRICAL PLANS
(47 of 55) 1-E9 BUILDING 1 TENTH AND ELEVENTH FLOOR ELECTRICAL PLANS
(48 of 55) 1-E10 BUILDING 1 THIRD AND THIRTEENTH FLOOR ELECTRICAL PLANS
(49 of 55) 1-E11 BUILDING 1 NORTH FIFTH FLOOR ELECTRICAL PLANS
(50 of 55) 1-E12 BUILDING 1 NORTH BASEMENT, FIRST, AND SECOND FLOOR ELECTRICAL PLANS
(51 of 55) 1-E13 BUILDING 1 NORTH THIRD AND FOURTH FLOOR ELECTRICAL PLANS
(52 of 55) 1-E14 BUILDING 27 CLC FIRST FLOOR ELECTRICAL PLAN
(53 of 55) 1-E15 BUILDING 27 CLC SECOND FLOOR ELECTRICAL PLAN
(54 of 55) 1-E16 BUILDING 27 CLC THIRD FLOOR ELECTRICAL PLAN
(55 of 55) 1-E17 BUILDING 27 CLC FOURTH FLOOR ELECTRICAL PLAN

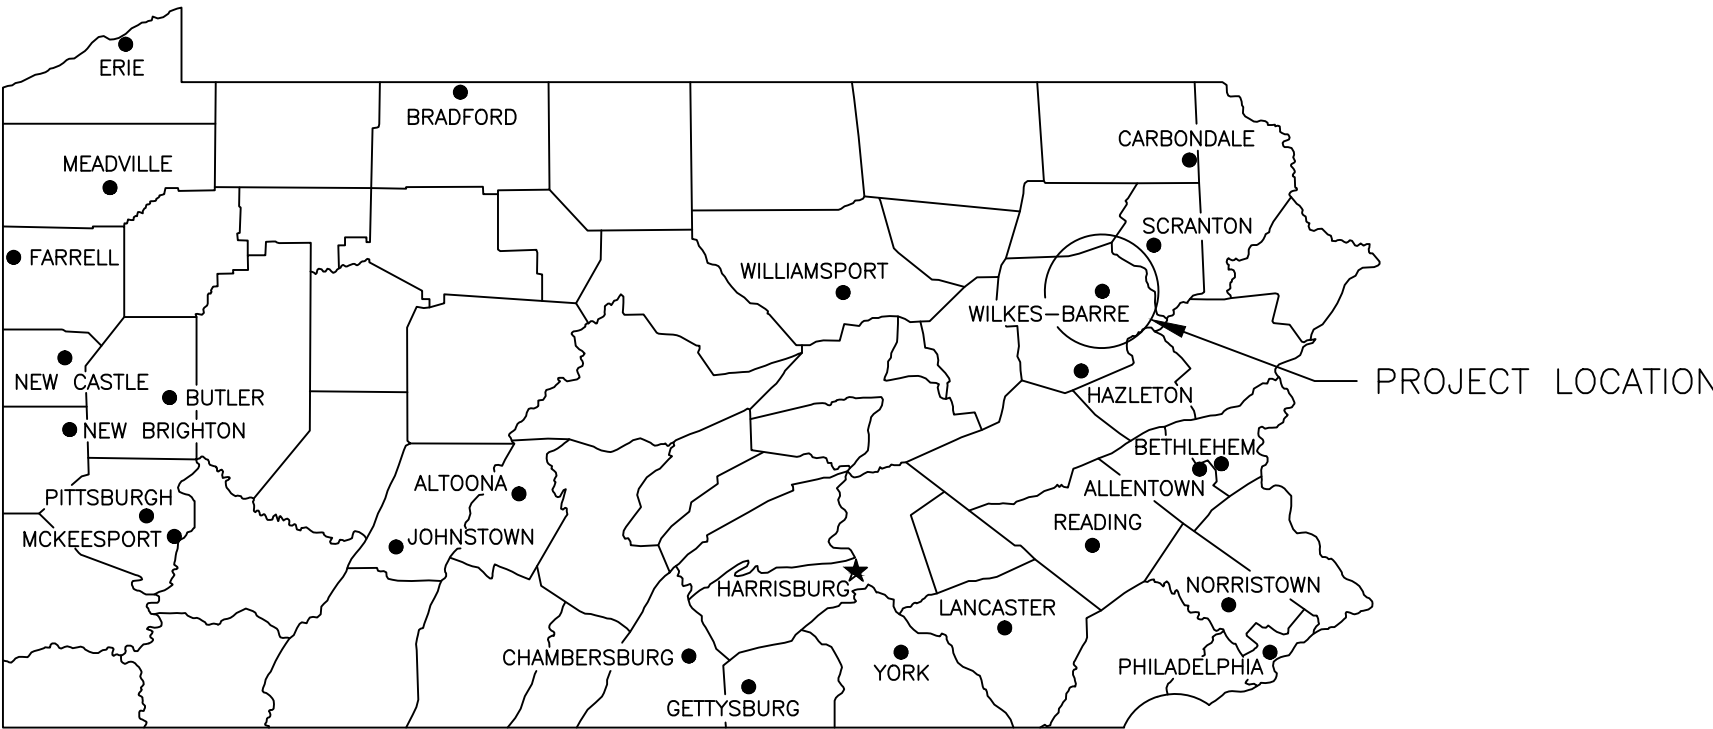


LOCATION MAP
SCALE: NOT TO SCALE

JOSEPH SHARON ASSOCIATE DIRECTOR, WILKES-BARRE VA MEDICAL CENTER	MIRZA Z. ALI, M.D. CHIEF OF STAFF	VALERIE BOYTON ASSOCIATE DIRECTOR FOR NURSING SERVICES	HANK OHOP CHIEF, FACILITY MANAGEMENT SERVICE
ED LEWIS SUPERVISOR, PLUMBING SHOP	JOE MCDANIELS CHIEF, ENVIRONMENTAL MANAGEMENT SERVICE	SALLY KASZOWICZ CHIEF, SPD	HANK OHOP SUPERVISOR, FACILITIES MAINTENANCE
KATHLEEN MROZINSKI INFECTION PREVENTION COORDINATOR	BRENT MILLER SAFETY & OCCUPATIONAL HEALTH MANAGER	ORLANDO MIRARCHI SUPERVISOR, PROJECT ENGINEERING	DAVID LONGMORE FACILITY CIO
KAREN SIMMS PATIENT SAFETY OFFICER	MIKE SCHMIDT PROJECT MANAGER, ENGINEERING		

AMENDMENT NO. 1	8/24/16
Revisions	Date

Professional Seal

Project Lead

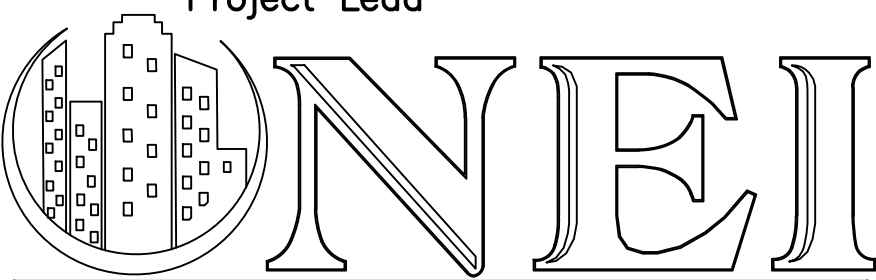

NORTHEAST INFRASTRUCTURE, LLC
630 PARK STREET HONESDALE, PA 18431
570-253-0846 OFFICE 570-253-1935 FAX
WWW.NEINFRA.COM

Drawing Title
COVER SHEET
Facility Project Name
DEPARTMENT OF VETERANS AFFAIRS MEDICAL CENTER WILKES-BARRE, PA

Project Title
PLUMBING SYSTEM UPGRADE PHASE II
Building Number
Checked L.J.M.
Drawn S.B.
Location
WILKES-BARRE, PENNSYLVANIA

Date
08/24/2016
Project No.
693-11-119
DRAWING NO.
DRAWING
1-11
DWG. 1 OF 55

BID AMENDMENT
NO.1
AUGUST 24, 2016

FULLY SPRINKLERED