


one eighth inch = one foot
0 4 8 16
one quarter inch = one foot
0 4 8
three eighths inch = one foot
0 4 8
one half inch = one foot
0 4 8
three quarters inch = one foot
0 4 8
one inch = one foot
0 6 12
one and one half inches = one foot
0 6 12
three inches = one foot
0 6 12

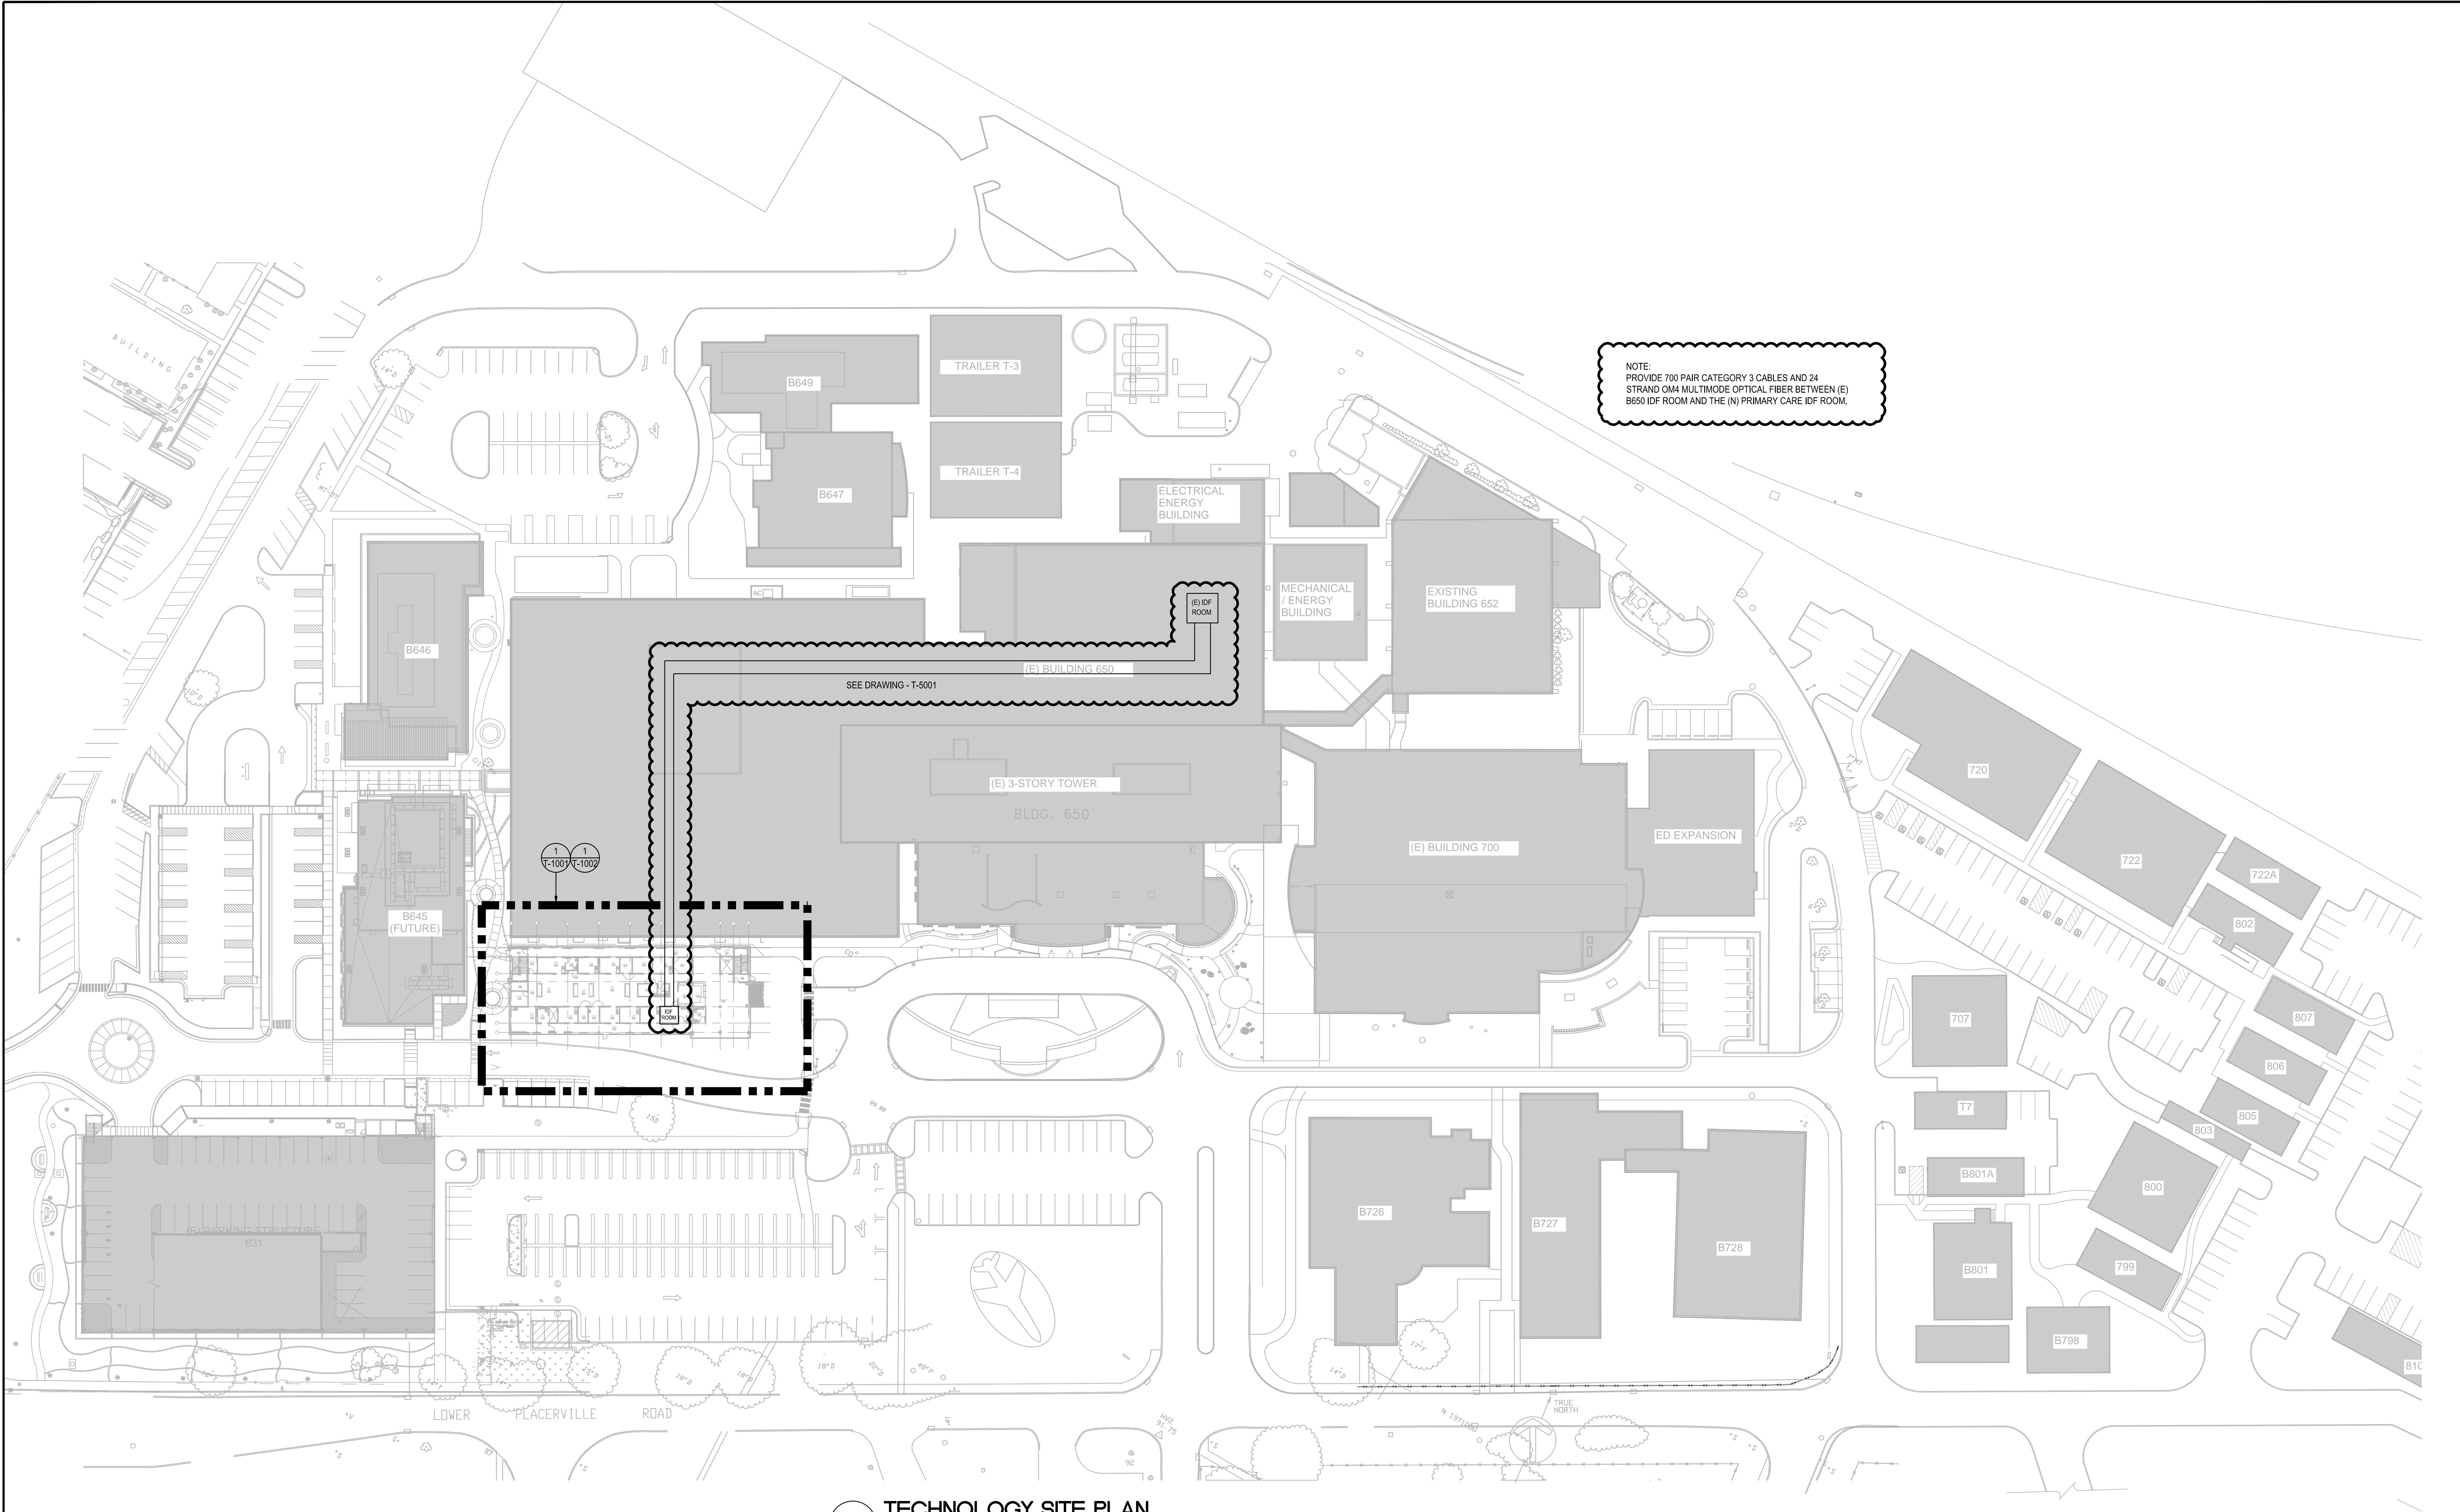

1 TECHNOLOGY SITE PLAN
1" = 480'

CONSULTANTS: BJL ENTERPRISES LLC 39 California Ave. #202 Pleasanton, CA. 94566 Telephone (510) 621-9652 Facsimile (925) 407-2887 www.bjent.com		KEY PLAN 		STAMP 		ARCHITECT/ENGINEERS: ADVANCE DESIGN CONSULTANTS, INC. 988 PARK AVENUE SAN JOSE CALIFORNIA 95126 P: (408) 297-1881 F: (408) 294-3186 www.adengineers.com ATTENTION: ONLY WET SIGNED DOCUMENTS CONSTITUTE ADVANCE DESIGN CONSULTANTS, INC. PROFESSIONAL WORK AND BECAUSE OTHER REPRODUCIBLE DOCUMENTS MAY BE EASILY ALTERED WITHOUT THE CONSENT OF ADVANCE DESIGN CONSULTANTS, INC., THE WET SIGNED DOCUMENTS MUST BE REFERRED TO FOR THE ORIGINAL AND CORRECT INFORMATION. IF THERE ARE ANY DIFFERENCES BETWEEN THE WET SIGNED DOCUMENTS AND ANY OTHER DOCUMENTS, THE WET SIGNED DOCUMENTS SHALL GOVERN. ADVANCE DESIGN CONSULTANTS, INC. IS NOT RESPONSIBLE FOR ANY MODIFICATIONS MADE TO OUR DOCUMENTS BY ANYONE OTHER THAN AUTHORIZED REPRESENTATIVES OF ADVANCE DESIGN CONSULTANTS, INC. PRJ# 14-308-38		Drawing Title TECHNOLOGY OVERALL SITE PLAN Approved: Project Director		Project Title CONSTRUCT PRIMARY CARE SERVICES BLDG. Location 10535 HOSPITAL WAY, MATHER, CA. Date 4/14/16 Checked J. WOODS Drawn J. BERRATO		Project Number 612-400 Building Number 642 Drawing Number T-1000		Office of Facilities Management Department of Veterans Affairs	
---	--	---------------------	--	------------------	--	--	--	--	--	---	--	--	--	--	--