

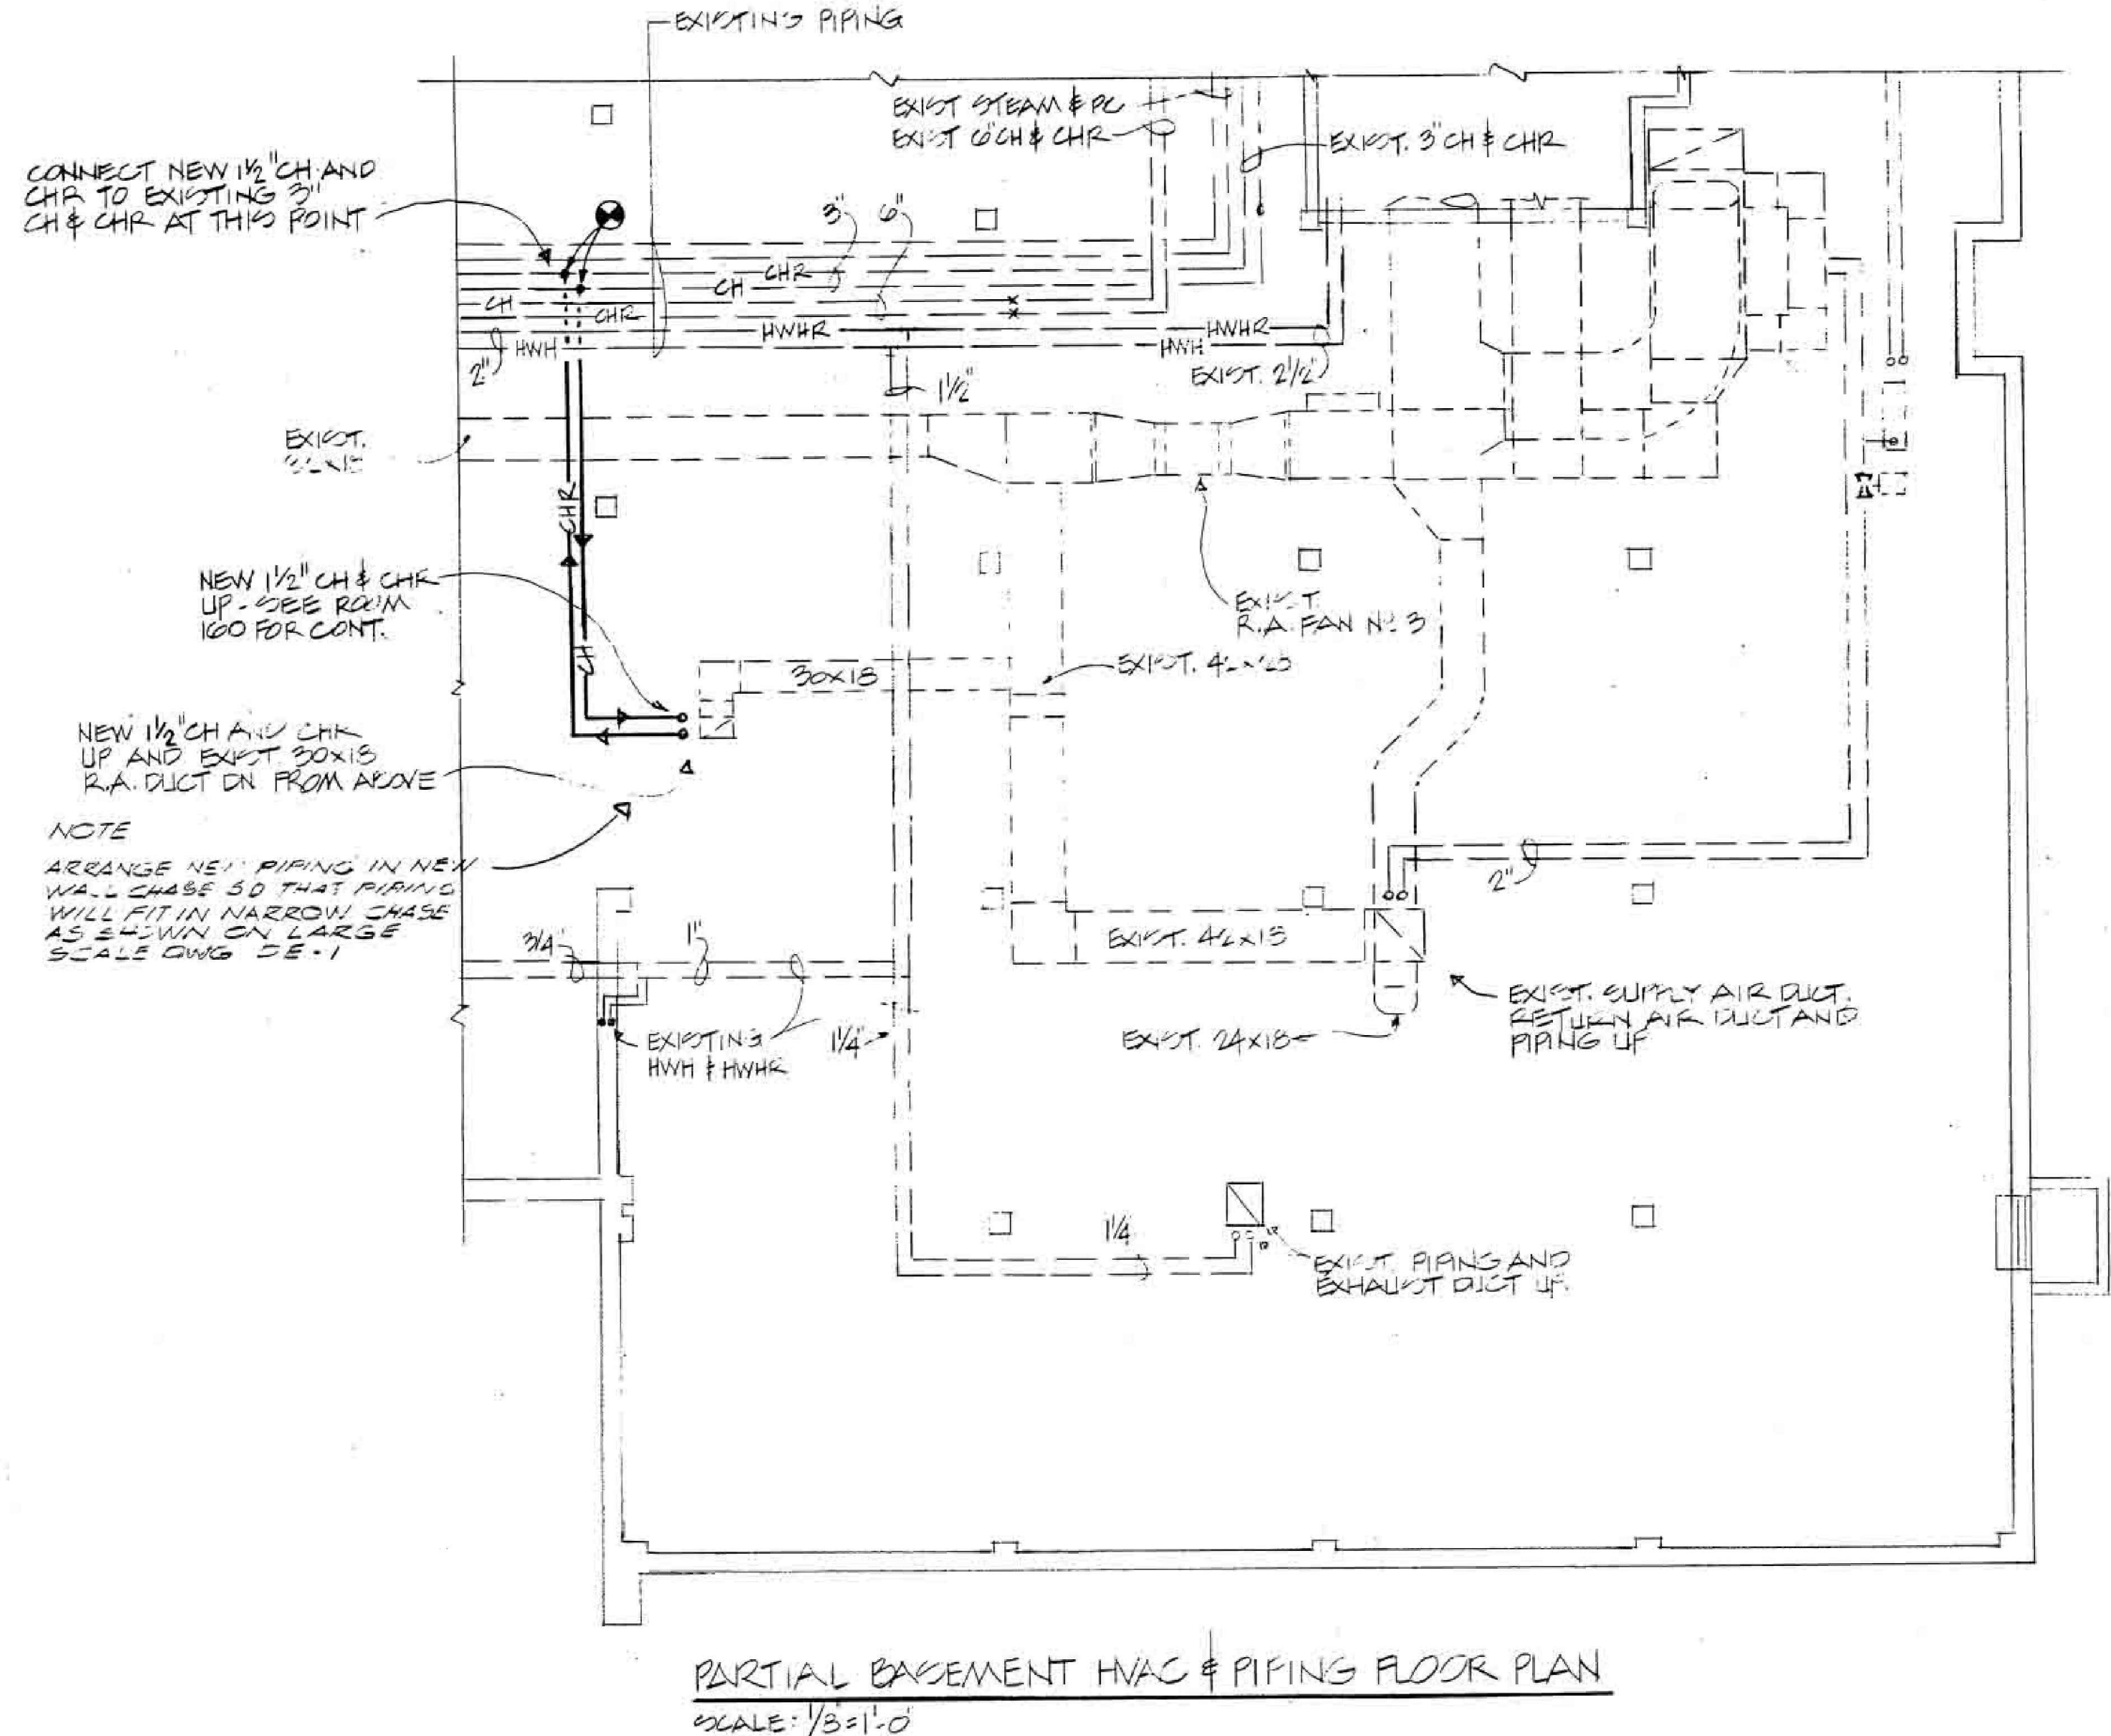


A three inches = one foot
B one and one-half inches = one foot
C one inch = one foot
D three-quarters inch = one foot
E one-half inch = one foot
F three-eighths inch = one foot
one-quarter inch = one foot
one-eighth inch = one foot

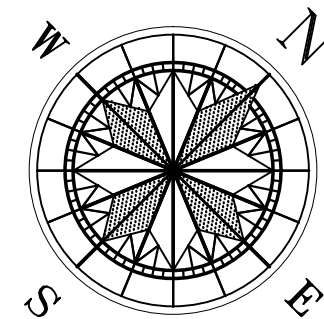

NOTE: THIS PLAN IS PROVIDED FOR
REFERENCE PURPOSES ONLY. ALL
EXISTING DATA SHALL BE FIELD VERIFIED.

HVAC DRAWING INDEX	
SHEET NO.	SHEET TITLE
83M1.1	EXISTING 1996 HVAC MODIFICATIONS-BASEMENT-BUILDING 83
83M1.2	1996 HVAC MODIFICATIONS-MAIN FLOOR-BUILDING 83
83M2.1	HVAC DEMOLITION - MAIN FLOOR - BUILDING 83
83M2.2	HYDRONIC PIPING DEMOLITION RISER DIAGRAM-BUILDING 83
83M2.3	HVAC DEMOLITION PLAN - BASEMENT- BUILDING 83
83M3.1	83-AHU-1 HVAC DETAILS AND SPECIFICATIONS - BUILDING 83
83M3.2	83-AHU-2 & 83-AHU-3 HVAC DETAILS AND SPECIFICATIONS - BUILDING 83
83M3.3	83-AHU-4 - HVAC DETAILS AND SPECIFICATIONS - BUILDING 83
83M3.4	HVAC SCHEDULES, DETAILS, AND PIPING SCHEMATIC - BUILDING 83
83M4.1	HVAC BUILDING AUTOMATION SYSTEM DETAILS - BUILDING 83
83M4.2	HVAC BUILDING AUTOMATION SYSTEM DETAILS - BUILDING 83
83M5.1	OVERALL BASEMENT HVAC PLAN - BUILDING 83
83M5.2	REVISED HVAC PLAN - BASEMENT - BUILDING 83
83M5.3	REVISED HOT WATER HEATING PIPING RISER DIAGRAM - BUILDING 83
83M5.4	HVAC DETAILS - BUILDING 83
90M1.1	EXISTING 1960 HVAC SCHEDULES - BUILDING 90
90M1.2	EXISTING HVAC DETAILS AND HVAC SCHEDULES - BUILDING 90
90M1.3	EXISTING HVAC DETAILS - BUILDING 90
90M1.4	EXISTING HVAC DETAILS - BUILDING 90
90M2.1	EXISTING 1960 HVAC DEMOLITION PLAN PARTIAL FIRST FLOOR PLAN - UNIT "A" - BUILDING 90
90M2.2	EXISTING 1960 HVAC DEMOLITION PLAN PARTIAL FIRST FLOOR PLAN - UNIT "B" - BUILDING 90
90M2.3	EXISTING 1960 HVAC DEMOLITION PLAN SECOND FLOOR PLAN - UNIT "B" - BUILDING 90
90M2.4	EXISTING 1960 HVAC DEMOLITION PLAN PARTIAL FIRST FLOOR PLAN - UNIT "C" - BUILDING 90
90M3.1	90-AHU-1- HVAC DETAILS AND SPECIFICATIONS - BUILDING 90
90M3.2	90-AHU-2- HVAC DETAILS AND SPECIFICATIONS - BUILDING 90
90M3.3	90-AHU-3- HVAC DETAILS AND SPECIFICATIONS - BUILDING 90
90M3.4	90-AHU-4- HVAC DETAILS AND SPECIFICATIONS - BUILDING 90
90M3.5	HVAC SCHEDULES, DETAILS, AND PIPING SCHEMATIC - BUILDING 90
90M3.6	KITCHEN HOOD SCHEDULES AND DETAILS - BUILDING 90
90M3.7	KITCHEN HOOD EXHAUST FAN SCHEDULES AND DETAILS - BUILDING 90
90M3.8	HVAC ENERGY MANAGEMENT SYSTEM - BUILDING 90
90M4.1	HVAC BUILDING AUTOMATION SYSTEM DETAILS - BUILDING 90
90M4.2	HVAC BUILDING AUTOMATION SYSTEM DETAILS - BUILDING 90
90M5.1	HYDRONIC PIPING PLANS - FIRST FLOOR - PART "B" & SECOND FLOOR - BUILDING 90
90M5.2	REVISED HVAC PLAN/HYDRONIC PIPING PLAN - FIRST FLOOR - PART "C" - BUILDING 90
90M5.3	HYDRONIC PIPING RISER DIAGRAMS - BUILDING 90
93M1.1	EXISTING 1960 ORIGINAL HVAC SCHEDULES AND DETAILS - BUILDING 93
93M1.2	EXISTING 1960 ORIGINAL HVAC SCHEDULES AND DETAILS - BUILDING 93
93M2.1	HVAC DEMOLITION PLAN - FIRST FLOOR - BUILDING 93
93M3.1	HVAC SCHEDULES - BUILDING 93
93M3.2	HVAC DETAILS - BUILDING 93
93M4.1	HVAC BUILDING AUTOMATION SYSTEM DETAILS - BUILDING 93
93M4.2	HVAC BUILDING AUTOMATION SYSTEM DETAILS - BUILDING 93
93M5.1	REVISED HVAC PLAN - FIRST FLOOR - BUILDING 93

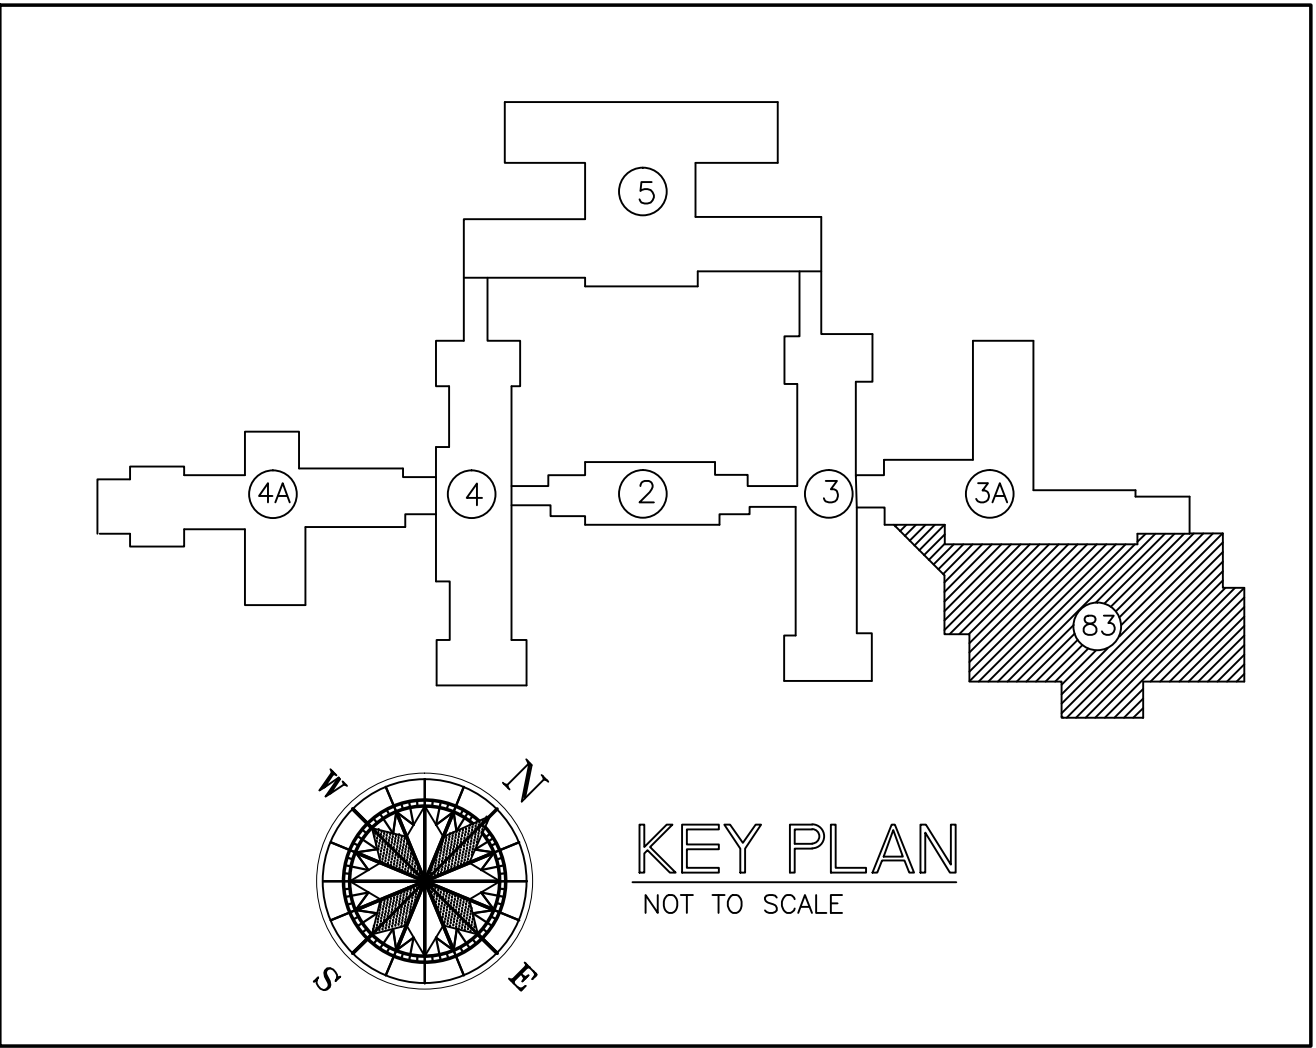

EXISTING 1996 HVAC MODIFICATIONS - BASEMENT -
BUILDING 83

SCALE: 1/8"=1'-0"



MCE MILLS-CONOLY
ENGINEERING, P.C.
8218 Old Federal Road
TELEPHONE: (334) 270-0010
Montgomery, AL 36117
FAX: (334) 270-0040



Approved:	Approved:	Drawing Title	Project Title	Date
Approved:	Approved:	EXISTING 1996 HVAC MODIFICATIONS - BASEMENT - BUILDING 83	HVAC MODIFICATIONS TO BUILDINGS 83, 90, & 93 TUSKEGEE, ALABAMA	12/21/10
Approved:	Approved:	Safety Officer	Building Number 83	Project No. 619-10-445
Approved:	Approved:	Clinical Representative	Checked RDW	Drawing No. 83M1.1
			Drawn TSC	Dwg. 2 of 59
			Location East Campus, Tuskegee, AL	

Veterans
Administration