


OVERALL BASEMENT HVAC PLAN - BUILDING 83

OVERALL BASEMENT HVAC PLAN - BUILDING 83
SCALE: 1/8"=1'-0"

HYDRONIC PIPING LEGEND	
	NEW HOT WATER SUPPLY HYDRONIC PIPING
	NEW HOT WATER RETURN HYDRONIC PIPING
	NEW CHILLED WATER HYDRONIC SUPPLY PIPING
	NEW CHILLED WATER HYDRONIC RETURN PIPING
	EXISTING STEAM PIPING
	EXISTING STEAM CONDENSATE PIPING
	EXISTING CHILLED WATER SUPPLY HYDRONIC PIPING
	EXISTING CHILLED WATER RETURN HYDRONIC PIPING

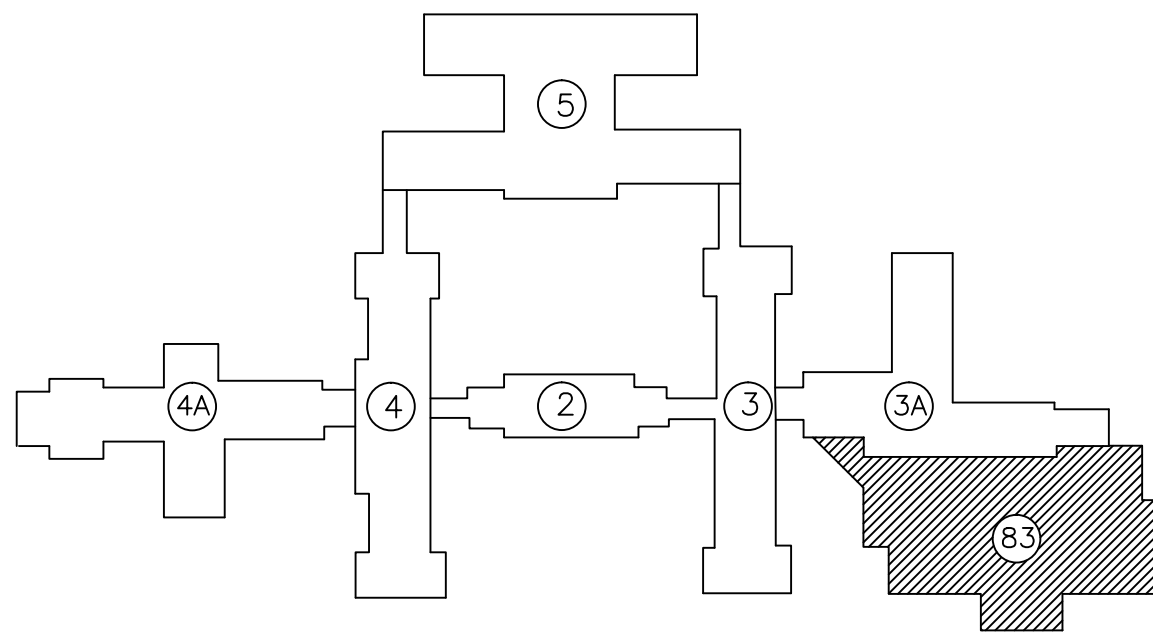


KEY PLAN
NOT TO SCALE

WHORTON ENGINEERING, INC.
HVAC - PLUMBING - PROCESS CONTROL

RANDALL WHORTON, P.E.
PH 256/820-9897 FAX 256/820-9896

25 SUMMERALL GATE ROAD
ANNISTON, ALABAMA 36205

WHORTON ENGINEERING PROJECT NO. 10159

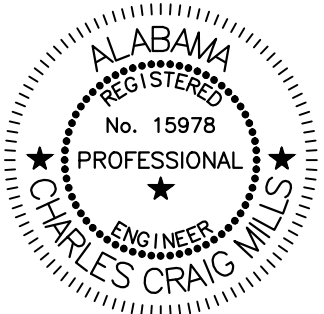

MCE MILLS-CONOLY
ENGINEERING, P.C.

8218 Old Federal Road
TELEPHONE: (334) 270-0010
Montgomery, AL 36117
FAX: (334) 270-0040



Central Alabama Veterans Health Care System

Approved:	
Approved:	
Approved:	
Approved:	

Approved:	
Approved:	
Approved:	
Approved:	

Drawing Title	OVERALL BASEMENT HVAC PLAN - BUILDING 83
Safety Officer	
Clinical Representative	

Project Title	HVAC MODIFICATIONS TO BUILDINGS 83, 90, & 93 TUSKEGEE, ALABAMA		
Building Number	83	Checked	RDW
Location	East Campus, Tuskegee, AL		

Date	12/21/10
Project No.	619-10-445
DRAWING NO.	83M5.1
Drawn	13 of 59

Veterans
Administration