



ENLARGED MECHANICAL ROOMS B-2 & B-5


HYDRONIC PIPING LEGEND	
	NEW HOT WATER SUPPLY HYDRONIC PIPING
	NEW HOT WATER RETURN HYDRONIC PIPING
	NEW CHILLED WATER HYDRONIC SUPPLY PIPING
	NEW CHILLED WATER HYDRONIC RETURN PIPING
	EXISTING STEAM PIPING
	EXISTING STEAM CONDENSATE PIPING
	EXISTING CHILLED WATER SUPPLY HYDRONIC PIPING
	EXISTING CHILLED WATER RETURN HYDRONIC PIPING

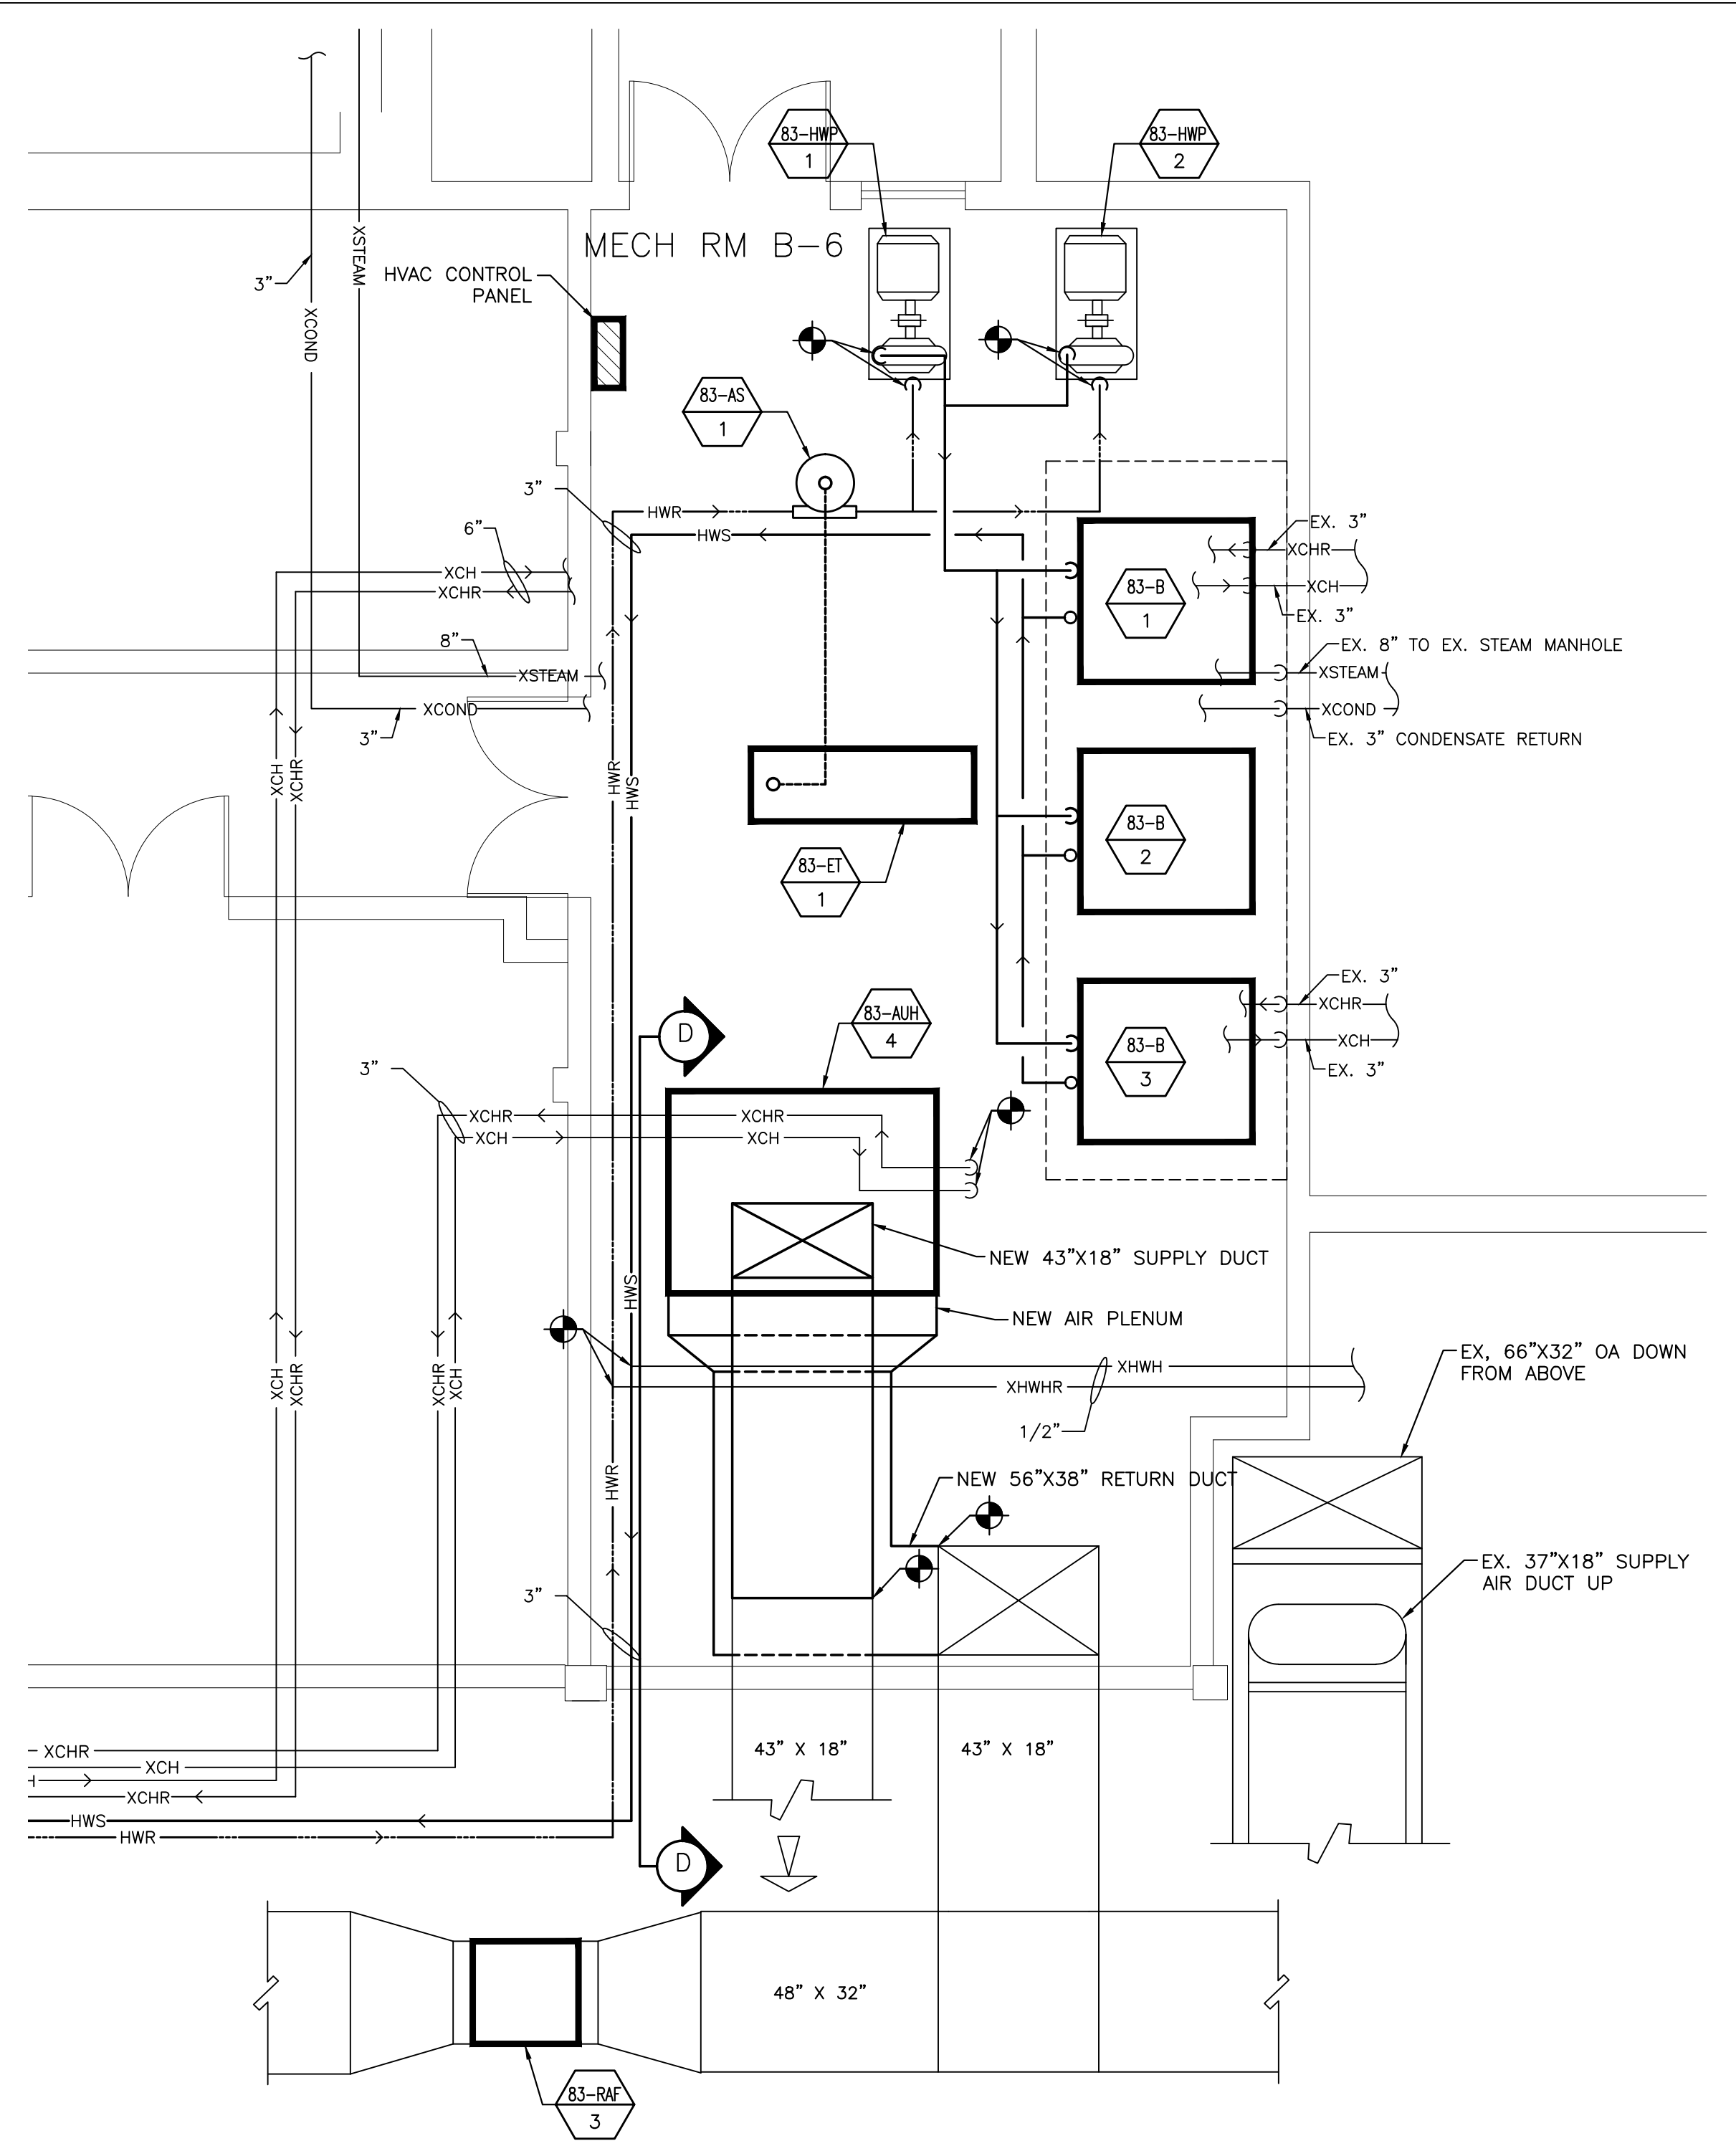


ENLARGED MECHANICAL ROOM B-6

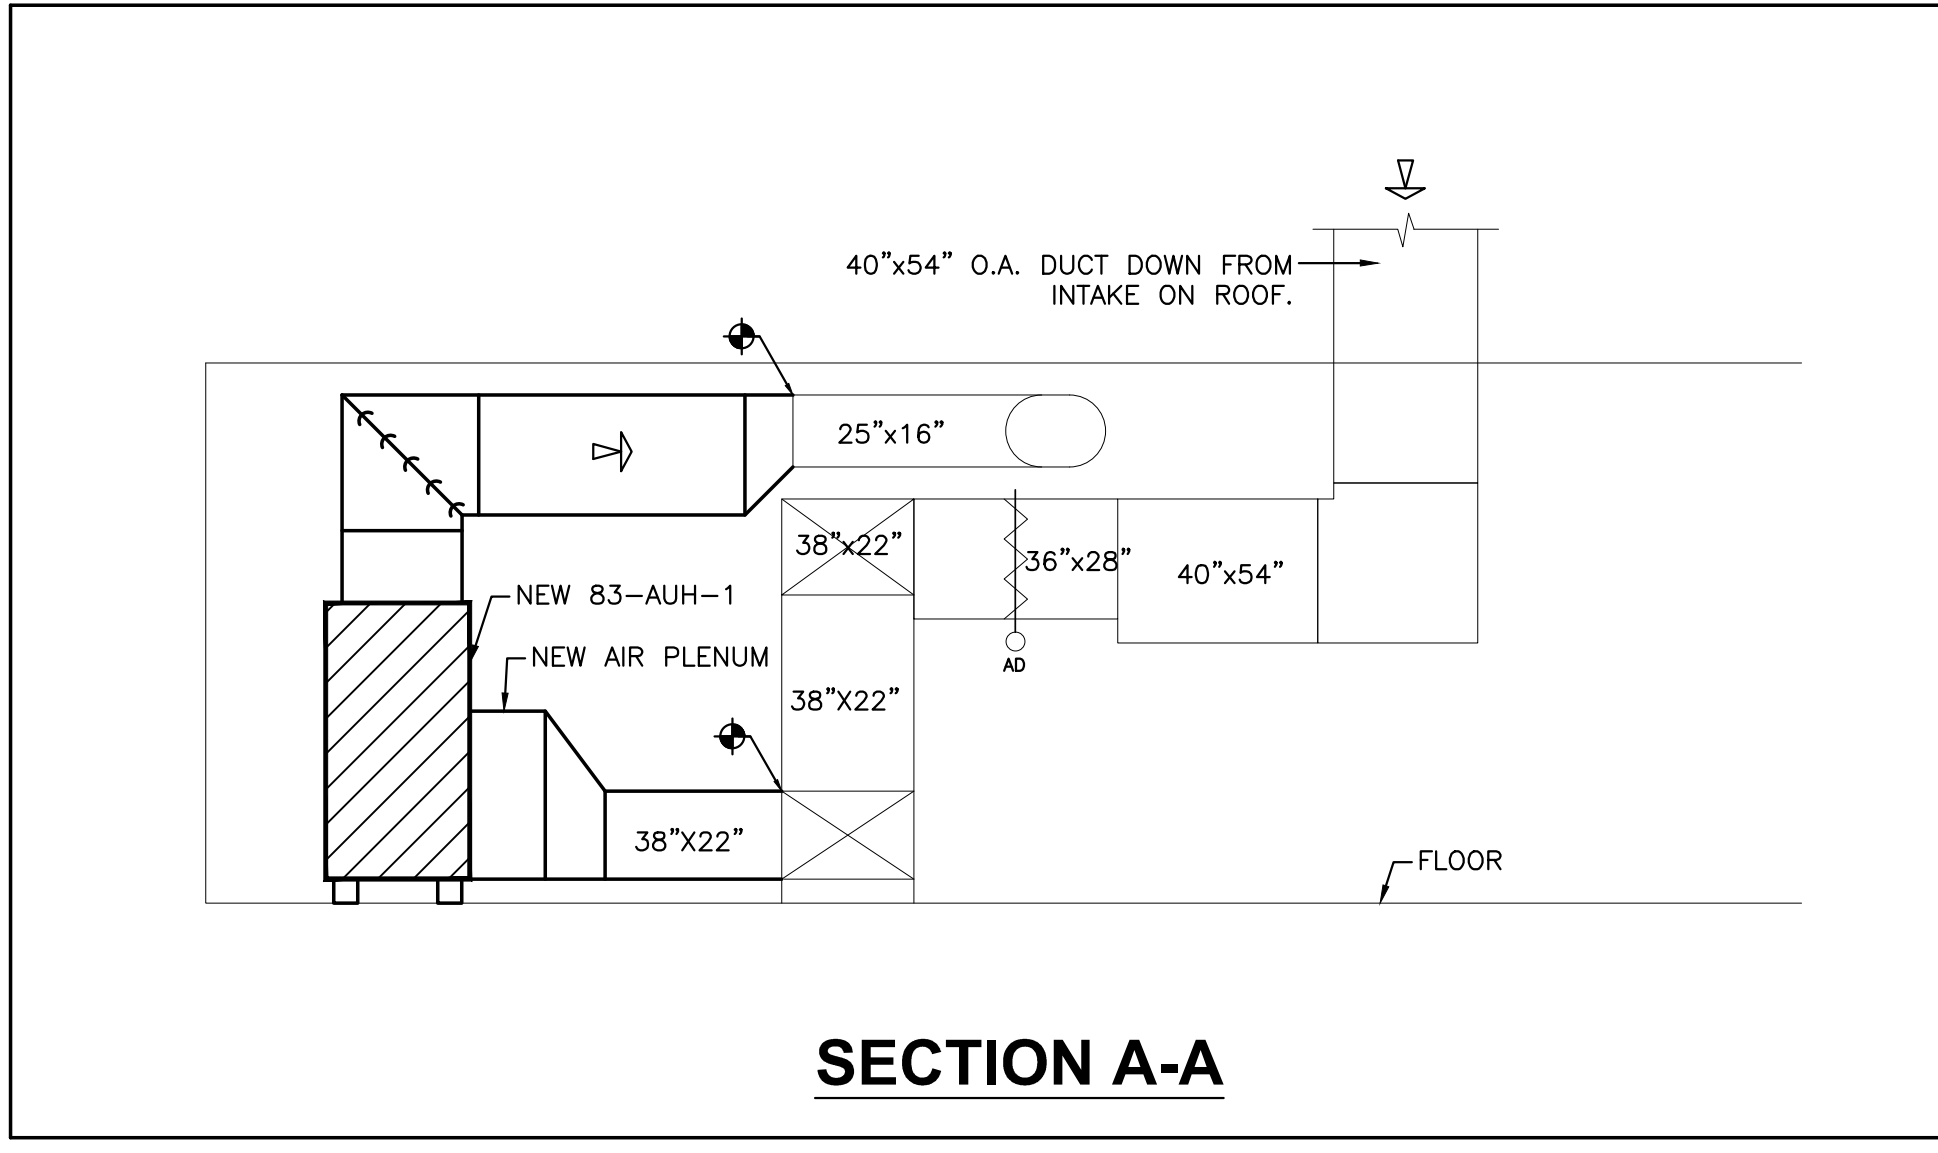


SECTION A-A

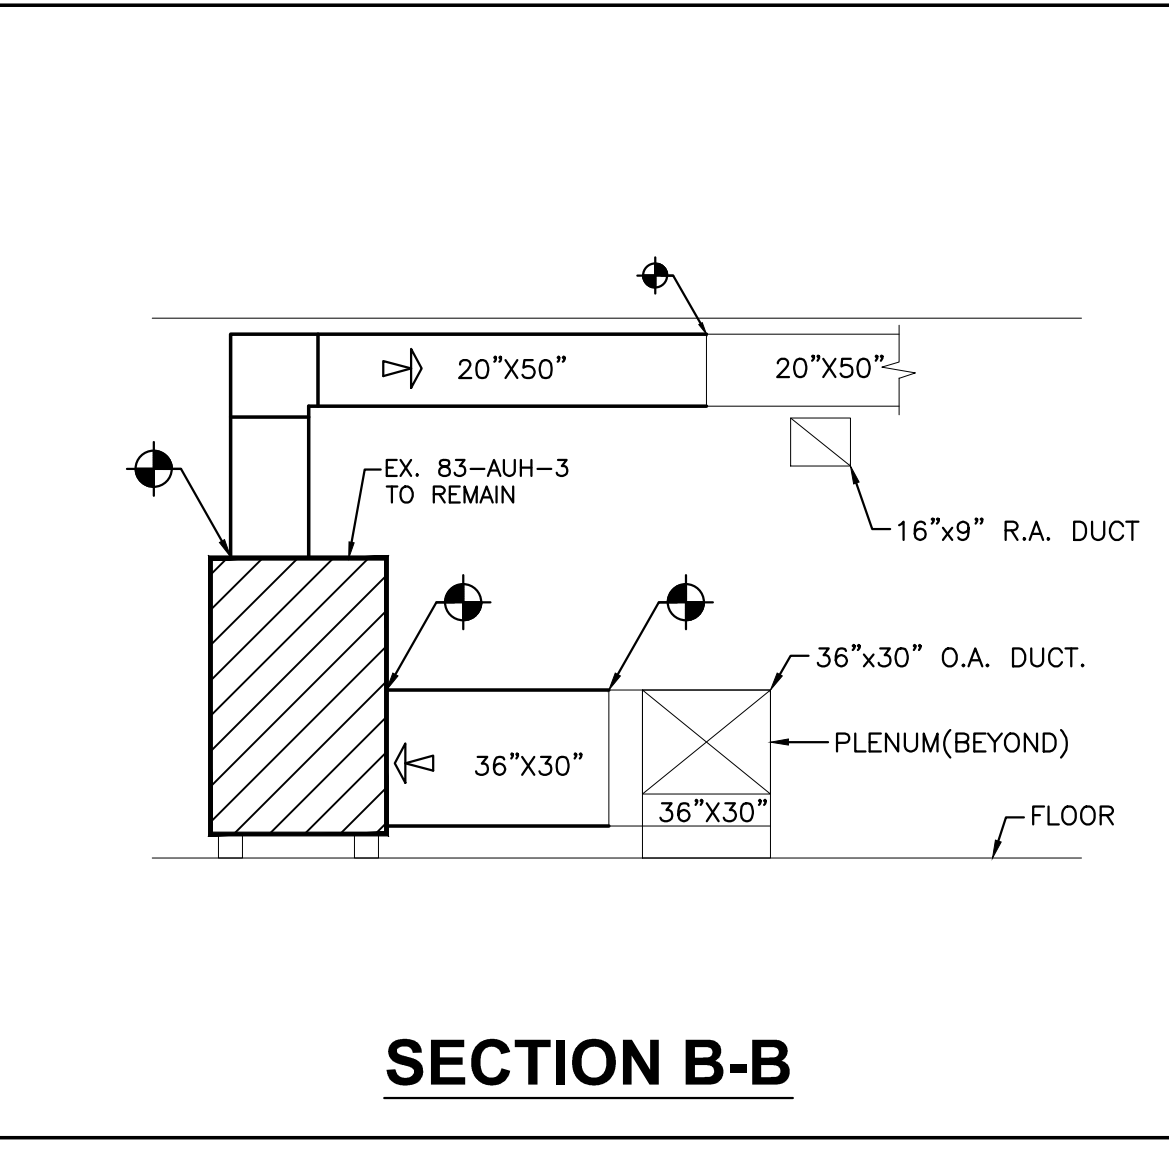


SECTION B-B

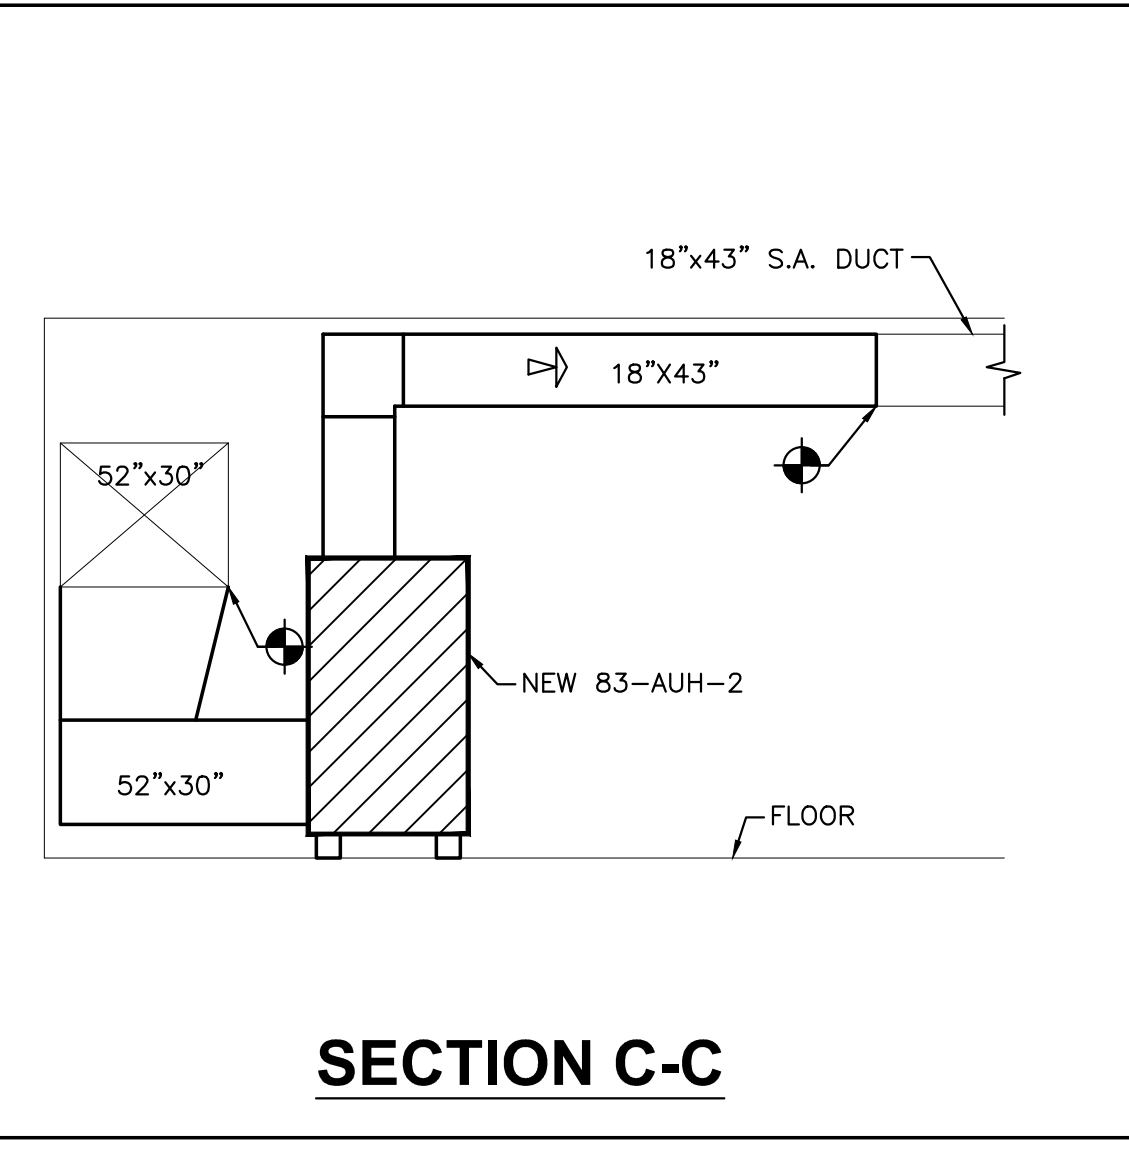

SECTION C-C

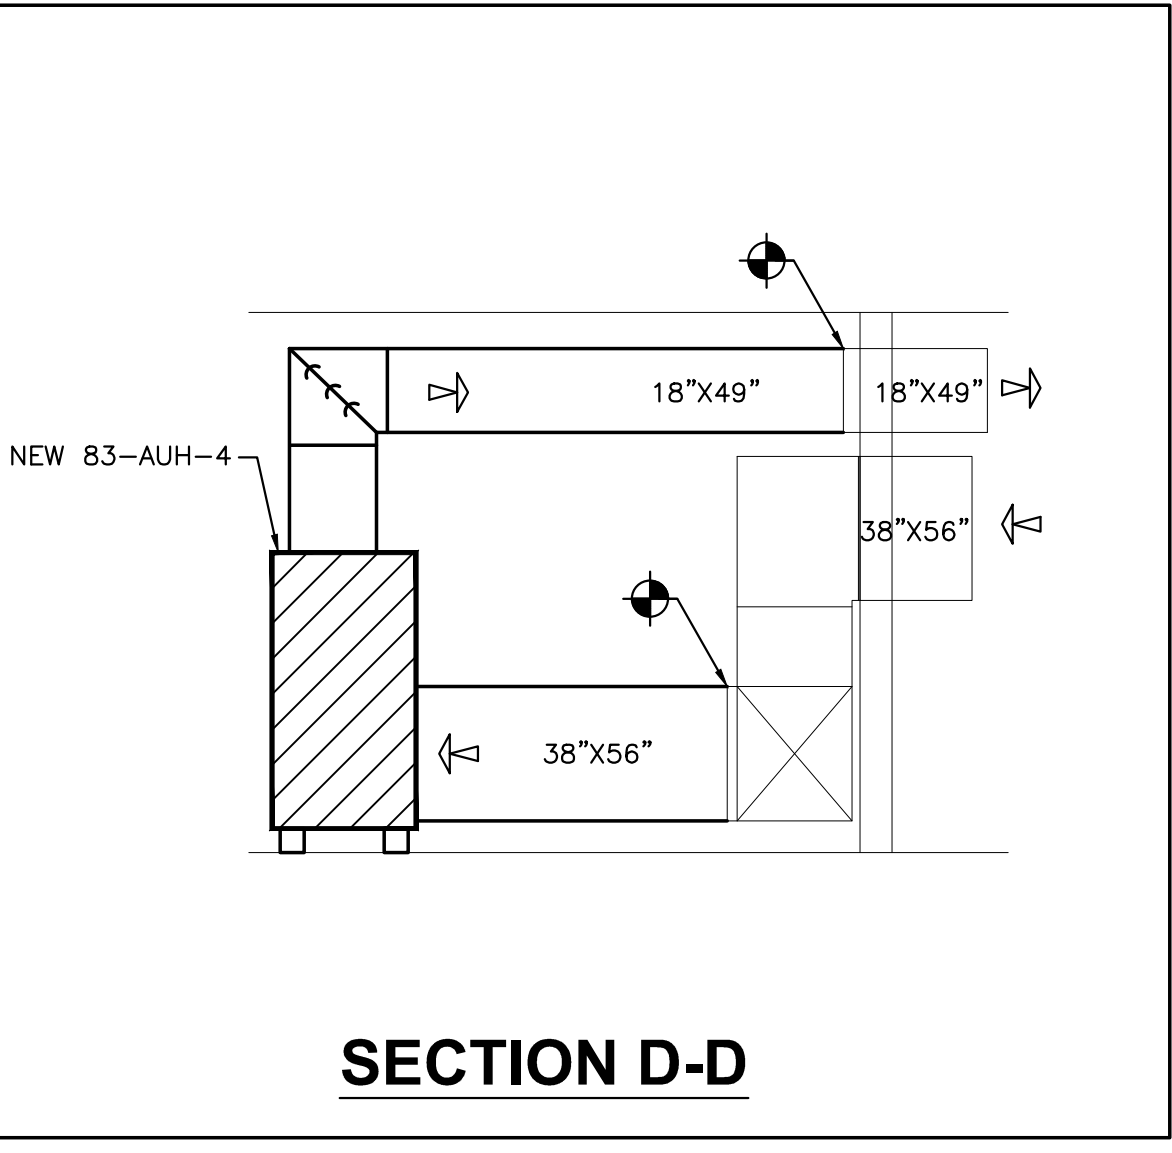

SECTION D-D

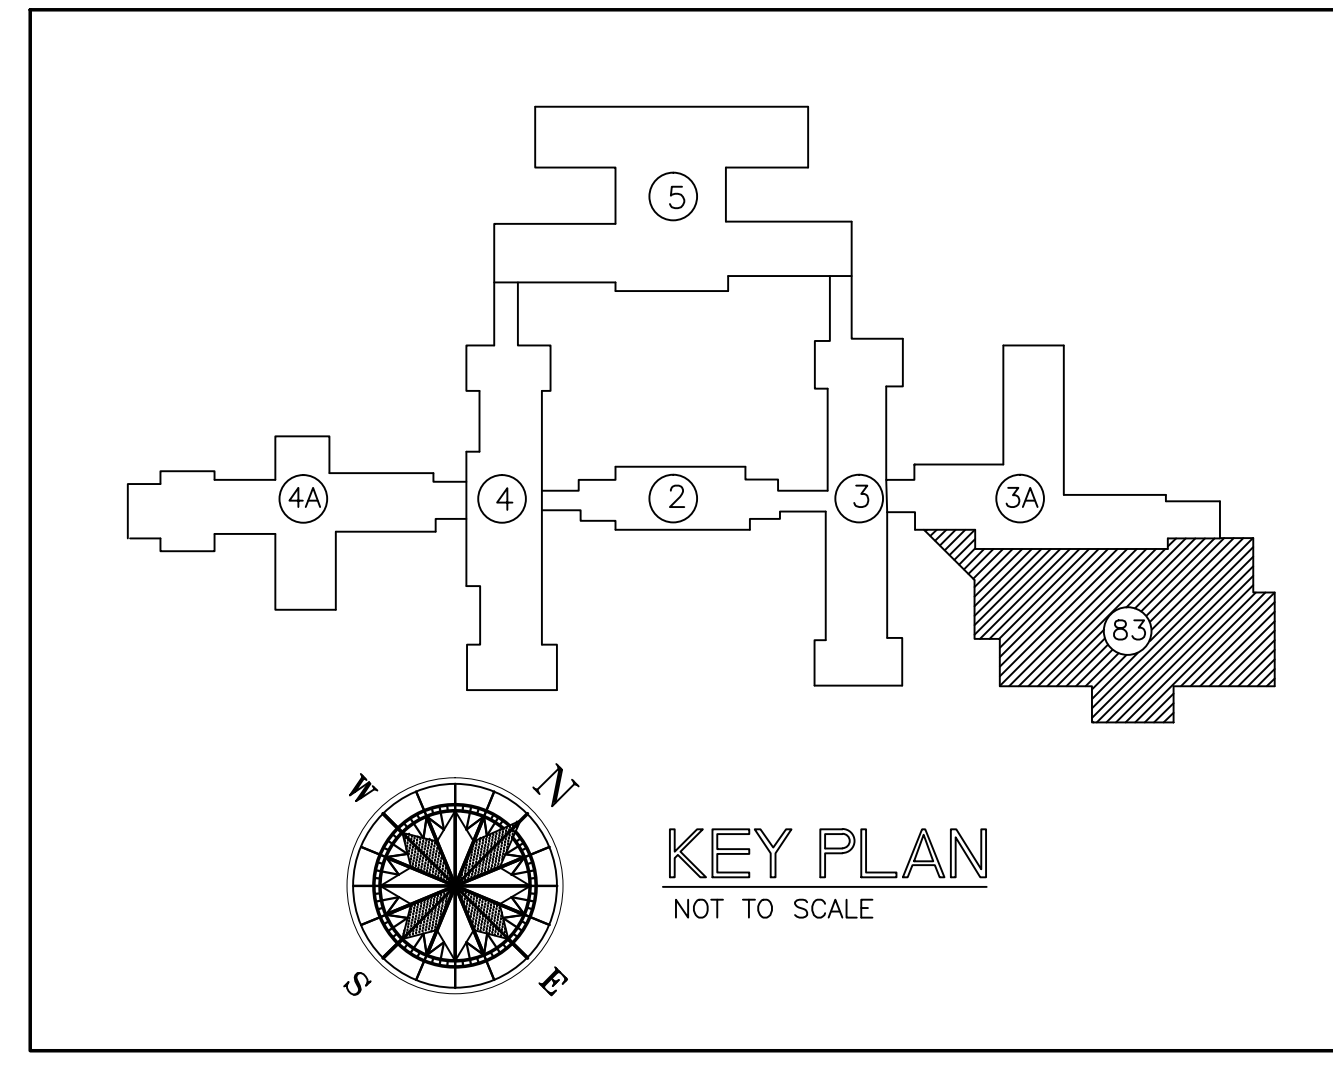

KEY PLAN  
NOT TO SCALE

REVISED HVAC PLAN - BASEMENT - BUILDING 83

SCALE: 1/4"=1'-0"

Revisions	Date

**MCE** MILLS-CONOLY  
ENGINEERING, P.C.

8218 Old Federal Road  
TELEPHONE: (334) 270-0010

Montgomery, AL 36117  
FAX: (334) 270-0040

Central Alabama Veterans Health Care System

Approved:	Approved:
Approved:	Approved:
Approved:	Approved:
Approved:	Approved:

Drawing Title
REVISED HVAC PLAN - BASEMENT - BUILDING 83
Safety Officer
Clinical Representative

Project Title
HVAC MODIFICATIONS TO BUILDINGS 83, 90, & 93 TUSKEGEE, ALABAMA
Building Number
83
Checked
RDW
Drawn
TSC
Location
East Campus, Tuskegee, AL

Date
12/21/10
Project No.
619-10-445
Drawing No.
83M5.2
Dep. 14 of 59

Veterans Administration