




DEMOLITION/INSTALLATION NOTES

- 1 REMOVE EXISTING AFTER FILTER AND DUCT. FURNISH AND INSTALL NEW DUCT WITH NEW ELECTRIC DUCT HEATER AS SHOWN ON REVISED PLANS
- 2 EXISTING ROLL FILTER TO REMAIN IN SERVICE.
- 3 EXISTING AIR HANDLER WITH CHILLED WATER COIL AND HOT WATER/STEAM COIL. REMOVE CHILLED WATER COIL AND REPLACE WITH NEW 15 TON DX HEAT PUMP PUMP COIL. FIELD VERIFY EXACT DIMENSION OF NEW COIL. REMOVE EXISTING HEATING COIL.
- 4 EXISTING AC-1 IS AS NOTED BELOW.
YORK MODEL NO. XTH-045X060-BAJAD46A
SERIAL NO. : CCVMT0160
208-3-60, SUPPLY FAN = 7.5 HP, 10.8 FLA, MCA = 13.5, MOCP = 20
- 5 REMOVE EXISTING RETURN AIR DUCT AND INSTALL NEW DUCT AS SHOWN ON REVISED PLANS.
- 6 EXISTING FAN-COIL UNITS HAVE BEEN PREVIOUSLY OBSOLETE.
- 7 REMOVE ALL EXISTING STEAM, HOT WATER, CHILLED WATER, PNEUMATIC CONTROLS, AND ALL EQUIPMENT, PIPING, ETC. NOT REQUIRED FOR REVISED OPERATION.
- 8 MODIFICATIONS SHALL INCLUDE NEW SIEMENS DDC CONTROLS CONNECTED TO CAMPUS NETWORK.
- 9 REMOVE EXISTING EXHAUST FAN, CAP EXISTING LOUVER INSIDE BUILDING WITH 1" INSULATION DUCT BOARD.

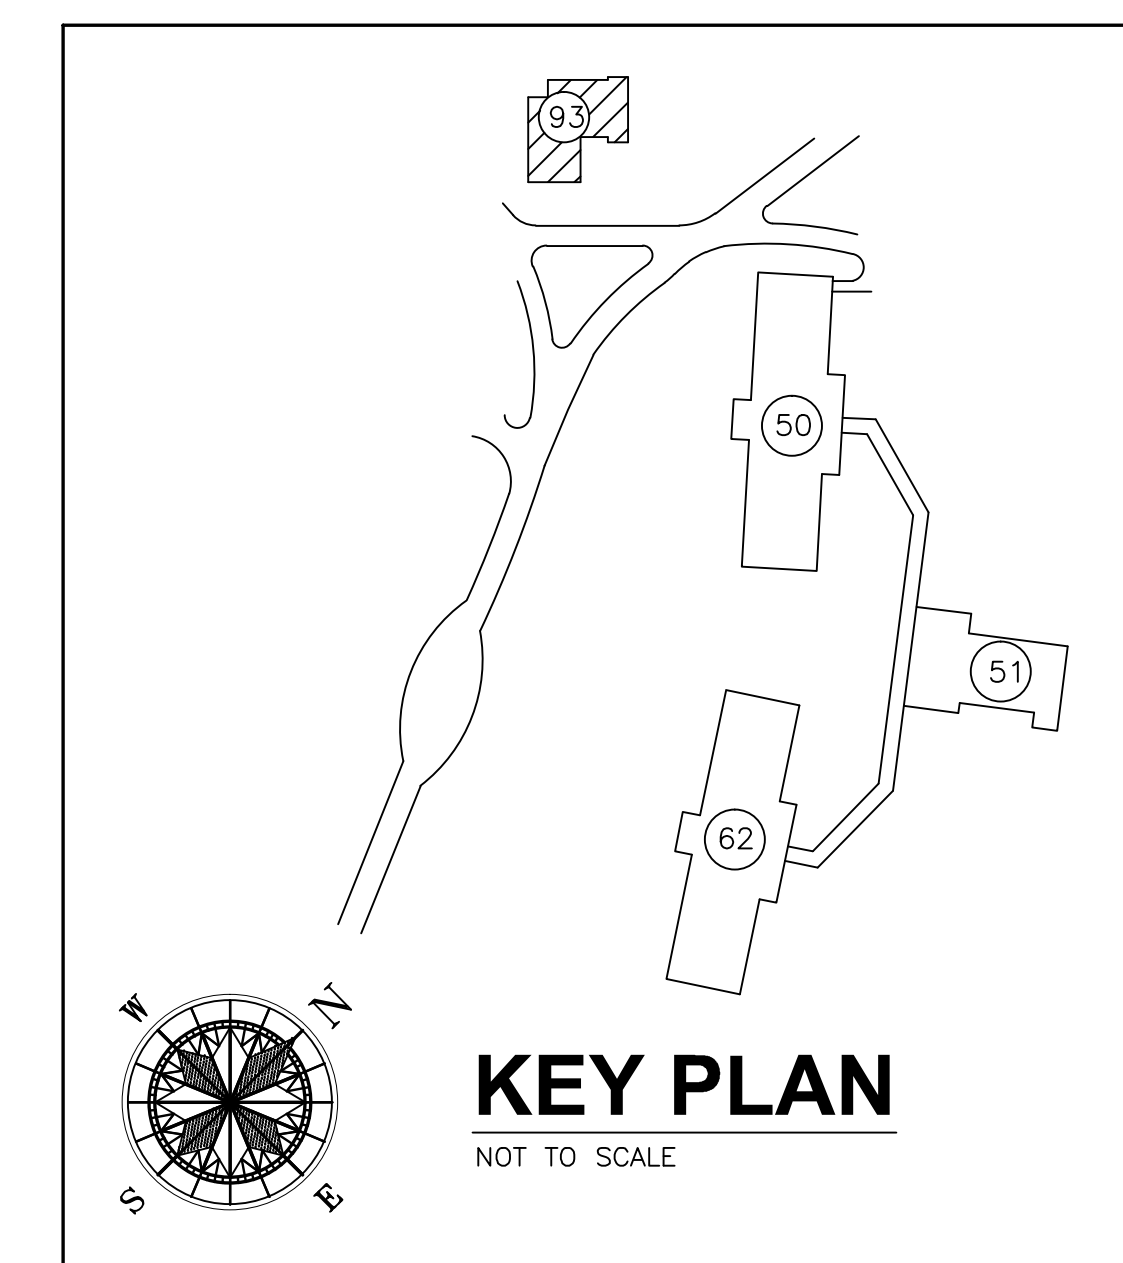

HVAC DEMOLITION PLAN - FIRST FLOOR - BUILDING 93

SCALE: 1/8"=1'-0"

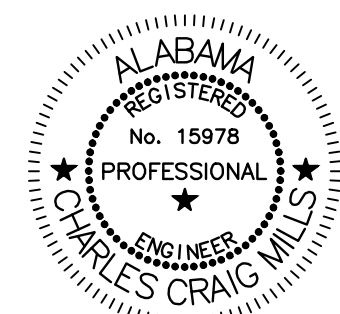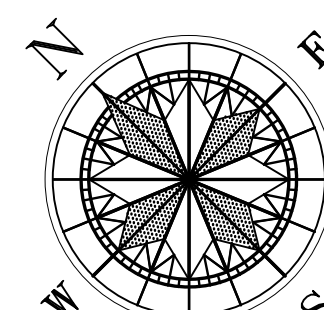

MCE MILLS-CONOLY
ENGINEERING, P.C.

8218 Old Federal Road
TELEPHONE: (334) 270-0010
Montgomery, AL 36117
FAX: (334) 270-0040



Central Alabama Veterans Health Care System

Approved:

Approved:

Approved:

Approved:

Approved:

Approved:

Approved:

Approved:

Drawing Title

HVAC DEMOLITION PLAN -
FIRST FLOOR - BUILDING 93

Safety Officer

Clinical Representative

Project Title

HVAC MODIFICATIONS TO
BUILDINGS 83, 90, & 93
TUSKEGEE, ALABAMA

Building Number

93

Checked

RDW

Drawn

JAD

Location
East Campus, Tuskegee, AL

Date

12/21/10

Project No.

619-10-445

Drawing No.

93M2.1

Drawn by 47 of 59

Veterans
Administration