


BLDG. 8 - 1ST FL.

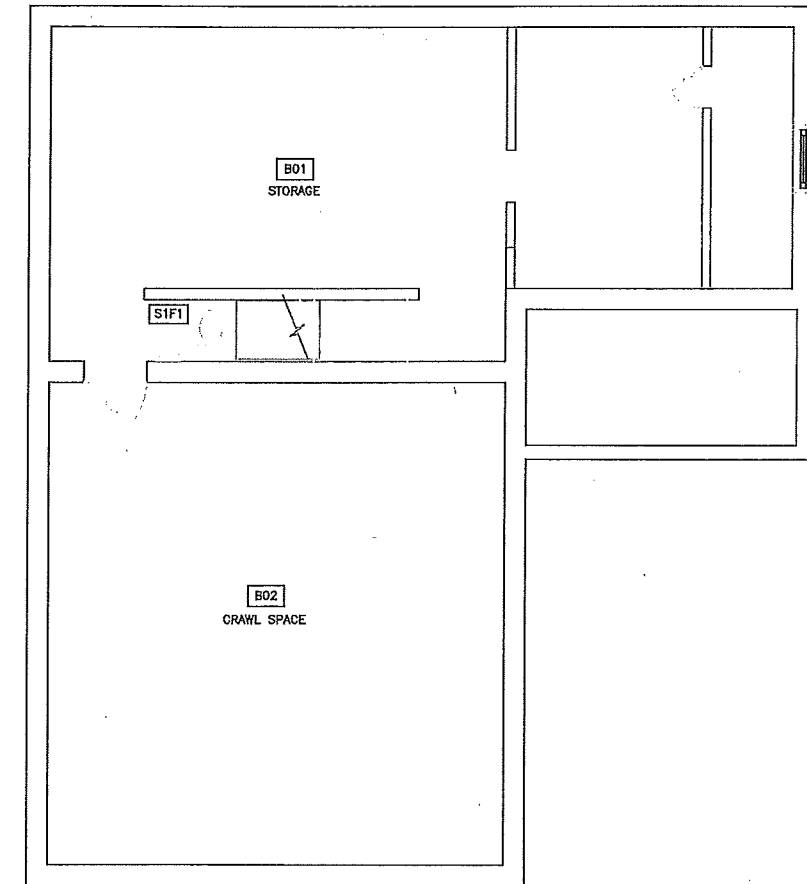

1 BASEMENT FLOOR PLAN
SCALE: 1/4"=1'-0"



	CONSULTANTS:	ARCHITECT/ENGINEERS: SAUNDERS MEP, INC. ENGINEERS - ARCHITECTS 7800 E. UNION AVENUE, SUITE 1100 DENVER, CO. 80237 TEL. 303-217-7080	Drawing Title ARCHITECTURAL BASEMENT/FIRST FLOOR PLANS AS-BUILT - BUILDING 8	Project Title AS-BUILT DOCUMENTS DEPT. OF VETERAN AFFAIRS VAMC CHEYENNE	Project Number VA442-10-108 Drawing Number 8	Office of Construction and Facilities Management
			Location CHEYENNE, WYOMING	Date Jan 14, 2019	Drawing Number A-101	Page 4 of 8