


## NEW WORK KEYED NOTES (POWER)

- ① **WAV BOX, 24V, COMBINE BOXES AND ADD 24V/120V POWER TO EXISTING 20A/1P CIRCUIT BREAKERS INSTALLED IN EXISTING 1FCR8.**
- ② **TV OUTLET TO BE ADDED, CONNECT TO EXISTING SERVICE.**
- ③ **SEE MECHANICAL PLANS FOR LOCATIONS OF EXHAUST FANS PROVIDE 20/1 LOCAL DISCONNECT SWITCH.**

## DEMOLITION KEYED NOTES (POWER)

 
- ① EXISTING SPACE AND RECEPTACLES TO REMAIN.
- ② DEMOLISH EXISTING RECEPTACLES COMPLETE BACK TO POINT OF ORIGIN INCLUDING, BUT NOT LIMITED TO CONDUIT AND WIRING. ANY CIRCUITS TO REMAIN IN USE SHALL BE EXTENDED AS NECESSARY TO BE RELOCATED SPACE SPACES OF EXISTING PANELS.

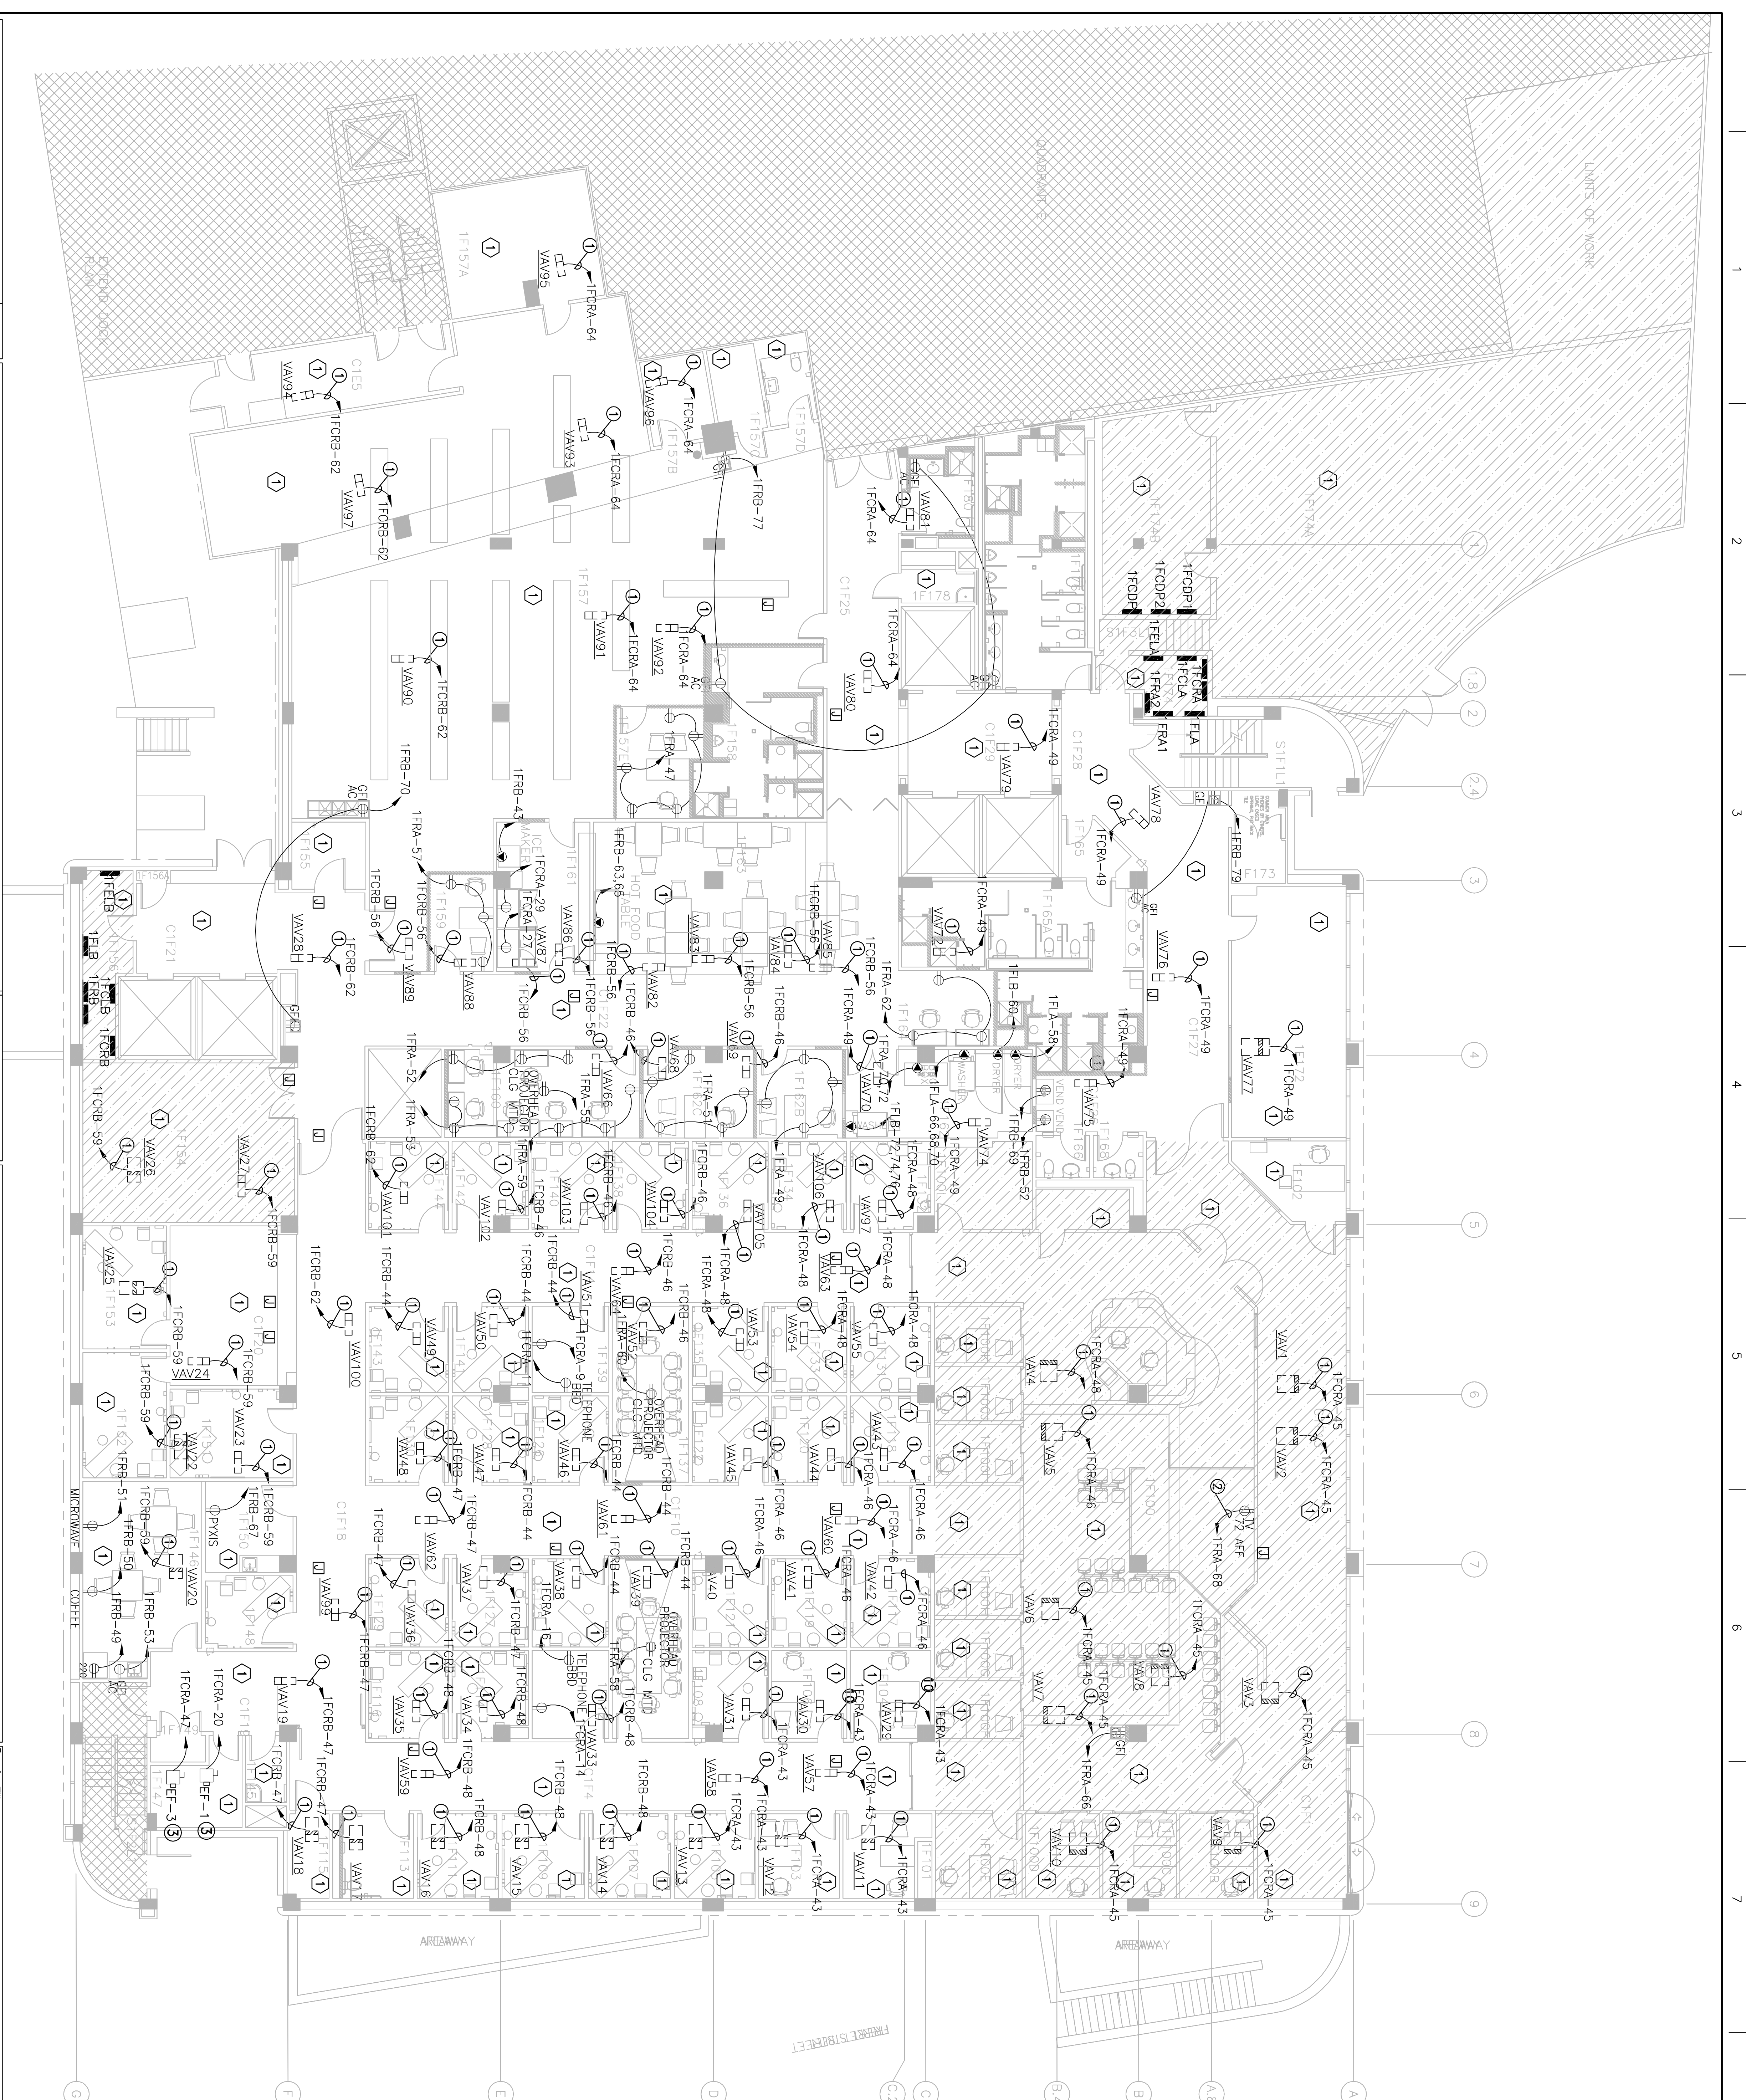

POWER PLAN - FIRST FLOOR  
SCALE 1/8" = 1'-0"

SCALE 1/8" = 1'-0"

GRAPHIC SCALE

$$1/8"=1'-0"$$


## AS-BUILT DRAWINGS

[illegible]