

RFI 07212.1: All exterior walls where J-4 walls were deleted and more than 3/4" of fire safing is exposed to be handled per RFI.

FLOOR PLAN LEGEND

NOT ALL SYMBOLS/NOTES APPEAR ON EVERY SHEET
WHERE SYMBOL REFERENCES ANOTHER DRAWING, SERIES
SYMBOL, IS SHOWN FOR BOUNDARY/REGIONAL COORDINATION
ONLY. REFERENCE THE DIMENSIONING DRAWINGS FOR FULL
SCOPE OF SYMBOL LOCATIONS & ASSOCIATED SPECIFICATIONS

GENERAL FLOOR PLAN NOTES

FLOOR PLAN SHEET NOTES


FLOOR PLAN SHEET NOTES

[illegible]

12 MAY 02 14:50:00 07004

[illegible]

KEY PLAN

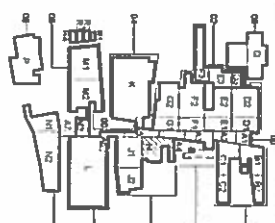

**CONSTRUCTION DOCUMENTS 1
FULLY SPRINKLERED**

OFFICE OF
CONSTRUCTION

MANAGEMENT

3
 VOLUME 15

10

REVISIONS:	DATE
01 BILLING	10/15/03
02 BILLING	10/15/04
03 BILLING	10/15/04
04 BILLING	10/15/04
100 BILLING	10/15/04

CONSULTANTS:
DESIGN ASSOCIATES / PARKING
CODE CONSULTANTS, INC. / CODE CONSULTANTS
THE SERGANT GROUP / AN & ACOSTA
HAMMER DESIGN ASSOCIATES / FOOD SERVICE
PYPBURN & ODOM / ABATEMENT
TATA & HOWARD / TASK CONSULTANT
I.S.C. GROUP, INC. / IRRIGATION
DAN EUSER WATER ARCHITECTURE, INC. / WATER

TERMINAL

ARCHITECT/JEN

studios NOVA


SCHREINK & PETERSON CO.
KORDANEMETH ENGINEER
BR-A CONSULTING ENGINEER
ARCHITECTURAL ENGINEER
SCALES ASSOCIATES / FRI

4

ENGINEERS:
CONSULTING ENGINEERS / CIVIL
ENGINEERING / STRUCTURAL
ENGINEERS / MECH. ELECT.
PLUMBING, LOW VOLTAGE
WIRING / PLUMBING
FIRE PROTECTION

BLDG 3 FIRST FLOOR PLAN - AREA 1

PROJECT TITLE	SLIVICS REPLACEMENT MEDICAL CENTER PROJECT		
LOCATION	NEW ORLEANS, LOUISIANA		
DATE	February 29, 2012	DIRECTED BY	ML
		DESIGNED BY	ADD/MDM

PROJECT NUMBER 629-HSZ-401	BUILDING NUMBER 03	DOCUMENT REFERENCE WPA-08	DRAWING NUMBER 3A1101-H	 Department of Virginia

OF
ACTION
ILITIES
EMENT



CONSULTANTS:	
DESIGN ASSOCIATES / PARKING	
CODE CONSULTANTS, INC. / CODE CONSULTANT	
THE SEXTANT GROUP / AV & ACUSTICAL	
HAMMER DESIGN ASSOCIATES / FOOD SERVICE	
RYBURN & ODOM / ABATEMENT	
TATY & HOWARD / TANK CONSULTANT	
U.S.C. GROUP, INC. / IRRIGATION	
DAW EUBER WATER ARCHITECTURE, INC. / WATER FEATURE	
10/19/2013	DATE
10	BUL 015C VE
REVISIONS:	



ARCHITECT/ENGINEERS:	
NOVA	
SCHRECK & PETERSON CONSULTING ENGINEERS / CIVIL	
KORDANEMETH ENGINEERING / STRUCTURAL	
BRYAN CONSULTING ENGINEERS / MECH. ELECT. PLUMBING, LOW VOLTAGE	
ARCHITECTURAL ENGINEERING / PLUMBING	
SCALES ASSOCIATES / FIRE PROTECTION	

BLDG 3 OVERALL SIXTH FLOOR PLAN	
APPROVED PROJECT DIRECTOR	

PROJ. CT. TITL.	
SERVICES REPLACEMENT MEDICAL CENTER PROJECT	
DATE	CHECKED
February 29, 2012	ML
NEW ORLEANS, LOUISIANA	AG/OMK


PROJECT NUMBER	
029-HS2-401	03
DOCUMENT SET PACKAGE	
WP_08	
DRAWING NUMBER	
3A1106	

OFFICE OF CONSTRUCTION AND FACILITIES MANAGEMENT	
Department of Veterans Affairs	



CONSTRUCTION DOCUMENTS I

F

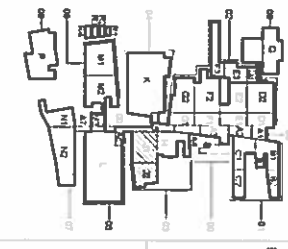


REVISIONS: ALL CHANGES TO BE MADE TO THE ORIGINAL DRAWING. ANY CHANGES TO THE ORIGINAL DRAWING MUST BE MADE TO THE ORIGINAL DRAWING. ANY CHANGES TO THE ORIGINAL DRAWING MUST BE MADE TO THE ORIGINAL DRAWING.

Scale: 1" = 45'

0' 45' 90'

1 BLDG 3 OVERALL SIXTH FLOOR PLAN

REFER TO THE FOLLOWING SKETCH FOR CHANGES
SK-8-4-NJ 3A1106

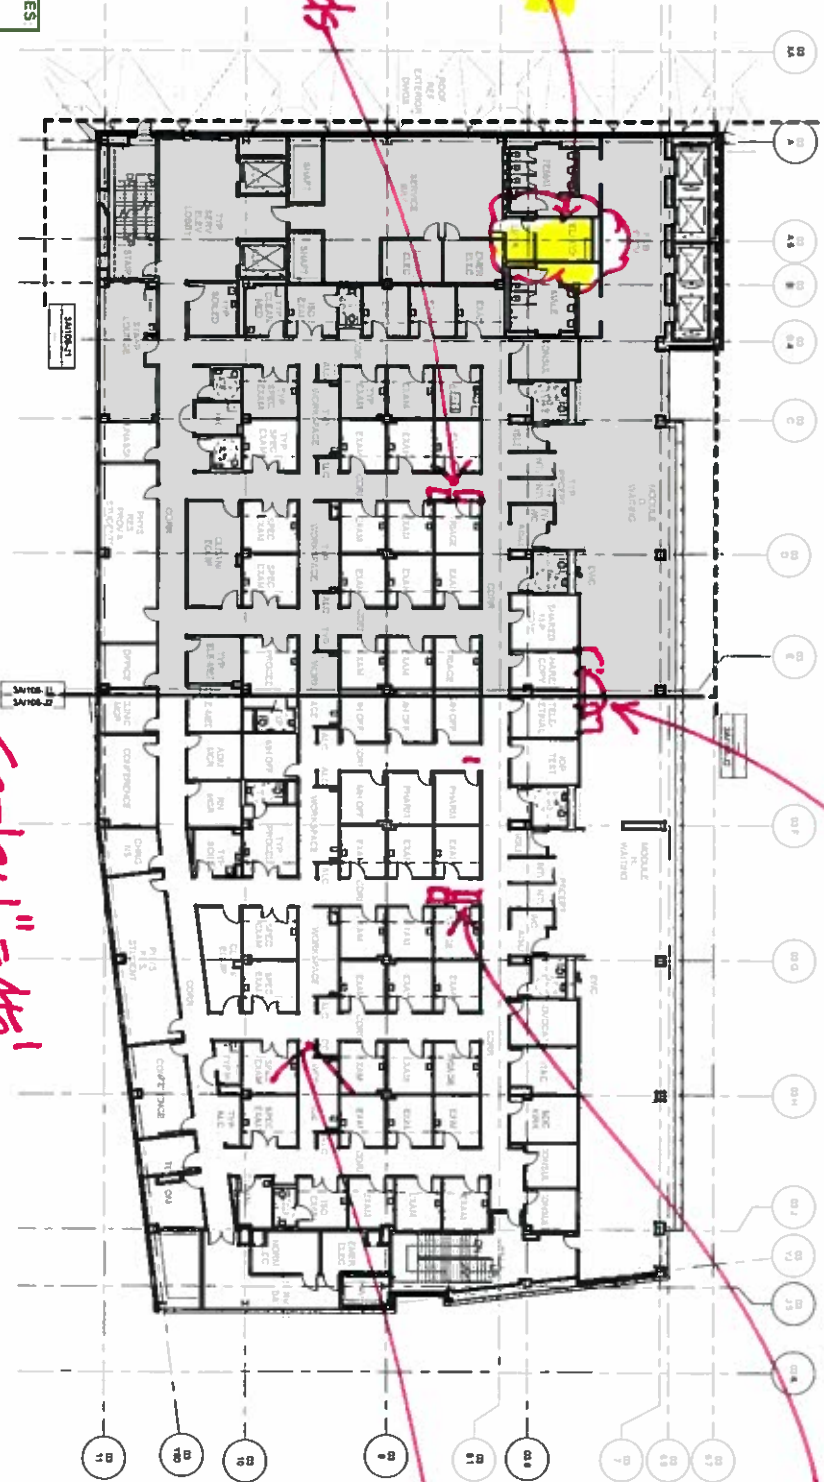

R-13538 Location of Control No nls


queuing monitor
+ 2 floor stand kiosks

2 display boards

Primary Care

2 display boards

closets

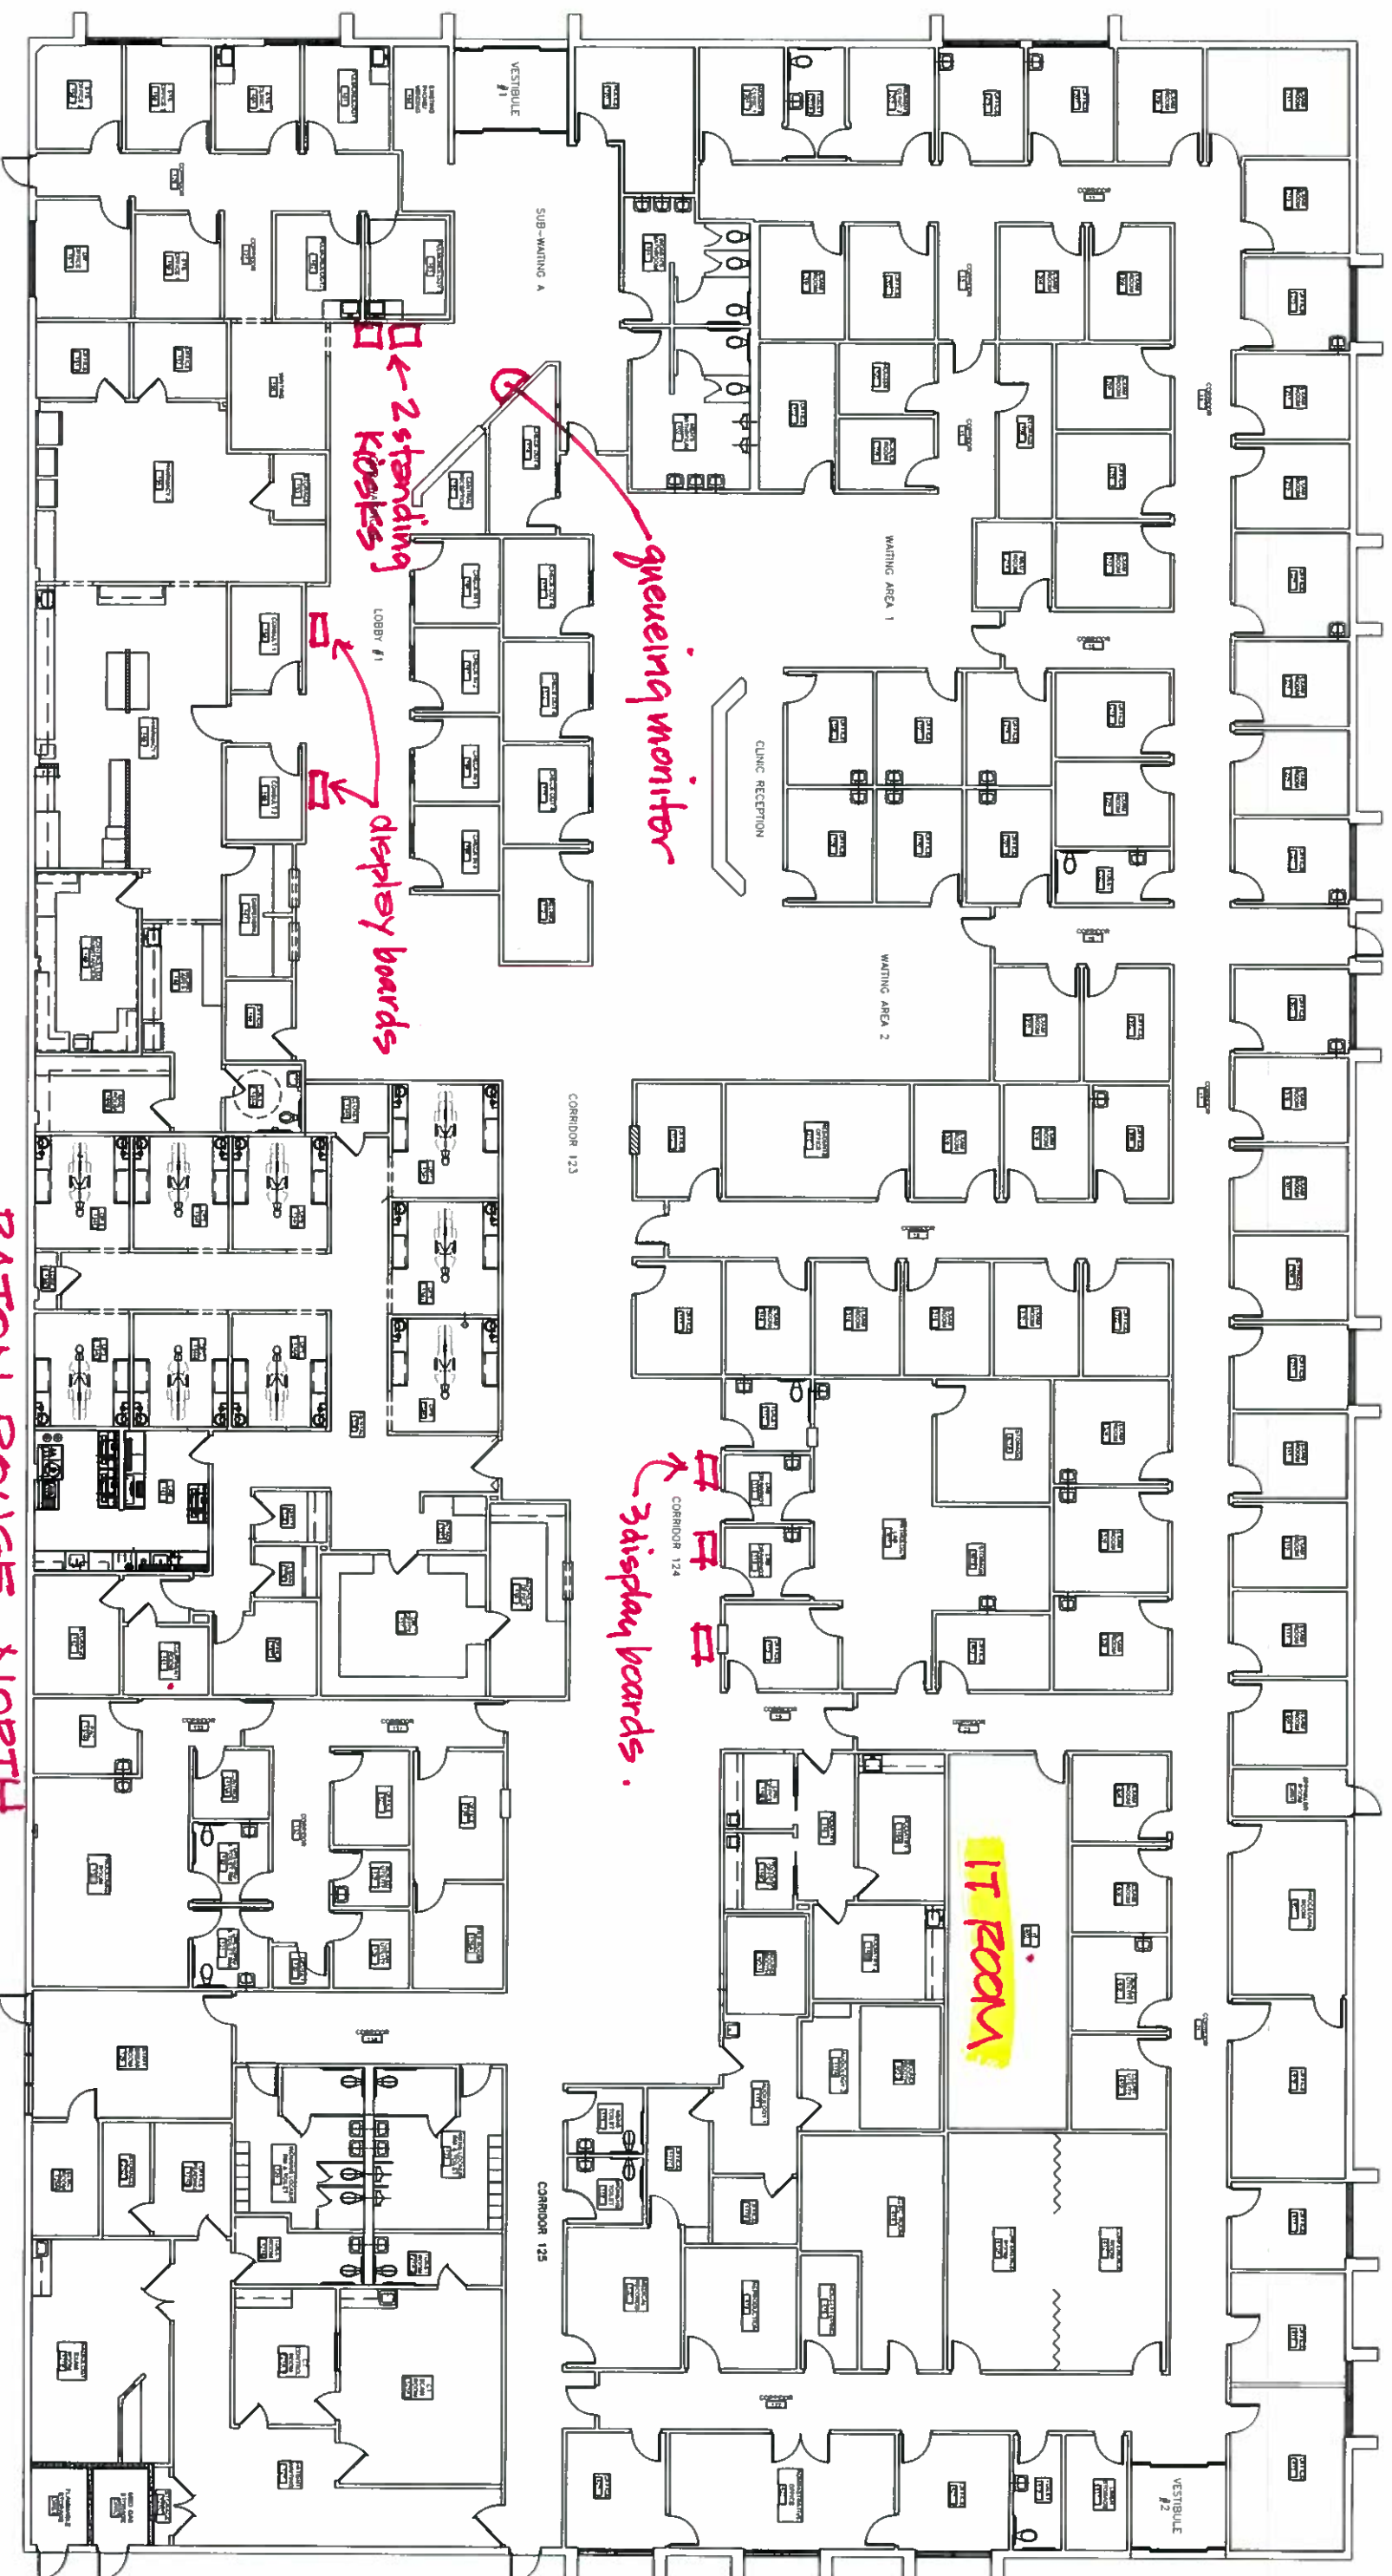

BATON ROUGE - NORTH

Scale: 1"=16'

0' 16' 32' 48'