


# AMARILLO VA HEALTHCARE SYSTEM EMERGENCY DEPARTMENT BUILDING

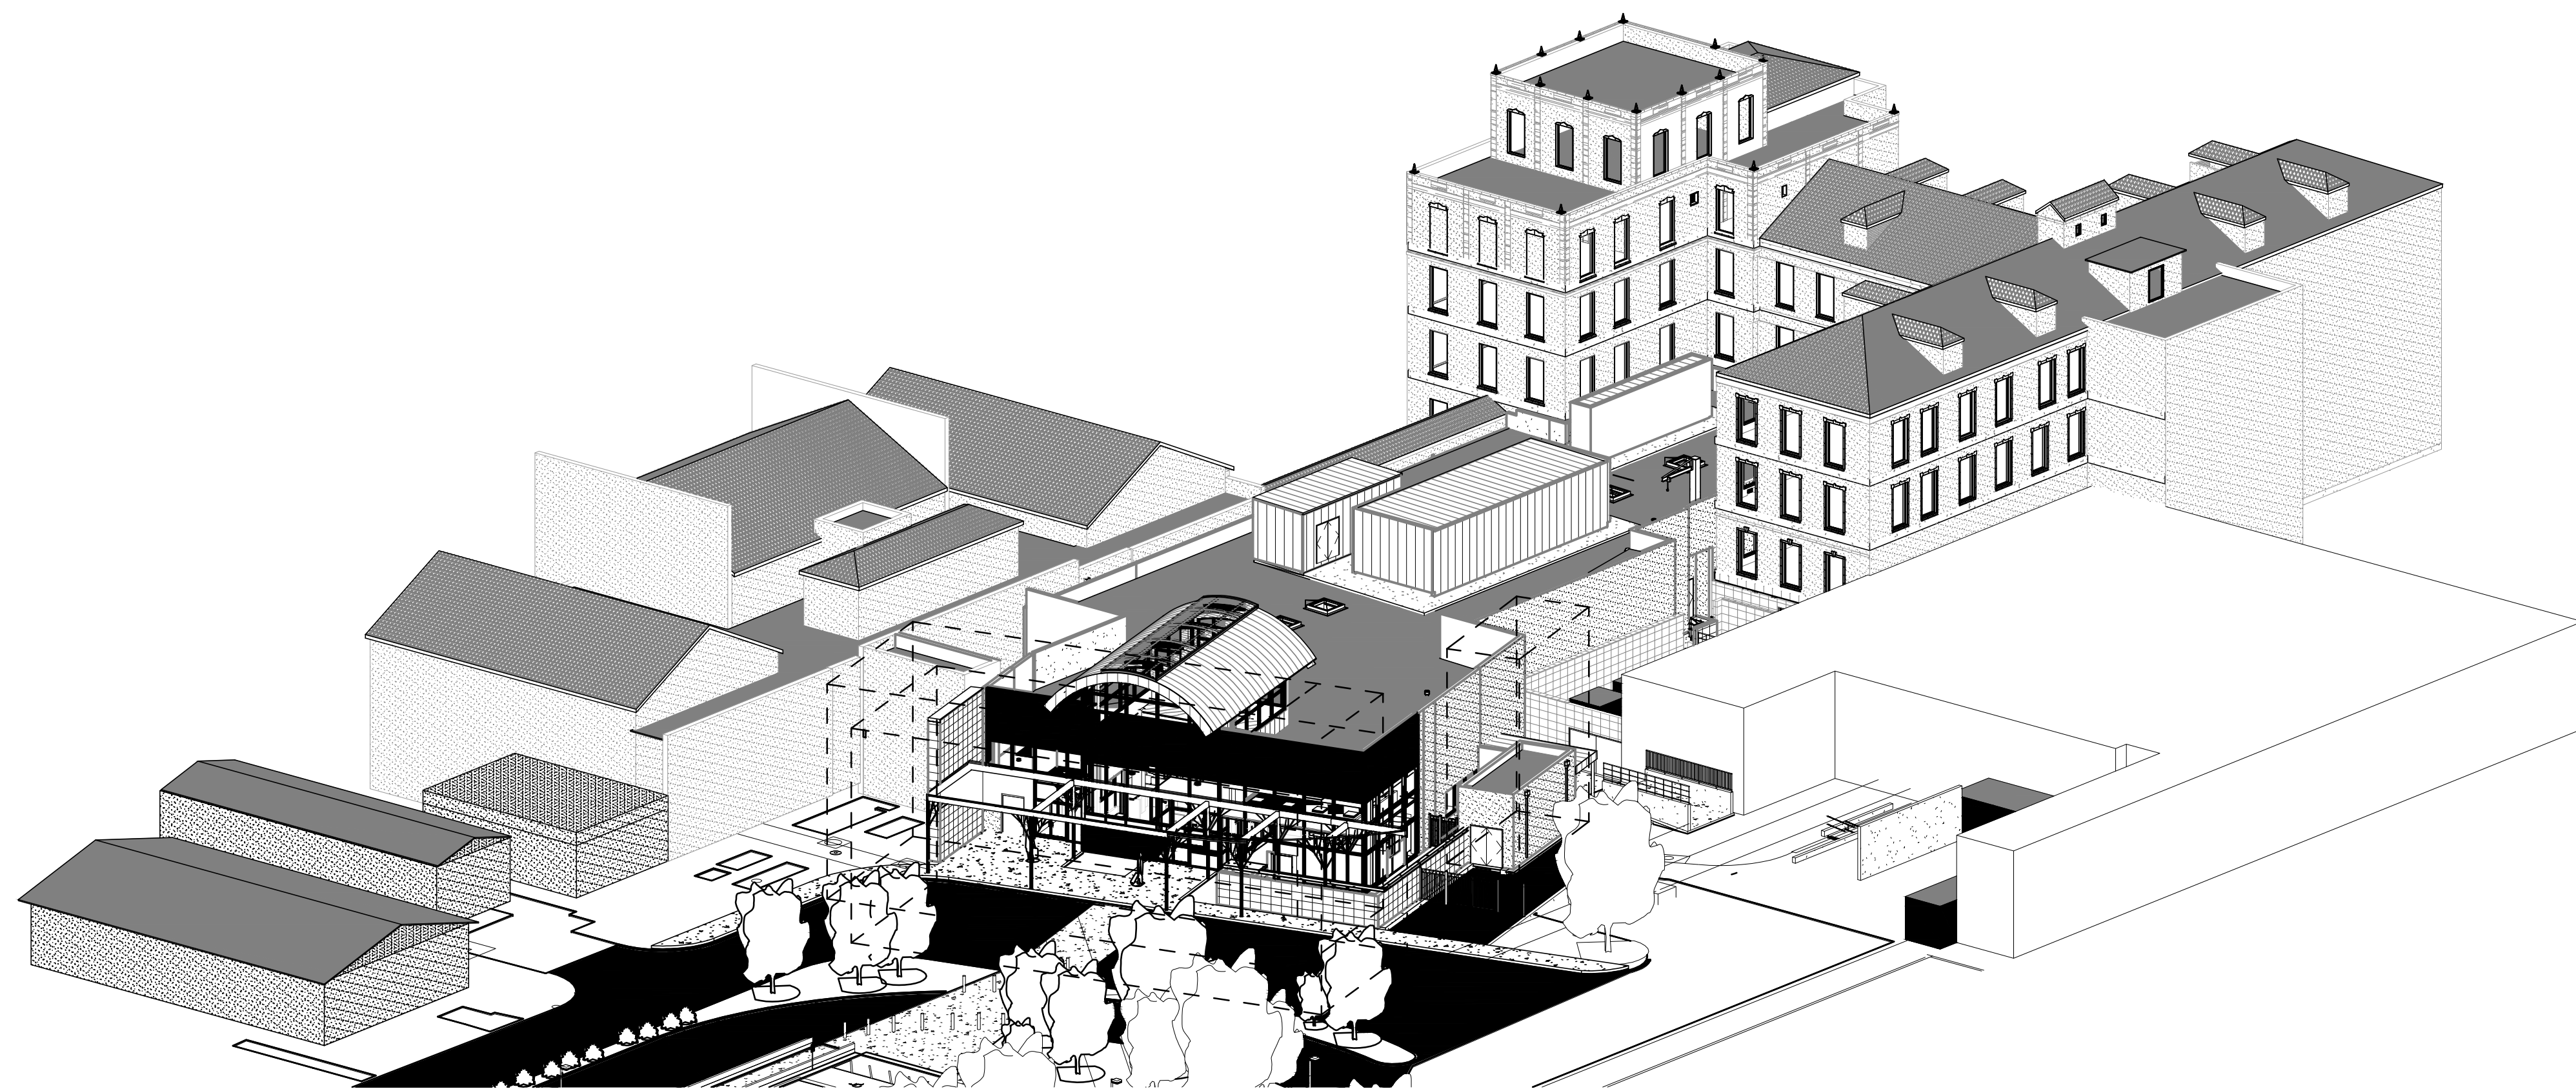

## PROJECT TEAM

### OWNER

AMARILLO VA HEALTH CARE SYSTEM  
6010 AMARILLO BLVD. WEST  
AMARILLO, TEXAS 79106

### ARCHITECT

SBBL ARCHITECTURE AND PLANNING  
1001 N. ALVERNON WAY, STE 105  
TUCSON, ARIZONA 85711-1019  
520.620.0255

### MECHANICAL/PLUMBING ENGINEER

TELIOS  
12946 DAIRY QASHFORD #130  
SUGARLAND, TEXAS 77478  
281.265.1636

### ELECTRICAL ENGINEER

TELIOS  
12946 DAIRY QASHFORD #130  
SUGARLAND, TEXAS 77478  
281.265.1636

### INTERIOR DESIGNER

AVIAR COMMERCIAL SPACE PLANNING & DESIGN  
180 E. BROADWAY BLVD.  
TUCSON, ARIZONA 85701  
520.624.3342

### CIVIL ENGINEER

BRODRICK ENGINEERING, LLC  
6859 E. REMBRANDT AVE #124  
MESA, ARIZONA 85212  
480.926.6333

### STRUCTURAL ENGINEER

BRODRICK ENGINEERING, LLC  
6350 N. CAMINO DE LA TIERRA, SUITE 140  
TUCSON, ARIZONA 85741  
520.887.9416

### LANDSCAPE ARCHITECT


 

PINNACLE DESIGN, INC.  
1048 N. 44TH ST., SUITE 200  
PHOENIX, ARIZONA 85008  
602.952.8585

INDEX		
Discipline	Sheet Name	Sheet Number
	COVER	48-GS0.1
GENERAL	SYMBOLS AND ABBREVIATIONS	48-GS0.2
	LIFE SAFETY	48-GS0.3
CIVIL	COVER SHEET	48-GS1.1
	GRADING AND DRAINAGE PLAN	48-GS1.2
	GRADING AND DRAINAGE PLAN	48-GS1.3
	WATER AND SEWAGE PLAN	48-GS1.4
	CIVIL DETAILS	48-GS1.5
	CIVIL DETAILS	48-GS1.6
	CROSS SECTIONS	48-GS1.7
	CROSS SECTIONS	48-GS1.8
STRUCTURAL	STRUCTURAL NOTES	48-SS 1
	STRUCTURAL NOTES	48-SS 2
	TYPICAL DETAILS	48-SS 3
	TYPICAL DETAILS	48-SS 4
	TYPICAL DETAILS	48-SS 5
	FOUNDATION PLAN	48-SS 6
	ROOF FRAMING PLAN	48-SS 7
	FOUNDATION DETAILS	48-SS 8
	FOUNDATION DETAILS	48-SS 9
	FRAMING DETAILS	48-SS 10
	FRAMING DETAILS	48-SS 11
	FRAMING DETAILS	48-SS 12
	FRAMING DETAILS	48-SS 13
LANDSCAPE	LANDSCAPE SYMBOL AND LEGEND	48-LS-1
	PLANTING PLAN	48-LS-2
	IRRIGATION PLAN	48-LS-3
	PLANTING AND IRRIGATION DETAILS	48-LS-4

INDEX		
Discipline	Sheet Name	Sheet Number
ARCHITECTURAL	ARCHITECTURAL DEMOLITION PLAN	48-AS0.1
	ARCHITECTURAL DEMOLITION DEDUCT PLAN	48-AS0.1A
	ARCHITECTURAL DEMOLITION ELEVATIONS	48-AS0.2
	ARCHITECTURAL DEMOLITION PHOTOS	48-AS0.3
	ARCHITECTURAL SITE PLAN	48-AS1.0
	ARCHITECTURAL SITE DEDUCT PLAN	48-AS1.1
	ARCHITECTURAL FLOOR PLAN	48-AS2.1
	ARCHITECTURAL DIMENSION PLAN	48-AS2.2
	ARCHITECTURAL REFLECTED CEILING PLAN	48-AS3.1
	ARCHITECTURAL ROOF PLAN	48-AS4.1
	ARCHITECTURAL BUILDING ELEVATIONS	48-AS5.1
	ARCHITECTURAL BUILDING SECTIONS	48-AS6.1
	ARCHITECTURAL BUILDING SECTIONS	48-AS6.2
	ARCHITECTURAL PLANS & SECTIONS- CANOPY	48-AS6.3
	ARCHITECTURAL PLANS AND SECTIONS- CANOPY	48-AS6.4
	WALL SECTIONS	48-AS7.1
	WALL SECTIONS	48-AS7.2
	WALL SECTIONS AND DETAILS	48-AS7.3
	ARCHITECTURAL DETAILS	48-AS7.5
	ARCHITECTURAL DETAILS	48-AS7.6
	ENLARGED PLANS	48-AS8.0
	ENLARGED PLANS	48-AS8.1
	ARCHITECTURAL INTERIOR ELEVATIONS	48-AS8.2
	ARCHITECTURAL INTERIOR ELEVATIONS	48-AS8.3
	ARCHITECTURAL INTERIOR ELEVATIONS	48-AS8.4
	DOOR/WINDOW SCHEDULE	48-AS9.1
	DOOR/WINDOW TYPES	48-AS9.2
	ARCHITECTURAL WALL TYPES	48-AS9.6
	ARCHITECTURAL WALL TYPES	48-AS9.7
MEDICAL EQUIPMENT	MEDICAL EQUIPMENT PLAN	48-EQS-1
	MEDICAL EQUIPMENT PLAN	48-EQS-2

INDEX		
Discipline	Sheet Name	Sheet Number
	MEDICAL EQUIPMENT MOUNTING HEIGHTS	48-EQS-3
	MEDICAL EQUIPMENT	48-EQS-4.1
	MEDICAL EQUIPMENT	48-EQS-4.2
	MEDICAL EQUIPMENT	48-EQS-4.3
	MEDICAL EQUIPMENT	48-EQS-4.4
	MEDICAL EQUIPMENT	48-EQS-4.5
	MEDICAL EQUIPMENT	48-EQS-4.6
	MEDICAL EQUIPMENT	48-EQS-4.7
	MEDICAL EQUIPMENT	48-EQS-4.8
	MEDICAL EQUIPMENT	48-EQS-4.9
	MEDICAL EQUIPMENT	48-EQS-5.1
	MEDICAL EQUIPMENT	48-EQS-5.2
	MEDICAL EQUIPMENT	48-EQS-5.3
	MEDICAL EQUIPMENT	48-EQS-5.4
	MEDICAL EQUIPMENT	48-EQS-5.5
	MEDICAL EQUIPMENT	48-EQS-5.6
	MEDICAL EQUIPMENT	48-EQS-5.7
	MEDICAL EQUIPMENT	48-EQS-5.8
MECHANICAL	MEP SYMBOLS AND LEGEND	48-MEP1.0
	MEP SITE PLAN	48-MEP1.1
	SITE LIGHTING PLAN	48-MEP1.2
	MECHANICAL FLOOR PLAN AREA "A"	48-MS2.1A
	MECHANICAL FLOOR PLAN AREA "B"	48-MS2.1B
	MECHANICAL ROOF PLAN	48-MS4.1
	MECHANICAL DETAILS	48-MS5.1
	MECHANICAL DETAILS	48-MS5.2
	MECHANICAL SCHEDULES	48-MS6.1
	MECHANICAL PIPING LEVEL 1 FLOOR PLAN	48-MPS2.1
	MEDICAL GAS LEVEL 1 FLOOR PLAN	48-MGS2.1

INDEX		
Discipline	Sheet Name	Sheet Number
PLUMBING	PLUMBING LEVEL 1 UNDER FLOOR PLAN	48-PS2.0
	PLUMBING LEVEL 1 FLOOR PLAN	48-PS2.1
	PLUMBING ROOF LEVEL	48-PS4.1
	PLUMBING SCHEDULE AND DETAILS	48-PS6.1
ELECTRICAL	ELECTRICAL LEVEL 1 FLOOR PLAN	48-ES2.1
	ELECTRICAL LIGHTING LEVEL 1 FLOOR PLAN	48-ES3.1
	ELECTRICAL ROOF PLAN	48-ES4.1
	ELECTRICAL RISER AND DETAILS	48-ES5.1
	ELECTRICAL PANEL SCHEDULE	48-ES6.1
	ELECTRICAL PANEL SCHEDULE	48-ES6.2
INTERIORS	FINISH PLAN & SCHEDULE	48-IS-1
	FLOOR PLAN PATTERN	48-IS-2
	FLOOR PLAN DETAILS	48-IS-3
	INTERIOR DESIGN ELEVATIONS	48-IS-4

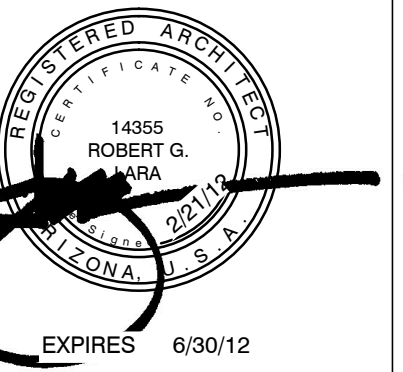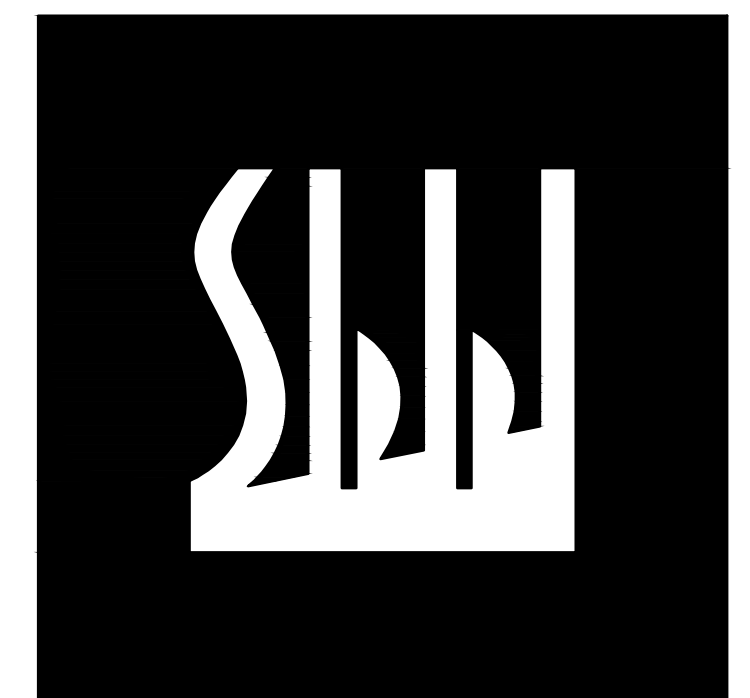

ARCHITECT OF RECORD:

SBBL Architecture + Planning  
1001 North Alvernon Way # 105, Tucson, Arizona 85711  
t: 520.620.0255 f: 520.620.0255 e: sbbl@sbbl.biz



EMERGENCY  
DEPARTMENT

AMARILLO VA HEALTH CARE SYSTEM  
AMARILLO, TEXAS

Approved: VA Area Proj. Mgr.

V.A. PROJECT NO: VA258-P-0196

SBBL PROJECT NO: 0110.00

DRAWN BY: RBT

CHECKED BY: KI

DATE: 07/15/11

△	Date	Revision

Approved: Med. Ctr. Director

Approved: Asst. VA Medical Director

Approved: Chief of Engineering

Approved: Chief of Projects



48-GS0.1

COVER