

E.K. FOX & ASSOCIATES, LTD CONSULTING ENGINEERS
1035 RIDGE TOP ROAD, SUITE 650, FAIRFAX, VIRGINIA 22030
T. 703.273.1112 F. 703.273.2112 EKFOX.COM
© E.K. FOX & ASSOCIATES, LTD ALL RIGHTS RESERVED

Project Name

FORT WAYNE

FINAL SUBMISSION

8 April 2016

Rev. Number	Description	Date
1	REVISED PER SITE COMMENTS	10-11-16

Description

ELECTRICAL ONE-LINE DIAGRAM

Project Number

Drawing Scale	Phase
---------------	-------

0398

CADO Plot Scr

Number

Date: 01/03/2011 09:51:00

Drawn By P|H


Checked By:	
-------------	--

Checked by JTS

Project Number

2401-XXX

E701

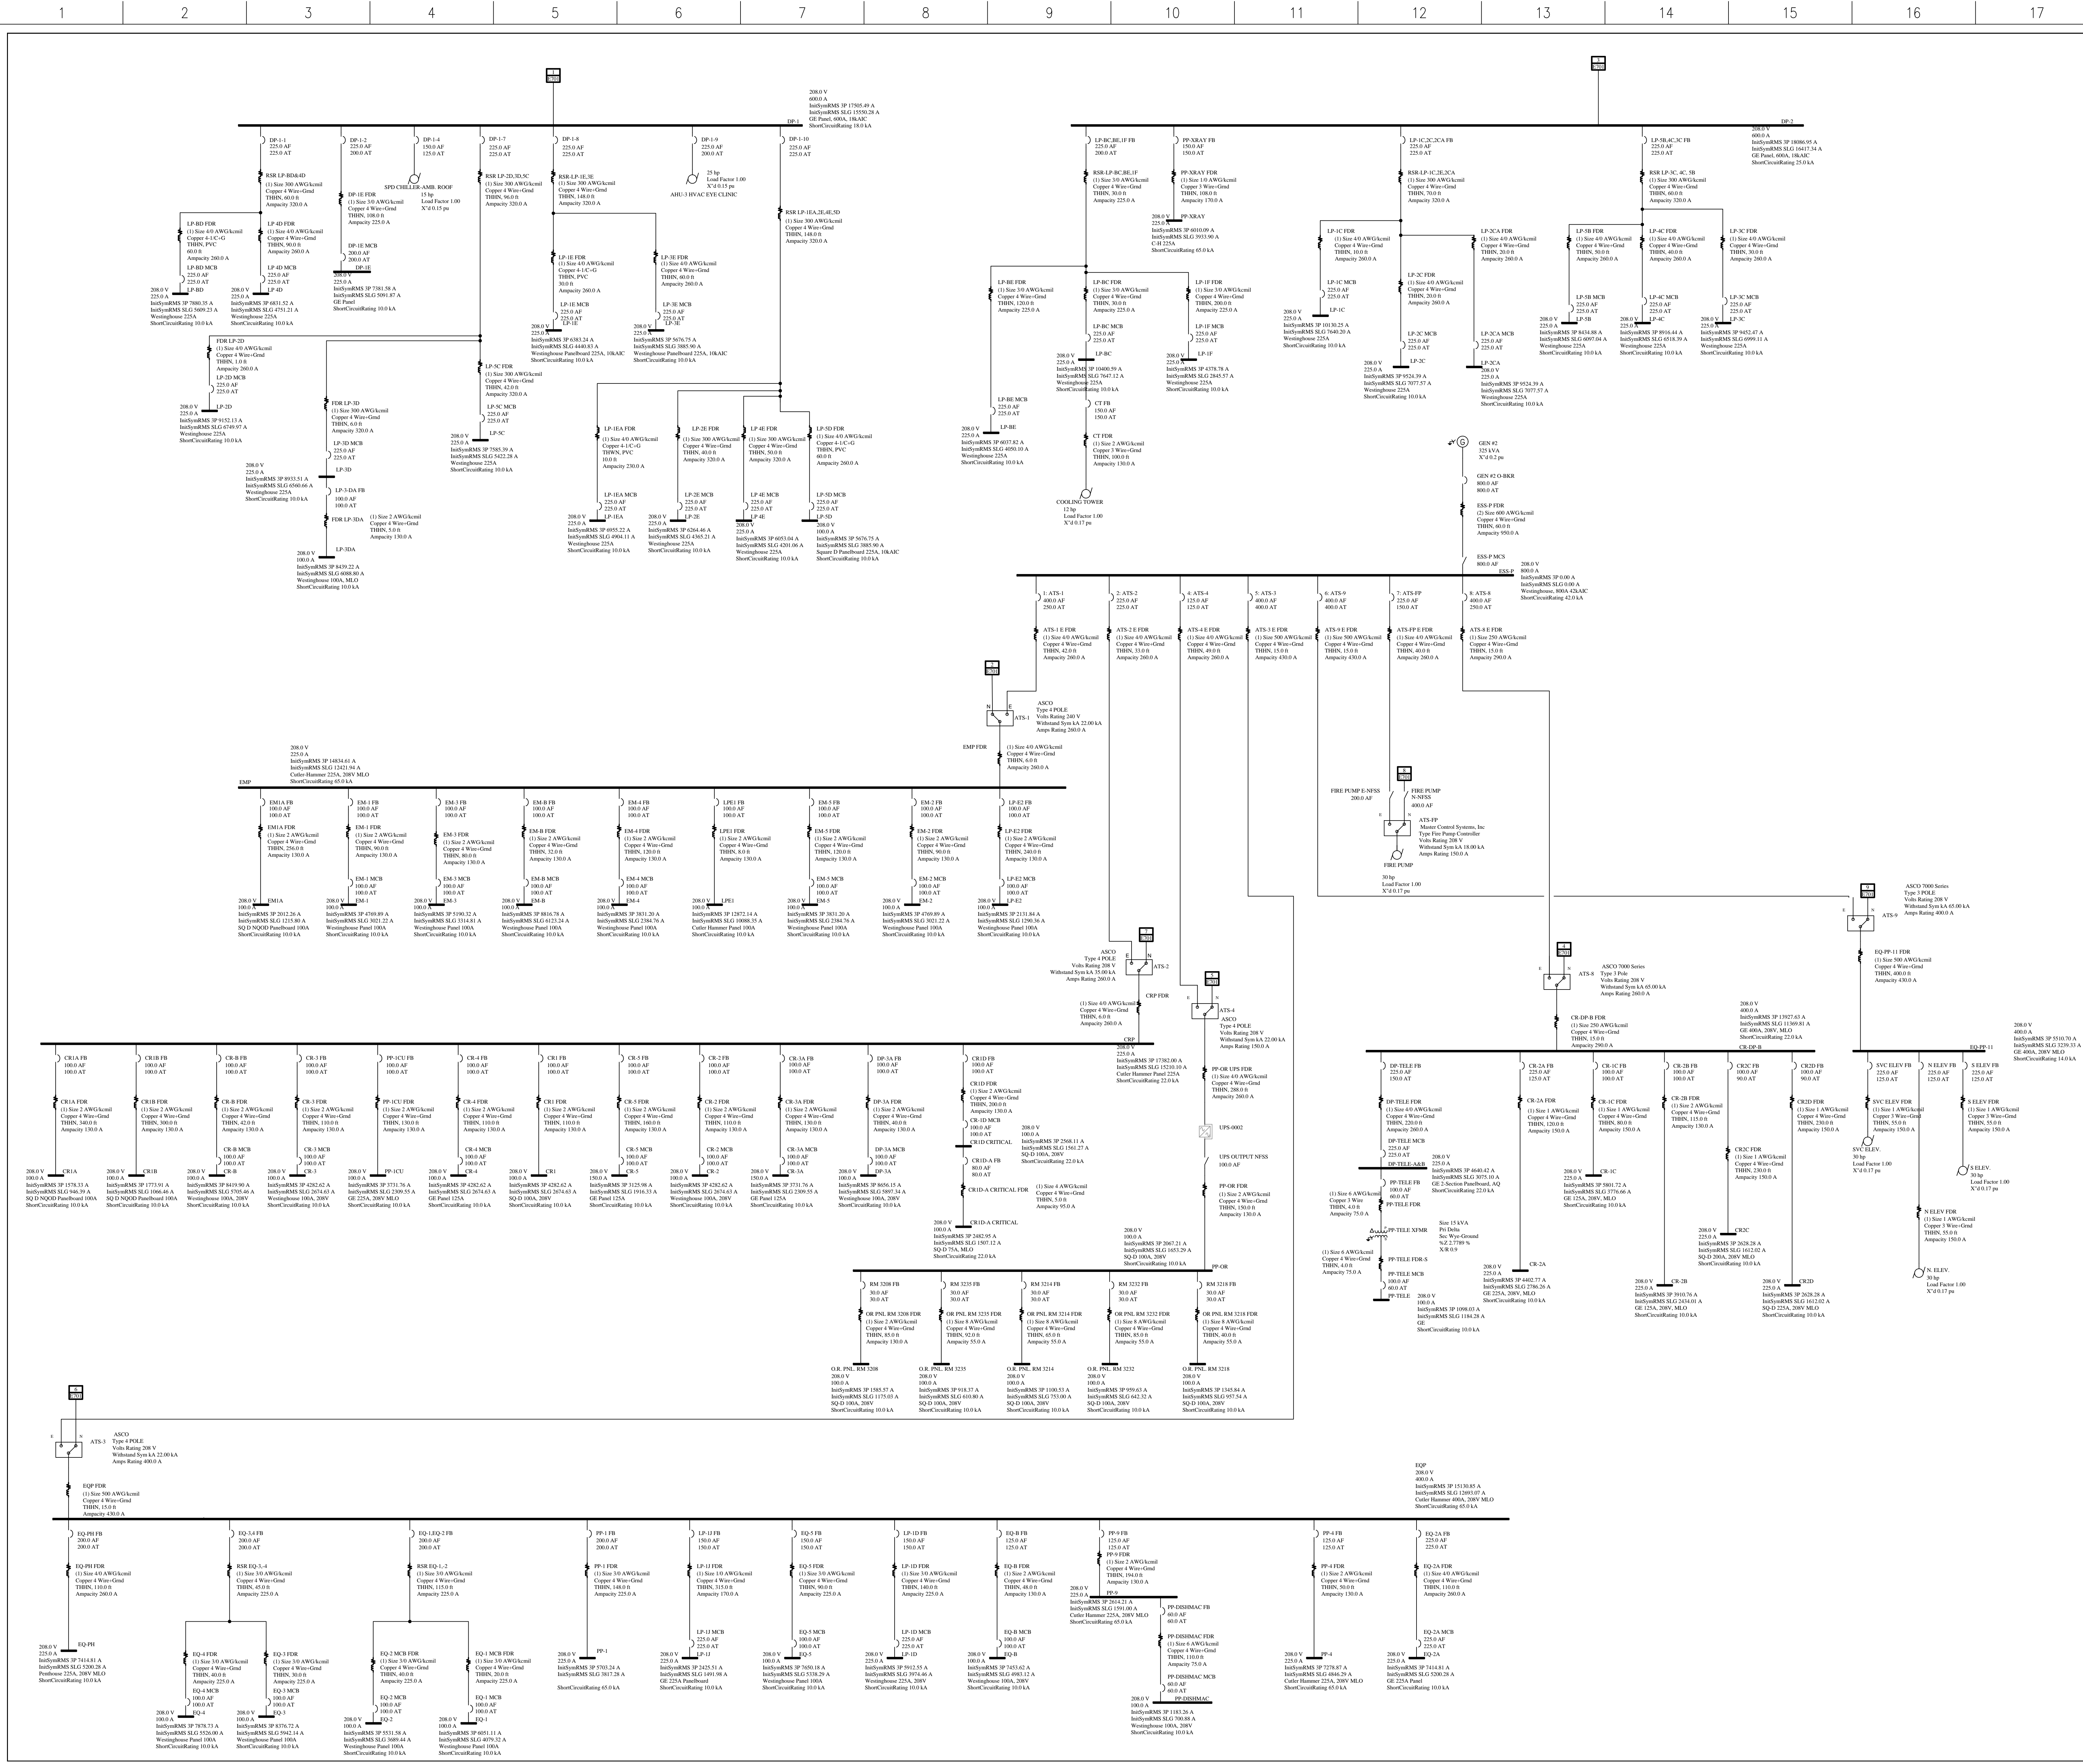

E.K. FOX & ASSOCIATES, LTD. CONSULTING ENGINEERS
4035 RIDGE TOP ROAD, SUITE 650, FAIRFAX, VIRGINIA 22030
T. 703.273.1112 F. 703.273.2112 EKF-FOX.COM
© E.K. FOX & ASSOCIATES, LTD. ALL RIGHTS RESERVED

Project Name

FORT WAYNE

FINAL SUBMISSION

8 April 2016

Rev. Number	Description	Date
1	REVISED PER SITE COMMENTS	10-11-16

Description

ELECTRICAL ONE-LINE DIAGRAM

Project Number	AS SHOWN	Phase
CADD File Name	E702	<input type="checkbox"/> CONCEPT <input type="checkbox"/> RELEASED
Port Number	Date	Sheet Number
	8 April 2016	
Drawn By	PLH	E702
Checked By	JTS	
Project Number	2401-XXX	
Classification		

FORT WAYNE

FINAL SUBMISSION

8 April 2016

Rev Number	Description	Date
1	REVISED PER SITE COMMENTS	10-11-16

Descrip

ELECTRICAL ONE-LINE DIAGRAM

Project Number	Drawing Scale AS SHOWN	Phase
CADD File Name E703	CADD Plot Scale 1:1	<input type="checkbox"/> CONCEPT <input type="checkbox"/> RELEASED
Part Number	Date 8 APRIL 2016	Sheet Number E703
	Drawn By PLH	
	Checked By JTS	
	Project Number 2401-XXX	
	Classification	