
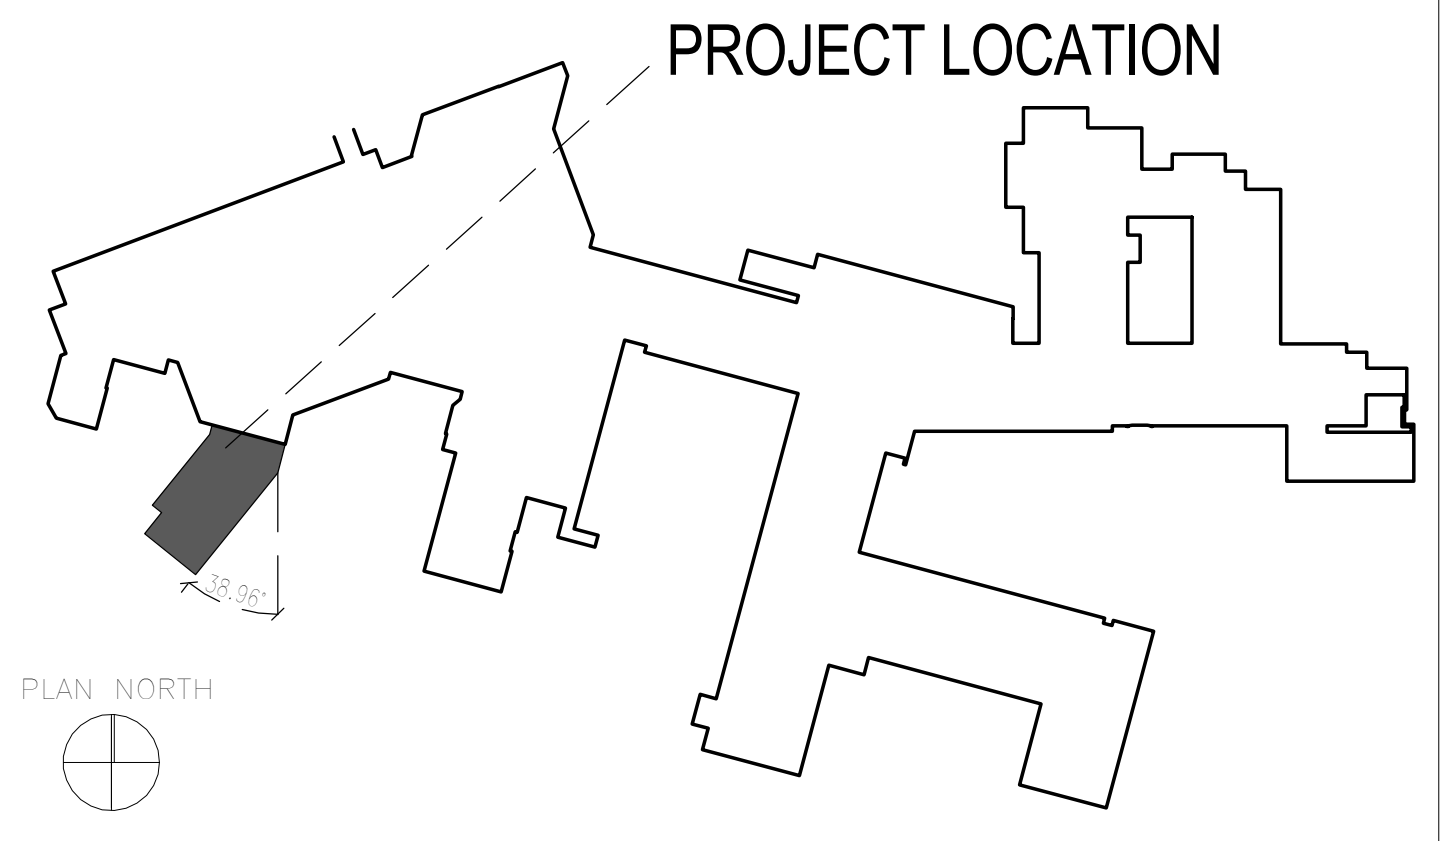



- KEYED NOTES -**
- RE-ROUTE EXISTING CONDUIT MOUNTED TO SIDE OF BUILDING TO ALLOW NEW ACCESS DOOR TO NEW ROOF. CONDUIT SHALL BE ROUTED BELOW THE NEW ROOF ACCESS DOOR. CONDUIT IS A 1-1/2" AND CONSISTS OF (3) #1 (1) #6 WIRES. THE CONDUIT AND FEEDER SERVES BUILDING 6 ELEVATOR. E.C. SHALL NOT INSTALL ANY NEW JUNCTION BOXES. E.C. TO COORDINATE OUTAGES WITH OWNER PRIOR TO COMMENCING THE WORK.
 - EXISTING CONCRETE SLAB TO BE UTILIZED FOR NEW TRANSFORMER AND PANELS.
 - JUNCTION BOX SERVING PUMP P-118 IN THIS LOCATION, TO BE REMOVED. E.C. TO PROVIDE NEW CONDUIT AND FEEDER FROM MCC/LP2 TO PUMP P-118. FEEDER SHALL BE (3) #12; (1) #12 GROUND. IN A 3/4" CONDUIT. REMOVE SPARE CIRCUIT ALSO WITHIN THIS JUNCTION BOX, BACK TO SOURCE.
 - APPROXIMATE LOCATION OF P-118.
 - FACE OF PANEL SHALL BE MOUNTED FLUSH WITH SIDE OF EXISTING CONCRETE SLAB.
 - PROVIDE UNISTRUT FROM STRUCTURE ABOVE TO FLOOR FOR NEW PANEL INSTALLATION.
 - EXISTING TCP IS LOCATED WHERE NEW DOOR IS TO BE INSTALLED. CAPTURE AND EXTEND EXISTING CIRCUIT SERVING TCP TO NEW TCP LOCATION AS NOTED ON THE DRAWINGS.
 - NURSE CALL RISER LOCATION TO PENTHOUSE THROUGH ABANDONED DUMBWATER SHAFT.
 - UTILIZE THE SPACE OUTLINED TO RISE FROM THIS LEVEL TO GROUND FLOOR FOR ROUTING OF NURSE CALL BACKBONE.

1 PARTIAL SECOND FLOOR PLAN
E102 1/16" = 1'-0"

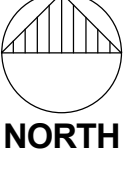

KEY PLAN

100% Construction Documents

CONSULTANTS:			ARCHITECT/ENGINEERS:			Drawing Title PARTIAL SECOND FLOOR PLAN			Project Title CONSTRUCTION MRI SUITE			Project Number 607-CSI-104			Office of Construction and Facilities Management					
<u>BWBR Architects, Inc.</u> 1241 John Q. Hammons Drive Suite 503 Madison, WI 53717			<u>GRAEF</u> 5126 W. Terrace Drive Suite 111 Madison, WI 53718			<u>The Concord Group</u> 55 E. Monroe Street Suite 2850 Chicago, IL 60603			 Nagel Architects Project Number: 151102			Building Number BLDG 1, New Addition								
<u>Ring & DuChateau, LLP</u> 17400 W. Capitol Drive Brookfield, WI 53045			<u>Environmental Management Consulting, Inc.</u> W7748 County Highway V Lake Mills, WI 53551									Location William S. Middleton VA Hospital, Madison, WI			Drawing Number E102 Dwg. XX of XX					
VA69D-16-B-1310-A00002 Revisions:									Approved: Project Director - - -			Date 09/26/2016			Checked TKO			Drawn MEG		
10/26/2016 Date																				