
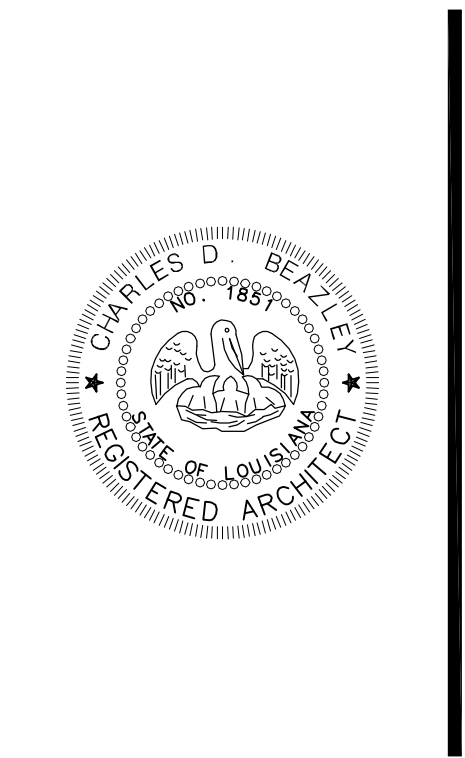


KEYNOTES:

NO	SPEC	NOTE
01.42		REMOVE EXISTING WATER DAMAGED PLASTER AND REPLACE. PLASTER SHALL BE TREATED WITH CHEMICAL WATERPROOFING AGENT.
06.70	055000	1" SQUARE WELDED TUBE BRACE - RE: C5/A211
07.91	079200	SEALANT
09.15A	092900	GYPSUM BOARD (5/8" THICK) MOISTURE RESISTANT - RE: C4/A601

LEGEND

CG	CORNER GUARD - RE:A2/A521
CC	CUBICLE CURTAINS - RE: ROOM FINISH SCHEDULE
EG	END GUARD - RE:A3/A521
HR	HANDRAIL - RE:B1/A521
CR	CHAIR RAIL - RE:B3/A521
BG	BUMPER GUARDS - RE:A1/A521
SN	SIGNAGE - RE: A5/A521
SD	SOAP DISPENSER - RE:A1/A601
PTD	PAPER TOWEL DISPENSER - RE:A1/A601
MH	MAGNETIC HOLD - RE: ELECTRICAL
NOTE: RE:C1/A601 FOR PARTITION TYPES	

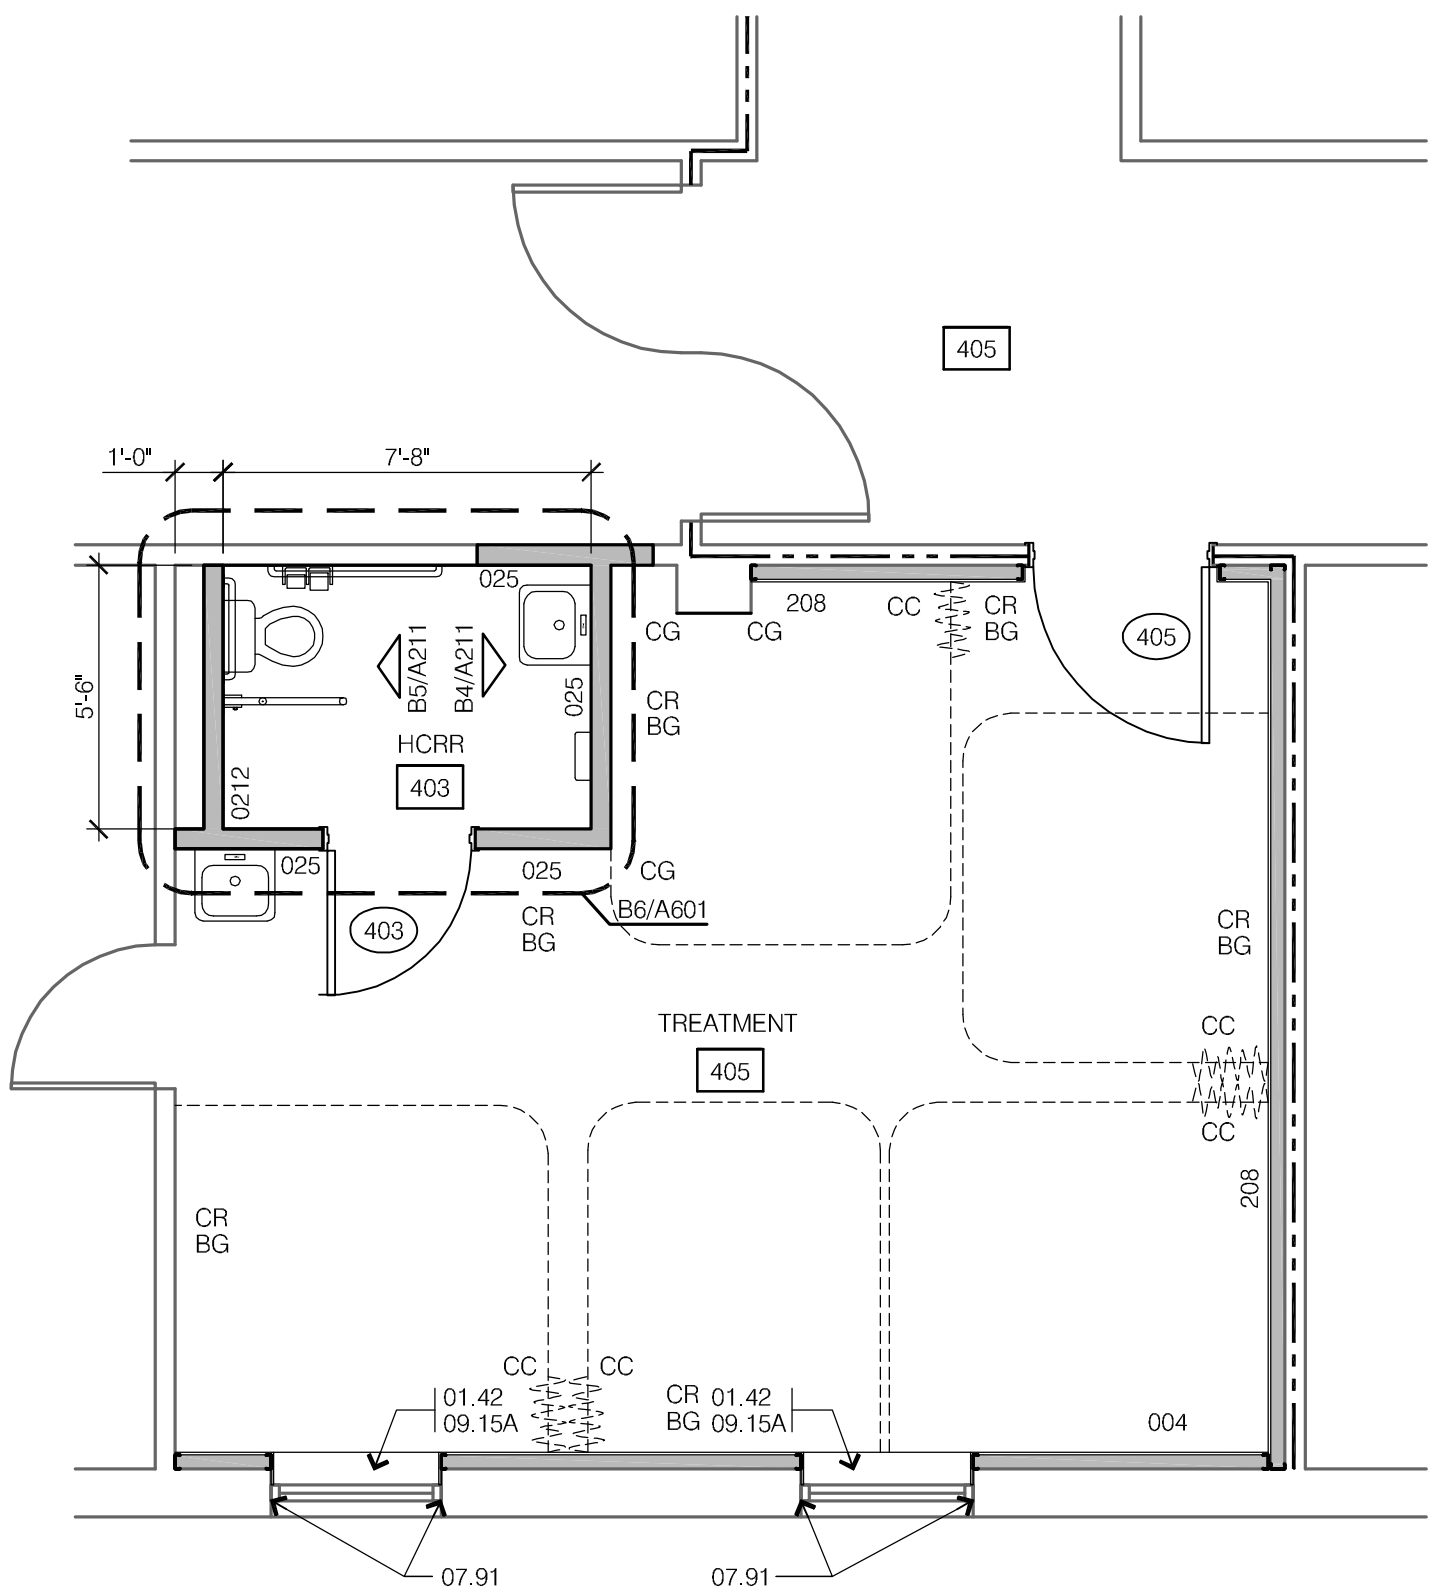

REVISED
3/7/2012

Project Title	RENOVATION FOR ONCOLOGY SERVICES & CHEMOTHERAPY - VA MEDICAL CENTER IN ALEXANDRIA, LOUISIANA
Building Number	7
Location	Alexandria, Louisiana
Drawn	TDH
Erected	CDB

Drawing Title	FLOOR PLANS
Approval Chief of Engineering	T. Lynn Rogers
Approval Service Director	



Date	OCTOBER 17, 2011
Project No.	502-11-122