



three eighths inch = one foot
one eighth inch = one foot
one quarter inch = one foot
one half inch = one foot
one inch = one foot
three quarters inch = one foot
one and one half inches = one foot
two inches = one foot
three inches = one foot

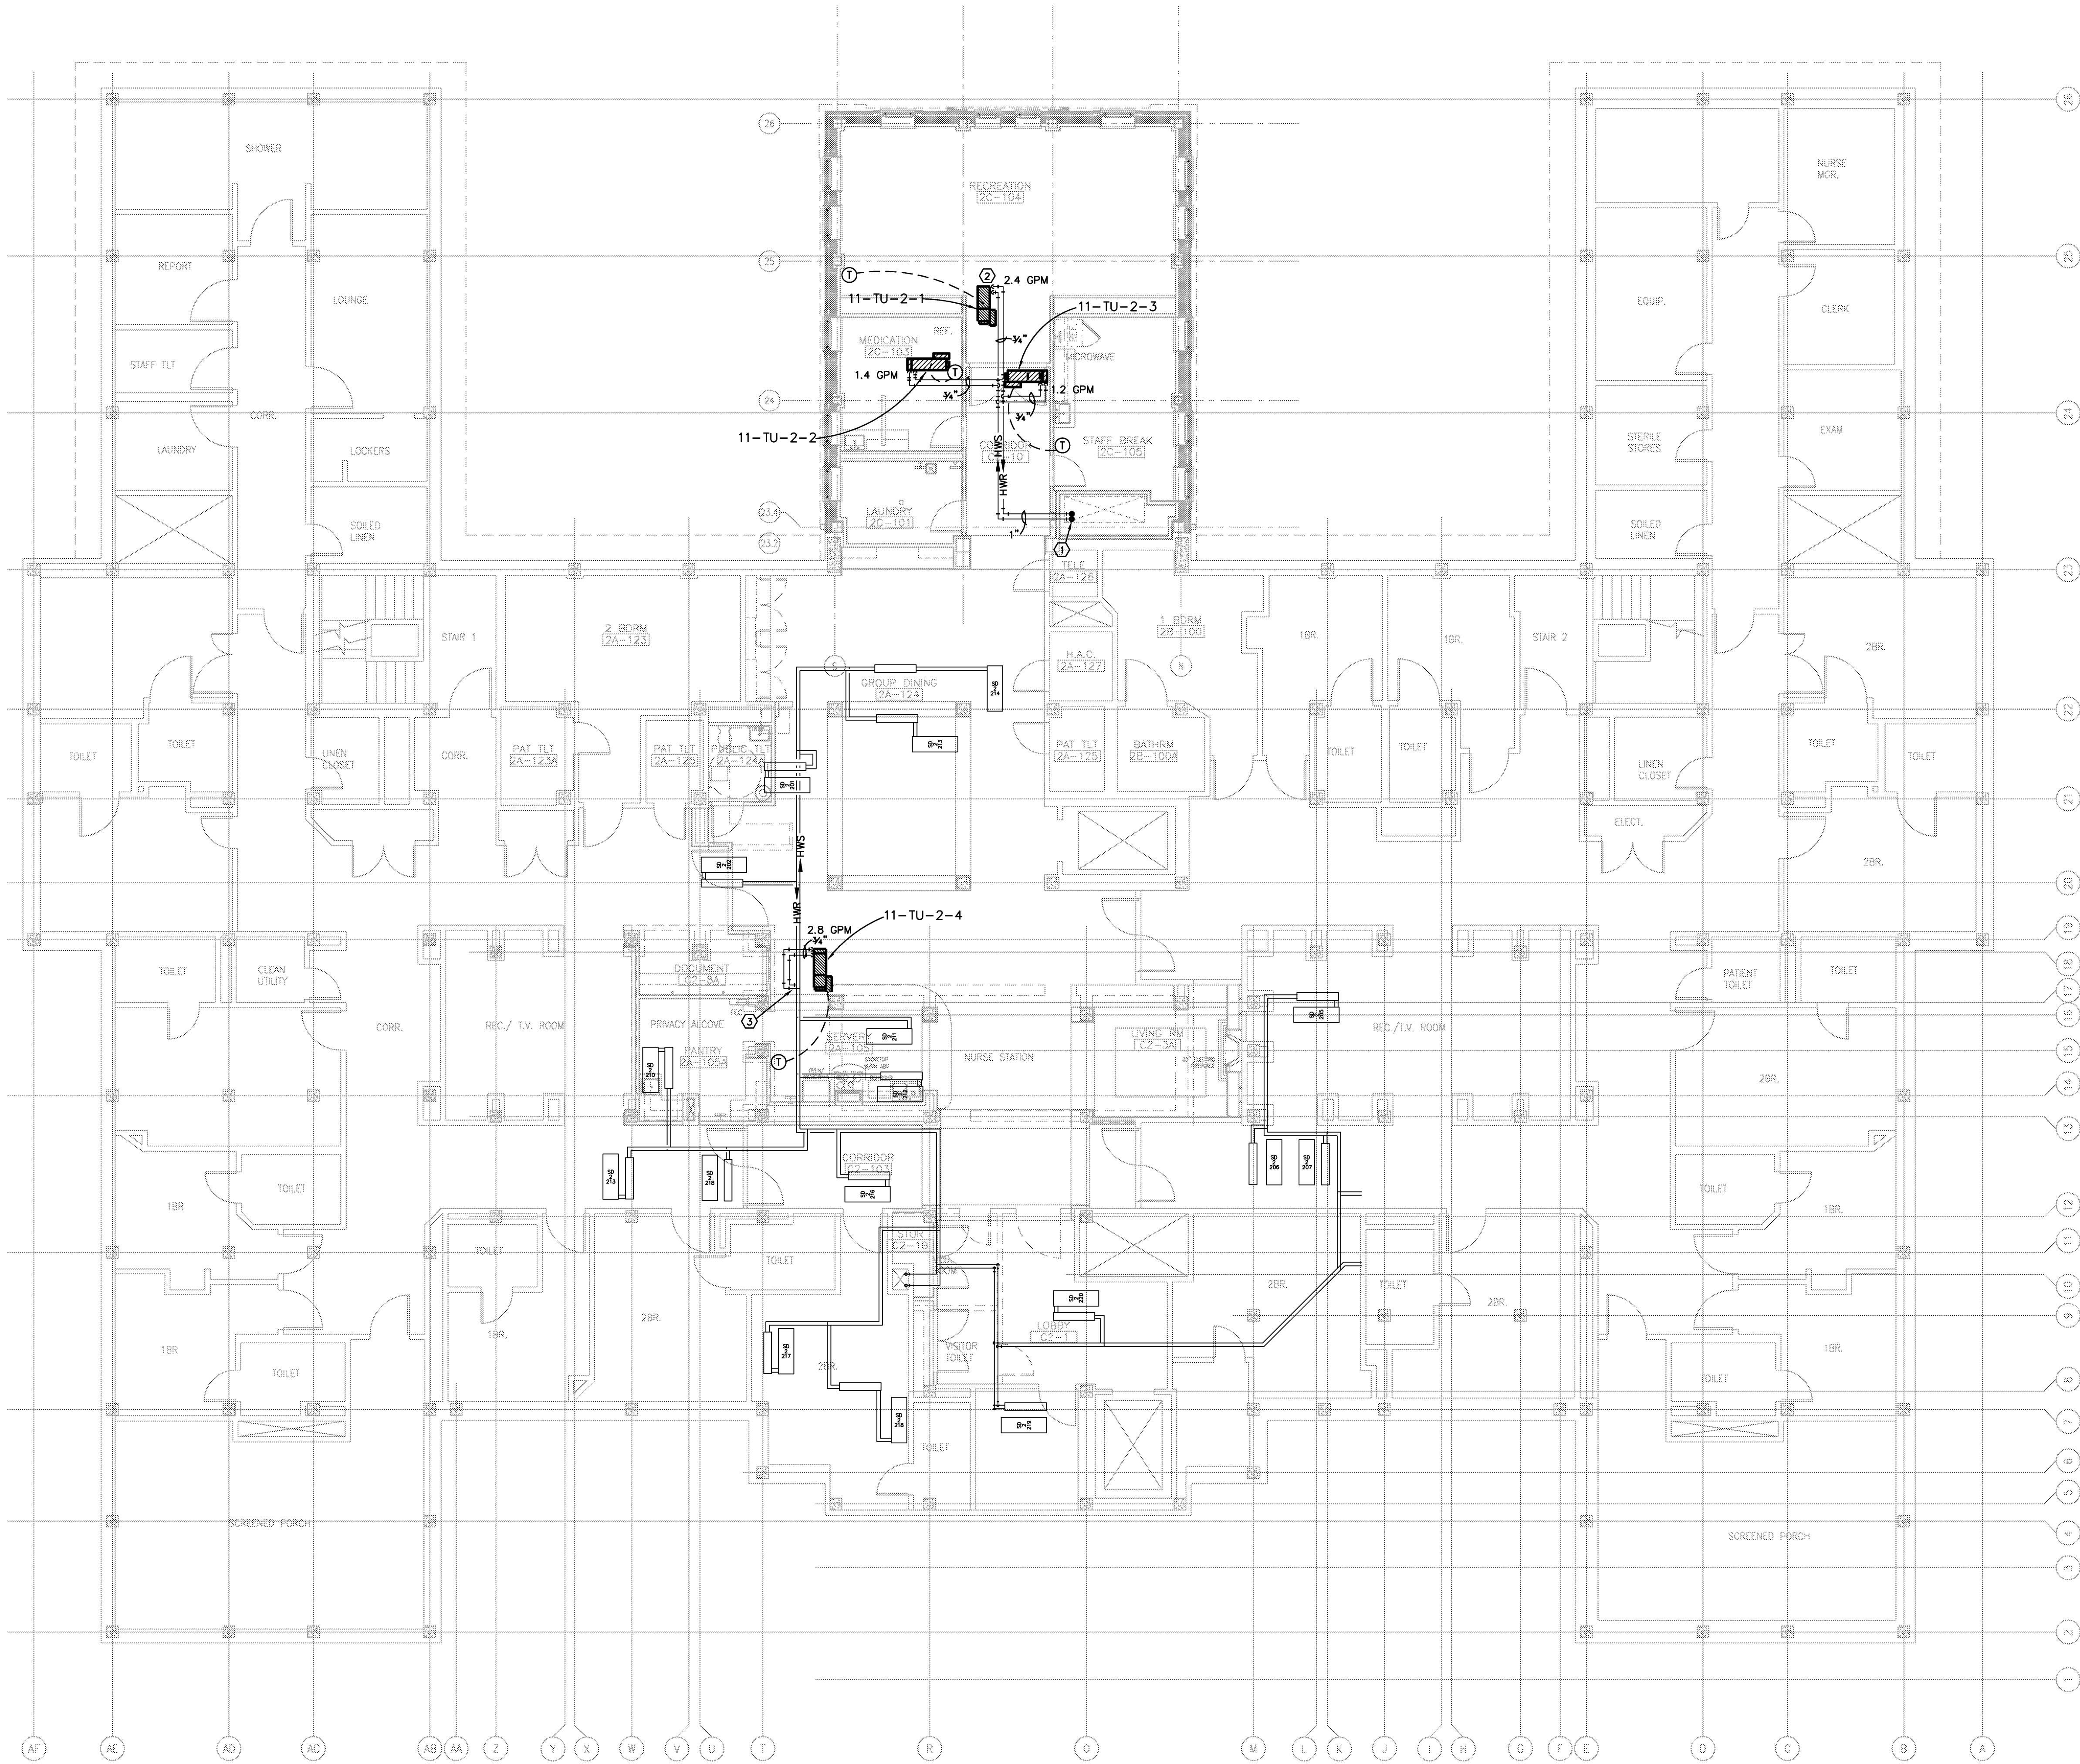

SCHEMATIC DESIGN SUBMISSION	08/02/10
DESIGN DEVELOPMENT SUBMISSION	09/03/10
CONSTRUCTION DOCUMENT SUBMISSION	11/22/10
ISSUE FOR BIDS	12/19/11
Revisions:	Date:

CONSULTANTS:

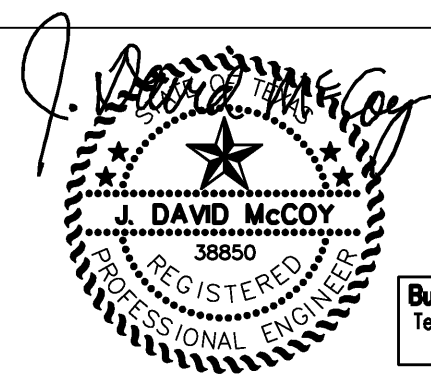

12/16/11
Burns, DeLatté & McCoy, Inc.
Texas Registered Engineering Firm
F-5855

ARCHITECT/ENGINEERS:

WILSON ARCHITECTURAL GROUP
505 WESTHEIMER, SUITE 800 HOUSTON, TEXAS 77058 TELEPHONE (713) 421-4764

MEP ENGINEERS
STRUCTURAL ENGINEERS
FIRE PROTECTION ENGINEERS
CIVIL ENGINEERS

BURNS DeLATTÉ AND MCCOY, INC.
PINNACLE STRUCTURAL
PROTECTION DEVELOPMENT INC.
BREWER AND ESCALANTE

Drawing Title

MECHANICAL LEVEL 2 PIPING PLAN
SCALE: 1/8" = 1' - 0"

Approved Project Director

Project Title

BUILDING 11 ADDITION AND
INTERIOR RENOVATIONS

Location

WACO, TEXAS

Date

19 DEC 2011

Checked

JDM

Drawn

PHJ

Project Number

674A4-CSI-516

Building Number

11

Drawing Number

11
MH108

Dwg. of

Office of
Construction
and Facilities
Management

