


GENERAL NOTES

1. COORDINATE ALL NEW WORK WITH EXISTING CONDITIONS.

KEYED NOTES

- ① THIS CONTRACTOR SHALL EXTEND EXISITNG LIGHTNING PROTECTION SYSTEM TO NEW ROOF.
② PROVIDE CONTROL WIRE AND CONDUIT TO LOCATE SWITCH BY THE HOOD.

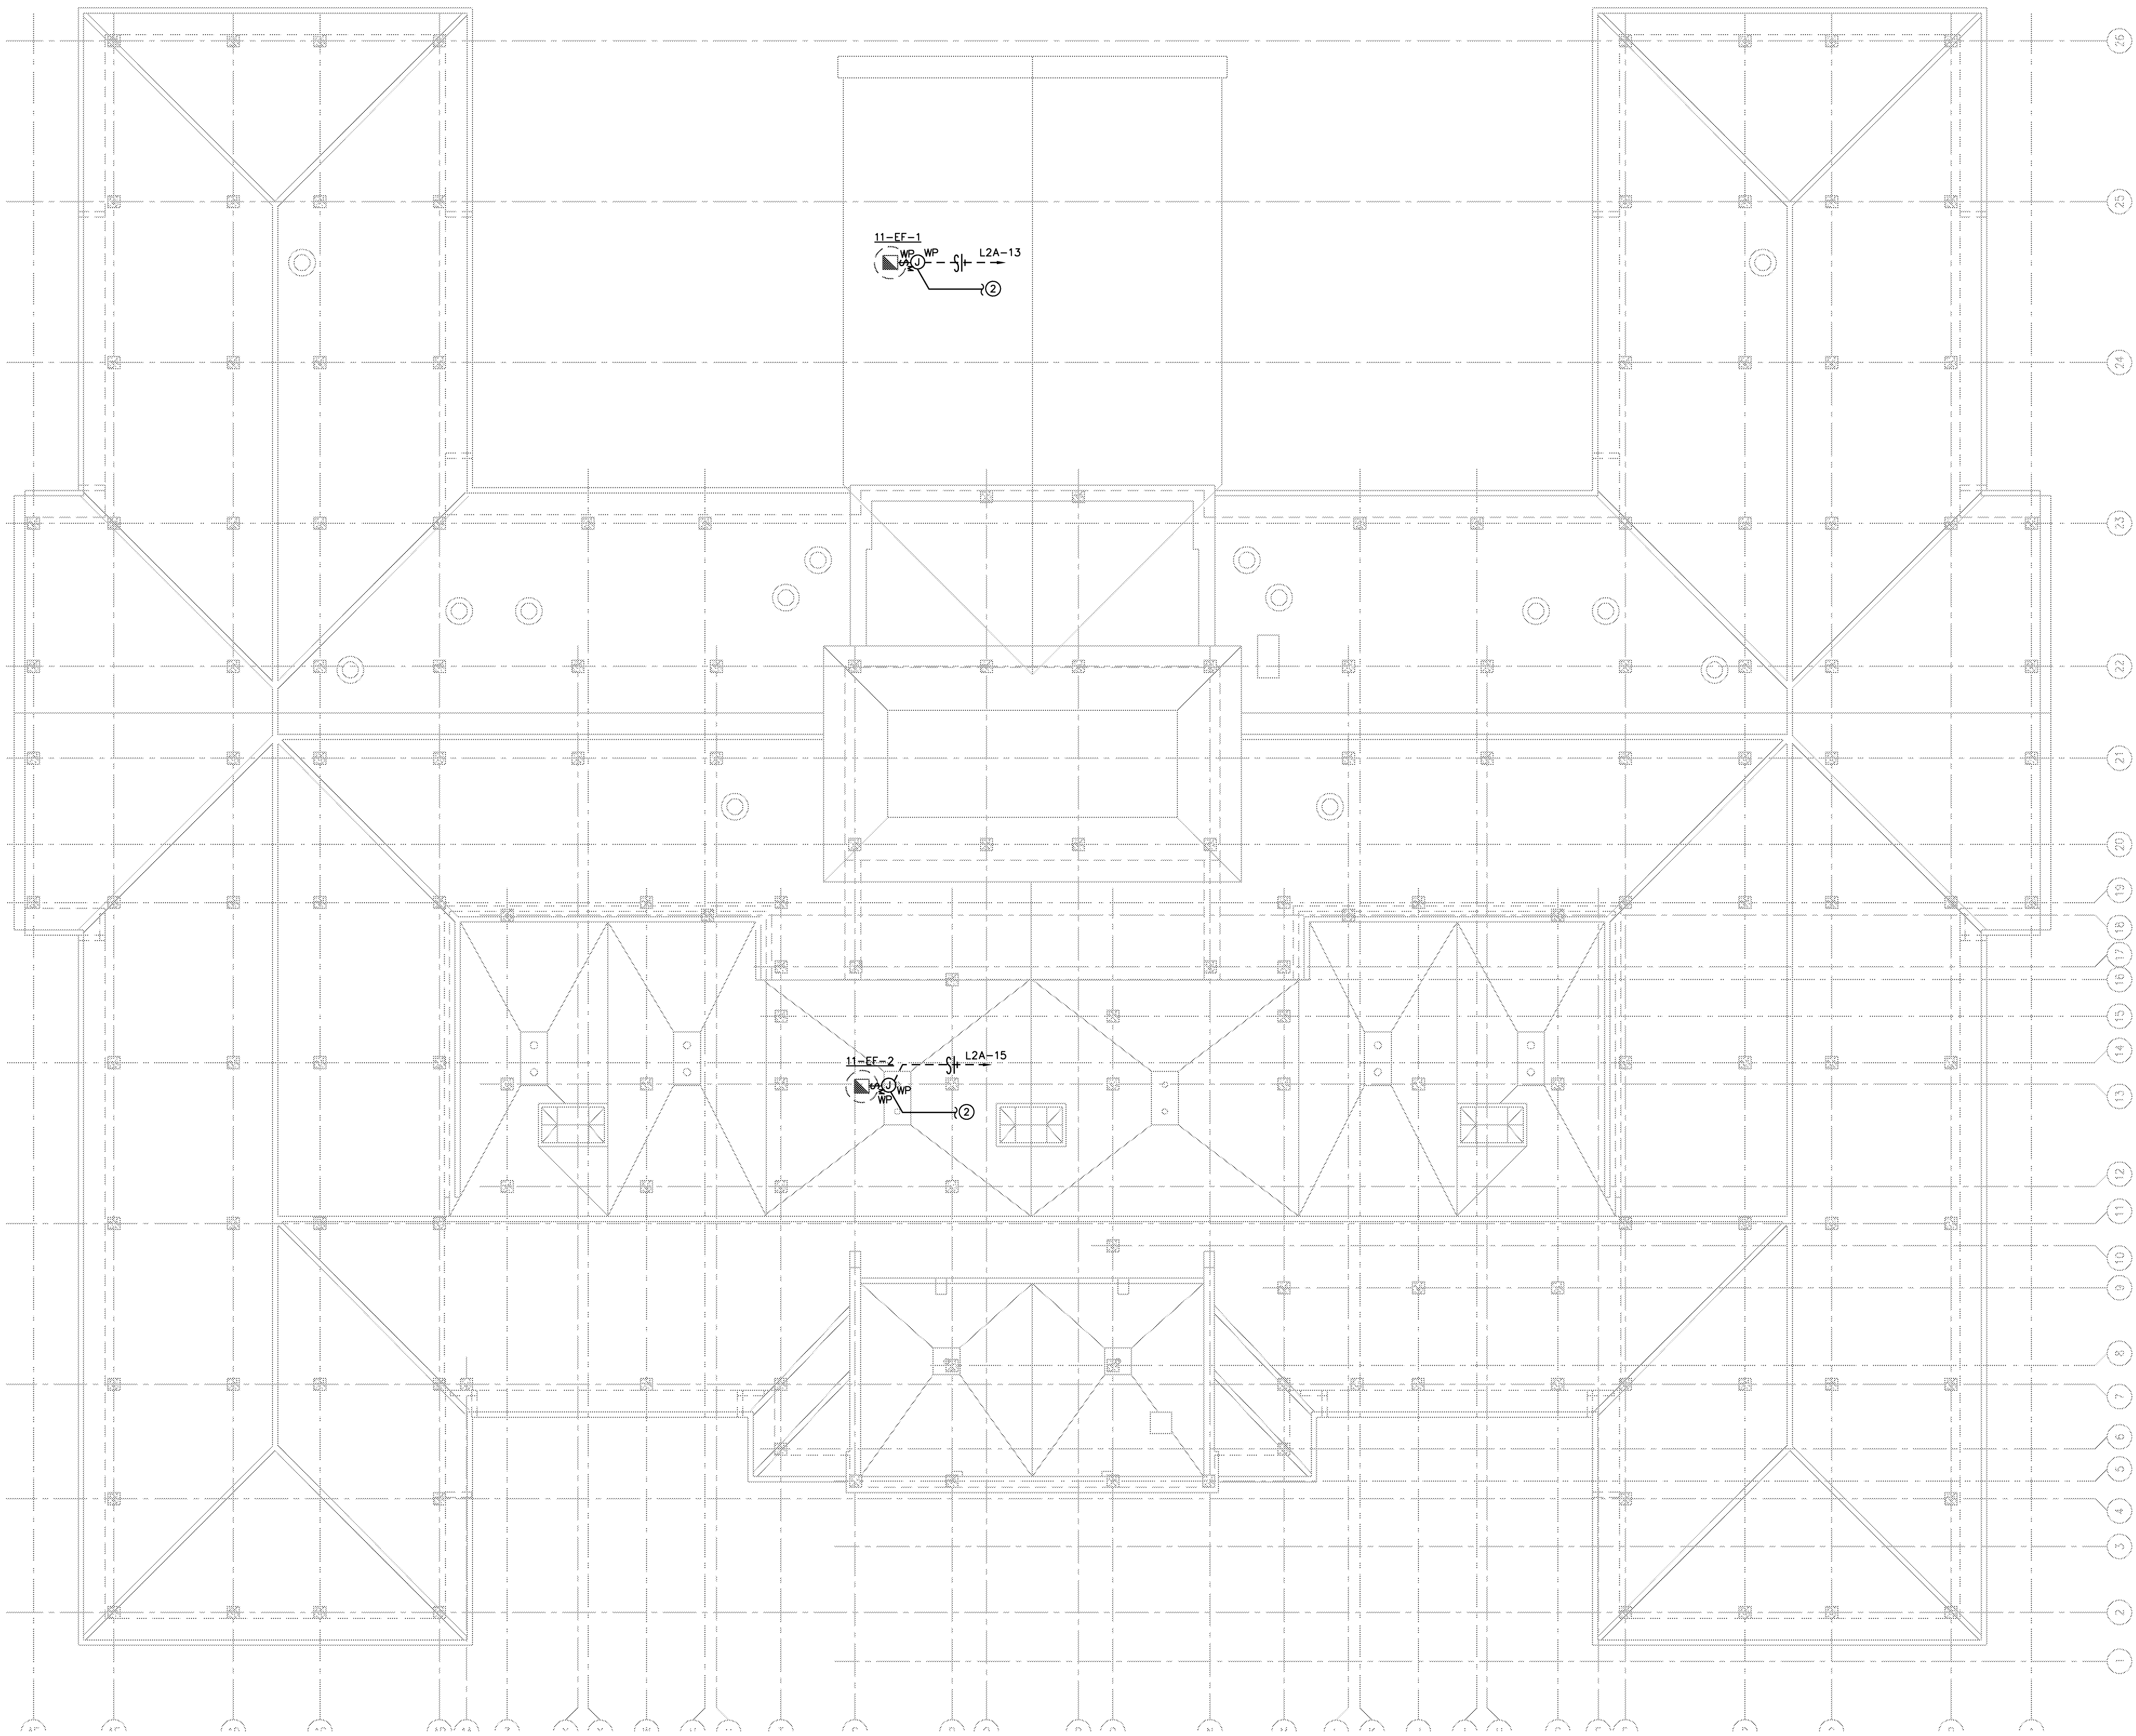

1 ROOF PLAN-POWER

SCALE: 1/8" = 1'-0"

BLD: 11

SCHEMATIC DESIGN SUBMISSION	08/02/10
DESIGN DEVELOPMENT SUBMISSION	09/03/10
CONSTRUCTION DOCUMENT SUBMISSION	11/22/10
ISSUE FOR BIDS	12/19/11
Revisions:	Date

CONSULTANTS:

12-19-11



Burns, DeLatté & McCoy, Inc.
Texas Registered Engineering Firm
F-585

ARCHITECT/ENGINEERS:

WILSON ARCHITECTURAL GROUP

501 WESTHEIMER, SUITE 1800 HOUSTON, TEXAS 77058 TELEPHONE (713) 621-8714

MEP ENGINEERS
STRUCTURAL ENGINEERS
FIRE PROTECTION ENGINEERS
CIVIL ENGINEERS

BURNS DeLATTÉ AND MCCOY, INC.
PINNACLE STRUCTURAL
PROTECTION DEVELOPMENT INC.
BREWER AND ESCALANTE

Drawing Title

ROOF PLAN
ELECTRICAL

SCALE: 1/8" = 1'-0"

Approved: Project Director

Project Title

BUILDING 11 ADDITION AND
INTERIOR RENOVATIONS

Location

WACO, TEXAS

Date

19 DEC 2011

Checked

FP

Drawn

JL

Project Number

674A4-CSI-516

Building Number

11

Drawing Number

11
ES103

Dwg. of

Office of
Construction
and Facilities
Management



Department of
Veterans Affairs