


GENERAL NOTES

1. COORDINATE ALL NEW WORK WITH EXISTING CONDITIONS.

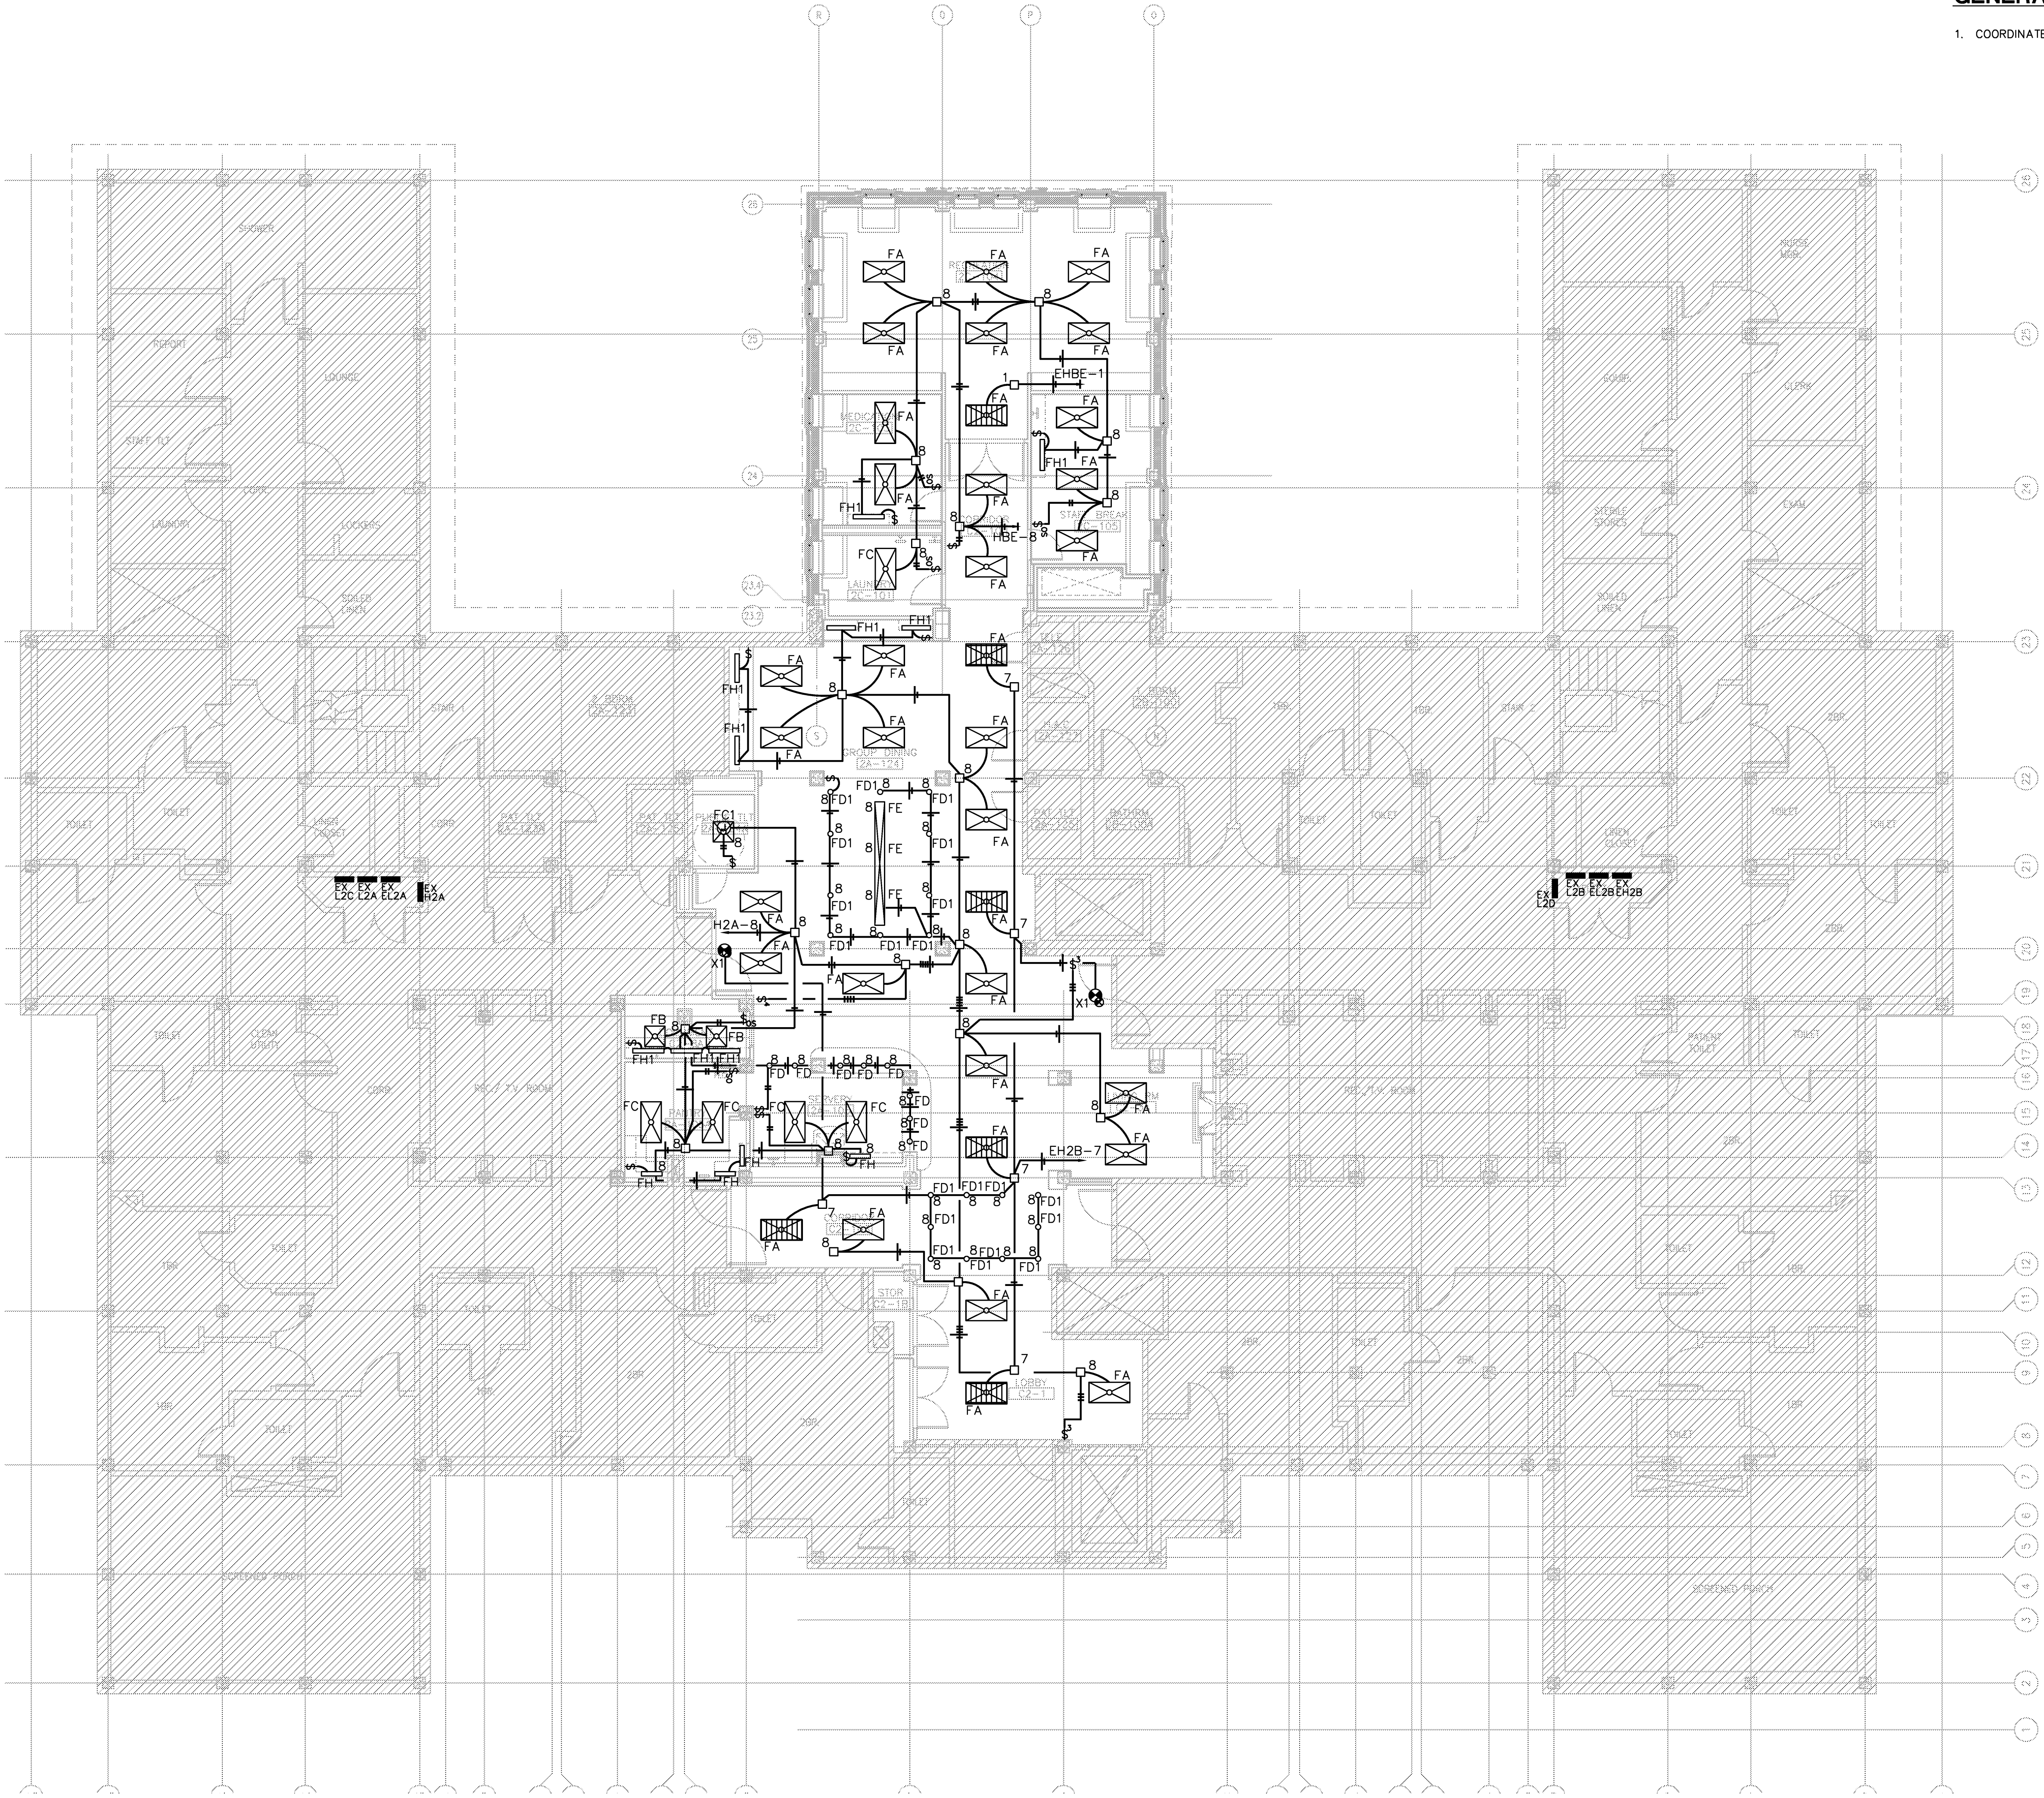

1 SECOND FLOOR PLAN-LIGHTING
SCALE: 1/8" = 1'-0"
BLD: 11

"ISSUED FOR BIDS"- FULLY SPRINKLERED

SCHEMATIC DESIGN SUBMISSION	08/02/10
DESIGN DEVELOPMENT SUBMISSION	09/03/10
CONSTRUCTION DOCUMENT SUBMISSION	11/22/10
ISSUE FOR BIDS	12/19/11
Revisions:	Date

CONSULTANTS:



12-19-11

Burn, DeLotte & McCoy, Inc.
Texas Registered Engineering Firm
E-685

ARCHITECT/ENGINEERS:

WILSON ARCHITECTURAL GROUP

501 WESTHEIMER SUITE 800 HOUSTON, TEXAS 77058 TELEPHONE (713) 621-8774

MEP ENGINEERS
STRUCTURAL ENGINEERS
FIRE PROTECTION ENGINEERS
CIVIL ENGINEERS

BURNS DeLATTE AND McCOY, INC.
PINNACLE STRUCTURAL
PROTECTION DEVELOPMENT INC.
BREWER AND ESCALANTE

Drawing Title
SECOND FLOOR
PLAN- LIGHTING
SCALE: 1/8" = 1'-0"

Approved Project Director

Project Title
BUILDING 11 ADDITION AND
INTERIOR RENOVATIONS

Location
WACO, TEXAS

Date
19 DEC 2011

Checked
FP

Drawn
JL

Project Number
674A4-CSI-516
Building Number
11 -204

Drawing Number
11 204
ES202
Dwg. of

Office of
Construction
and Facilities
Management

