

ISSUE FOR BID	02.10.12
Revisions:	Date

CONSULTANTS:

ARCHITECT/ENGINEERS:



1 312.446.2200
www.baileyedward.com
312 East Wacker Dr
Suite 400
Chicago, IL
60601-7208
©2011 Bailey Edward Design
Design Firm License No. 104-019682

BE # 1115-11-01

Drawing Title
**DEMO ROOF PLAN -
OVERALL - BLDG 134**

Approved Project Director

Project Title
**VAMC Repair / Replace Flat
Roofs - Bldgs. 134, 135, 187
and Tramway**

Project Number
VAM# 556-12-11

Building Number
134

Drawing Number
AD-101

Location
3001 Green Bay Road, North Chicago, IL 60064

Date
02.10.2012




Checked:
MLP

Drawn:
DLW

Dwg. 5 of 23



Office of
Facilities
Management

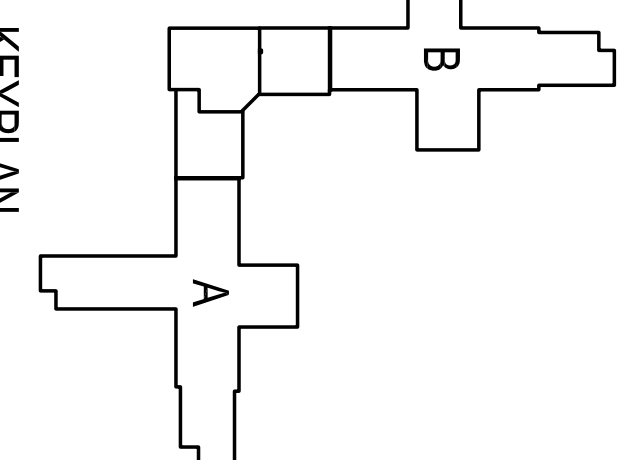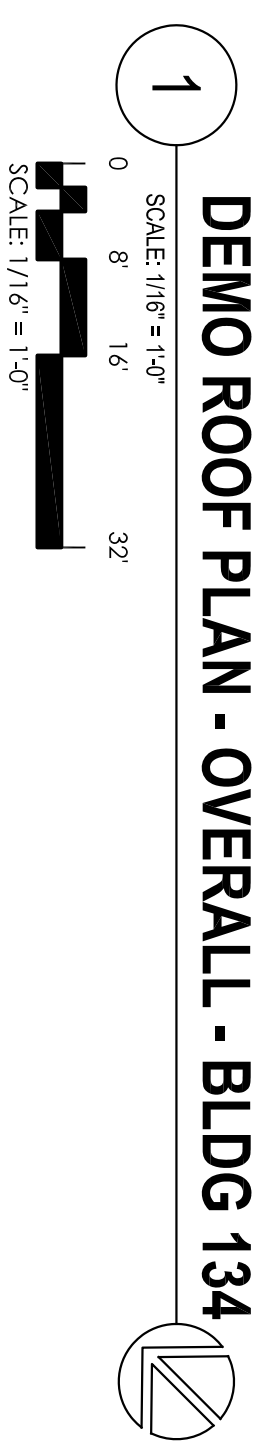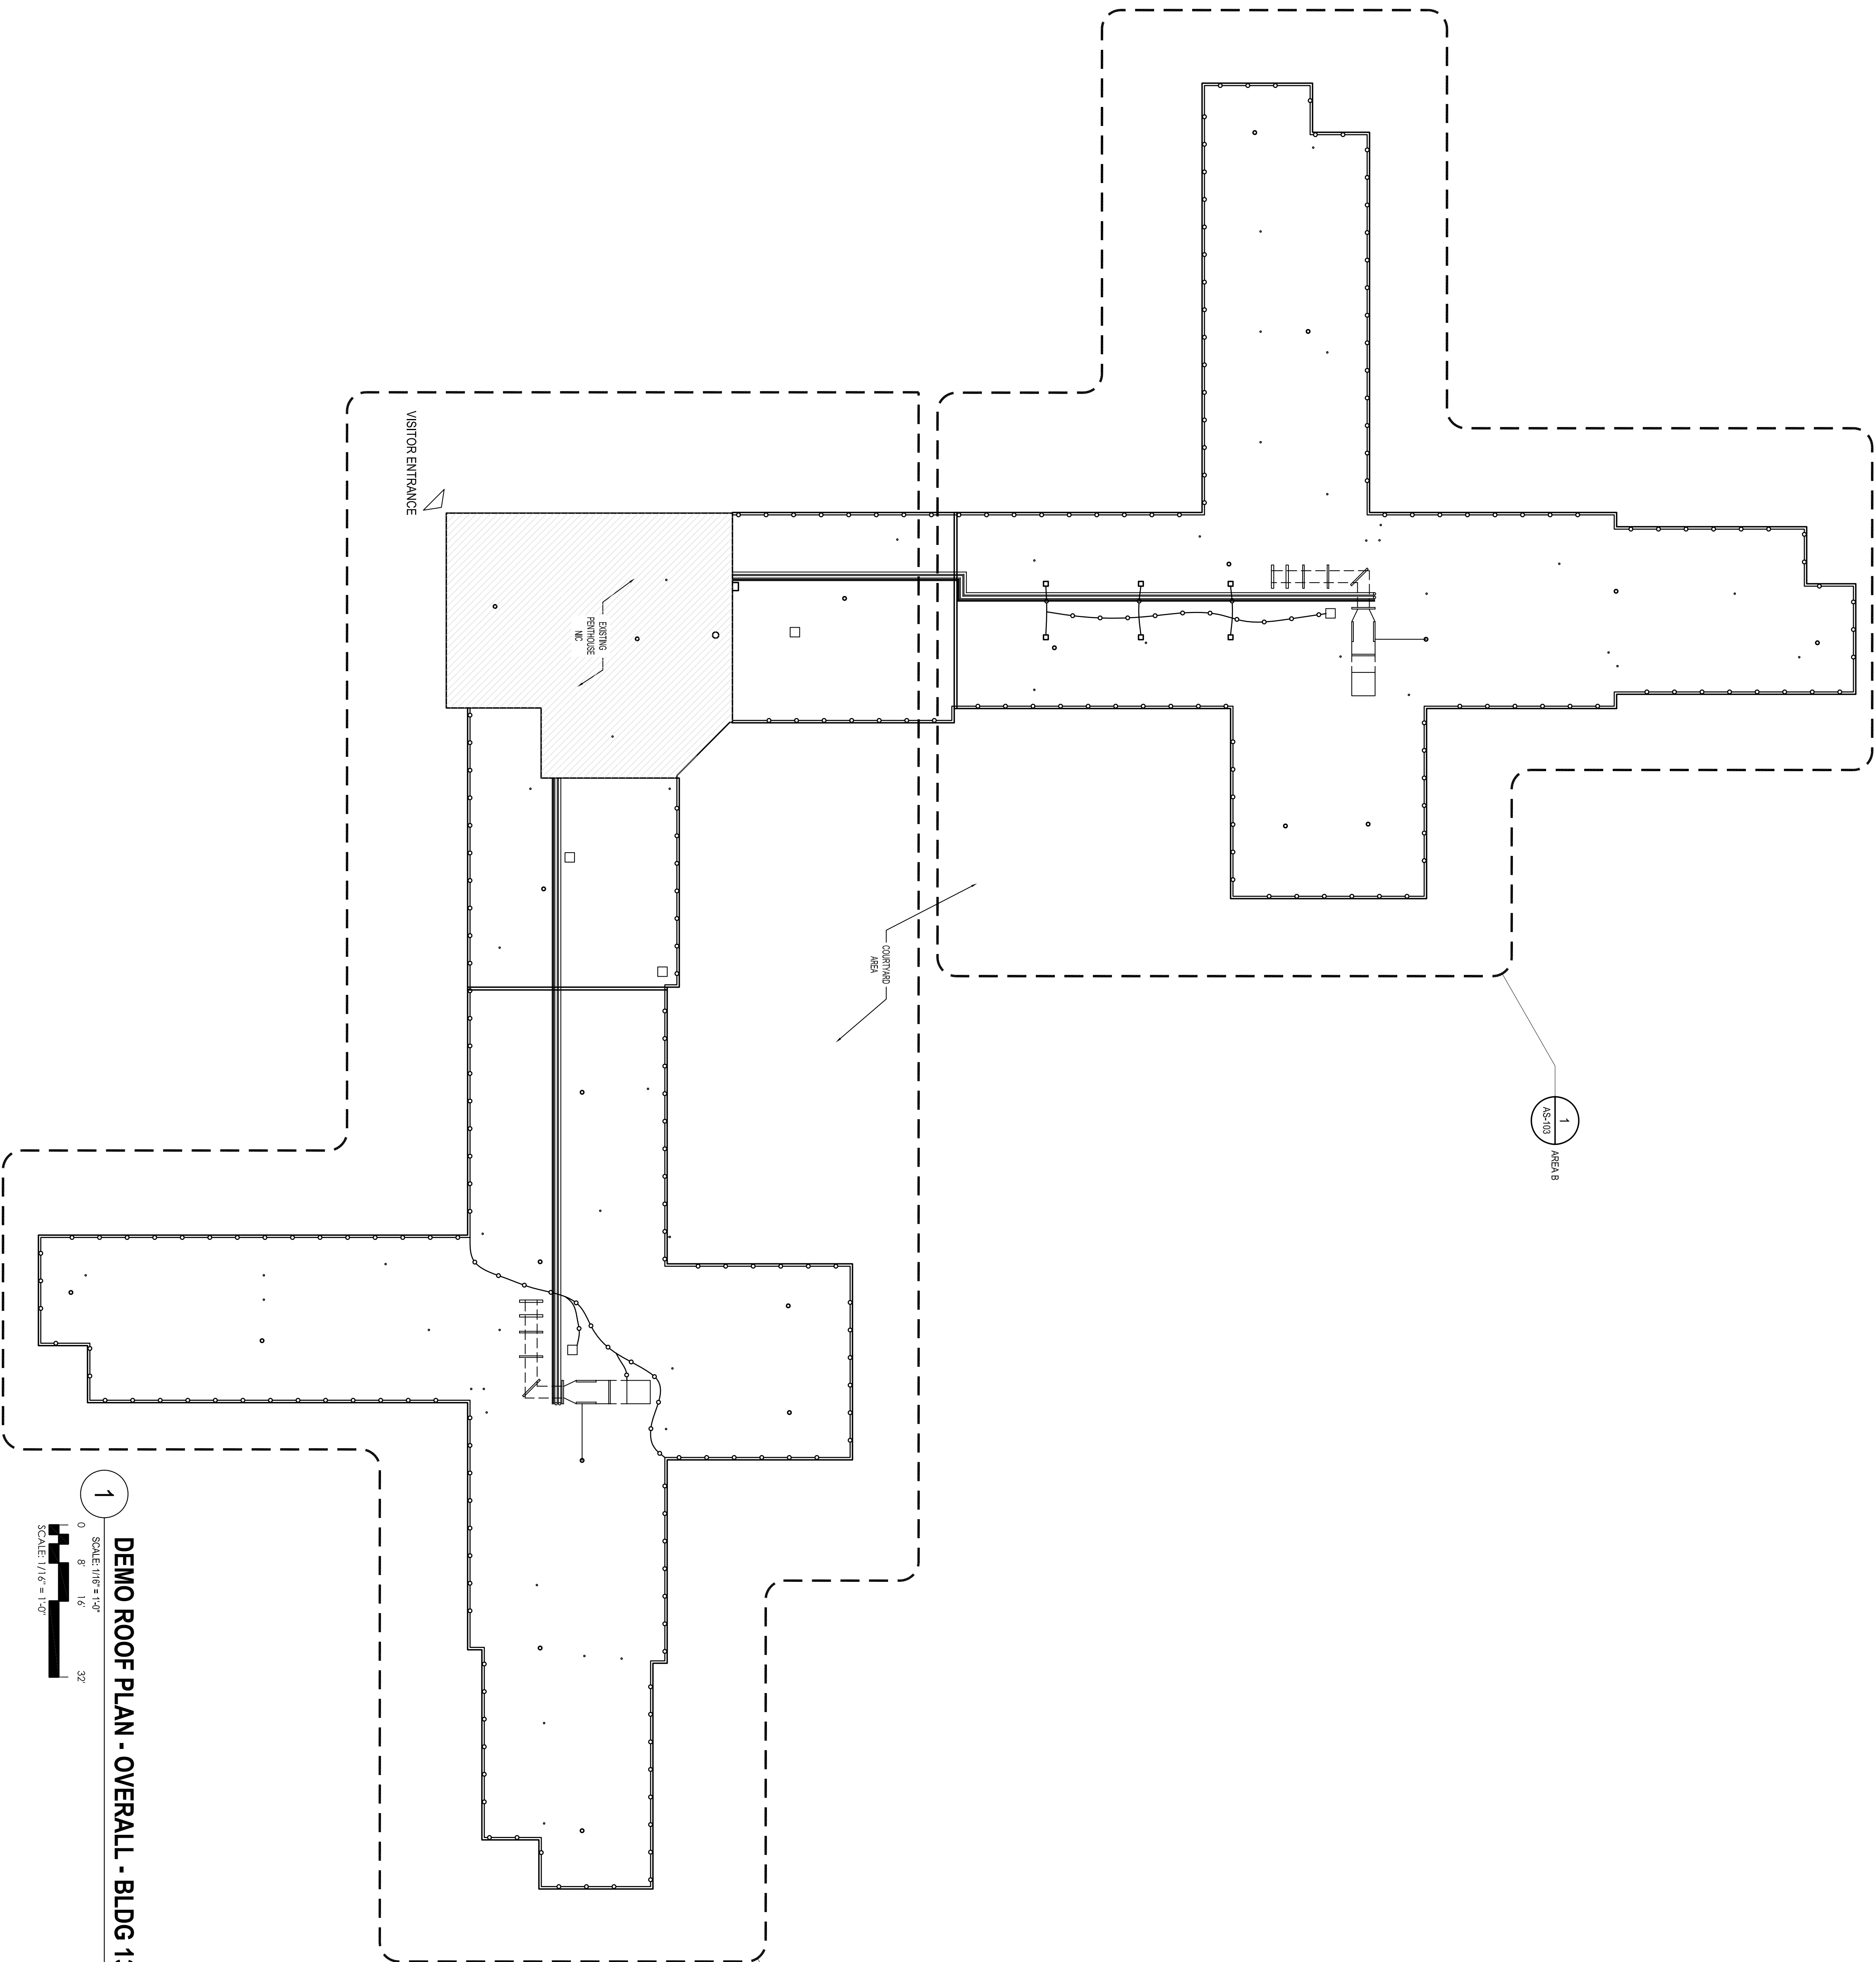

NOTES:
1. KEY PLAN ONLY, SEE REFERENCED DRAWINGS FOR DETAILS.
2. CONTRACTOR TO OBTAIN PERMITS AND NEW WORK ACTIVITIES SCHEDULE WITH OWNER REGARDING WORK NEAR
3. CONTRACTOR TO OBTAIN ACCESS THROUGH LOADING DOCK, VERIFY WITH OWNER.