

ISSUE FOR BID	02.10.12
Revisions:	

CONSULTANTS:

ARCHITECT/ENGINEERS:






bailey edward

1312442300
www.baileyedward.com
35 East Wacker Dr
Chicago, IL
60601-2300
Design Firm License No. 06-007992

BE # 1115-11-01

Drawing Title		Project Title		Project Number		Office of Facilities Management
ROOF PLAN - OVERALL BLDG 135		VAMC Repair / Replace Flat Roofs - Bldgs. 134, 135, 187 and Tramway		VAM 556-12-11		
				Building Number 135		
Approved Project Director		Location		Drawing Number		Department of Veterans Affairs
		3001 Green Bay Road, North Chicago, IL 60064		AS-104		
Date 02.10.2012		Checked: MLP		Drawn: DLW		
				Dwg 17 of 23		

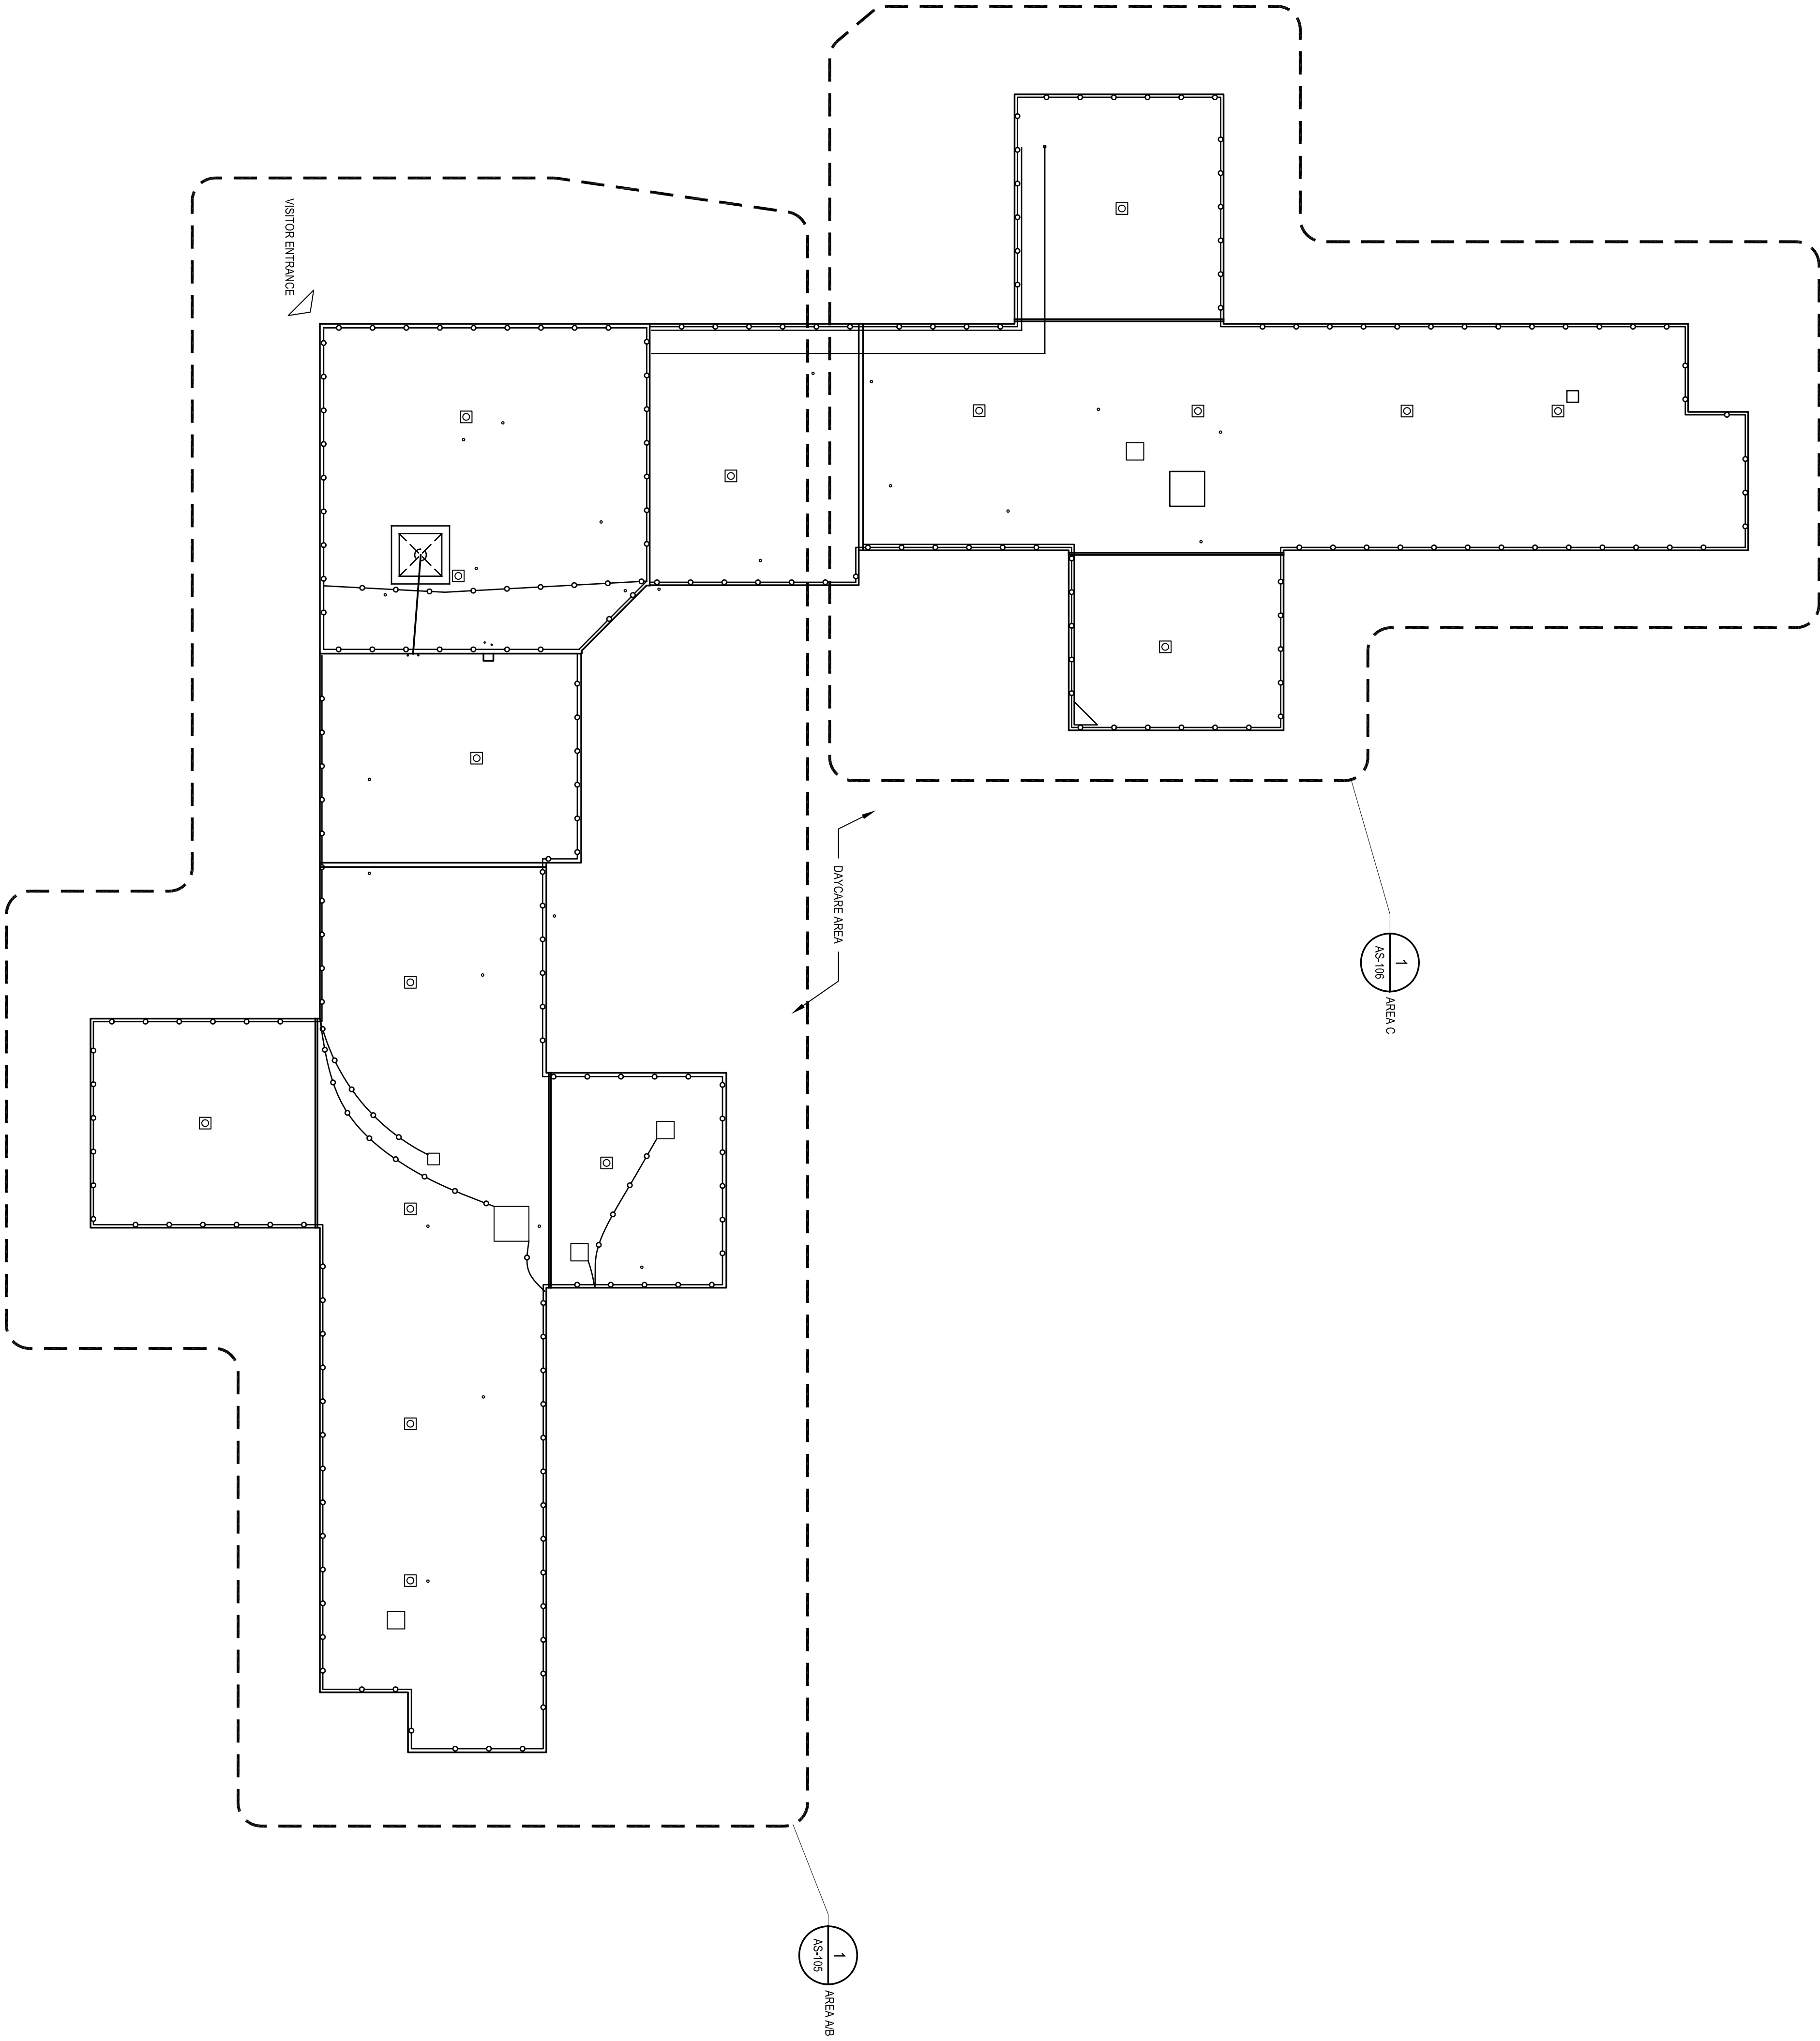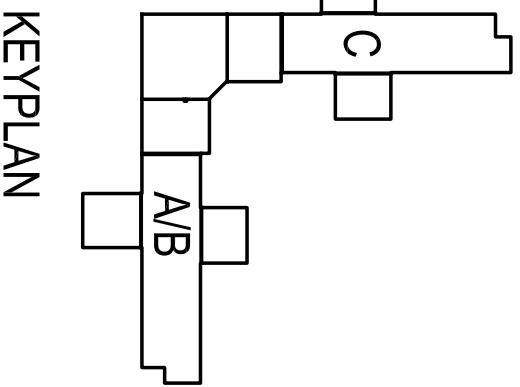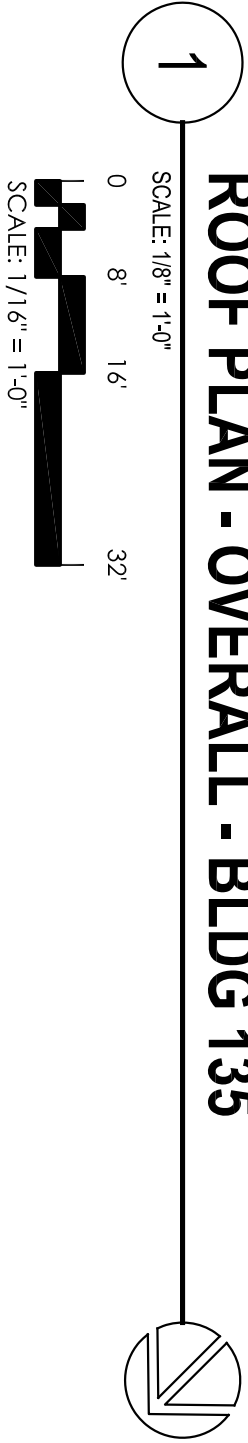

NOTES:
1. KEY PLAN ONLY, SEE REFERENCED DRAWINGS FOR DETAILS.
2. CONTRACTOR TO COORDINATE PIANO AND NEW WORK ACTIVITIES SCHEDULE WITH VAMC PLANNING WORK TEAM.
3. CONTRACTOR TO OBTAIN ACCESS TO THE LOADING DOCK, YARD, AND OWNERS.