



NOTE:
CONTRACTOR TO SURVEY & DOCUMENT EXTENT OF EXISTING MASONRY WORK INDICATED PRIOR TO COMMENCING WITH THE WORK. NOTIFY THE CO-OP & OWNER OF ANY DISCREPANCIES WITH EXISTING CONDITIONS PRIOR TO PROCEEDING.

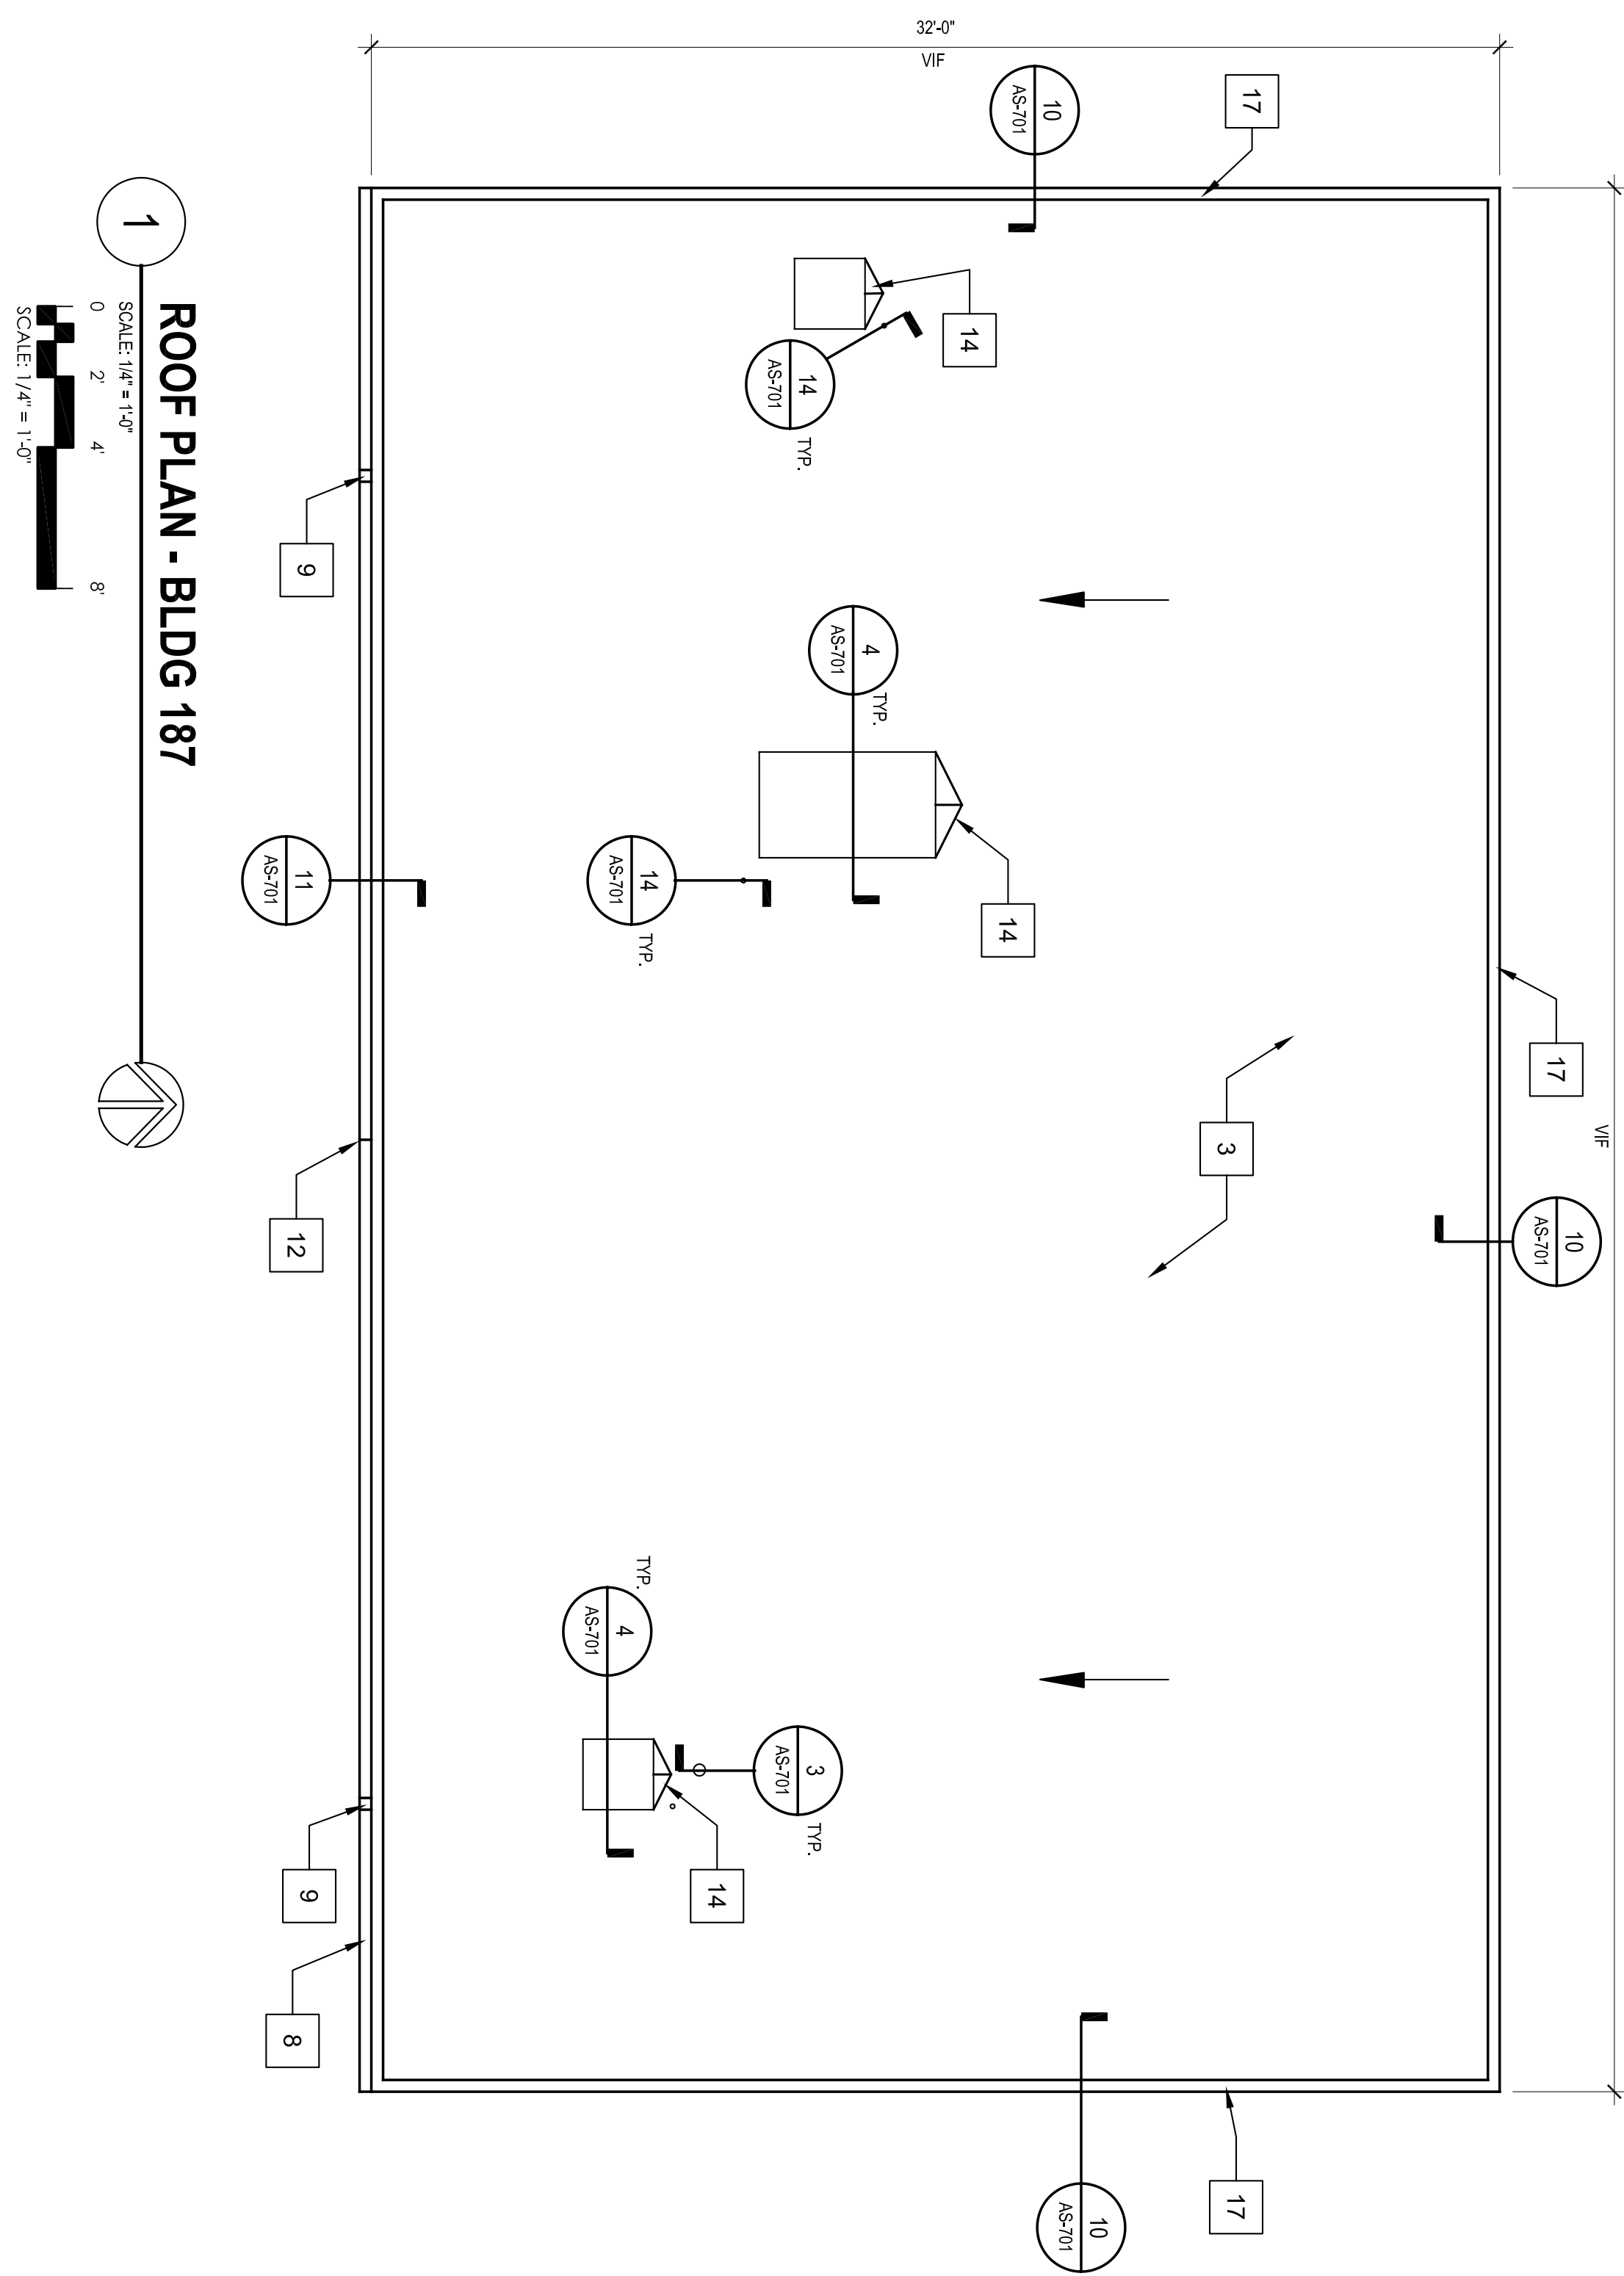

ISSUE FOR BID	02.10.12
Revisions:	Date

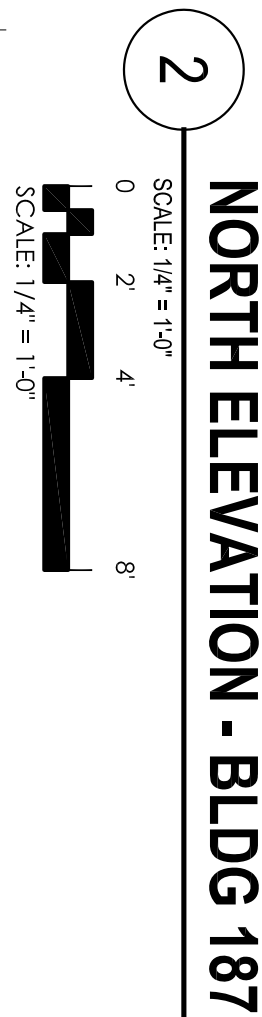

ARCHITECT/ENGINEERS:

1 312 440 2300
F 312 440 2301
www.beylseyd.com

35 East Wacker Dr
Suite 2800
Chicago, IL
60601-4206

boiley edward

©2011 Bailey Edward Design
Design Firm License No. 164-001962

Drawing Title	Project Number			 Department of Waterworks & Utilities	
ROOF PLAN & ELEVATIONS - BLDG 187	V/M/C Repair / Replace Flat Roofs - Bldgs. 134, 135, 187 and Tramway				VAA 556-12-11
					Building Number 187
					Drawing Number AS-107
	Approved Project Director	Location 3001 Green Bay Road, North Chicago, IL 60064	Date 02.10.2012		Checked: MLP
 Department of Waterworks & Utilities					