




2 SOUTH ELEVATION
1/8" = 1'-0"

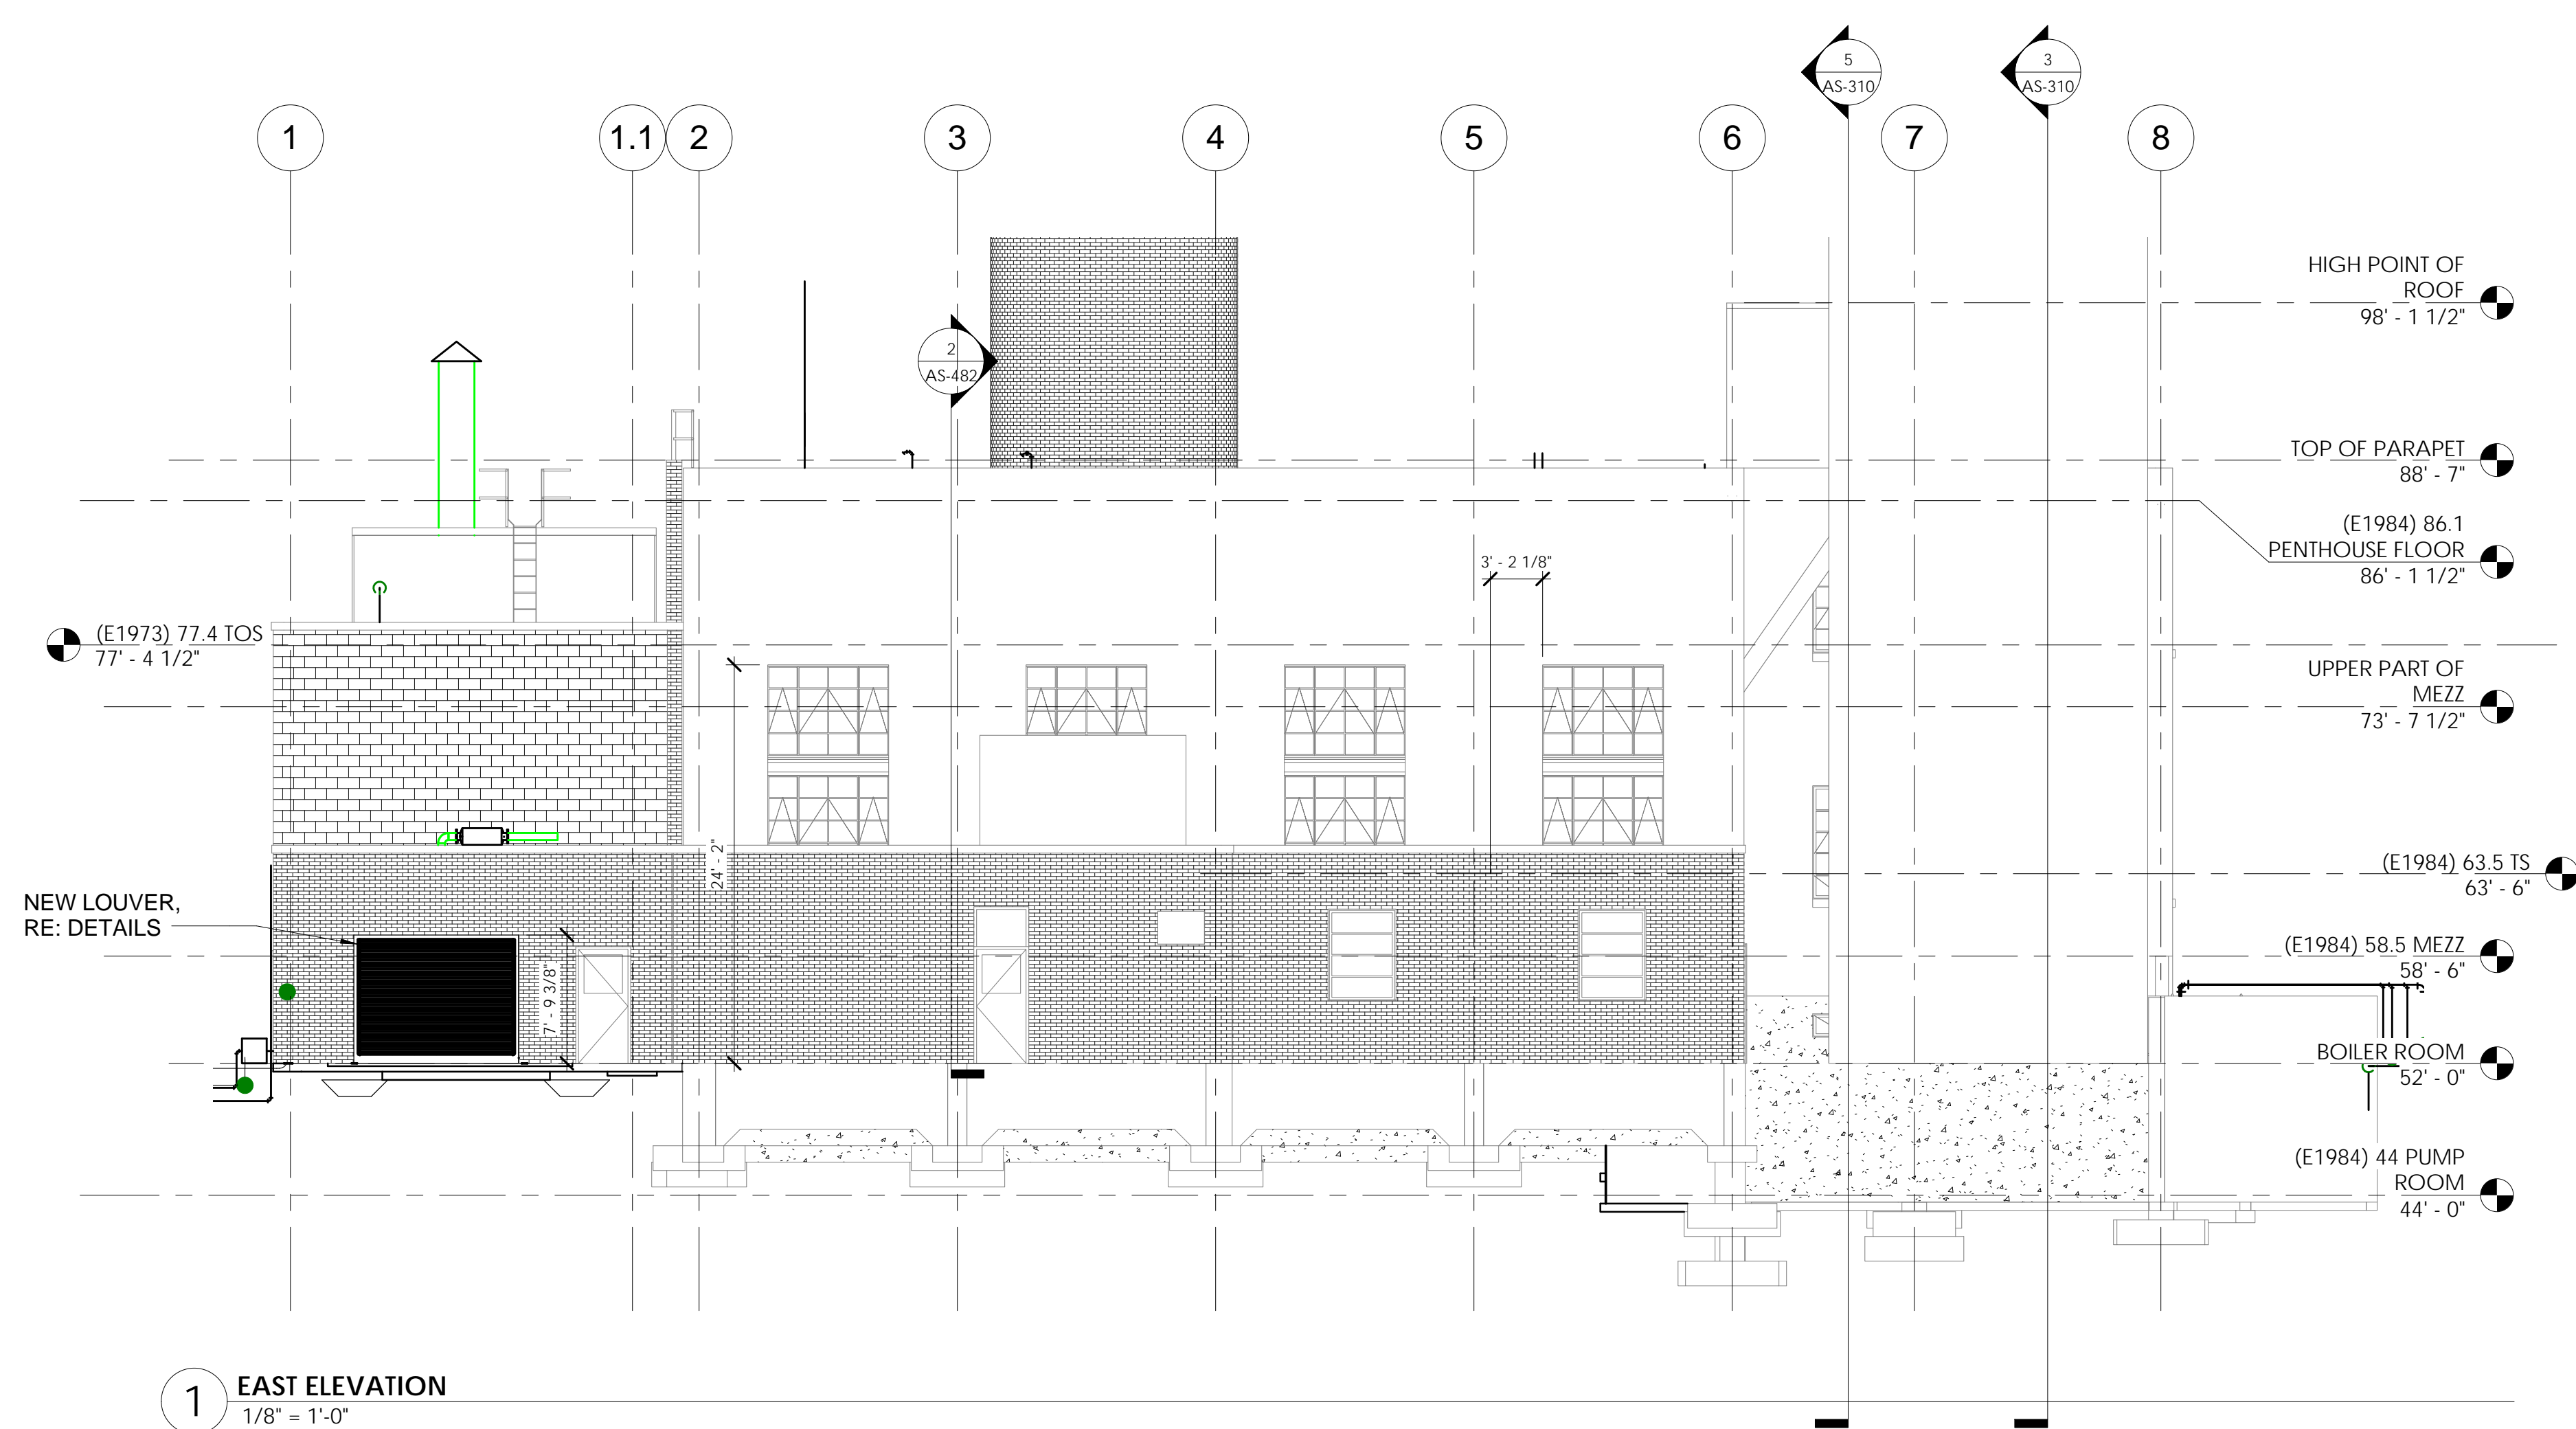

1 EAST ELEVATION
1/8" = 1'-0"

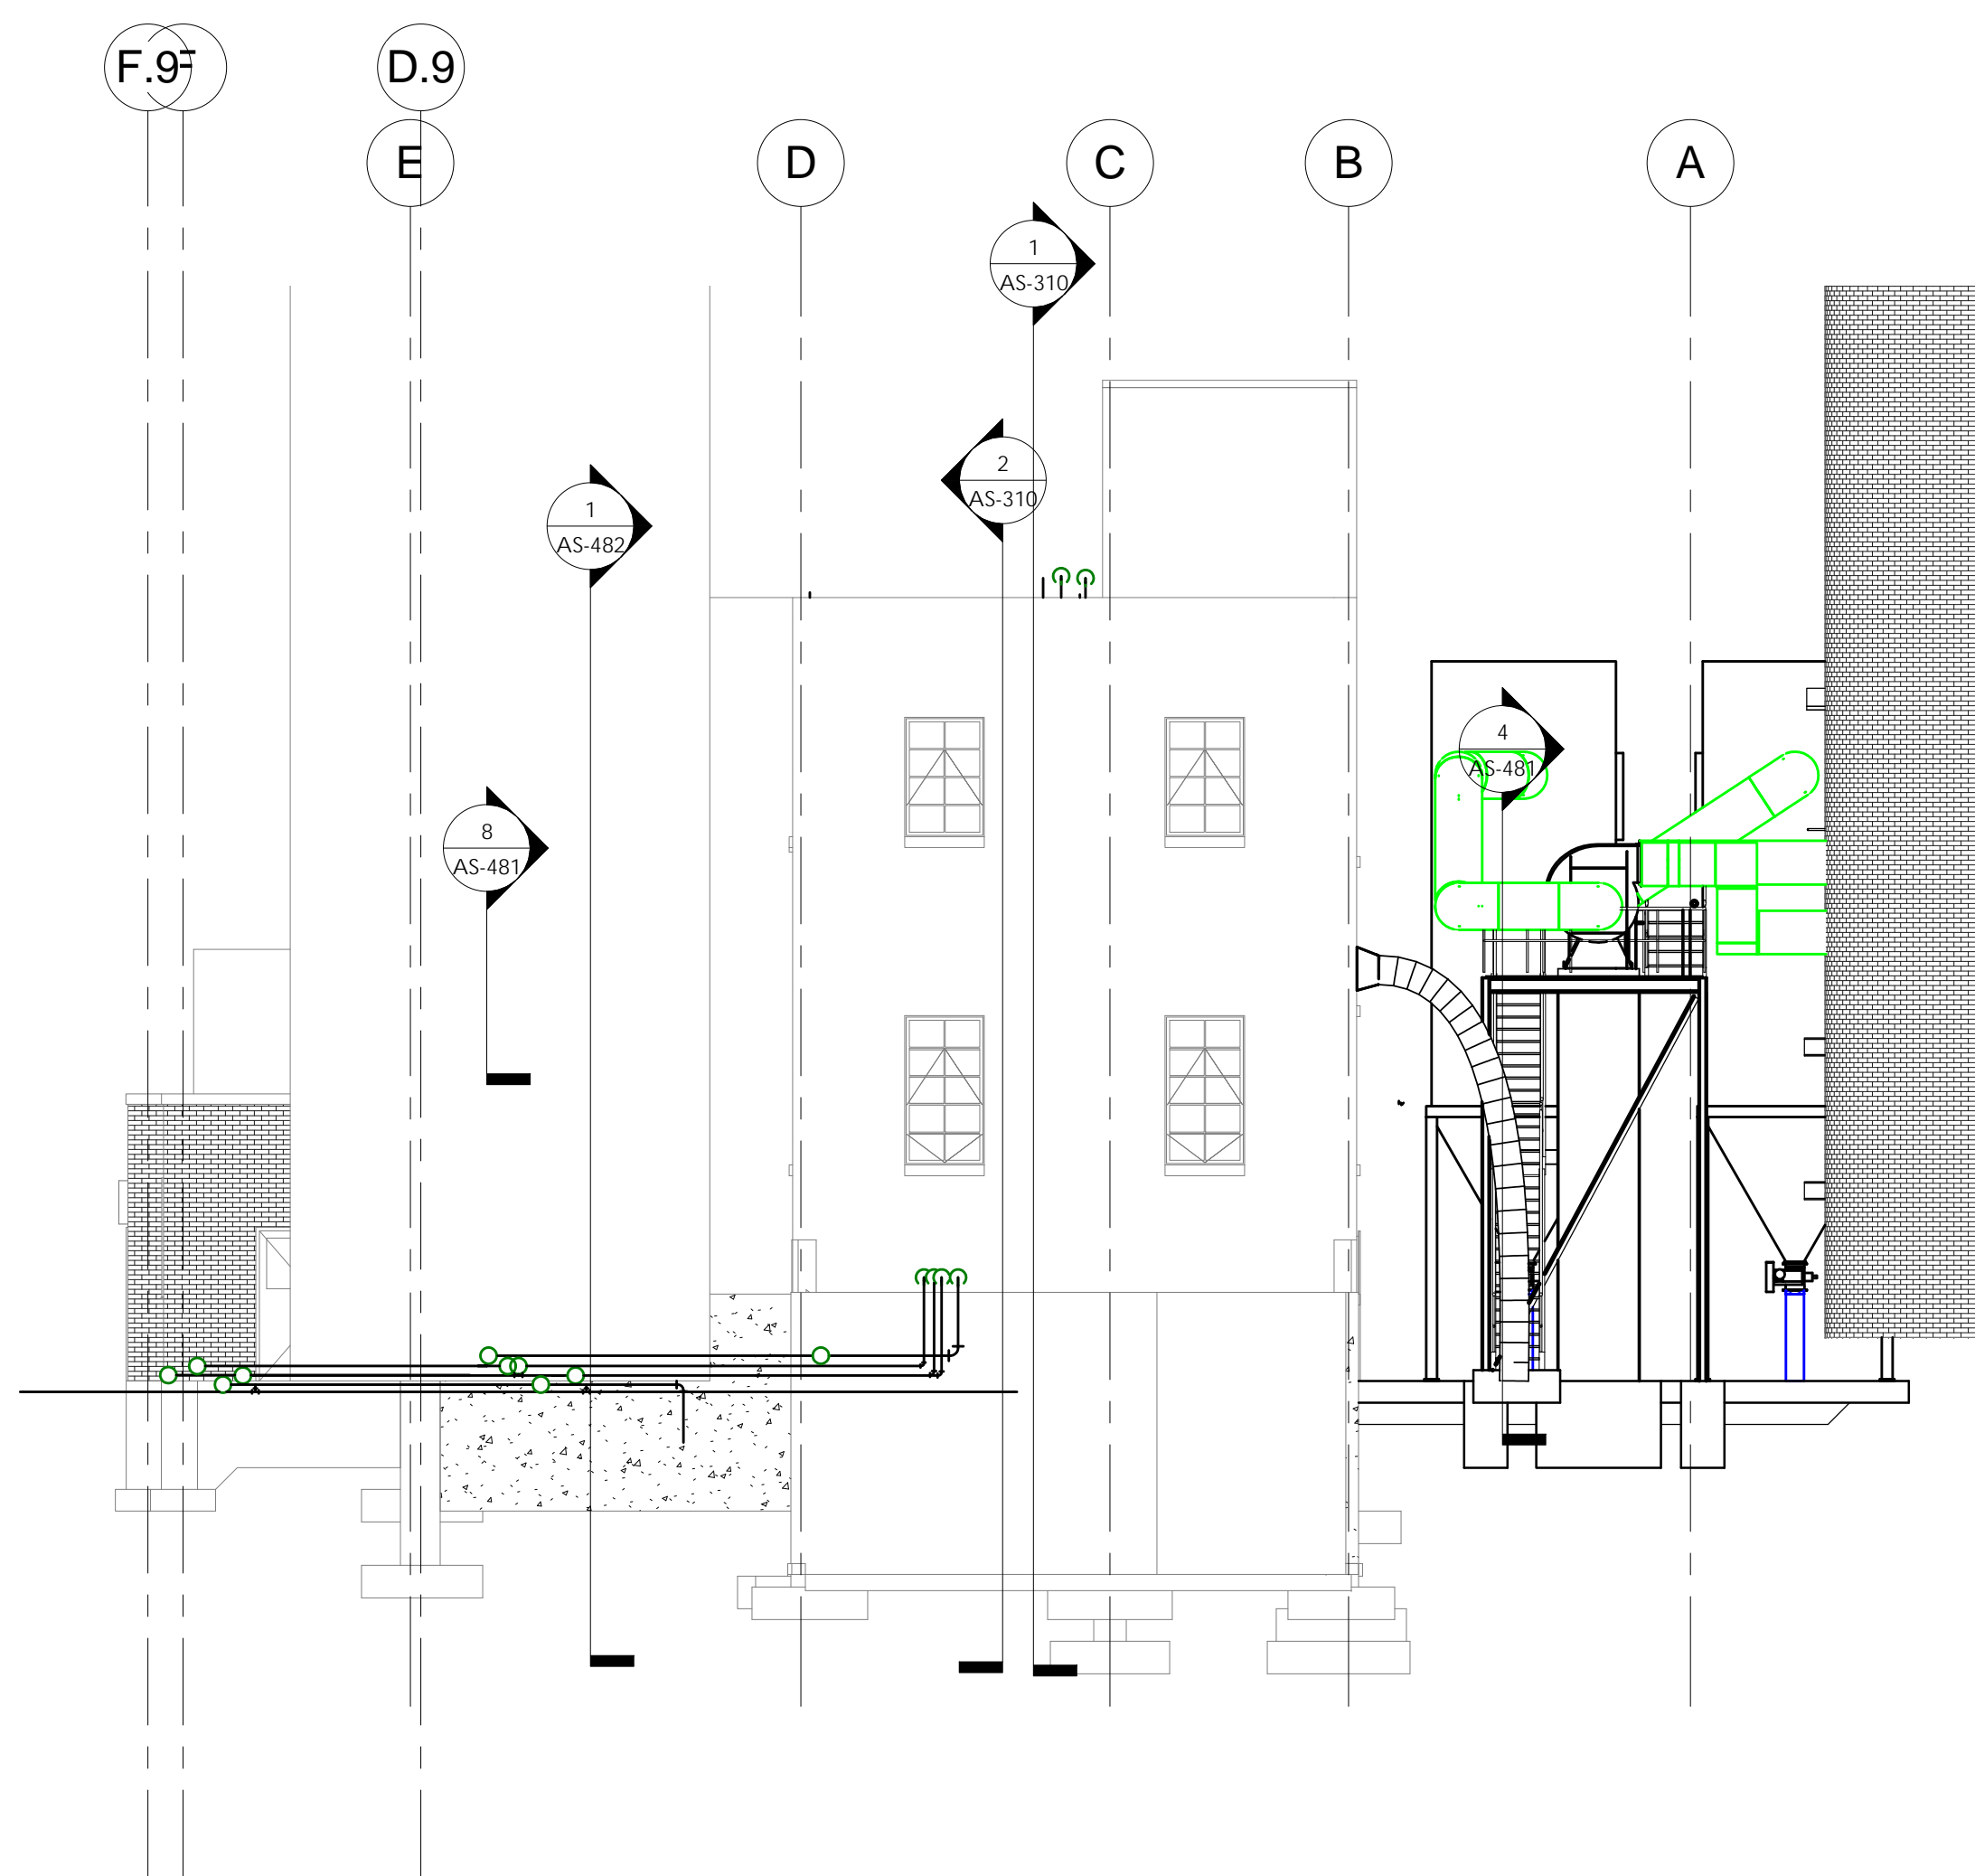

3 NORTH ELEVATION
1/8" = 1'-0"

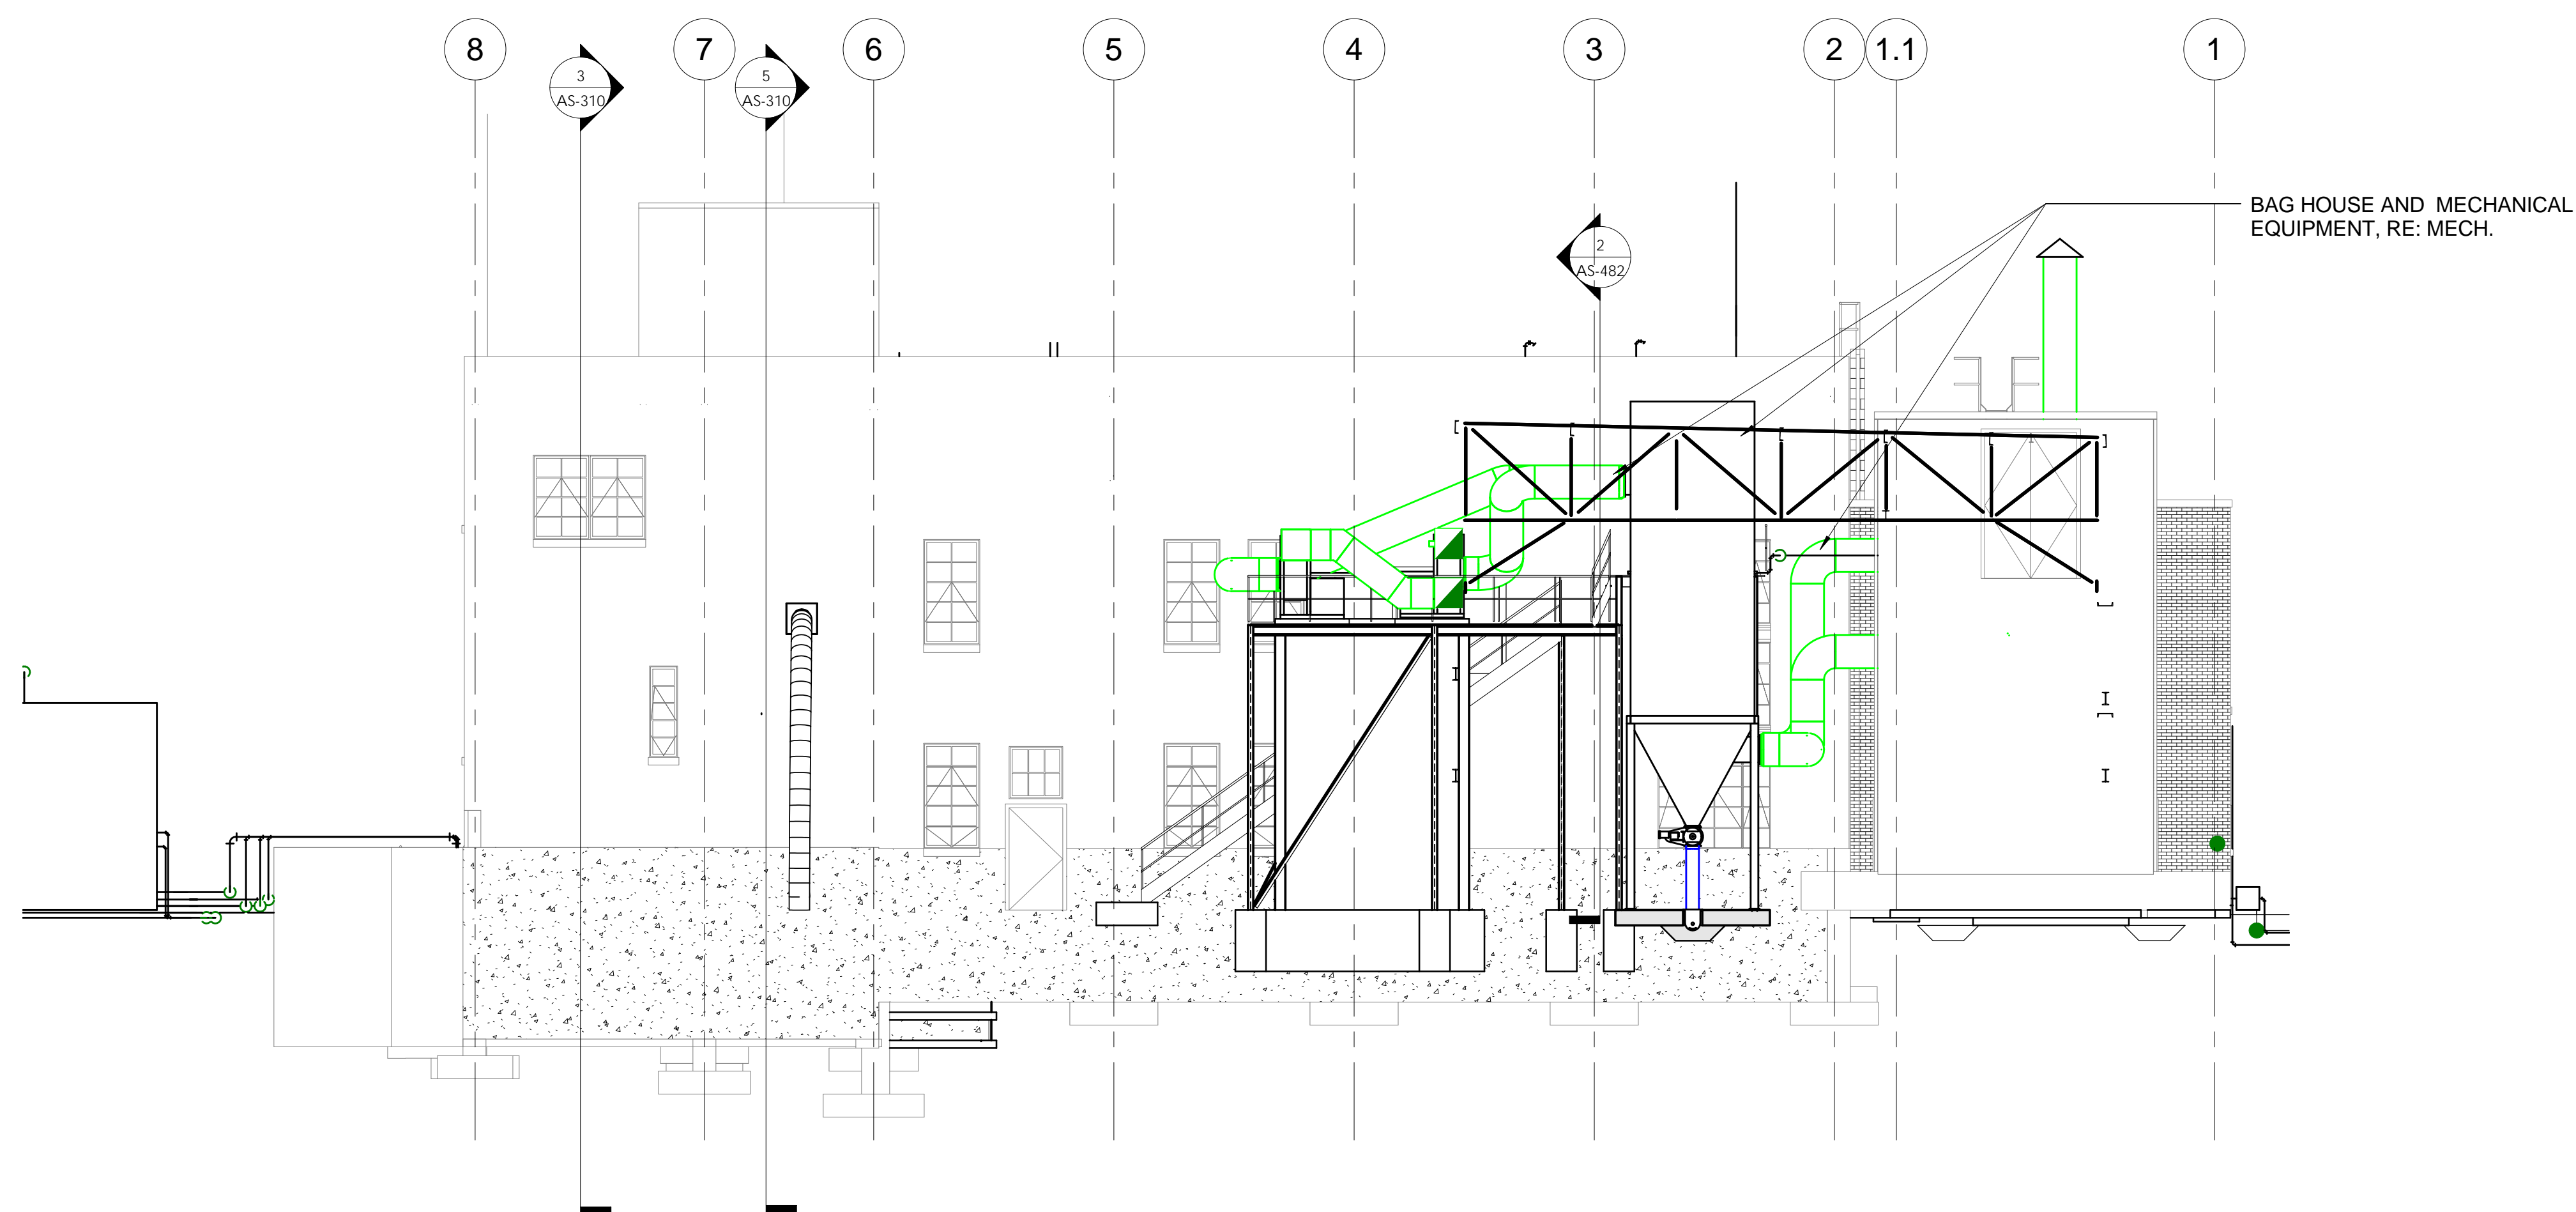

4 WEST ELEVATION
1/8" = 1'-0"


[illegible]

CONSULTANTS:

MKK Consulting Engineers, Inc.	Calibre
7600 East Orchard Road	9090 S Ridgeline Blvd.
Suite 250S	Suite 105
Greenwood Village, CO 80111	Highlands Ranch, CO 80129
Phone: 303.796.6000	Phone: 303.730.0434
Fax: 303.796.6099	Fax: 303.730.1130

Calibre
9090 S Ridgeline Blvd.
Suite 105
Highlands Ranch, CO 80129
Phone: 303.730.0434
Fax: 303.730.1130

Structural Consultants Inc.
3400 E Bayaud Ave # 300
Denver, CO 80209-2929
Phone: 303.399.5154
Fax: 303.333.9501

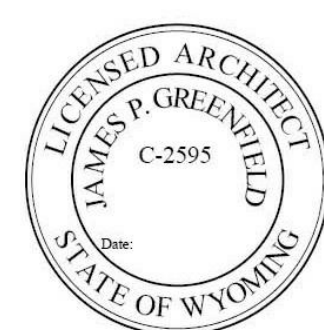

ARCHITECT/ENGINEERS:

GREENFIELD ARCHITECTS
3650 S YOSEMITE ST, STE 402
DENVER, CO 80237
PHONE: 303-770-1020
FAX: 303-770-0922

GA Project Number 10-435

	Drawing Title
--	---------------

NEW ELEVATIONS

Approved: Project Director
JASON BROWN

Project Title	-BOILER PLANT -REPLACEMENT
---------------	-------------------------------

Location	- SHERIDAN, WY
----------	----------------

Date
12/15/2011
BIDDING & CNSTN

Checked	JG
---------	----

Drawn	WS
-------	----

Project Number






Building Number
- 90

Drawing Number	AS-211
----------------	--------

Dwg. of

Office of
Construction
and Facilities
Management



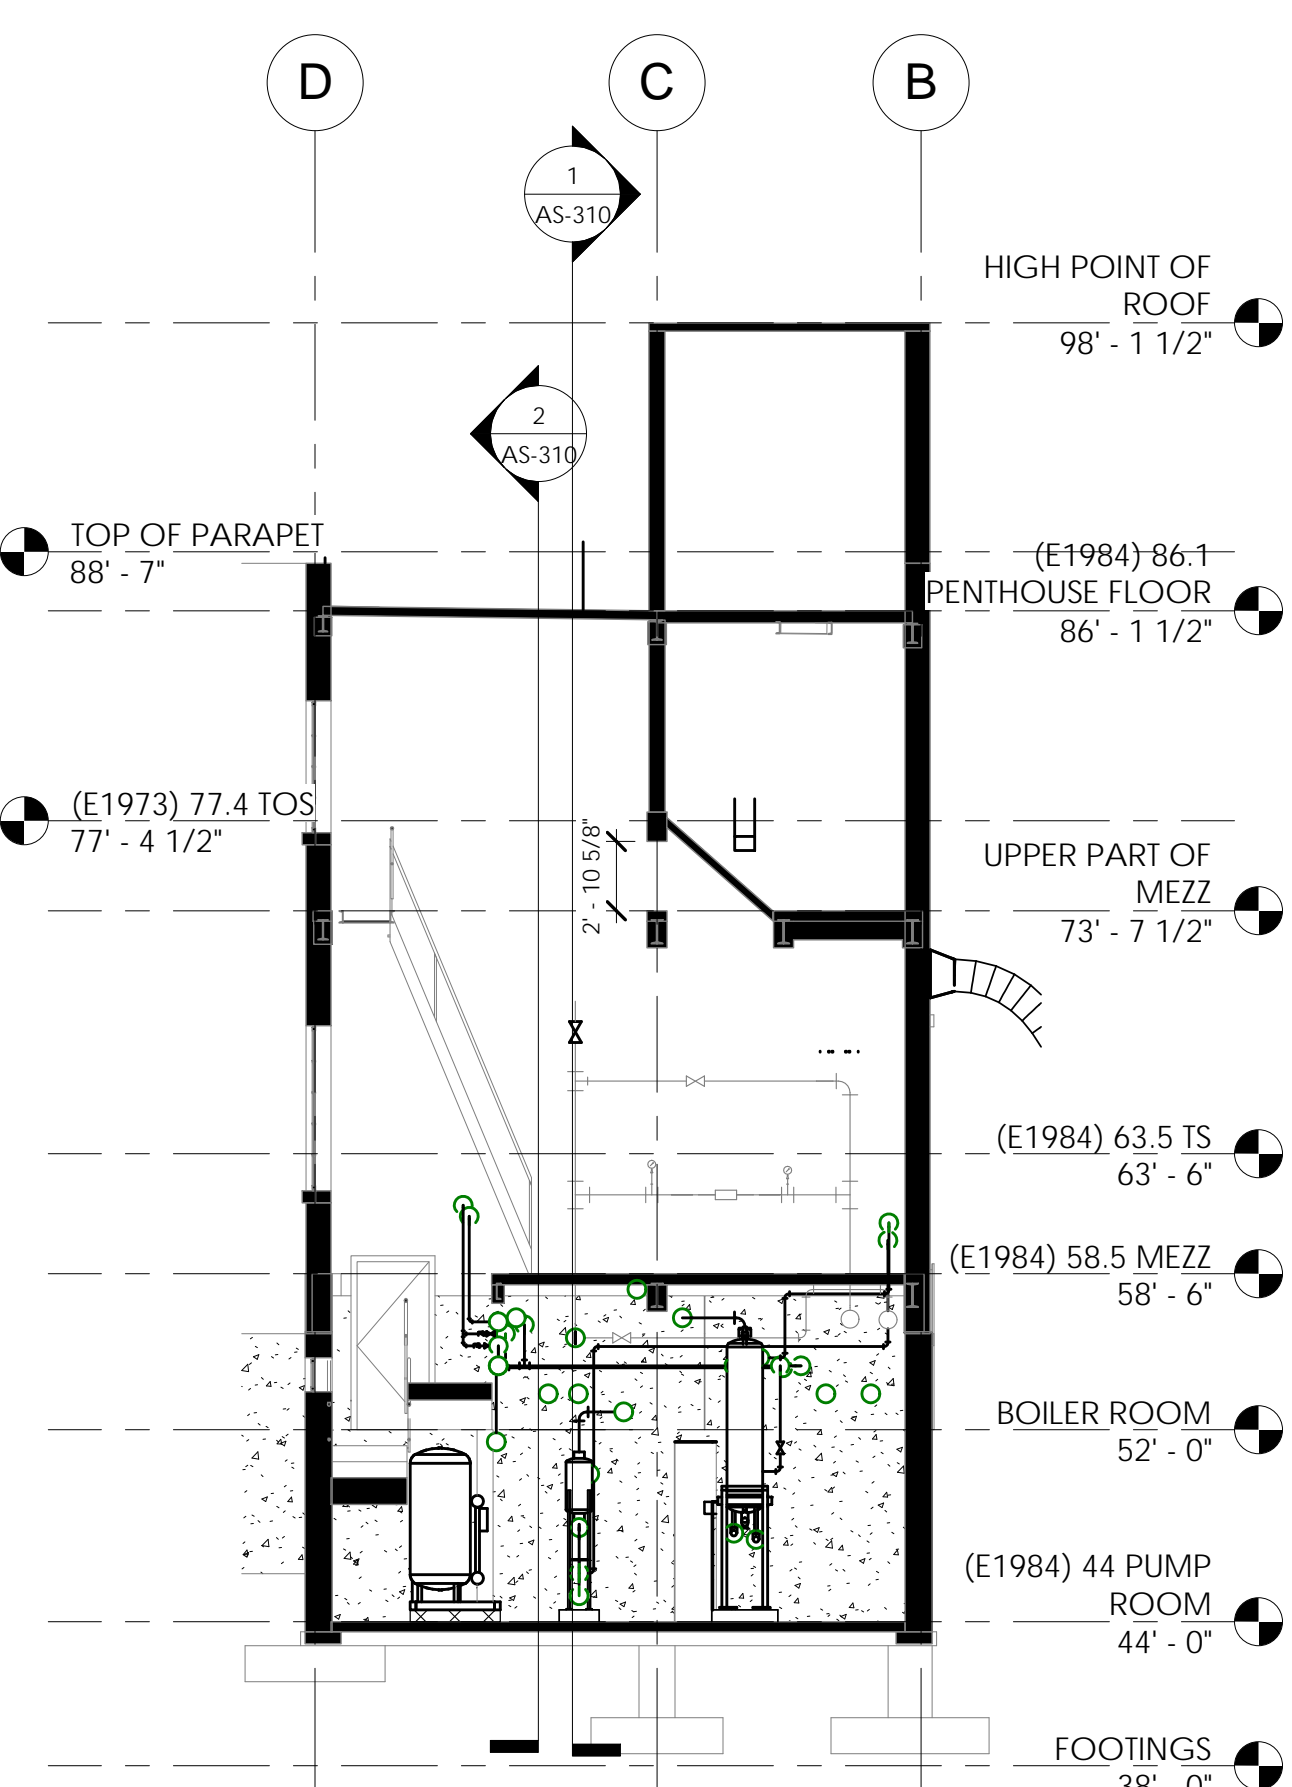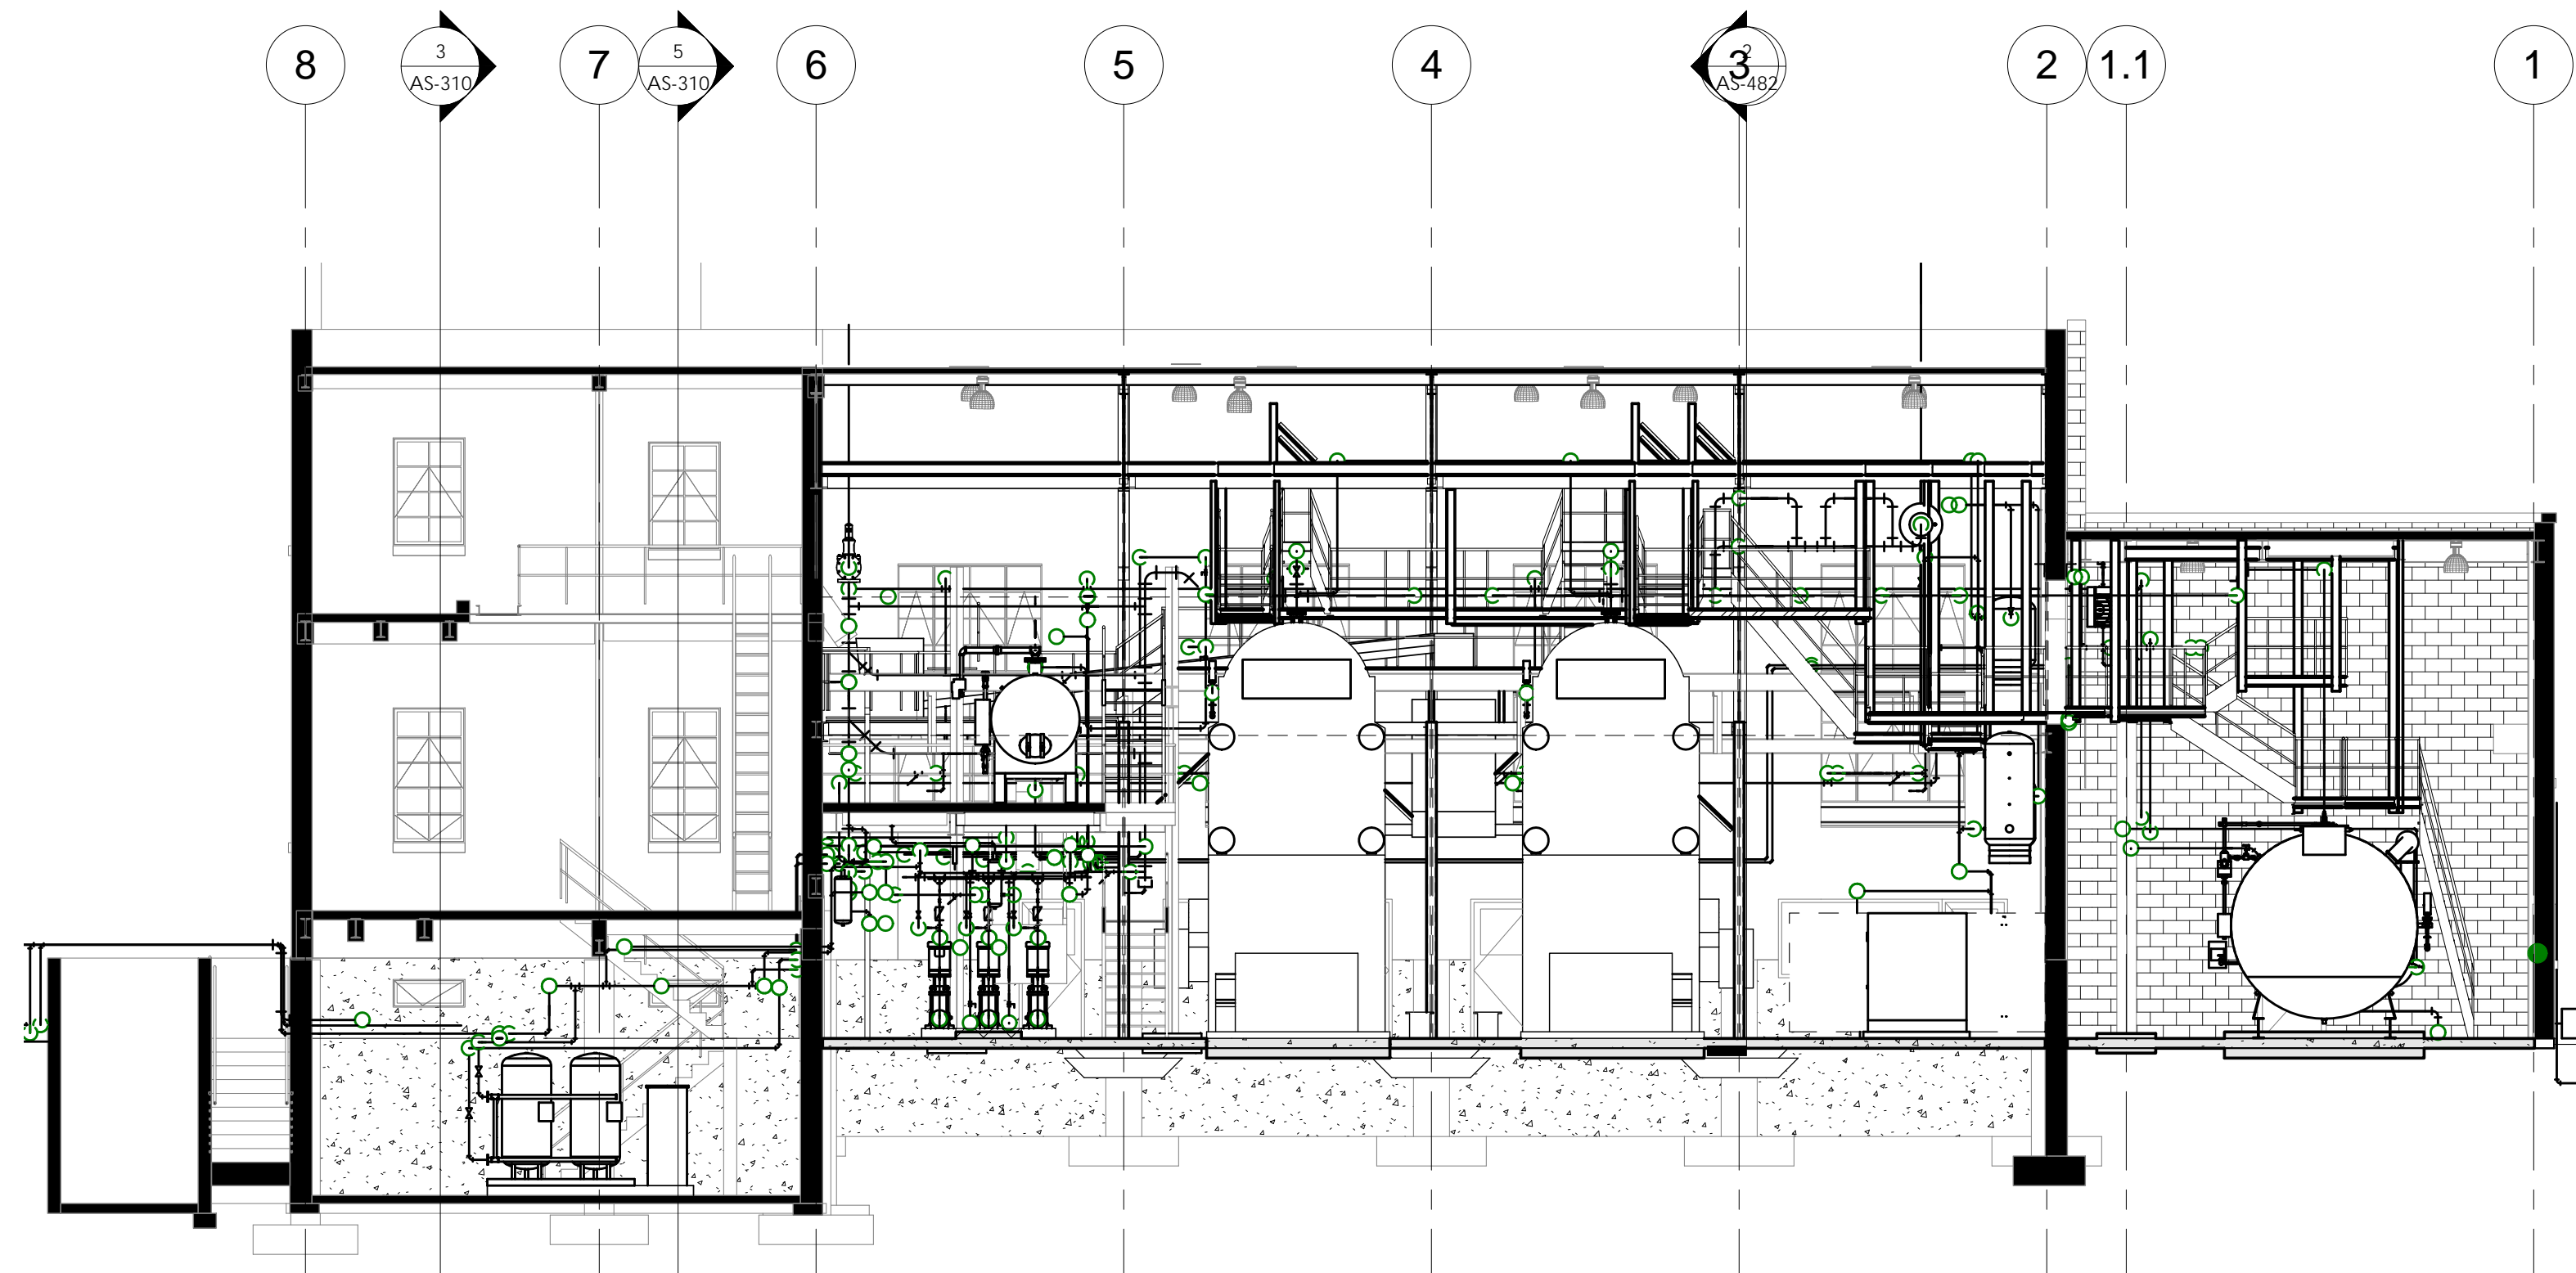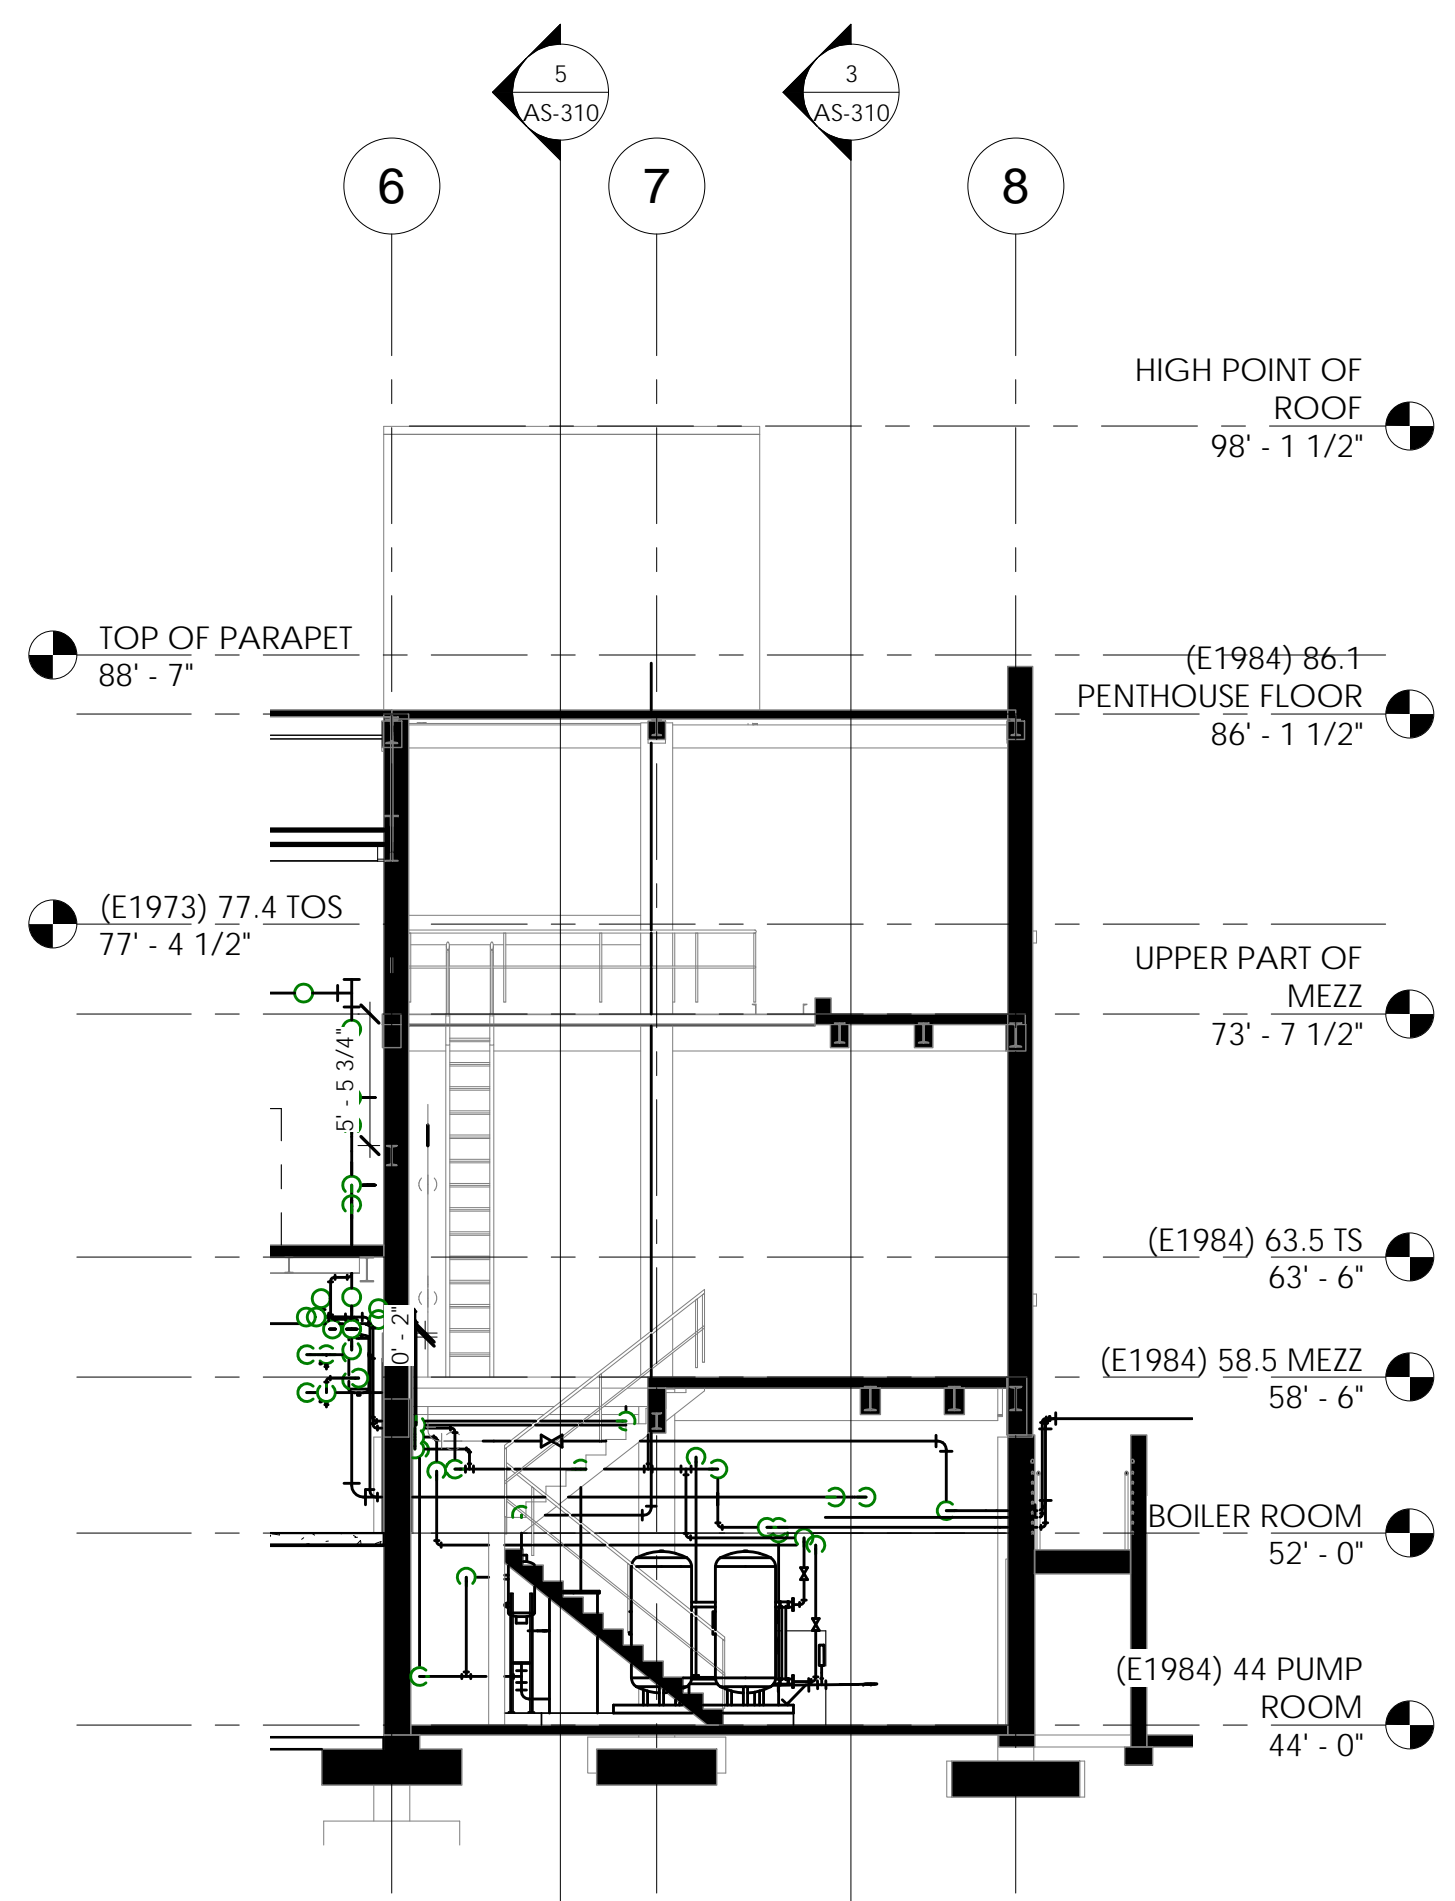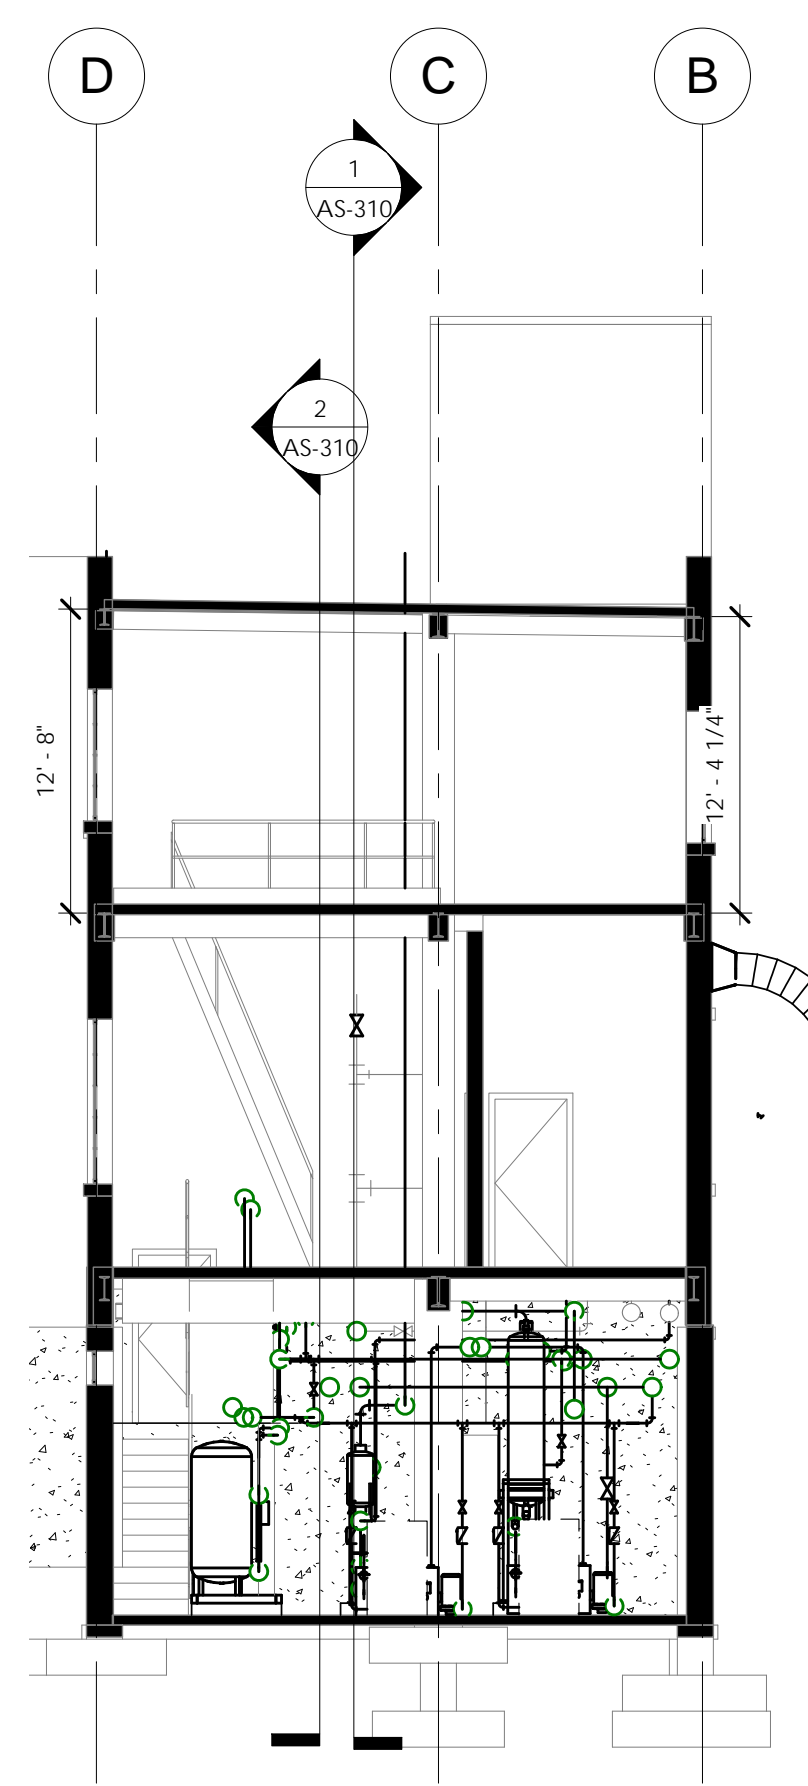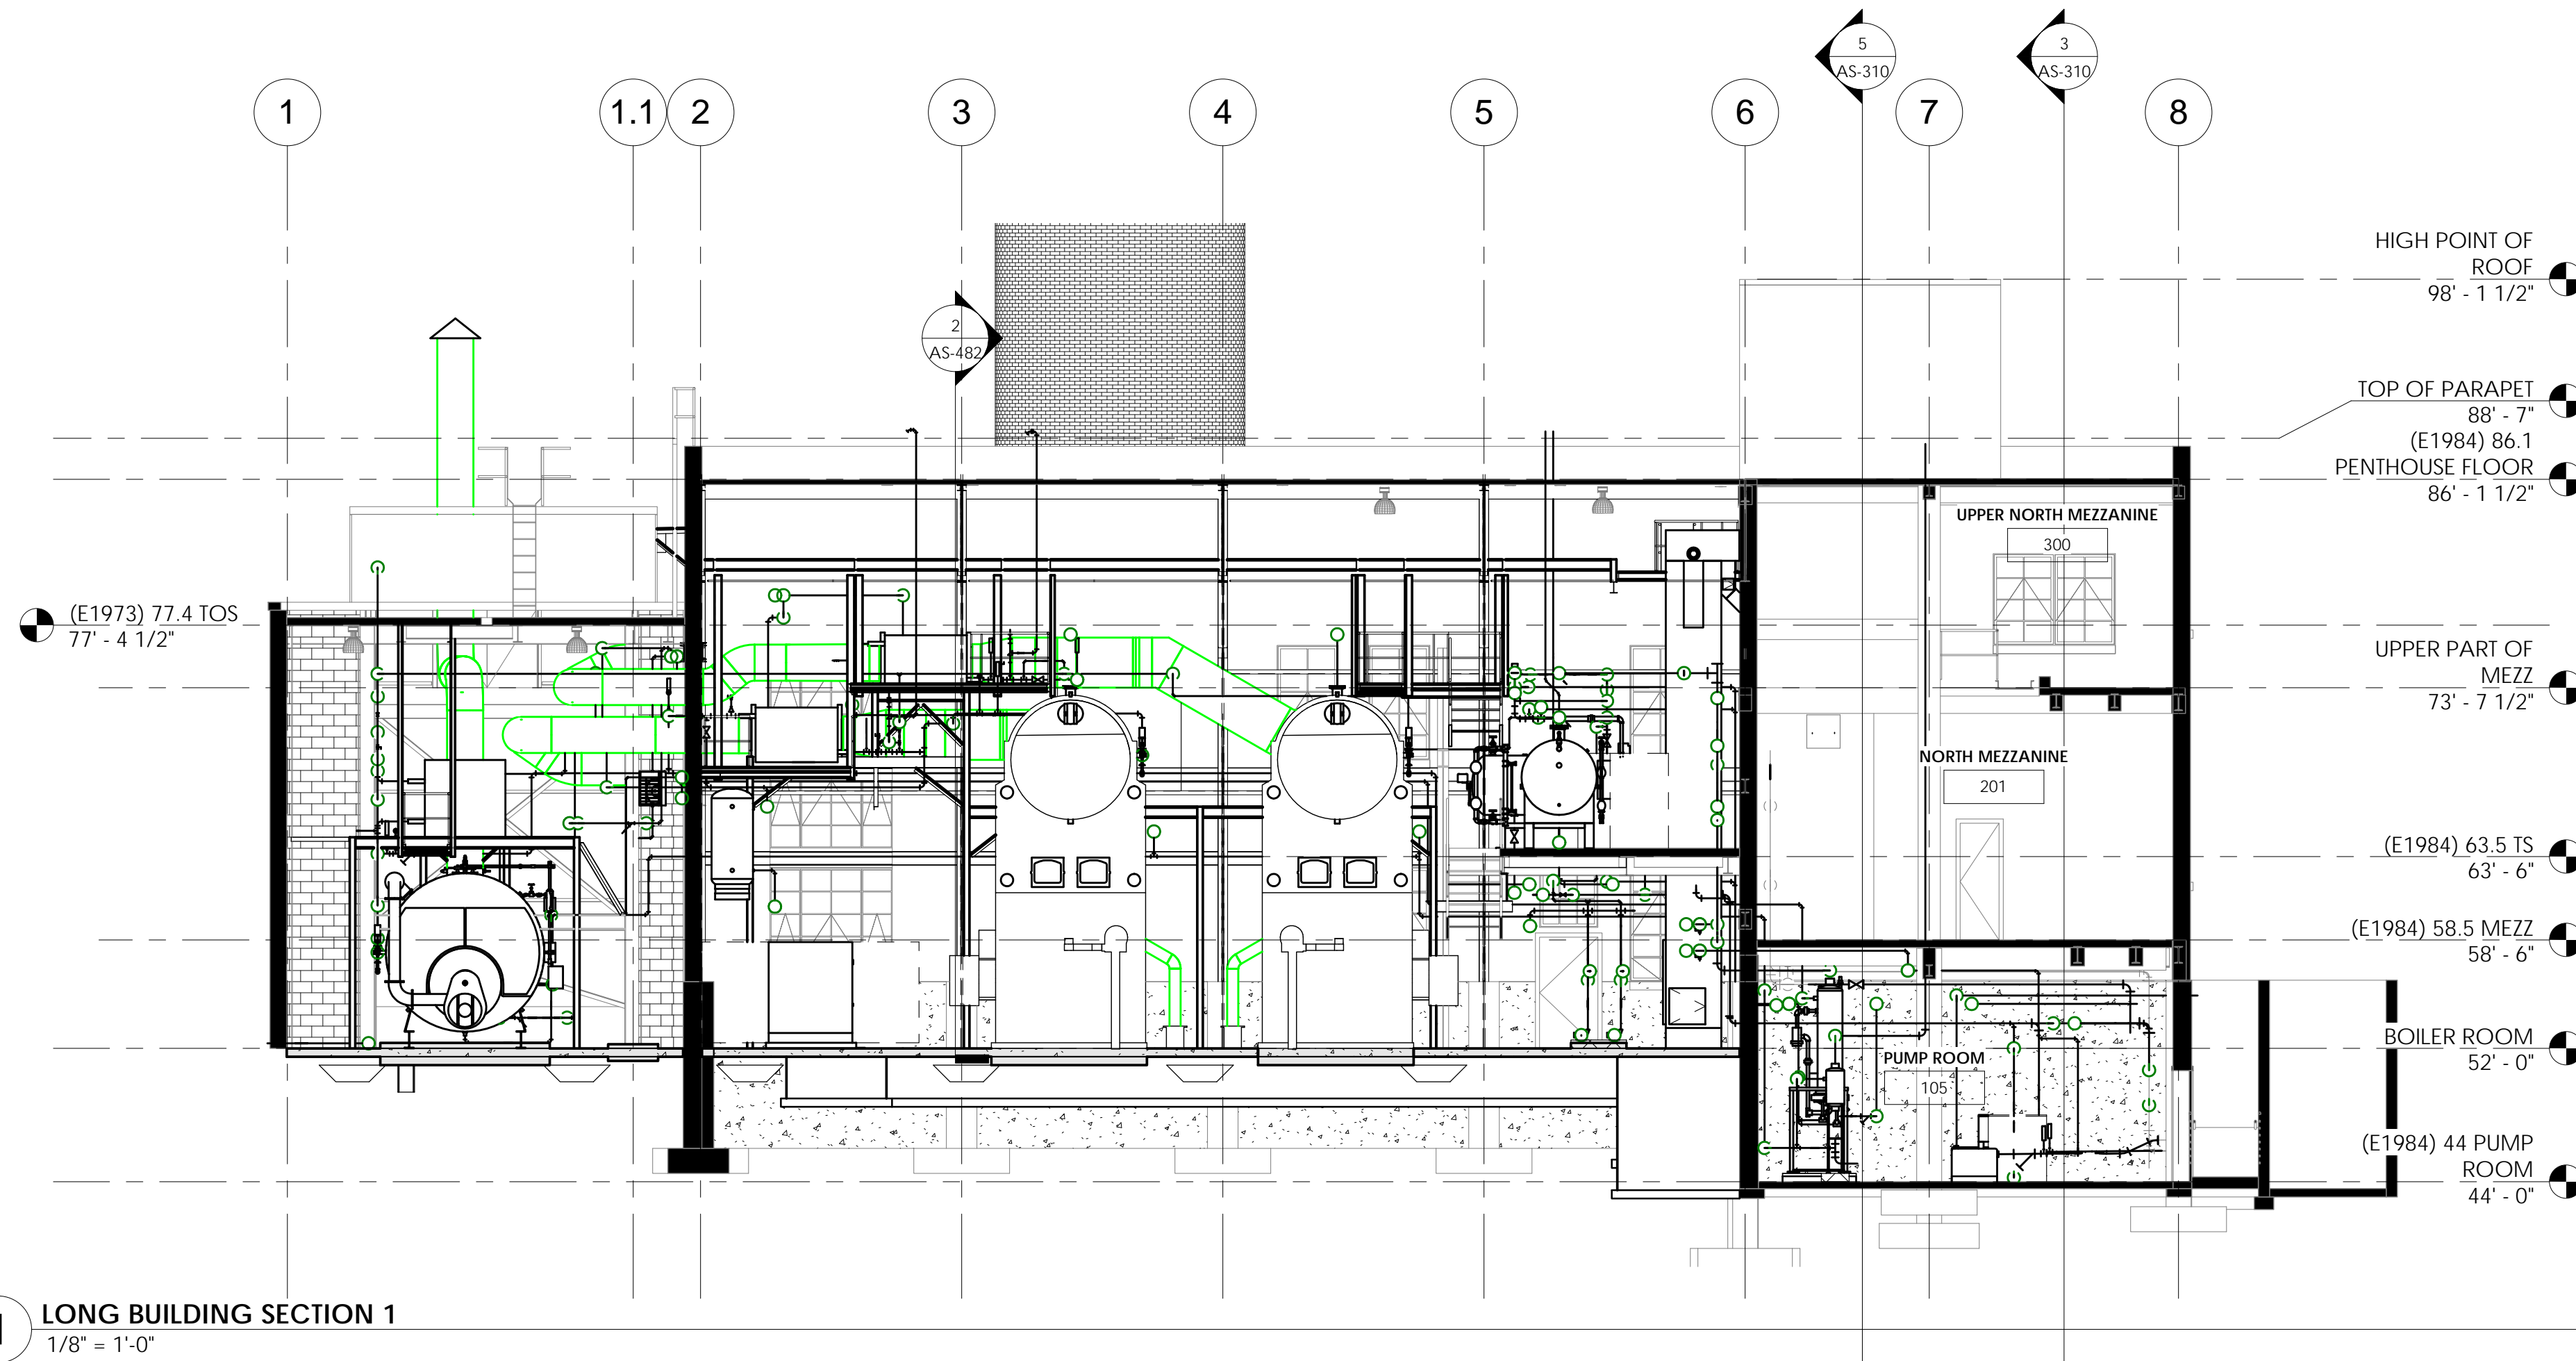

1 LONG BUILDING SECTION 1
1/8" = 1'-0"

3 PENTHOUSE SECTION 1
1/8" = 1'-0"

4 PENTHOUSE SECTION 2
1/8" = 1'-0"

2 LONG BUILDING SECTION 2
1/8" = 1'-0"

5 PENTHOUSE SECTION 4
1/8" = 1'-0"

CONSULTANTS:

MKK Consulting Engineers, Inc.
7600 East Orchard Road
Suite 250S
Greenwood Village, CO 80111
Phone: 303.796.6000
Fax: 303.796.6099

Calibre
9090 S Ridgeline Blvd.
Suite 105
Highlands Ranch, CO 80129
Phone: 303.730.0434
Fax: 303.730.1130

Structural Consultants Inc.
3400 E Bayaud Ave # 300
Denver, CO 80237
Phone: 303.399.5154
Fax: 303.333.9501



ARCHITECT/ENGINEERS:

GREENFIELD ARCHITECTS
3650 S YOSEMITE ST, STE 402
DENVER, CO 80237
PHONE: 303-770-1020
FAX: 303-770-0922

GA Project Number 10-435

Drawing Title
BUILDING SECTIONS

Approved: Project Director
JASON BROWN

Project Title
-BOILER PLANT
-REPLACEMENT
-

Location
- SHERIDAN, WY

Date
12/15/2011
BIDDING & CNSTN

Checked
JG

Drawn
WS

Project Number
- 666-11-101
Building Number
- 90
Drawing Number
AS-310

Dwg. of --

Office of
Construction
and Facilities
Management
Department of
Veterans Affairs

CONSTRUCTION DOCUMENTATION SUBMISSION - BIDDING AND CONSTRUCTION

P:\2010-035 - VAMC VA Medical Center Drawings\AMC Bolter\12/12/2011 03:16 AM

VA FORM 08-6231

CONSULTANTS:

MKK Consulting Engineers, Inc.
7600 East Orchard Road
Suite 250S
Greenwood Village, CO 80111
Phone: 303.796.6000
Fax: 303.796.6099

Calibre
9090 S Ridgeline Blvd.
Suite 105
Highlands Ranch, CO 80129
Phone: 303.730.0434
Fax: 303.730.1130

Structural Consultants Inc.
3400 E Bayaud Ave # 300
Denver, CO 80209-2929
Phone: 303.399.5154
Fax: 303.333.9501



ARCHITECT/ENGINEERS:

GREENFIELD ARCHITECTS
3650 S YOSEMITE ST, STE 402
DENVER, CO 80237
PHONE: 303-770-1020
FAX: 303-770-0922

GA Project Number 10-435

Drawing Title

CATWALK SECTIONS

Approved: Project Director
JASON BROWN

Project Title
-BOILER PLANT
-REPLACEMENT
-

Location
- SHERIDAN, WY

Date
12/15/2011
BIDDING & CNSTN

Checked
JG

Drawn
WS

Project Number
- 666-11-101
Building Number
- 90


Drawing Number
AS-482

Dwg. of --


Office of
Construction
and Facilities
Management




1 CATWALK SECTION 1
1/8" = 1'-0"

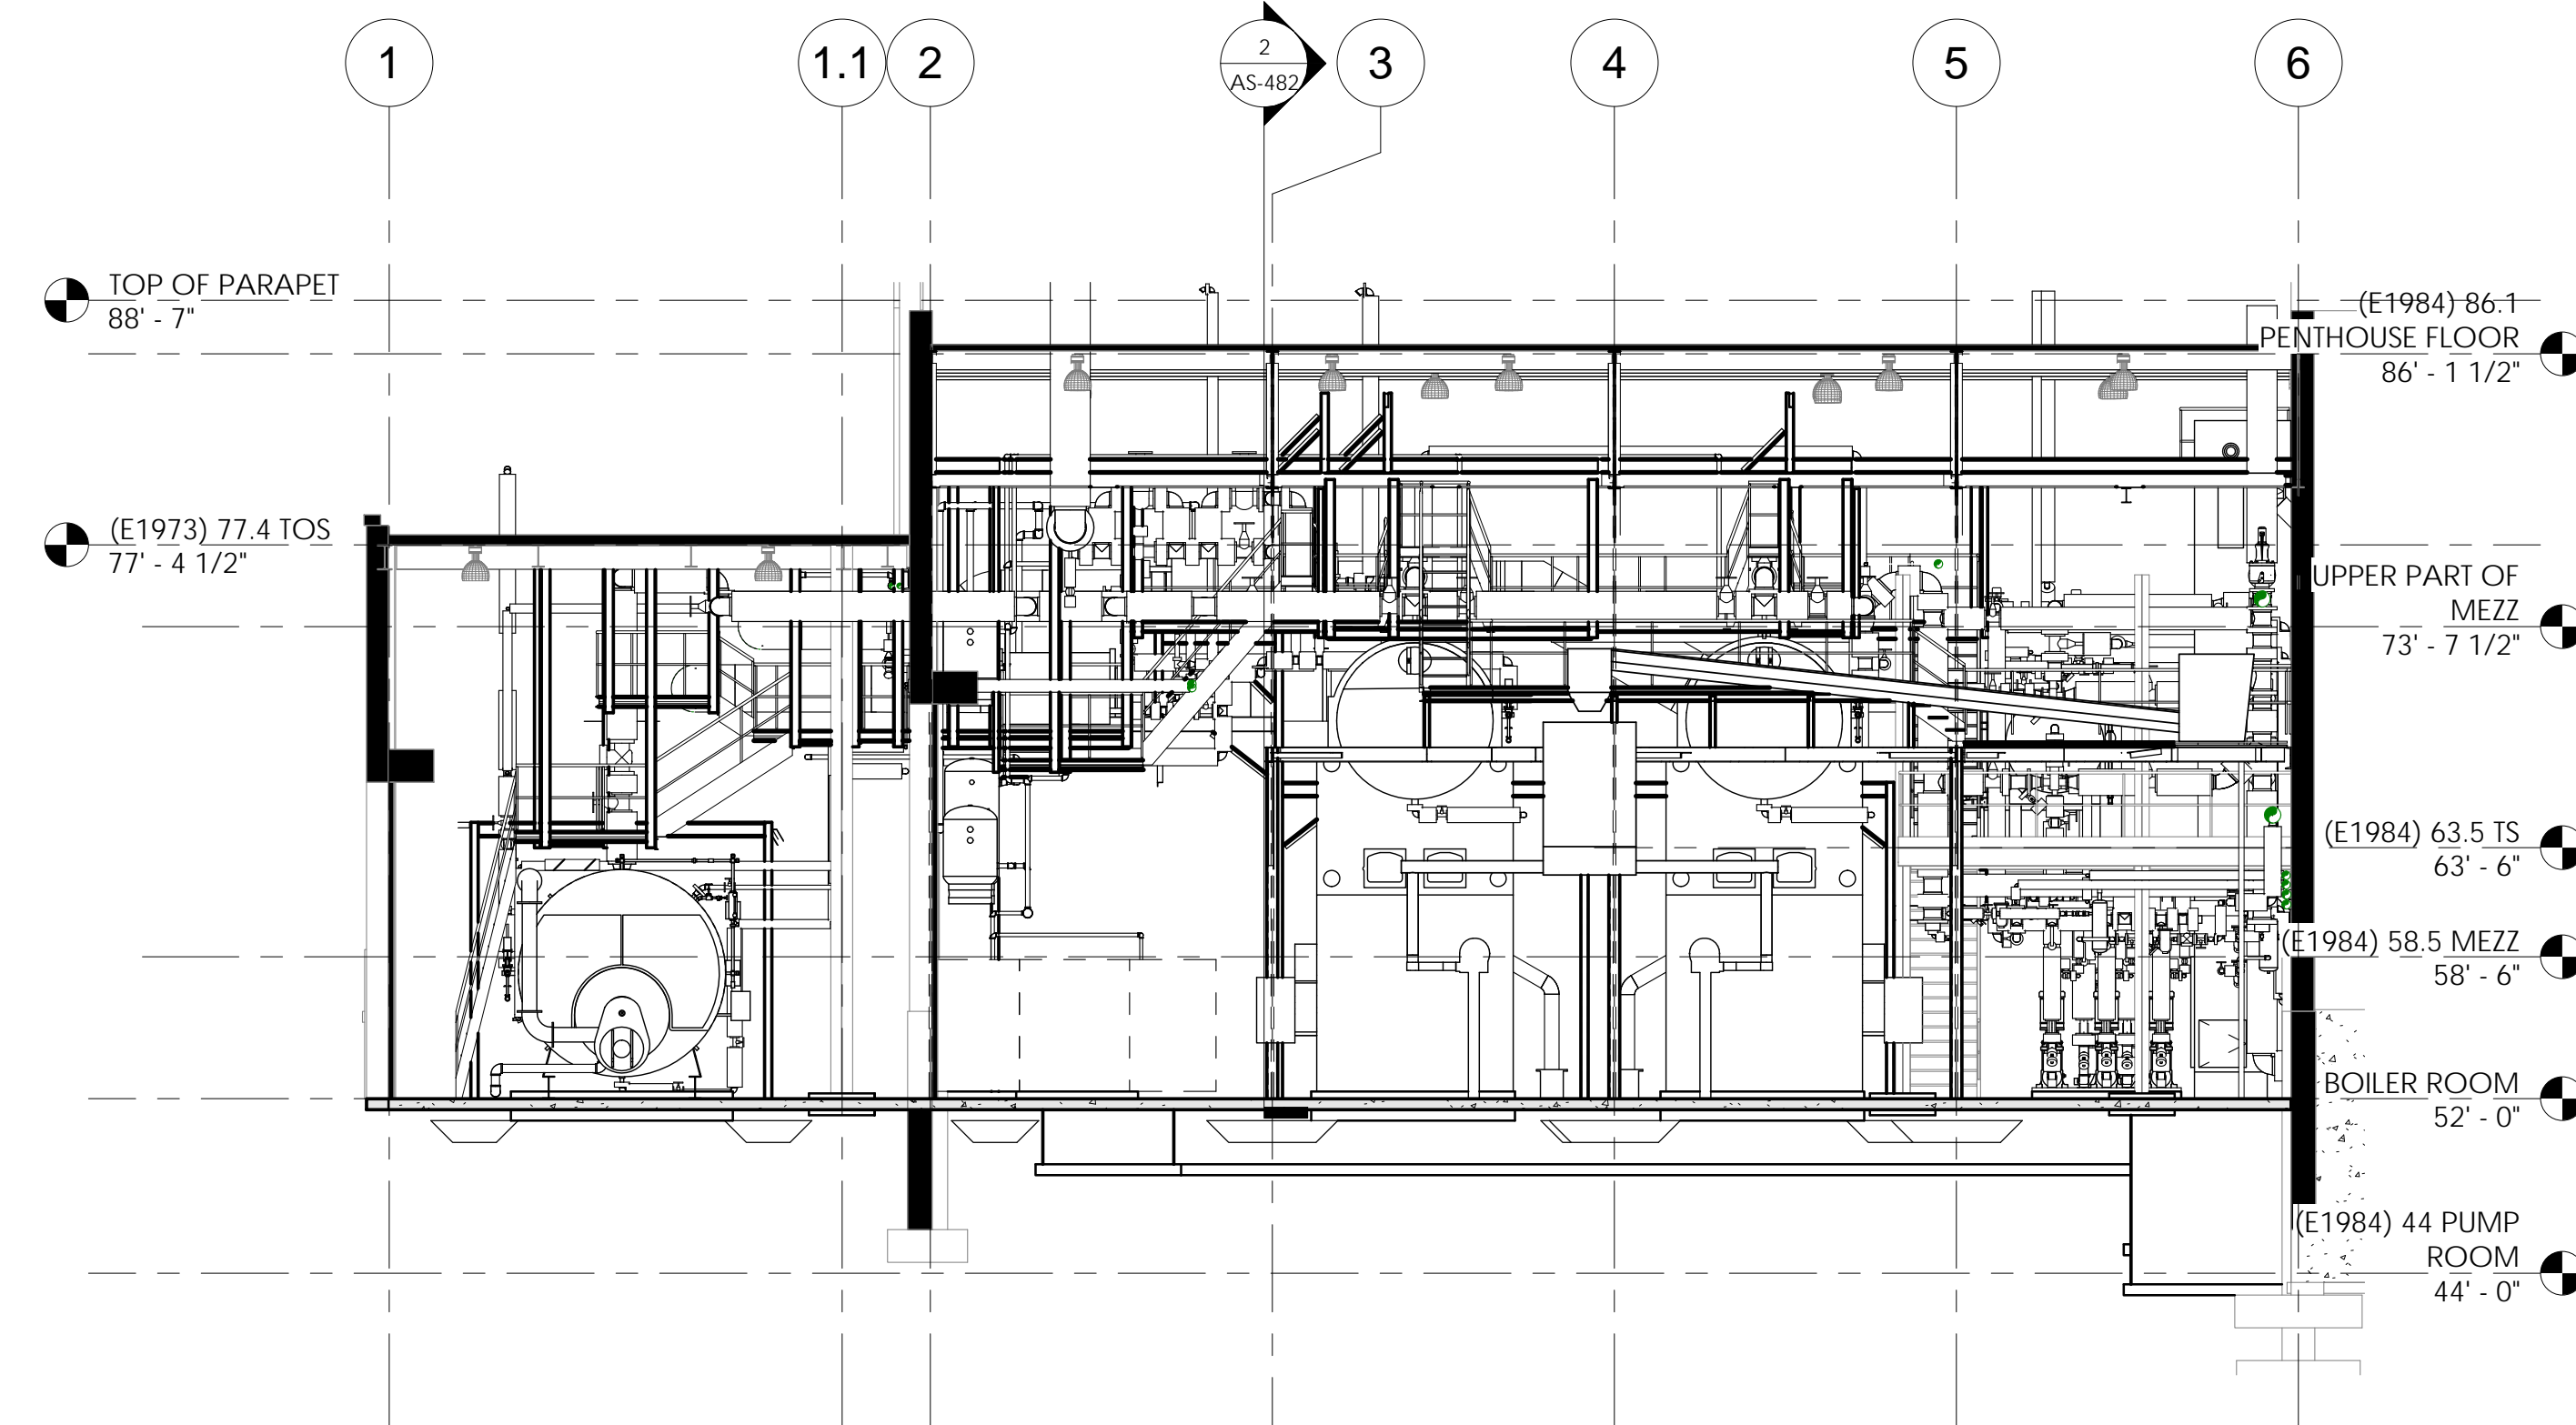


3 CATWALK VERTICAL CIRCULATION D1
1/4" = 1'-0"

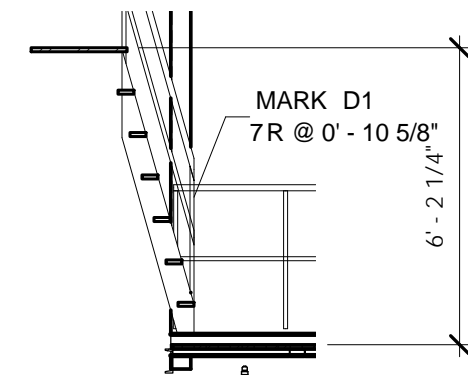


4 CATWALK VERTICAL CIRCULATION D2
1/4" = 1'-0"

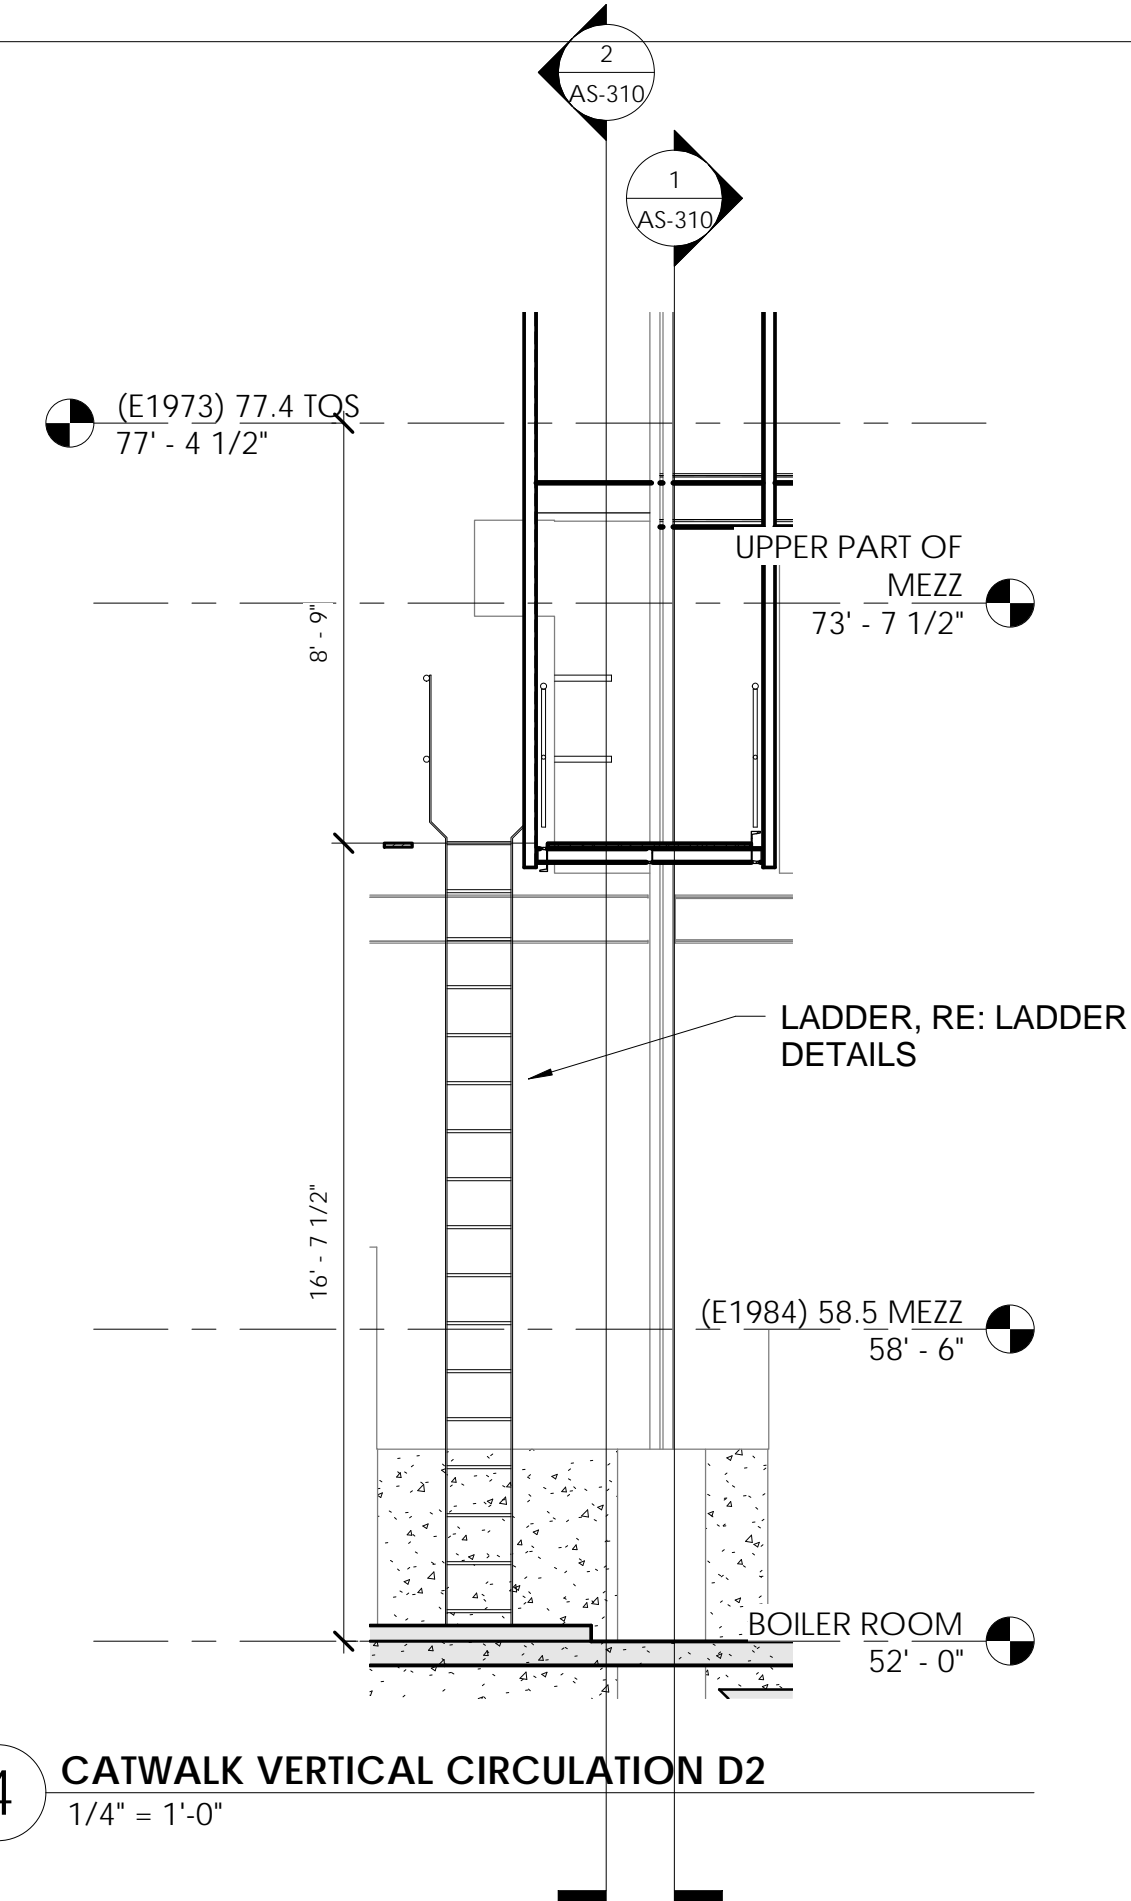


5 CATWALK VERTICAL CIRCULATION D3 & D4
1/4" = 1'-0"

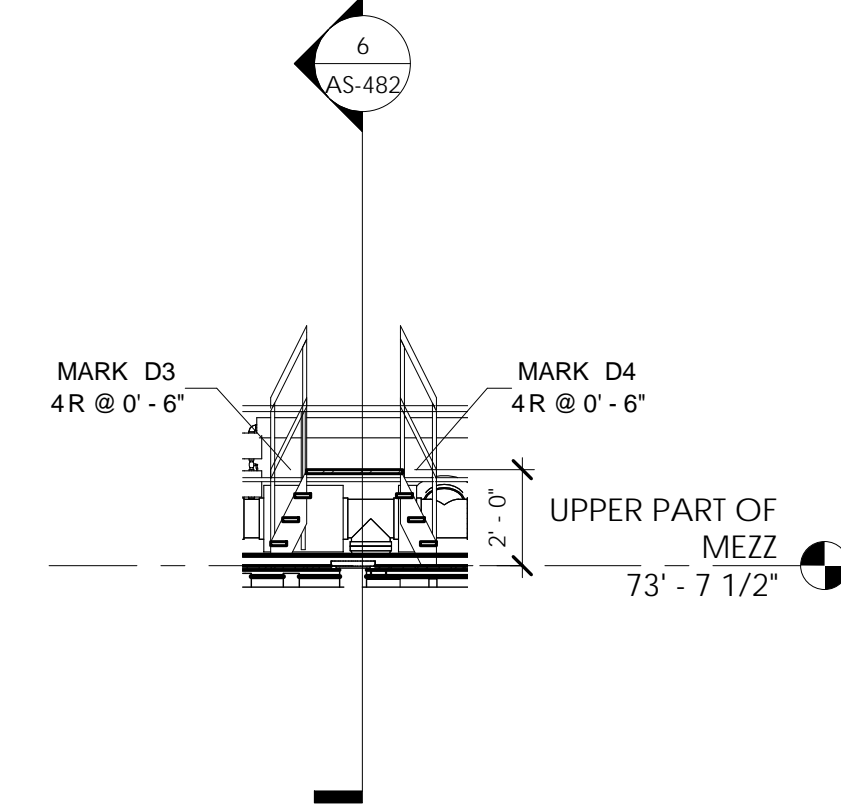


6 CATWALK VERTICAL CIRCULATION D5
1/4" = 1'-0"

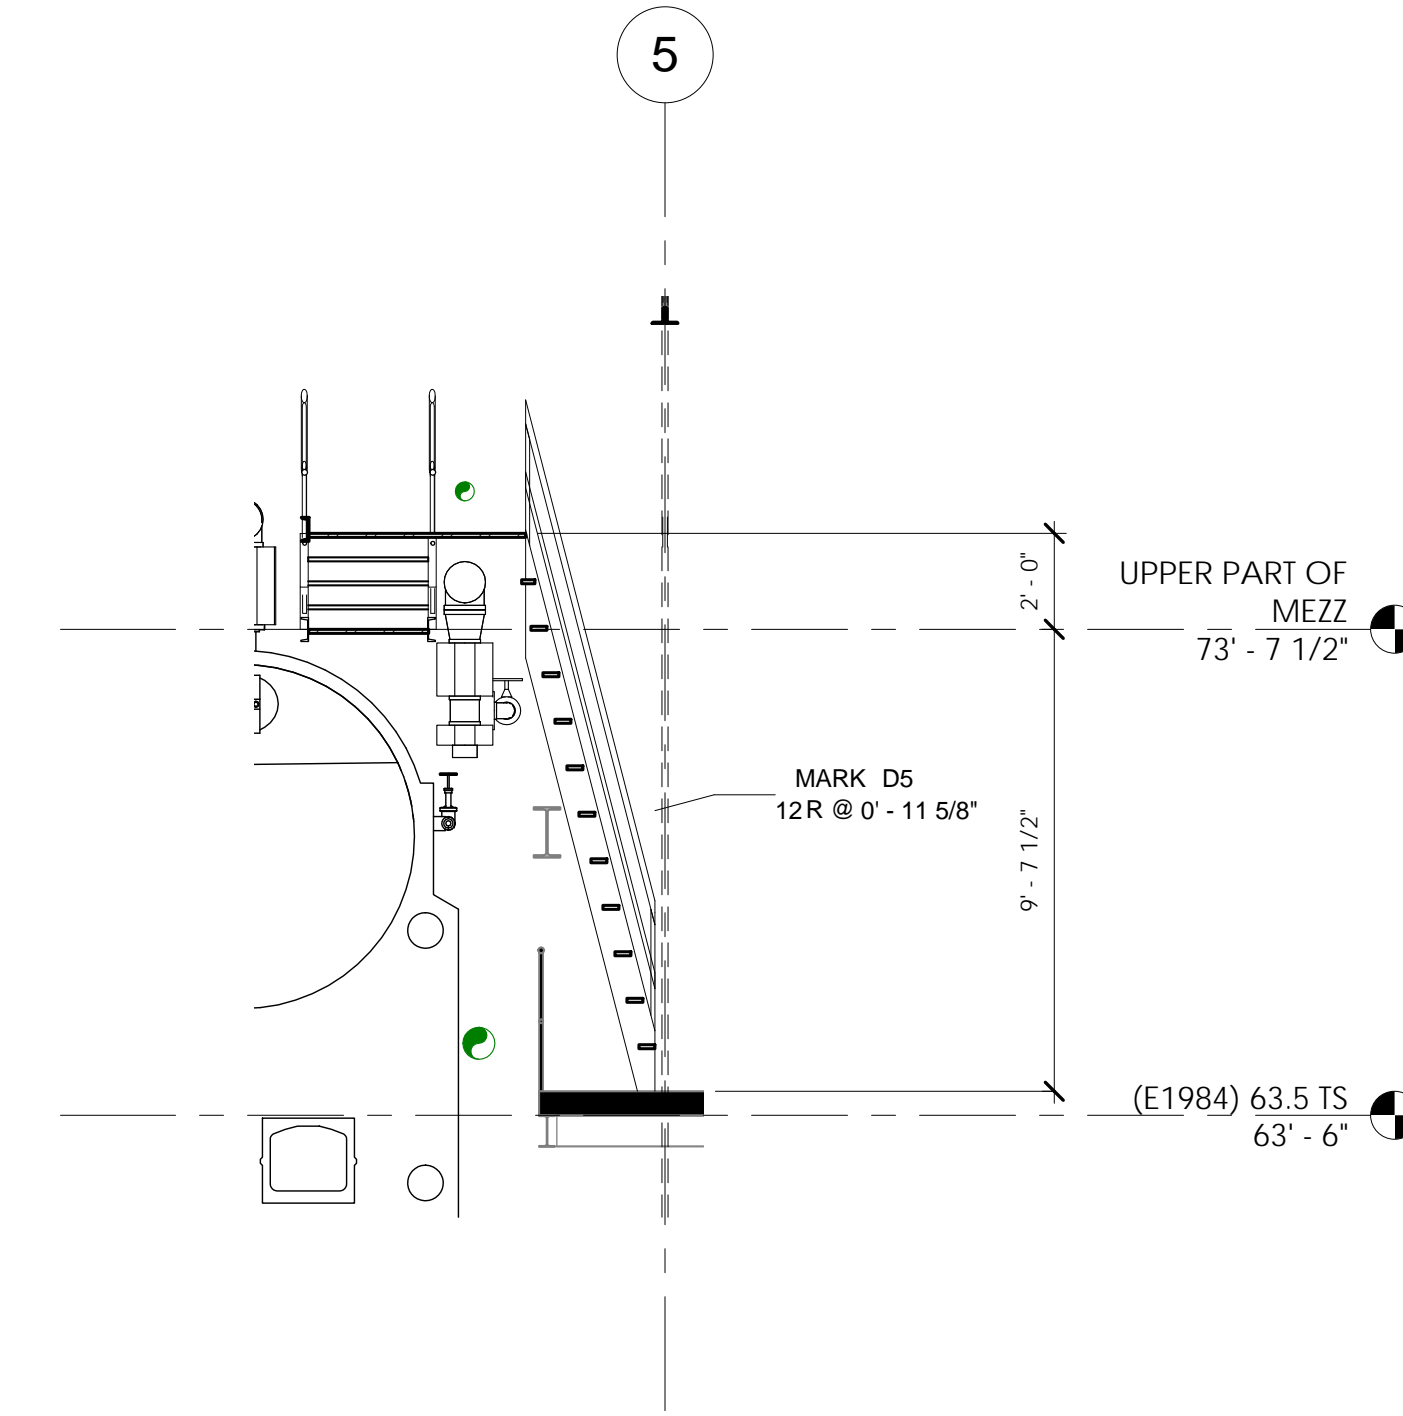


2 CATWALK SECTION 2
1/8" = 1'-0"

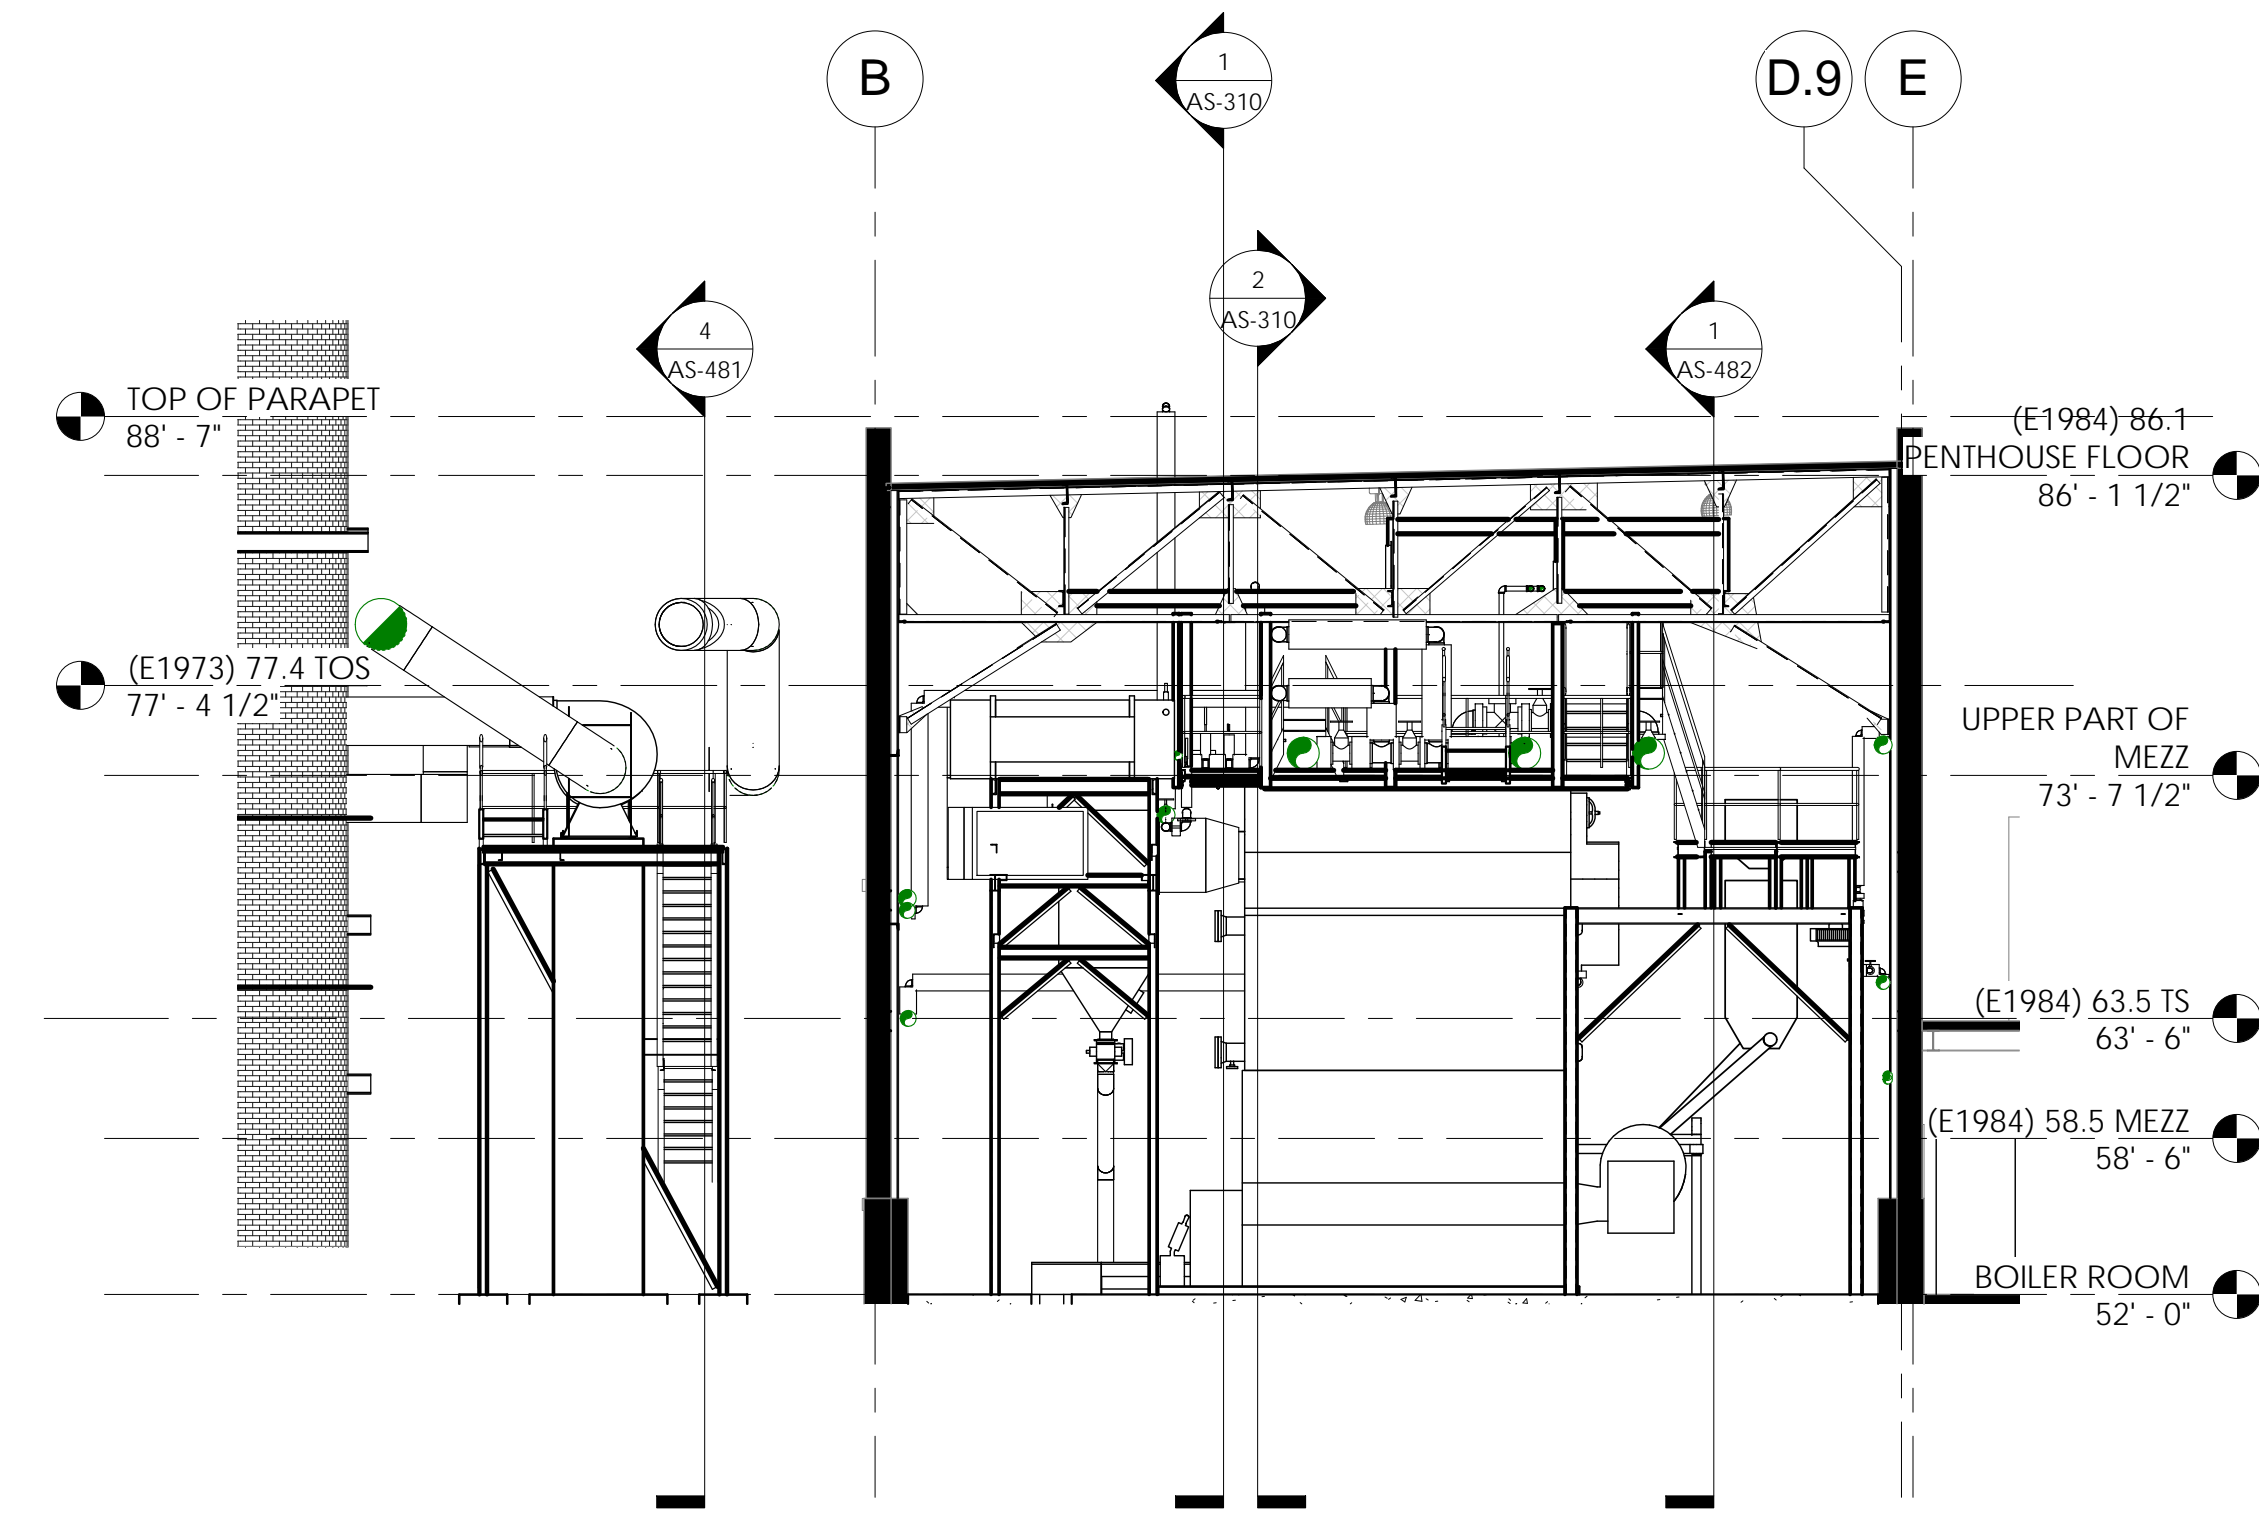


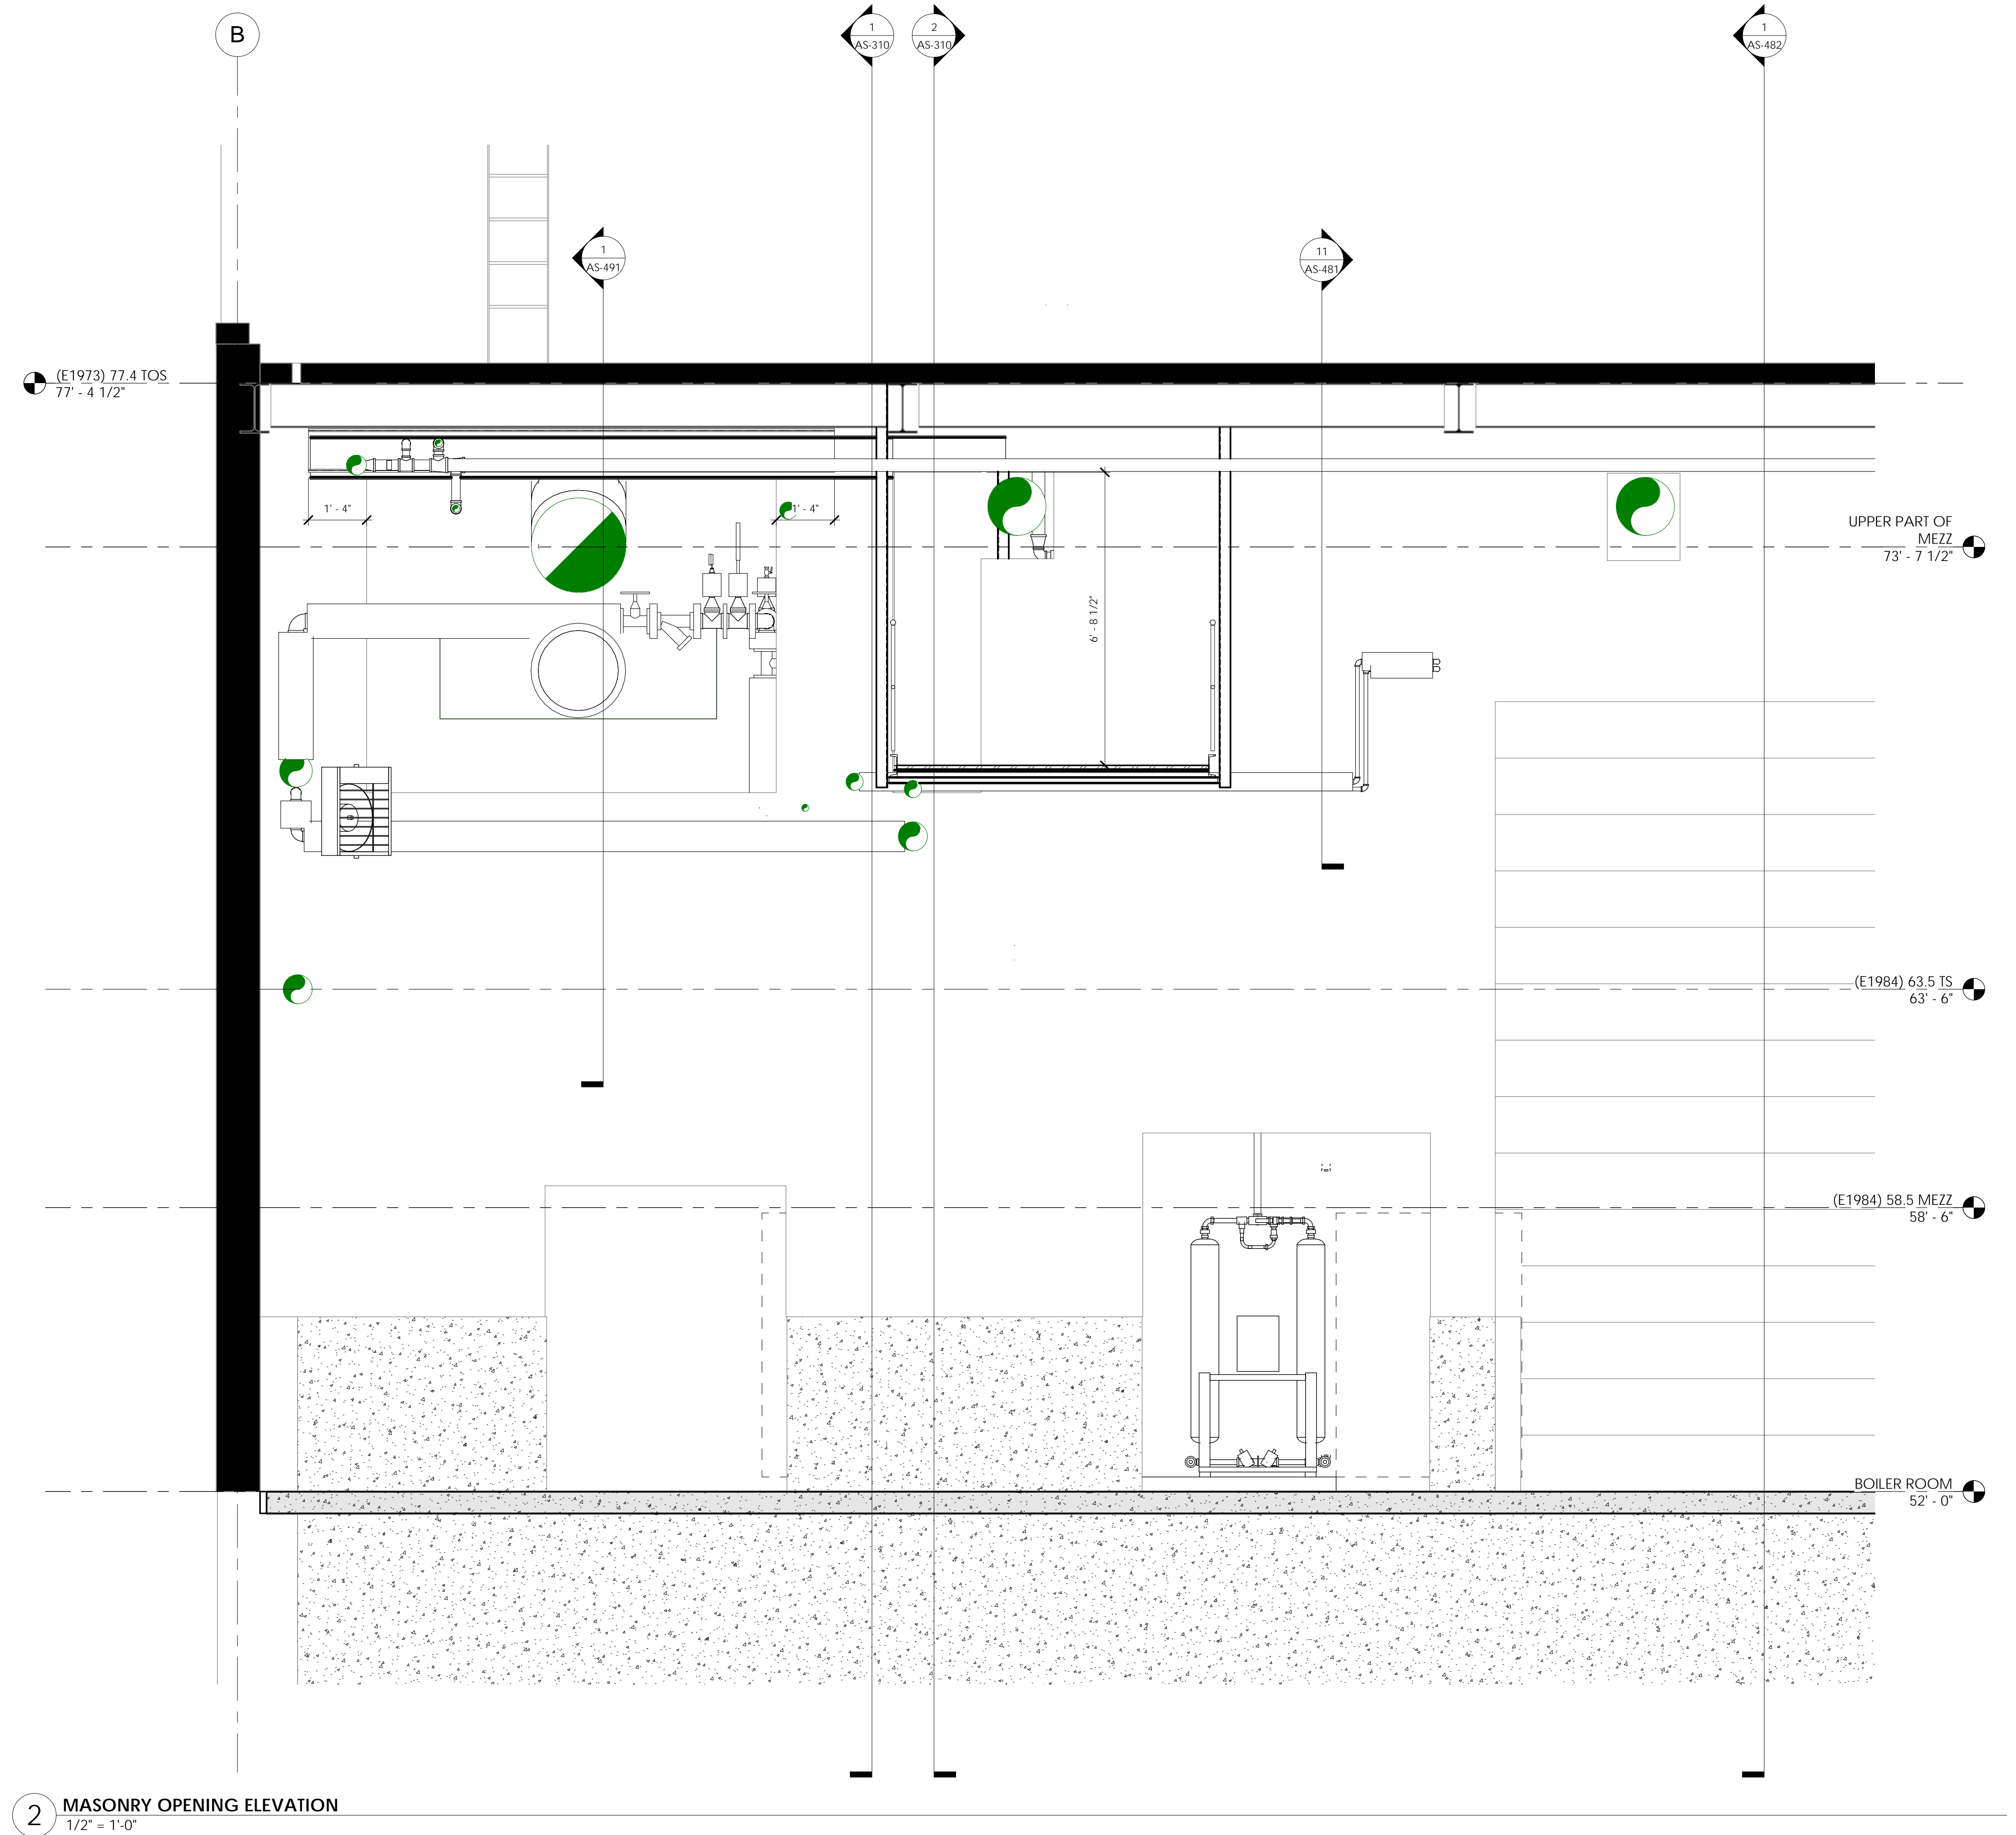

2 MASONRY OPENING ELEVATION
1/2" = 1'-0"

CONSULTANTS:		
MKK Consulting Engineers, Inc. 7600 East Orchard Road Suite 2505 Greenwood Village, CO 80111 Phone: 303.796.6000 Fax: 303.796.6099	Calibre 9090 S Ridgeline Blvd. Suite 105 Highlands Ranch, CO 80129 Phone: 303.730.0434 Fax: 303.730.1130	Structural Consultants Inc. 3400 E Bayaud Ave # 300 Denver, CO 80209-2929 Phone: 303.399.6154 Fax: 303.333.9501

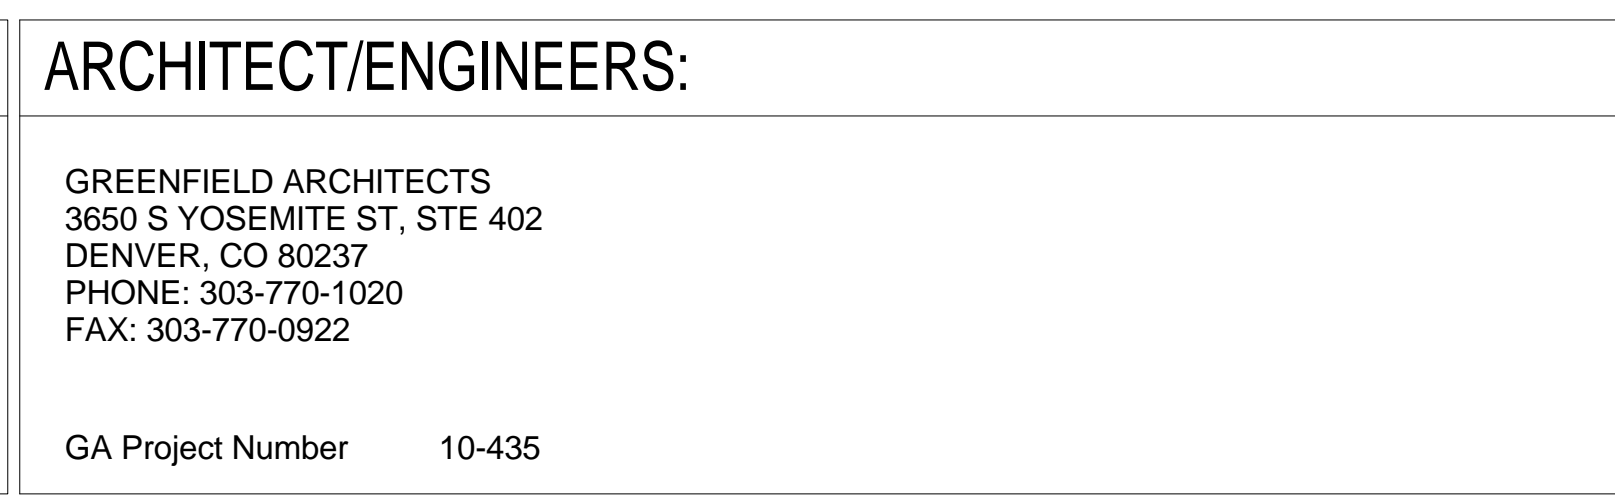

 Drawing Title		DESIGN DETAILS		Project Title -BOILER PLANT -REPLACEMENT -		Project Number - 666-11-101		Office of Construction and Facilities Management
						Building Number - 90		
Approved: Project Director JASON BROWN				Location - SHERIDAN, WY		Drawing Number AS-491		
				Date 12/15/2011 BIDDING & CNSTN	Checked JG	Drawn WS	Dwg. of --	
<div> Department of Veterans Affairs</div>								