


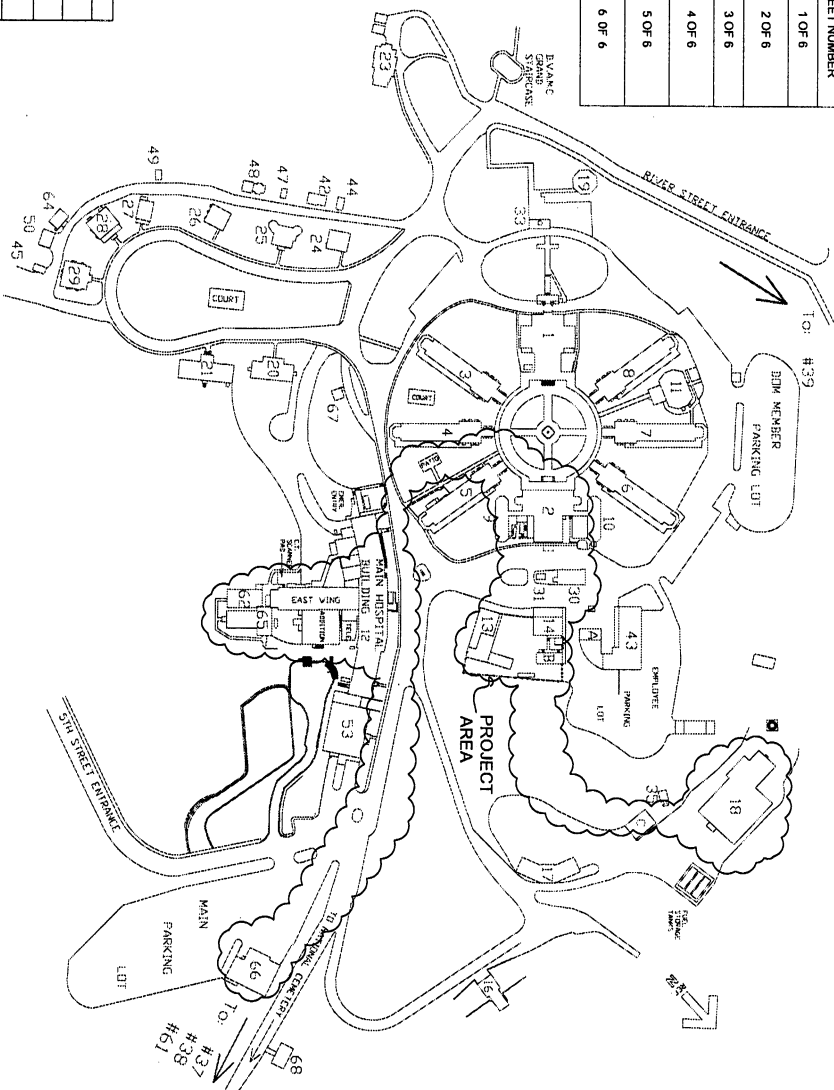

ASSESS/UPGRADE FIBER CABLE COMMUNICATIONS

PROJECT NO.: 568-12-207

DRAWING INDEX		
DRAWING NUMBER	TITLE	SHEET NUMBER
G-1	COVER SHEET	1 OF 6
C-1	PARTIAL SITE FIBER PLAN	2 OF 6
E-1	HOSPITAL BASEMENT LEVEL FIBER PLAN	3 OF 6
E-2	HOSPITAL GROUND, FIRST, SECOND, & THIRD LEVEL FIBER PLANS	4 OF 6
E-3	ARCADÉ BLDG. #1, & BLDG. B FIBER PLANS	5 OF 6
E-4	BLDG. #18 & #66 & #13 FIBER PLANS	6 OF 6

[illegible]



GENERAL CONTRACTOR SHALL BE RESPONSIBLE FOR GENERAL REGULATION INCLUDING EXCAVATION OF WALL FOOTINGS, STOPS & BRACKETS TO BE INSTALLED IN CONCRETE WALLS AND FOUNDATIONS. THE GENERAL CONTRACTOR SHALL BE RESPONSIBLE FOR THE PROTECTION OF ALL EXISTING UTILITIES AND STRUCTURES. THE GENERAL CONTRACTOR SHALL BE RESPONSIBLE FOR THE PROTECTION OF ALL EXISTING UTILITIES AND STRUCTURES. THE GENERAL CONTRACTOR SHALL BE RESPONSIBLE FOR THE PROTECTION OF ALL EXISTING UTILITIES AND STRUCTURES.

HOSPITAL B FIBER PLANN	Drawing Scale $1/8" = 1'-0"$
	Profr Scale $12" = 1'-0"$
Approved: Service Director	Approved: Division Chief

Location	BRAC'S V.A. MEDICAL CENTER 500 NORTH FIFTH STREET HOT SPRINGS, SD 57447
Date	3-19-2012
Checked	JH
Drawn	

568-12-207
Building Number
#12
DRAWING NO.
E-1





**Office of
Facilities
Management**

NUMBERED CONSTRUCTION NOTES

- [illegible]

GENERAL CONSTRUCTION NOTES:

1. CONSTITUTIONAL DUE PROCESS RIGHTS ARE VIOLATED BY THE STATE'S ENFORCEMENT OF A MANDATORY VOTING LAW THAT REQUIRES VOTERS TO VOTE IN PERSON AT A POLLING PLACE ON ELECTION DAY.
2. CONSTITUTIONAL DUE PROCESS RIGHTS ARE VIOLATED BY THE STATE'S ENFORCEMENT OF A MANDATORY VOTING LAW THAT REQUIRES VOTERS TO VOTE IN PERSON AT A POLLING PLACE ON ELECTION DAY.
3. CONSTITUTIONAL DUE PROCESS RIGHTS ARE VIOLATED BY THE STATE'S ENFORCEMENT OF A MANDATORY VOTING LAW THAT REQUIRES VOTERS TO VOTE IN PERSON AT A POLLING PLACE ON ELECTION DAY.
4. CONSTITUTIONAL DUE PROCESS RIGHTS ARE VIOLATED BY THE STATE'S ENFORCEMENT OF A MANDATORY VOTING LAW THAT REQUIRES VOTERS TO VOTE IN PERSON AT A POLLING PLACE ON ELECTION DAY.
5. CONSTITUTIONAL DUE PROCESS RIGHTS ARE VIOLATED BY THE STATE'S ENFORCEMENT OF A MANDATORY VOTING LAW THAT REQUIRES VOTERS TO VOTE IN PERSON AT A POLLING PLACE ON ELECTION DAY.
6. CONSTITUTIONAL DUE PROCESS RIGHTS ARE VIOLATED BY THE STATE'S ENFORCEMENT OF A MANDATORY VOTING LAW THAT REQUIRES VOTERS TO VOTE IN PERSON AT A POLLING PLACE ON ELECTION DAY.
7. CONSTITUTIONAL DUE PROCESS RIGHTS ARE VIOLATED BY THE STATE'S ENFORCEMENT OF A MANDATORY VOTING LAW THAT REQUIRES VOTERS TO VOTE IN PERSON AT A POLLING PLACE ON ELECTION DAY.
8. CONSTITUTIONAL DUE PROCESS RIGHTS ARE VIOLATED BY THE STATE'S ENFORCEMENT OF A MANDATORY VOTING LAW THAT REQUIRES VOTERS TO VOTE IN PERSON AT A POLLING PLACE ON ELECTION DAY.
9. CONSTITUTIONAL DUE PROCESS RIGHTS ARE VIOLATED BY THE STATE'S ENFORCEMENT OF A MANDATORY VOTING LAW THAT REQUIRES VOTERS TO VOTE IN PERSON AT A POLLING PLACE ON ELECTION DAY.
10. CONSTITUTIONAL DUE PROCESS RIGHTS ARE VIOLATED BY THE STATE'S ENFORCEMENT OF A MANDATORY VOTING LAW THAT REQUIRES VOTERS TO VOTE IN PERSON AT A POLLING PLACE ON ELECTION DAY.

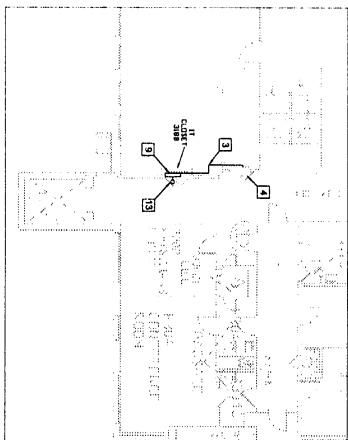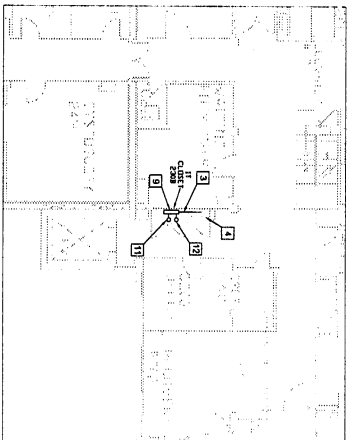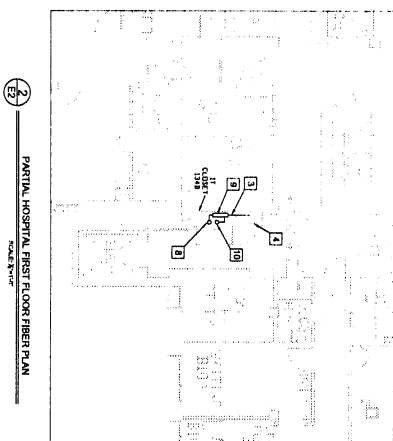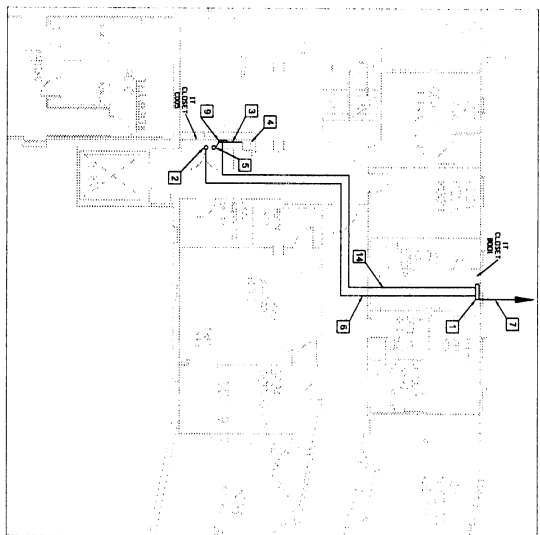

- NUMBERED CONSTRUCTION NOTES:**

 1. APPROVED BY: [REDACTED] DATE: 01/04/2017
 2. ONE (1) UNIT 1101A OF 18 APARTMENTS, UNITS 1101A1 TO 1101A2, LOCATED AT 1101A, 1101A1 AND 1101A2, 1101A3, 1101A4, 1101A406, 1101A4

GENERAL
NOTES:

[illegible]

Drawing: 1114
HOSPITAL GROUND, 1st,
3rd LEVEL FIBER PLANS

Project Title
ASSESS/UPGRADE
FIBER CABLES

Project No.	568-12-207
Building Number	812

**Office of
Facilities**

PLAN NORTH


Drawing Scale	$1/8" = 1'-0"$
Plot Scale	$12" = 1'-0"$

Approved: Division Chief


Location	BRIMCS V.A. METER 500 NORTH FIRST HOT SPRINGS, AR
Date	3-19-2012

DRAWING NO.
E-2

Management

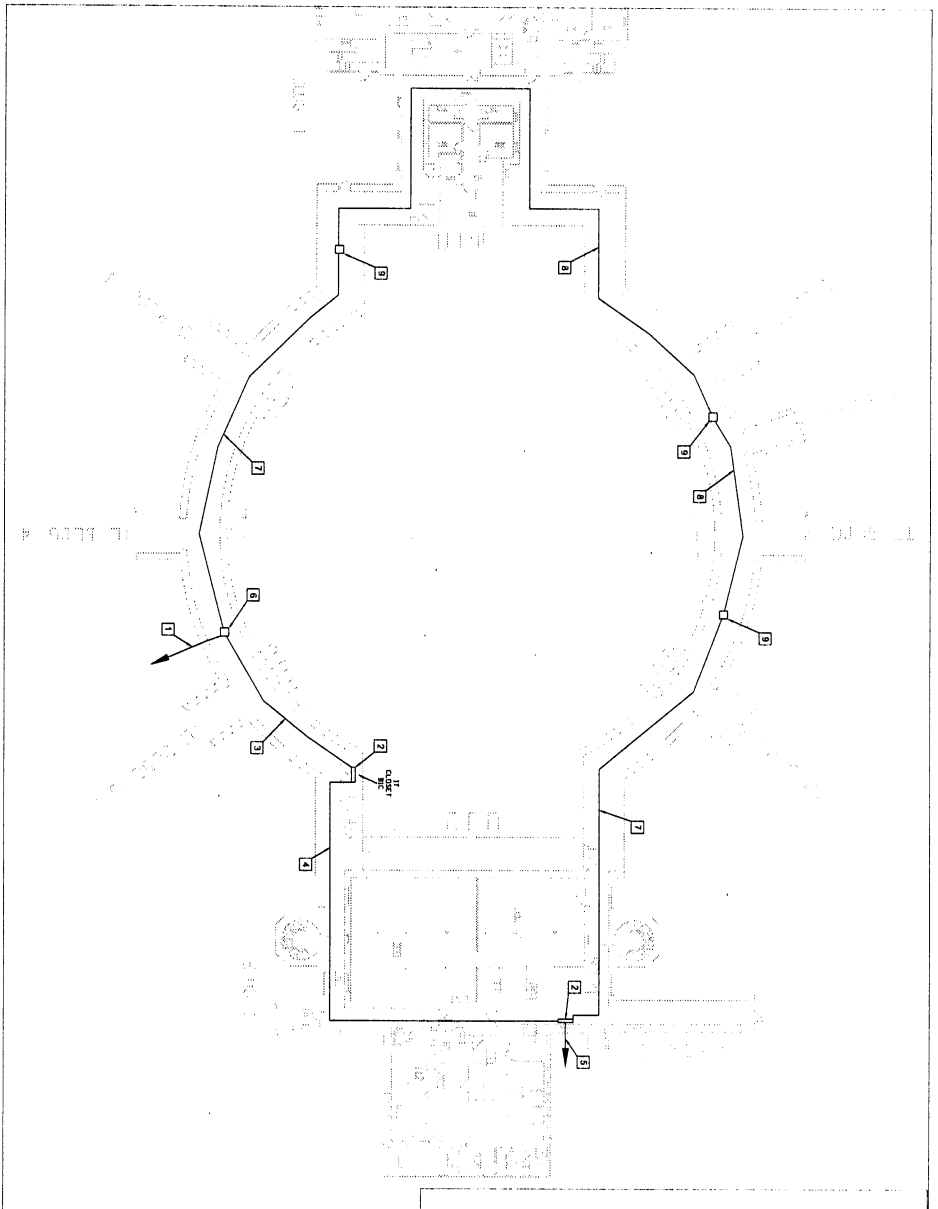

1 PARTIAL ARCADE BASEMENT LEVEL FIBER PLAN
SCALE: 1/8" = 1'-0"

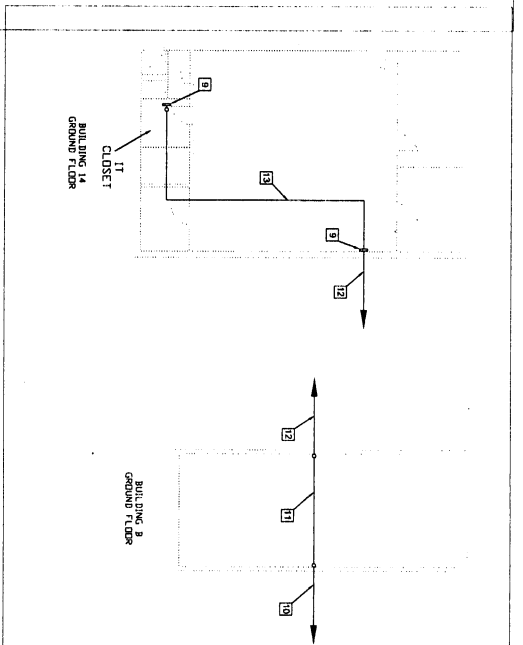


2 BLDG. #14 & B. GROUND LEVEL FIBER PLAN
SCALE: 1/8" = 1'-0"


NUMBERED CONSTRUCTION NOTES:

1. SEE SITE PLAN FOR THE LOCATION OF THE CLOSET. SEE SITE PLAN FOR THE LOCATION OF THE CLOSET.
2. SEE SITE PLAN FOR THE LOCATION OF THE CLOSET. SEE SITE PLAN FOR THE LOCATION OF THE CLOSET.
3. SEE SITE PLAN FOR THE LOCATION OF THE CLOSET. SEE SITE PLAN FOR THE LOCATION OF THE CLOSET.
4. SEE SITE PLAN FOR THE LOCATION OF THE CLOSET. SEE SITE PLAN FOR THE LOCATION OF THE CLOSET.
5. SEE SITE PLAN FOR THE LOCATION OF THE CLOSET. SEE SITE PLAN FOR THE LOCATION OF THE CLOSET.
6. SEE SITE PLAN FOR THE LOCATION OF THE CLOSET. SEE SITE PLAN FOR THE LOCATION OF THE CLOSET.
7. SEE SITE PLAN FOR THE LOCATION OF THE CLOSET. SEE SITE PLAN FOR THE LOCATION OF THE CLOSET.
8. SEE SITE PLAN FOR THE LOCATION OF THE CLOSET. SEE SITE PLAN FOR THE LOCATION OF THE CLOSET.
9. SEE SITE PLAN FOR THE LOCATION OF THE CLOSET. SEE SITE PLAN FOR THE LOCATION OF THE CLOSET.
10. SEE SITE PLAN FOR THE LOCATION OF THE CLOSET. SEE SITE PLAN FOR THE LOCATION OF THE CLOSET.
11. SEE SITE PLAN FOR THE LOCATION OF THE CLOSET. SEE SITE PLAN FOR THE LOCATION OF THE CLOSET.
12. SEE SITE PLAN FOR THE LOCATION OF THE CLOSET. SEE SITE PLAN FOR THE LOCATION OF THE CLOSET.
13. SEE SITE PLAN FOR THE LOCATION OF THE CLOSET. SEE SITE PLAN FOR THE LOCATION OF THE CLOSET.

GENERAL NOTES: GENERAL CONSTRUCTION AND/OR ALL INFORMATION SHALL BE THE PROPERTY OF THE ARCHITECT. THE ARCHITECT SHALL BE RESPONSIBLE FOR THE ACCURACY OF THE INFORMATION PROVIDED. THE ARCHITECT SHALL BE RESPONSIBLE FOR THE ACCURACY OF THE INFORMATION PROVIDED. THE ARCHITECT SHALL BE RESPONSIBLE FOR THE ACCURACY OF THE INFORMATION PROVIDED.	
DATE:	
PROJECT TITLE: ARCADE & BUILDING #14 & BUILDING B FIBER PLANS	
DESIGNER: 1/2" = 1'-0" 1/2" = 1'-0"	APPROVED: [Signature] [Title]
DATE: 1-10-2017	DATE: 1-10-2017
PROJECT NO.: 060-17-2017	PROJECT NO.: 060-17-2017
ARCHITECT: ARCH. #14 & B	ARCHITECT: ARCH. #14 & B
ENGINEER: E-3	ENGINEER: E-3
Office of Facilities Management 1000 14th St. N. Minneapolis, MN 55403	

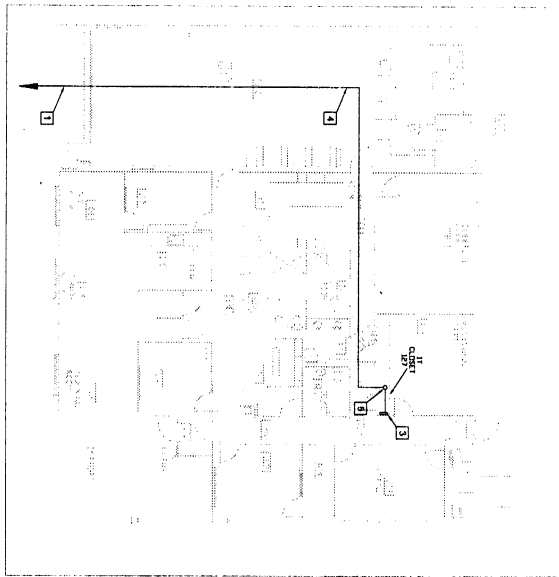


BUILDING #66 FIBER PLAN
SCALE 1/4" = 1'-0"

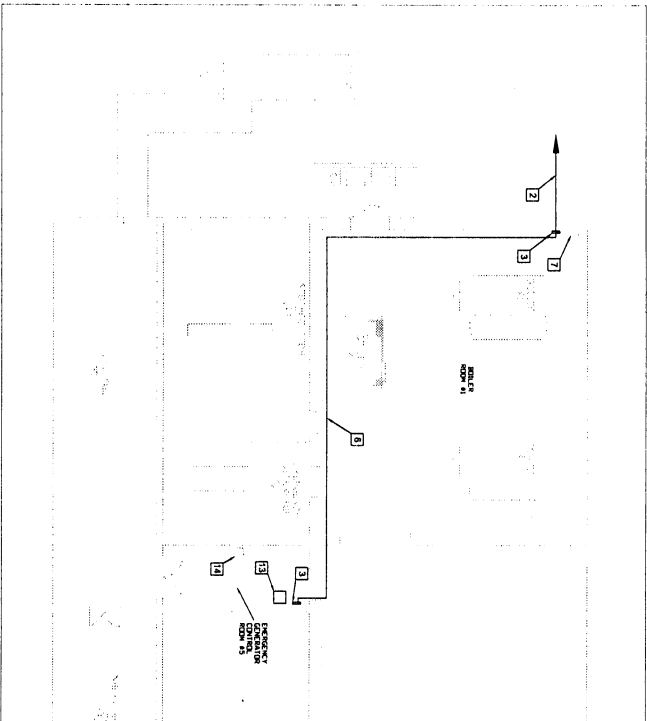

2
E4

PARTIAL BUILDING #18 FIBER PLAN

SCALE: 1/8"=1'-0"

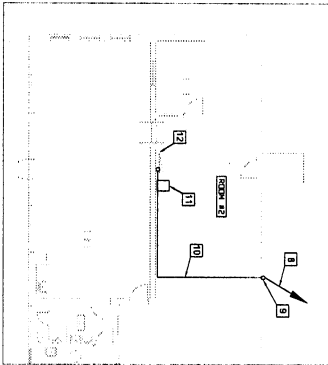

3
E4

PARTIAL BUILDING #13 FIBER PLAN

SCALE 3/4" = 1'-0"

- [illegible]

**GENERAL
NOTES:**

[illegible]

**BUILDINGS #18 & #66 & #13
FIBER PLANS**

ASSESS/UPGRADE FIBER CABLES

Project No.
568-12-207

Building Number
#18, #66, & #13

**Office of
Facilities
Management**



PLAN NORTH

Phot Scale
12" = 1' @ 0"

Approved: Service Director

Date 3-19-2017

Checked	Drawn
114	MM

1
 2
 3
 525

ST	L
ST-100	100
ST-101	101
ST-102	102
ST-249	249
ST-250	