


three inches = one foot



one and one-half inches = one foot

one inch = one foot

three-quarters inch = one foot





one-half inch = one foot

three-eighths inch = one foot

one-quarter inch = one foot



one-eighth inch = one foot

0 4 8 16

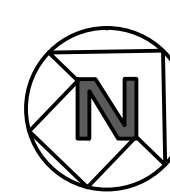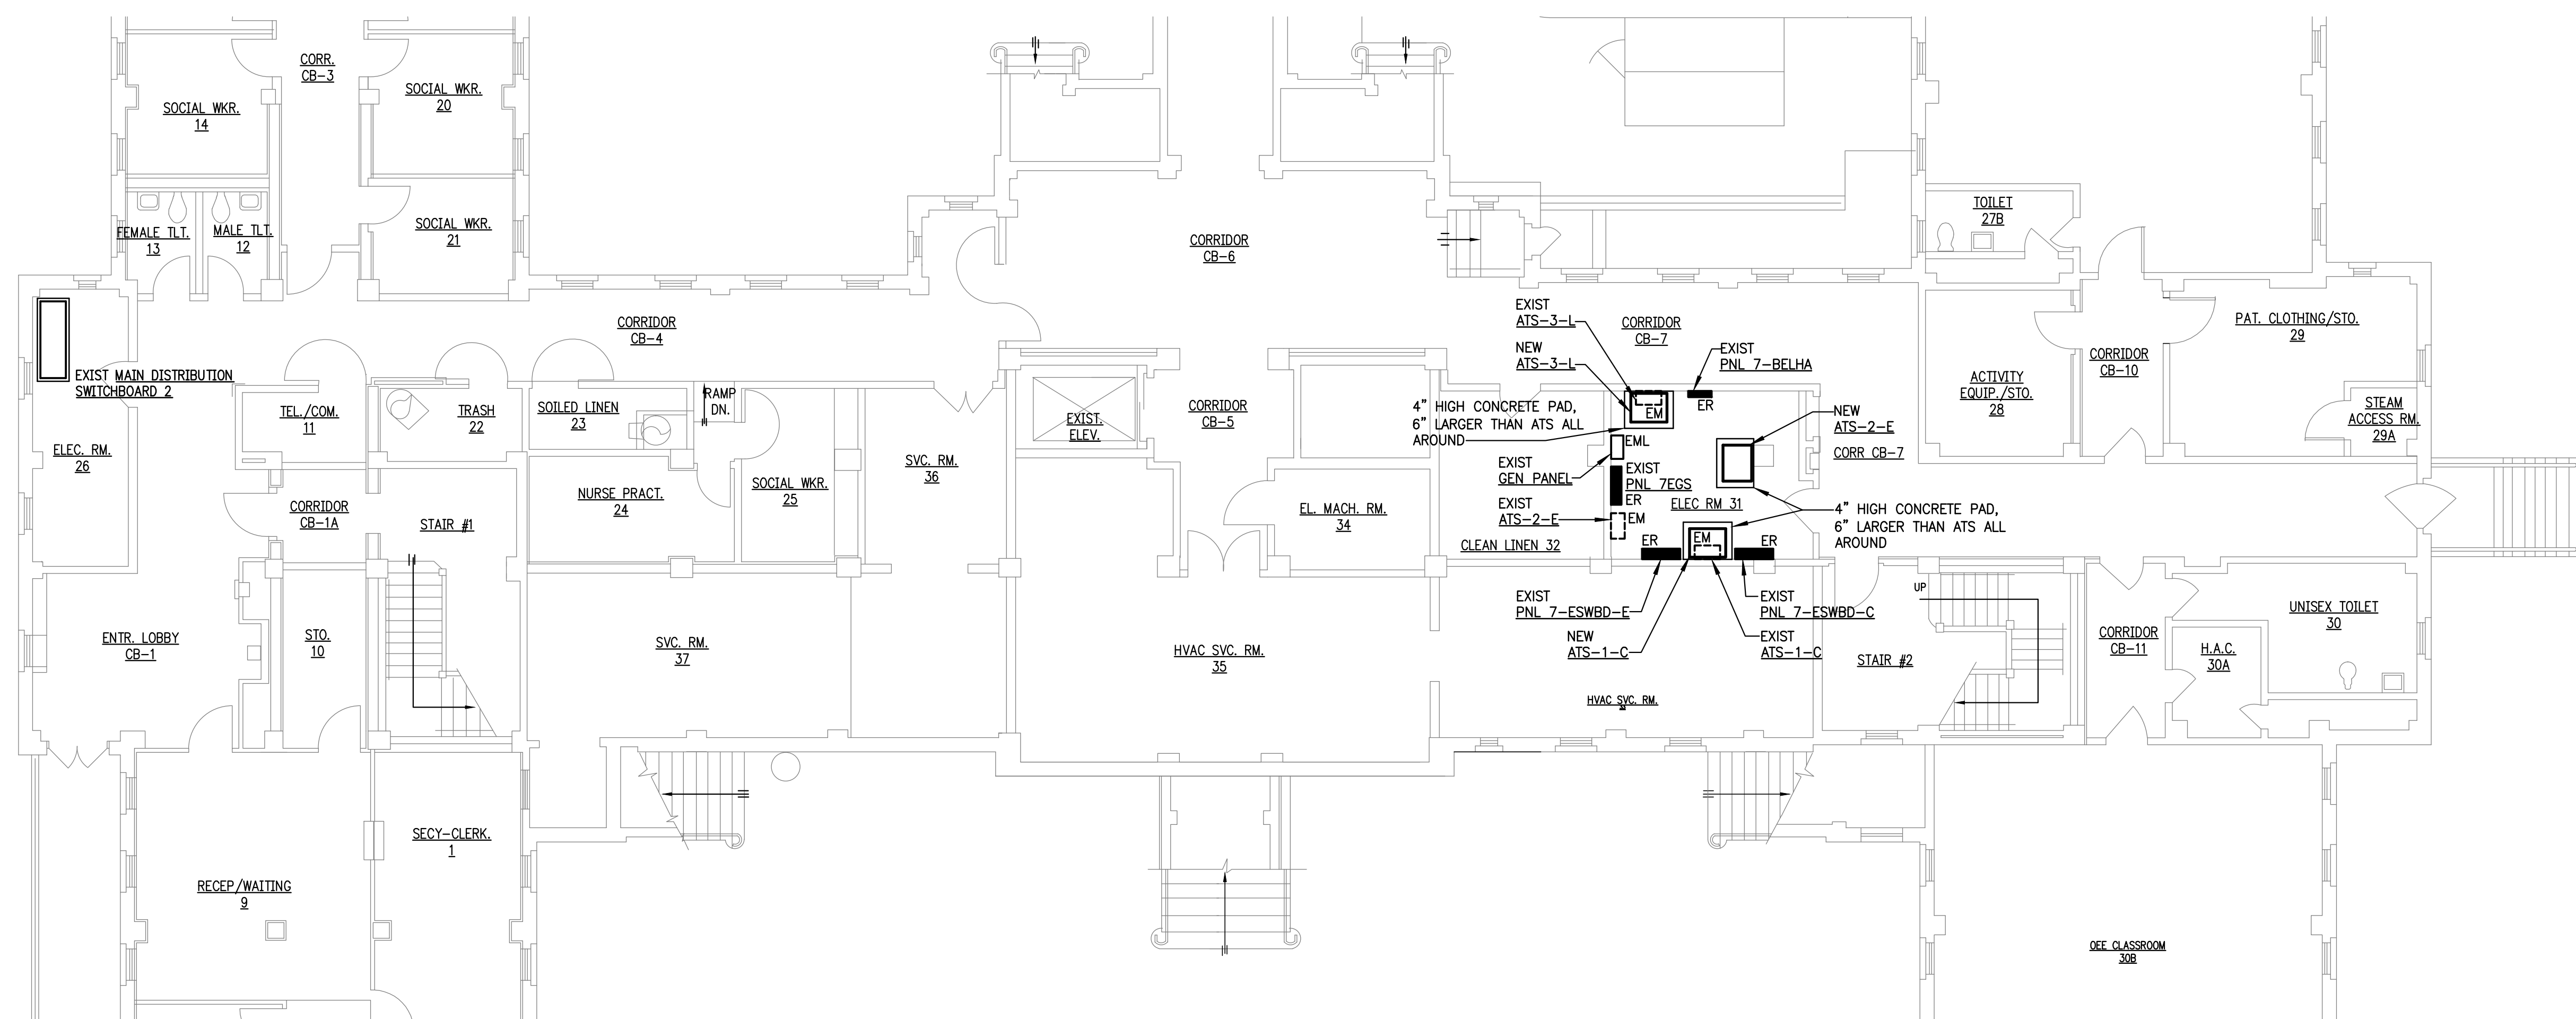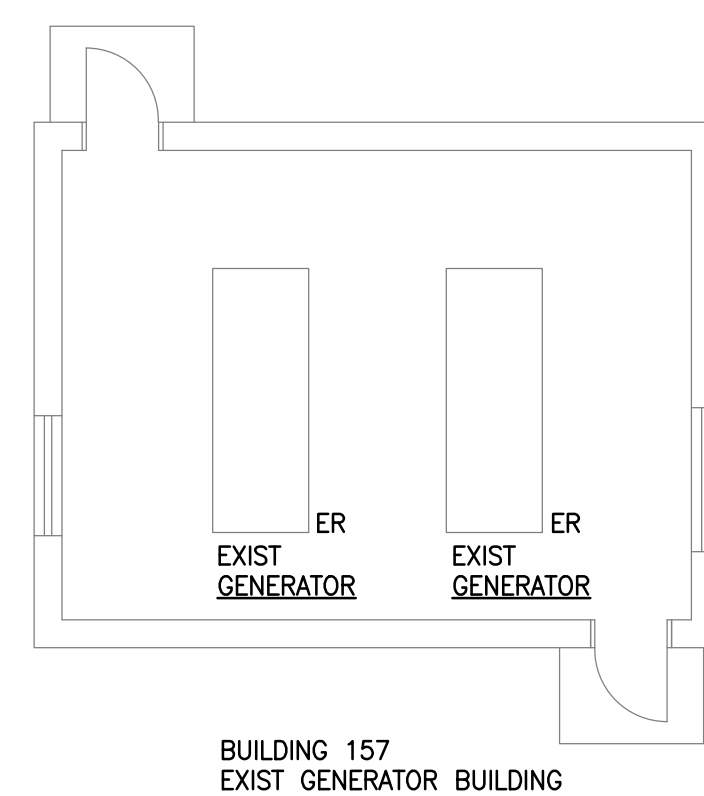

BLDG 7 AND GEN BLDG 157
PARTIAL BASEMENT FLOOR PLAN - POWER



SCALE: 1/8" = 1'-0"

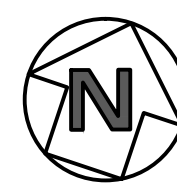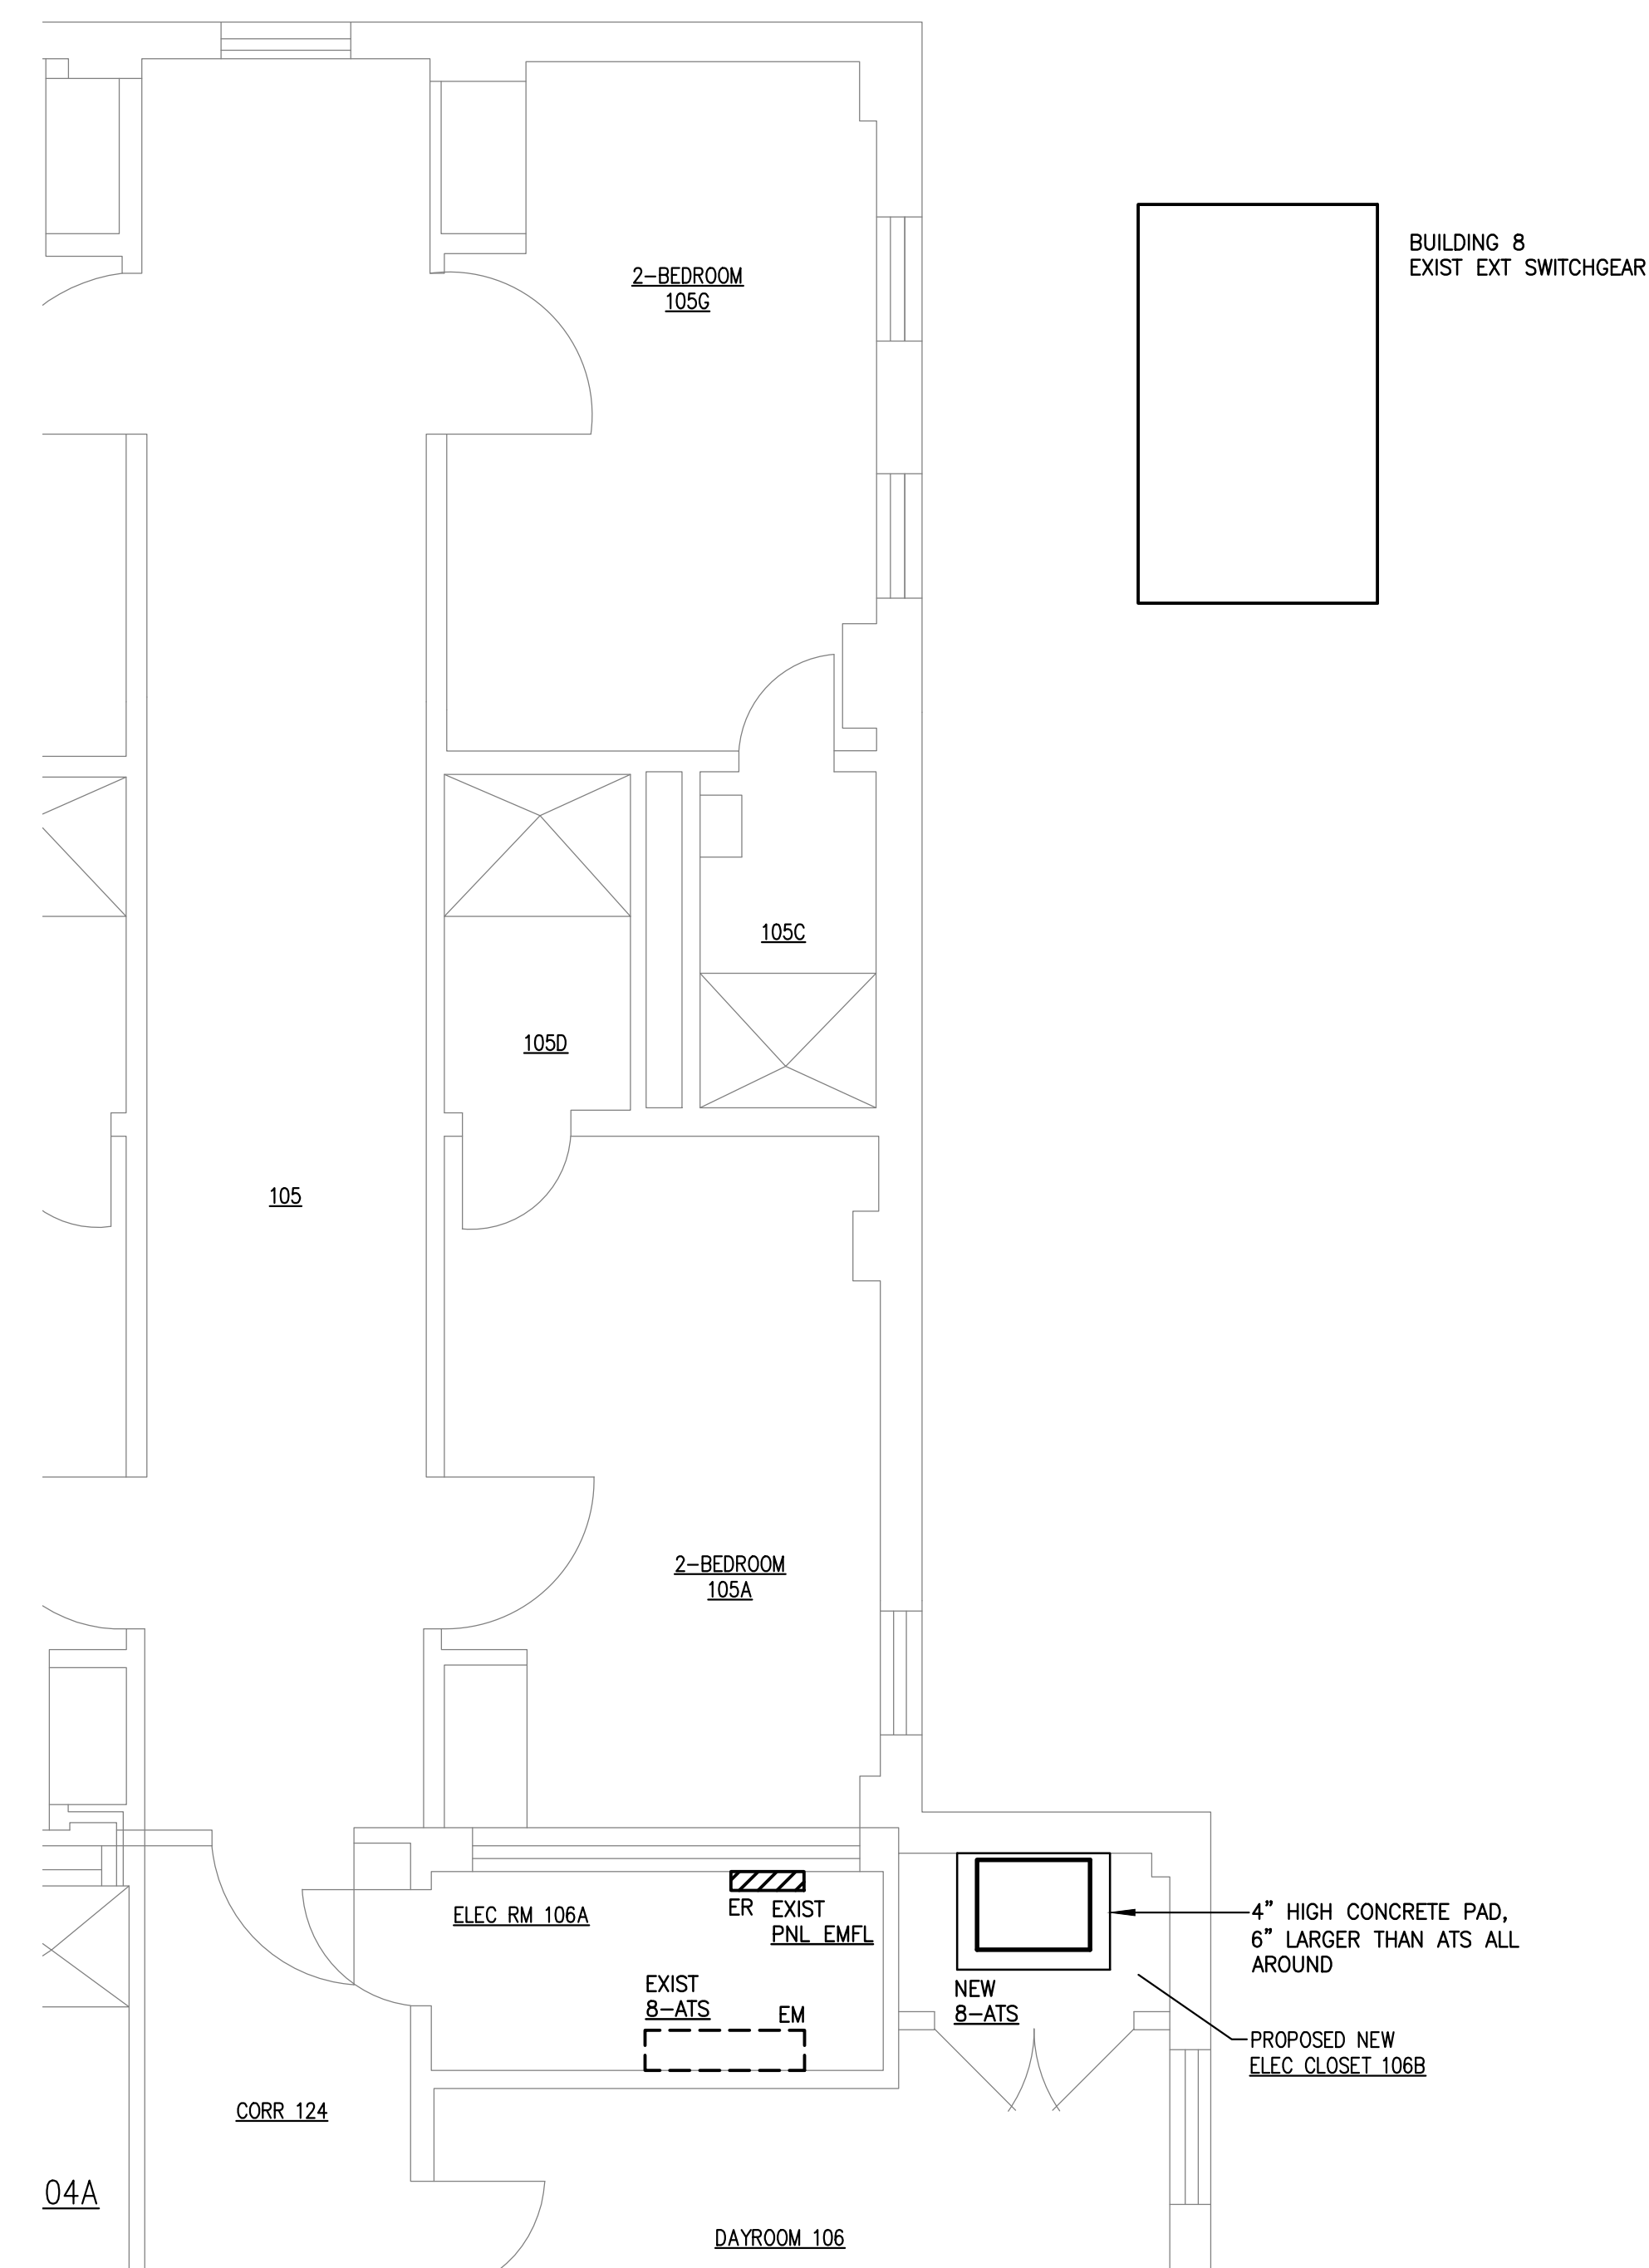

BLDG 8 AND GEN BLDG 138
PARTIAL FIRST FLOOR PLAN – POWER



SCALE: $1/4'' = 1'-0''$

BUILDING 138
EXIST GENERATOR BUILDING

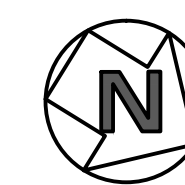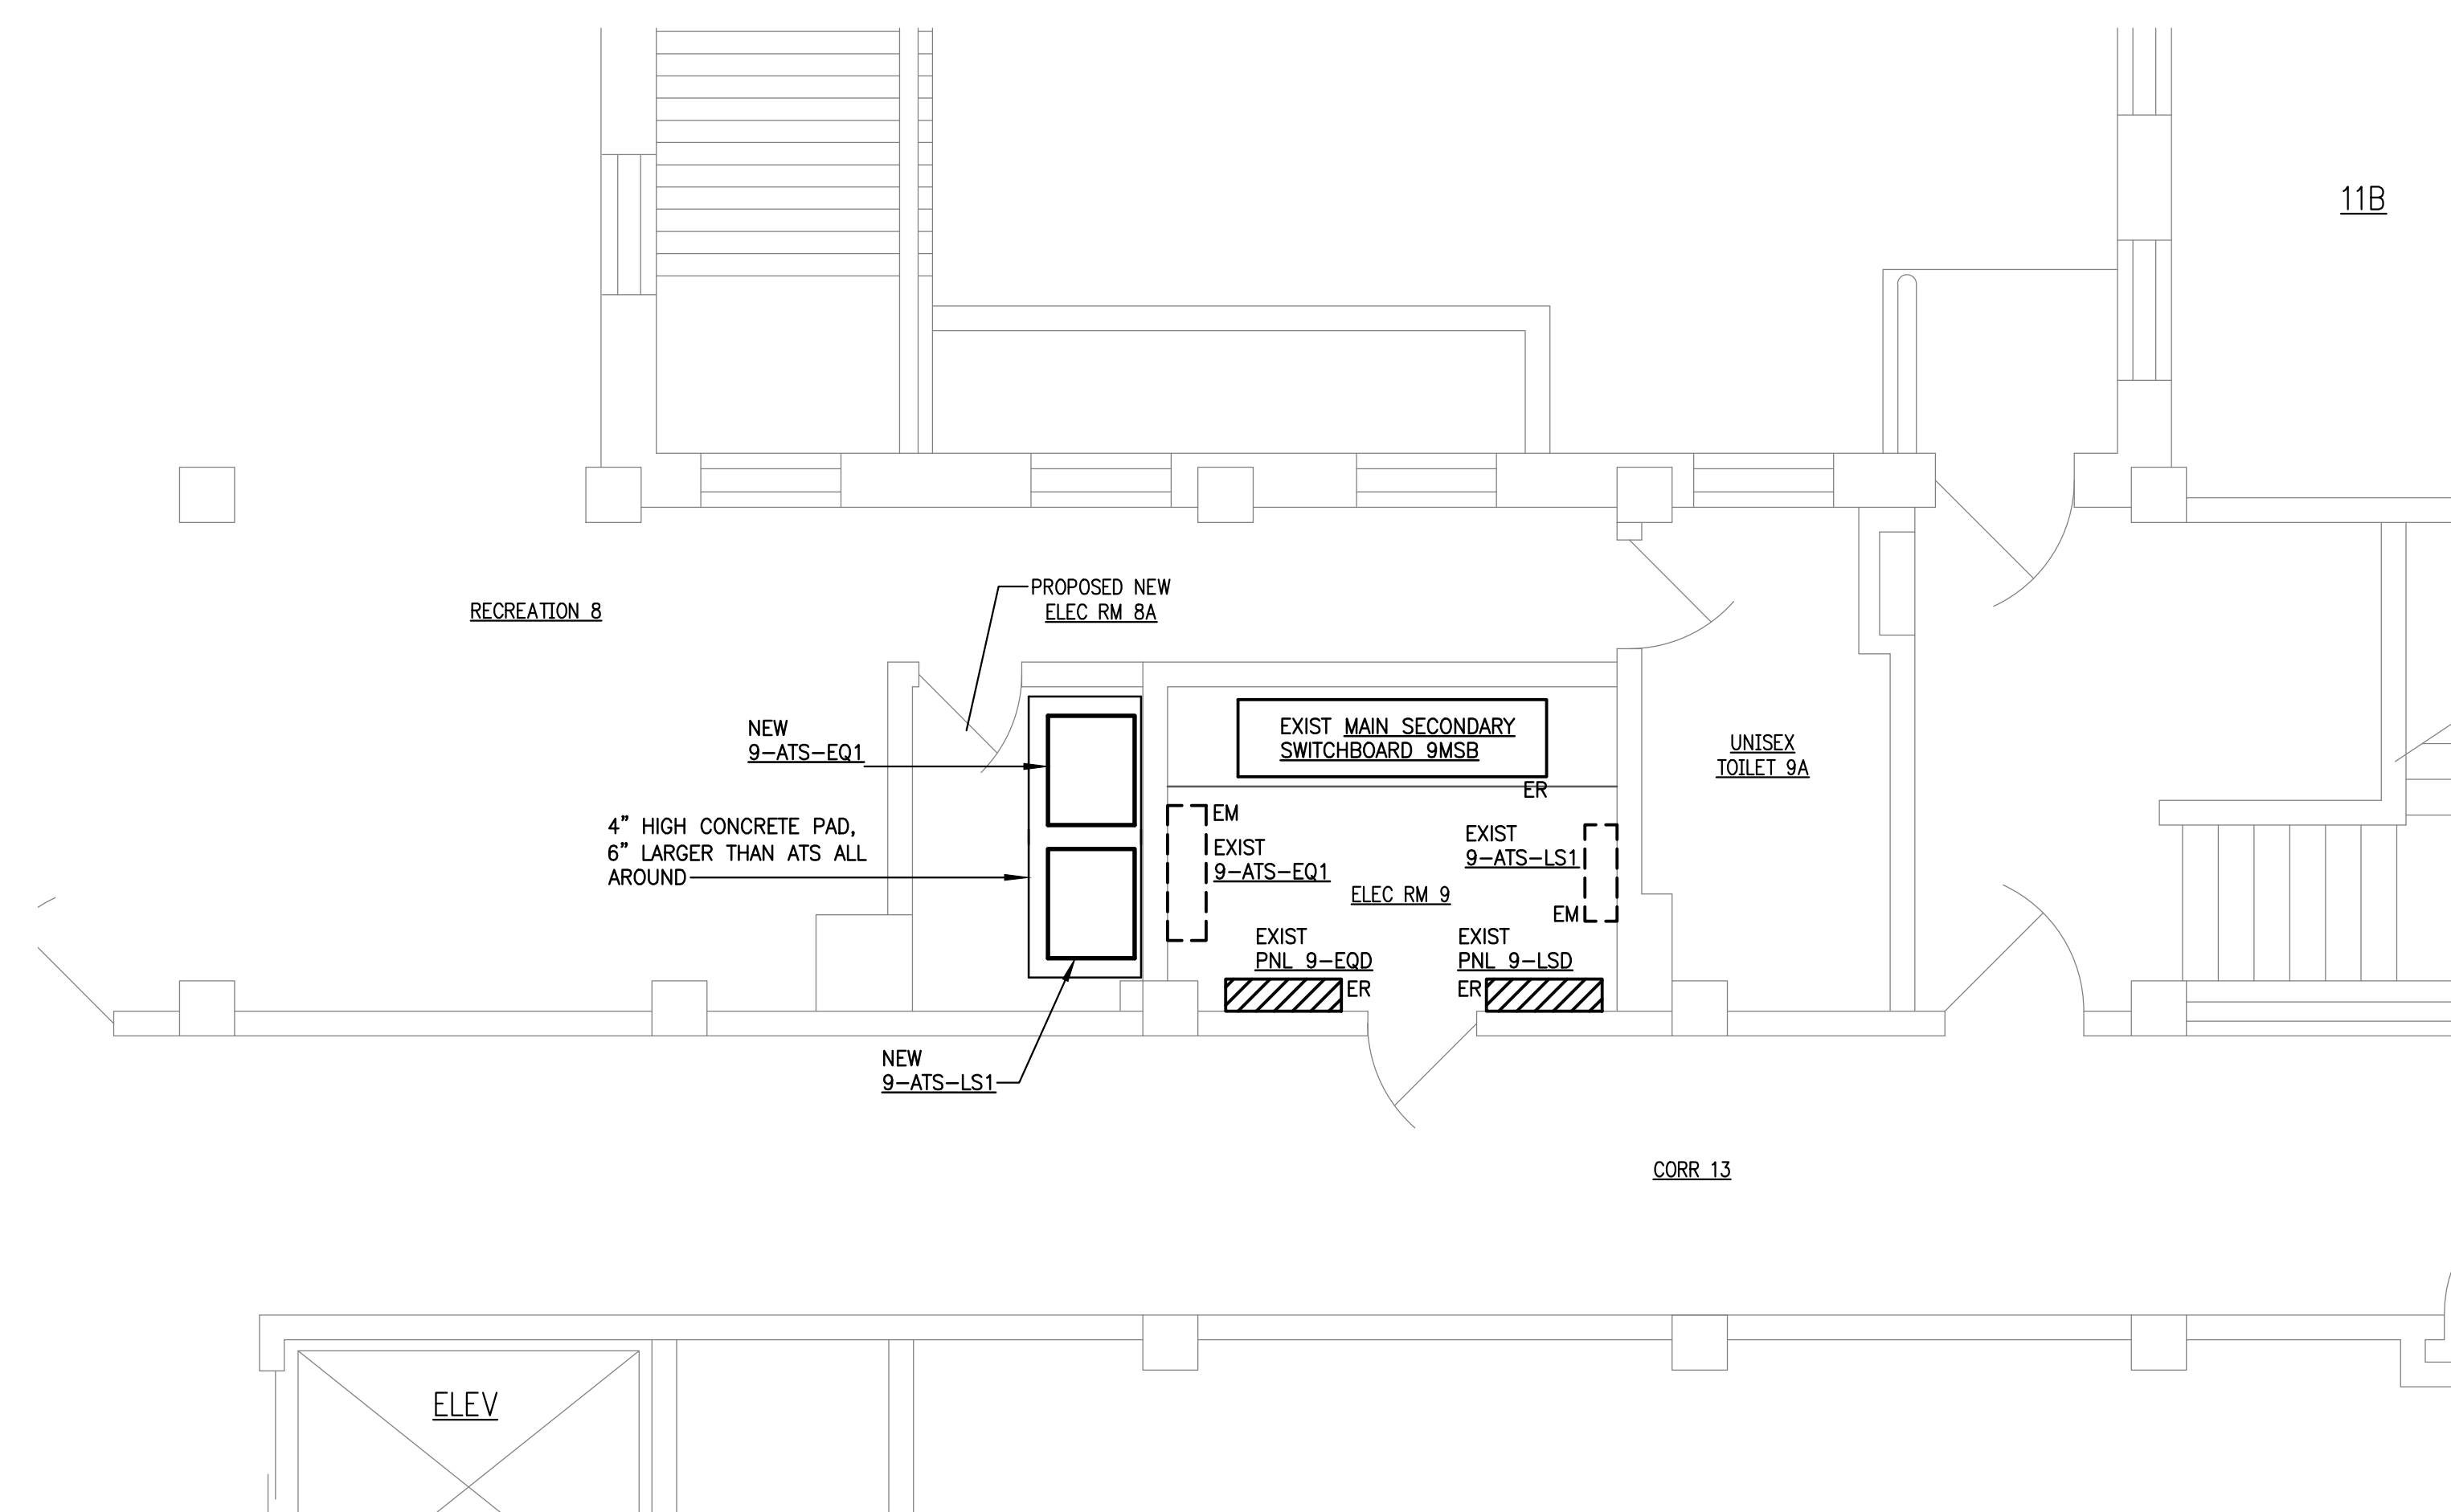

BLDG 9
PARTIAL BASEMENT FLOOR PLAN – POWER

  SCALE: 1/4" = 1'-0"

								APPROVED: Energy Engineer		APPROVED: Safety Manager		APPROVED: Service Chief		DRAWING TITLE BUILDINGS 7, 8, 9, 138 AND 157 PARTIAL FLOOR PLANS - POWER		PROJECT TITLE UPGRADE ELECTRICAL SYSTEM (REPLACE ATS)		DATE 02-17-12					
										APPROVED: Infection Control Officer		APPROVED: Chief of Staff		APPROVED: Chief of Facility Management Svc.		BUILDING NUMBER 7, 8, 9, 138 AND 157		CHECKED NAC		DRAWN WDC/RGW		PROJECT NO. 658-12-106	
REVISIONS		BY		DATE						APPROVED: GEMS Coordinator		APPROVED: Associate Director		APPROVED: Medical Center Director		LOCATION V.A.M.C. SALEM, VA. 24153		DRAWING NO. ES 5		DWG. 6 OF 13		Veterans Affairs	

Veterans Affairs