


Fisher House Foundation, Inc.

- LEGEND
- STAIRS AND ELEVATORS
 - WALLS OF TRUCK AND FIRE RIGS
 - FIRE RATED PARTITIONS
 - FIRE RATED PARTITIONS
 - FIRE RATED PARTITIONS
 - ELECTRICAL PANEL
 - ELECTRICAL PANEL
 - ELECTRICAL PANEL

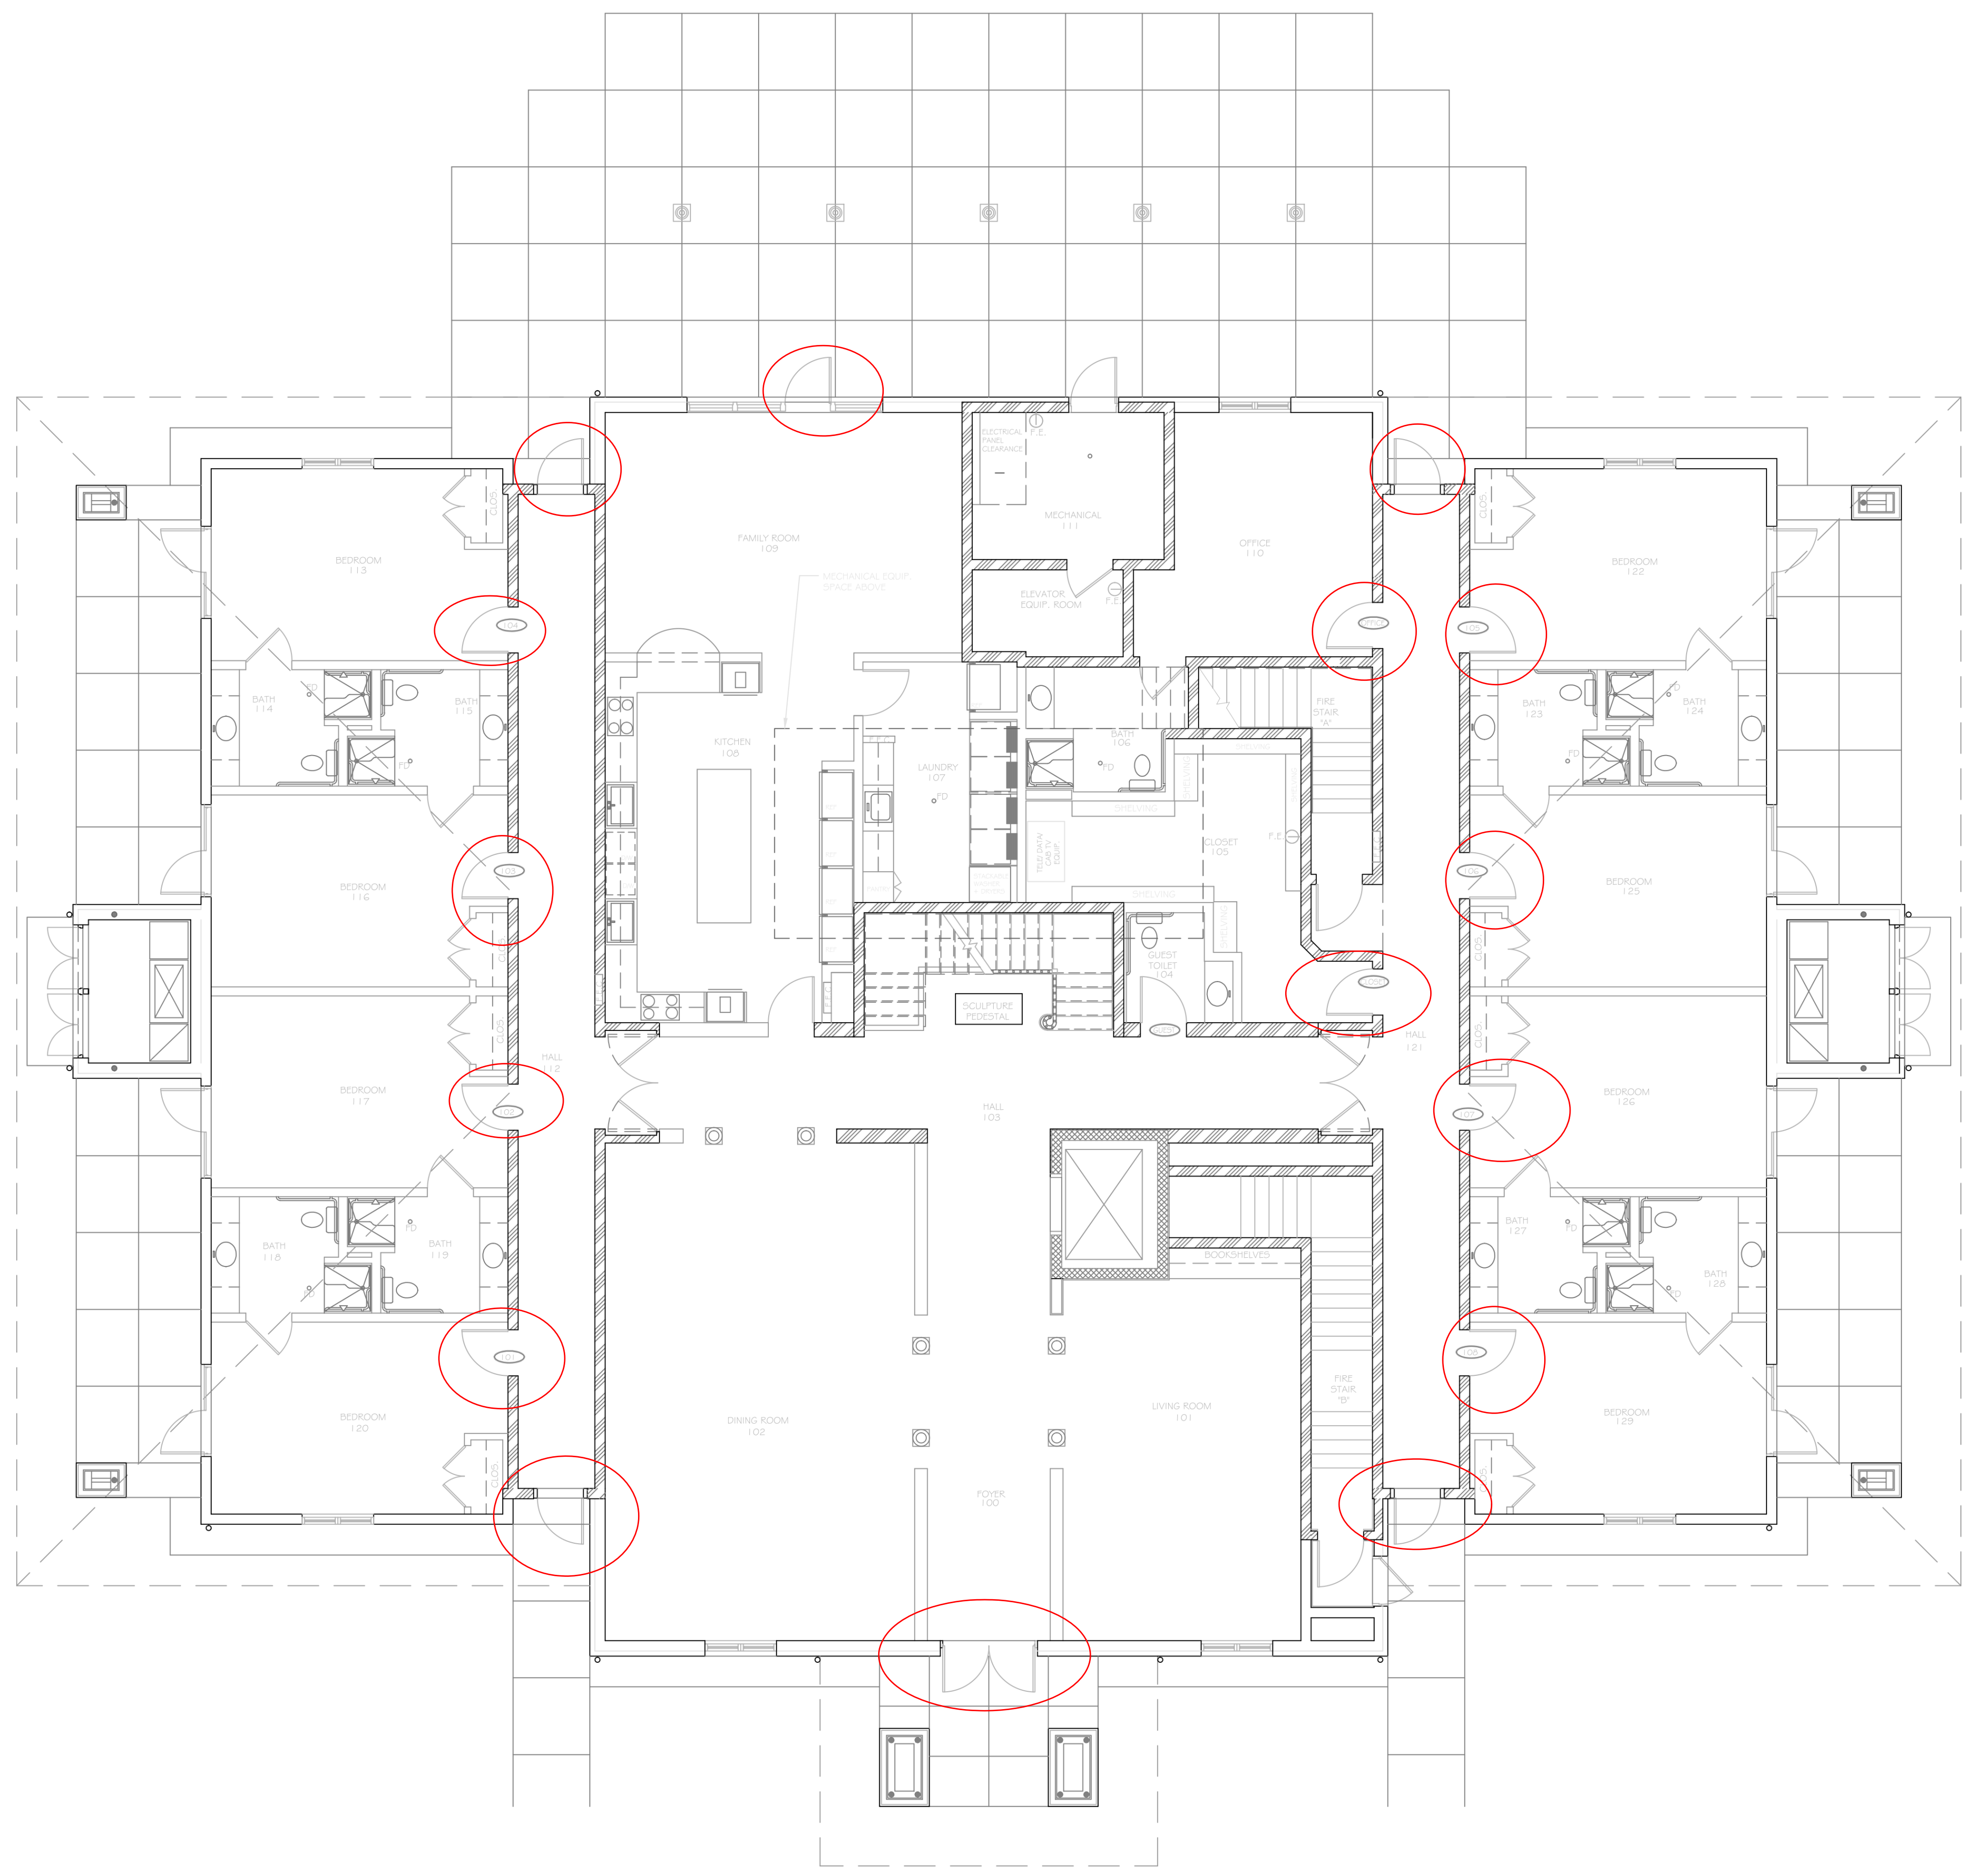

REVISION	DATE	DESCRIPTION
PROJECT		
PROPOSED FISHER HOUSE VA MEDICAL CENTER LAS VEGAS, NV		
DRAWING		
FIRST FLOOR PLAN		
SCALE	FLOOR	DRAWING No.
1/4"=1'-0"	1	A-1
DATE		
1/4"=1'-0"		

DESIGNER ASSOCIATES ARCHITECTS LEADERS 400 BROADWAY NEW YORK, NY 10018