



TENNESSEE VALLEY HEALTHCARE SYSTEM

MURFREESBORO CAMPUS



BUILDING 6

REPLACEMENT OF ATTIC AIR HANDLING UNITS

6 - CS	COVER SHEET
ASBESTOS ABATEMENT	
6 - AB 1	ASBESTOS ABATEMENT PLAN
ARCHITECTURAL	
6 - A 1	DEMOLITION FLOOR PLAN
6 - A 2	NEW WORK FLOOR PLAN
6 - A 3	PARTIAL EXTERIOR ELEVATIONS AND DETAILS
MECHANICAL	
6 - M 1	MECHANICAL SCHEDULES, LEGEND & ABBREVIATIONS
6 - M 2	DEMOLITION FLOOR PLAN
6 - M 3	NEW WORK FLOOR PLAN
6 - M 4	NEW WORK CROSS SECTION
6 - M 5	PHASING PLAN
6 - M 6	PHASING PLAN
6 - M 7	NEW WORK LARGE SCALE
6 - M 8	MECHANICAL RISER DEMOLITION
6 - M 9	MECHANICAL RISER NEW WORK
6 - M 10	PUMP ROOM DEMOLITION AND NEW WORK
6 - M 11	MECHANICAL DETAILS
6 - M 12	MECHANICAL DETAILS
6 - M 13	MECHANICAL DETAILS
6 - M 14	MECHANICAL DETAILS
6 - M 15	HVAC CONTROLS
ELECTRICAL	
6 - E 1	GENERAL SYMBOLS AND SINGLE LINE DIAGRAMS
6 - E 2	GROUND FLOOR PLAN - ELECTRICAL
6 - E 3	PARTIAL PUMP ROOM PLAN - ELECTRICAL
6 - E 4	ATTIC PLAN - DEMOLITION - ELECTRICAL
6 - E 5	ATTIC PLAN - NEW WORK - ELECTRICAL
6 - E 6	PANELBOARD SCHEDULES & DETAILS

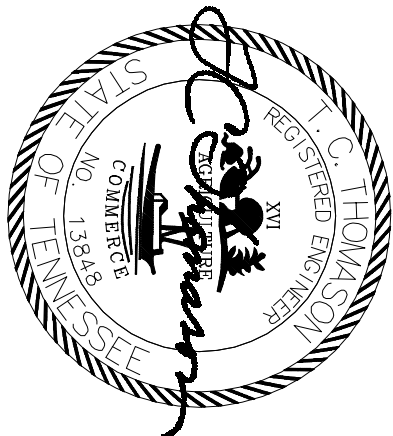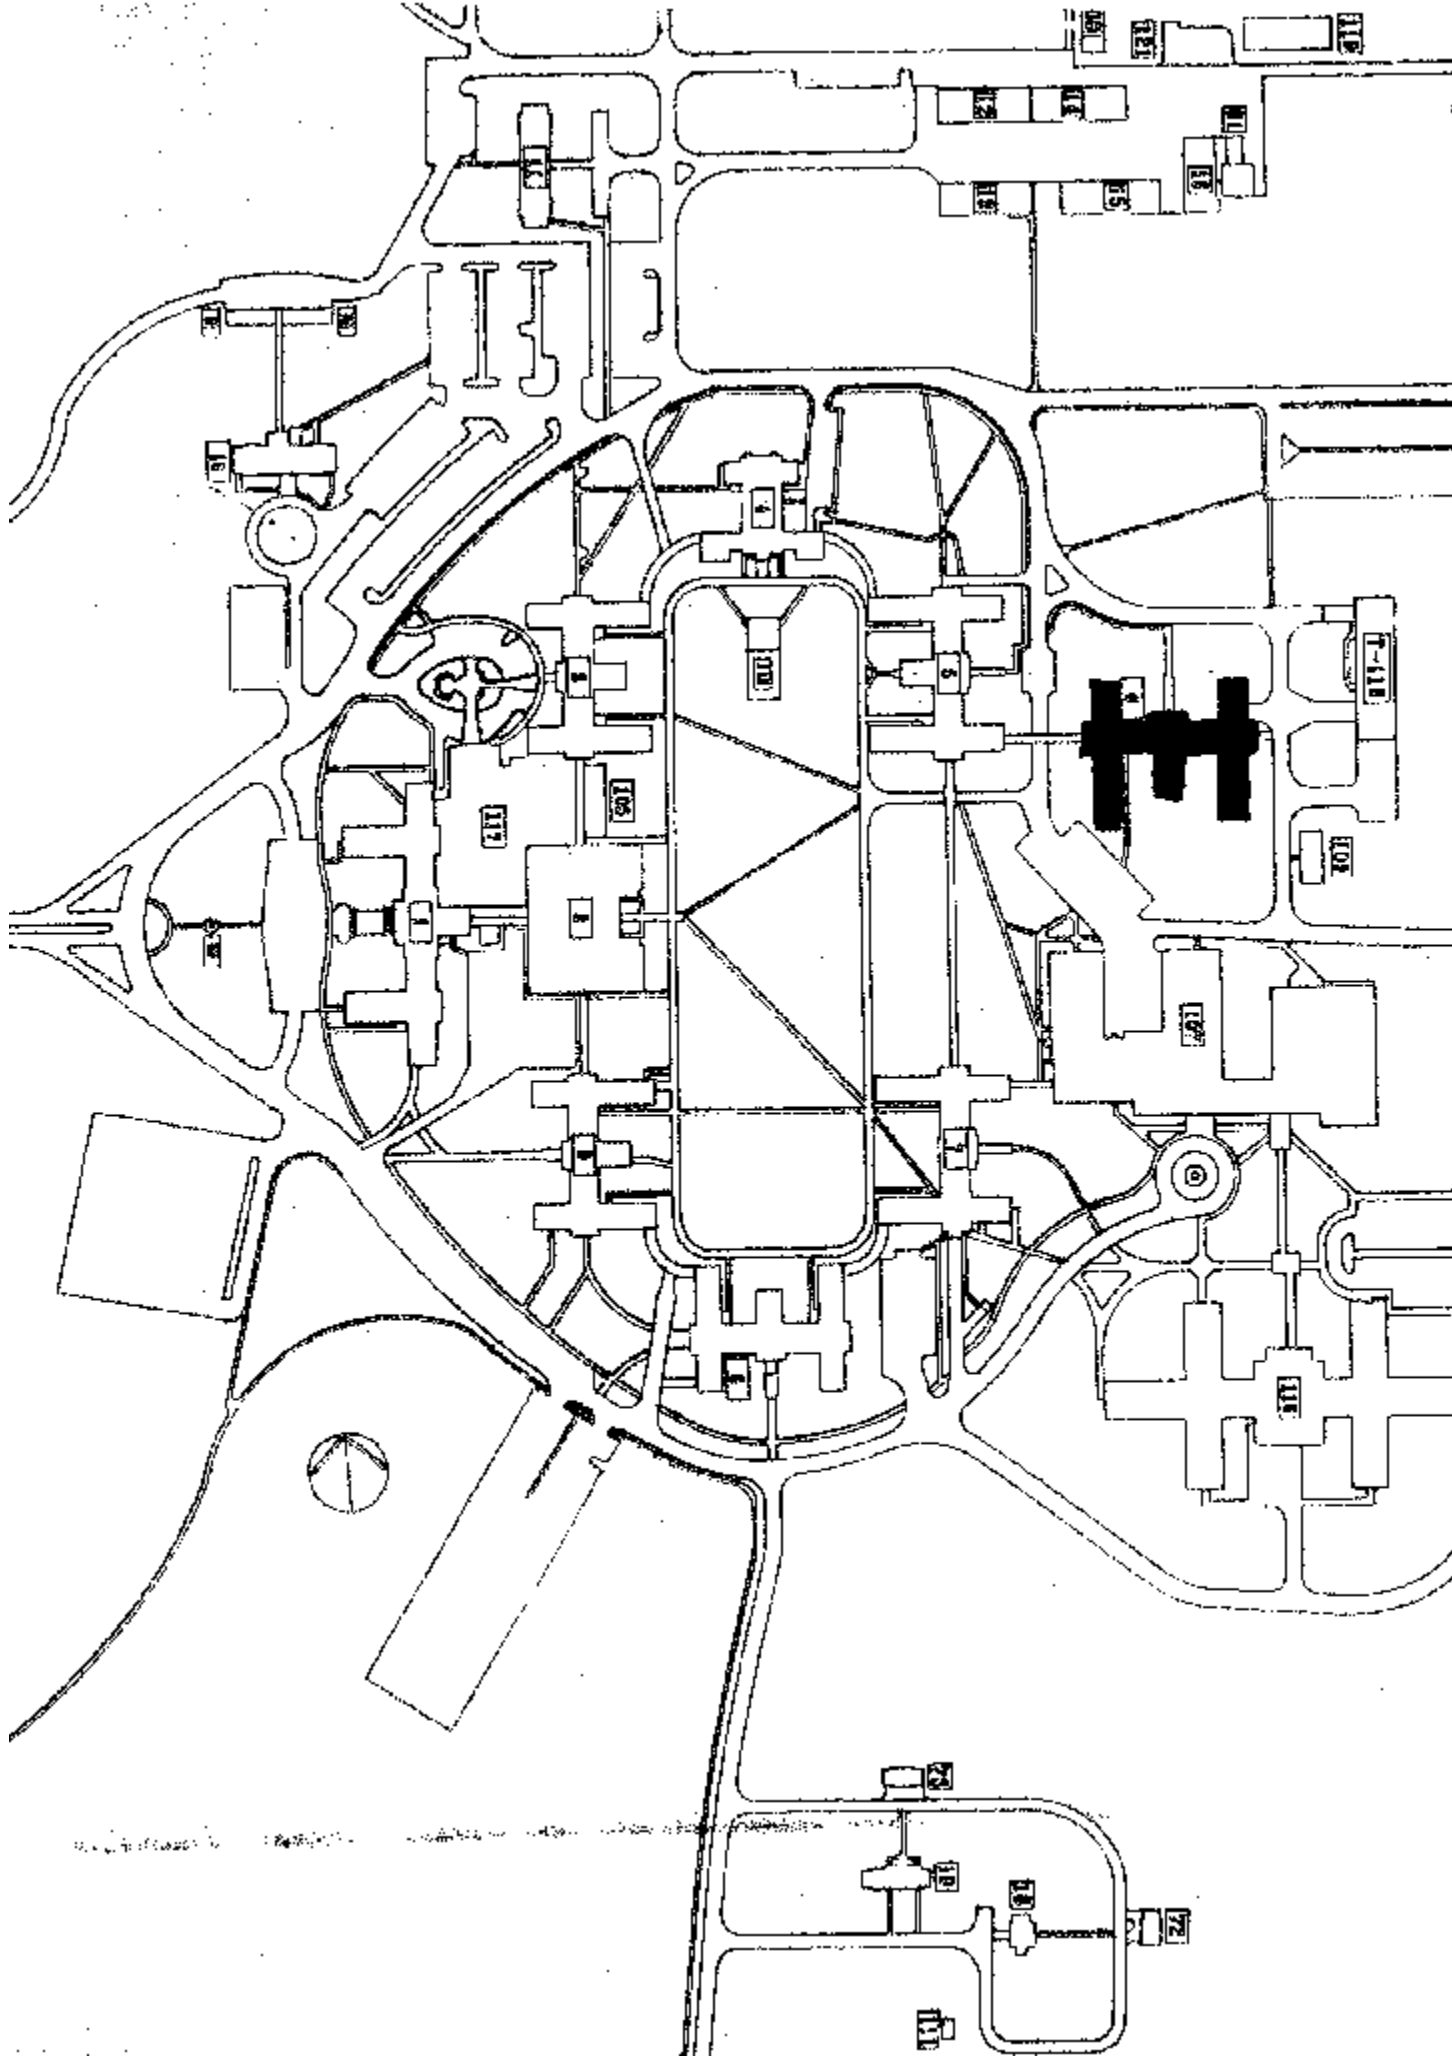

CONSTRUCTION DOCUMENTS

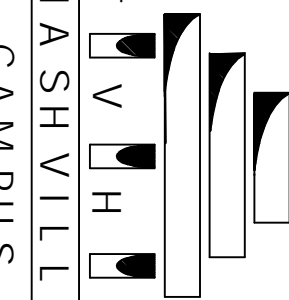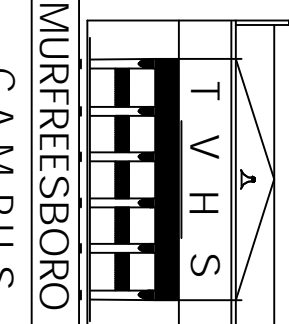Revisions	Date
<div><div><div>Tennessee Valley Healthcare System</div></div><div><div>MURFREESBORO CAMPUS</div></div></div>	
TENNESSEE VALLEY HEALTHCARE SYSTEM MURFREESBORO CAMPUS	
Drawing Title COVER SHEET	
Project Title REPLACE ATTIC AHUS BUILDING 6	
Approved: —	Approved: Facility Manager
Approved: —	Approved: Director
Building Number 6	Created TCT
Location TMS - YORK CAMPUS	Drawn SP
Date 01/20/2012	Project No. 626A4-11-204
FILE NAME 11060R	DRAWING NO. 6 - CS
Veterans Administration	