

0 1 2 3 4 5 6 7 8 9

A
three inches = one foot

B
one and one-half inches = one foot

C
one inch = one foot

D
three-quarters inch = one foot

E
one-half inch = one foot


F
three-eighths inch = one foot

G
one-quarter inch = one foot


H
one-eighth inch = one foot

GENERAL DEMOLITION NOTES:


1. REMOVE POWER FEEDER, DISCONNECT SWITCH, ETC. TO AIR HANDLING UNIT SUPPLY AND RETURN FANS.
2. TEMPORARY SUPPORT SMOKE DUCT DETECTOR INDEPENDENT OF AIR HANDLING UNIT DUCT WORK TO ALLOW REPLACEMENT AND REWORK OF DUCT WORK.
3. DISCONNECT FIRE ALARM SIGNAL FROM AIR HANDLING UNIT STARTER. REMOVE SMOKE DUCT DETECTORS. SEE NEW PLANS FOR NEW SMOKE DUCT DETECTORS.
4. VERIFY EXACT LOCATION OF DISCONNECT SWITCHES IN FIELD.
5. DISCONNECT AND REMOVE FIRE ALARM SMOKE DUCT DETECTOR AND SHUTDOWN RELAY FOR AHU-17 AND 18.

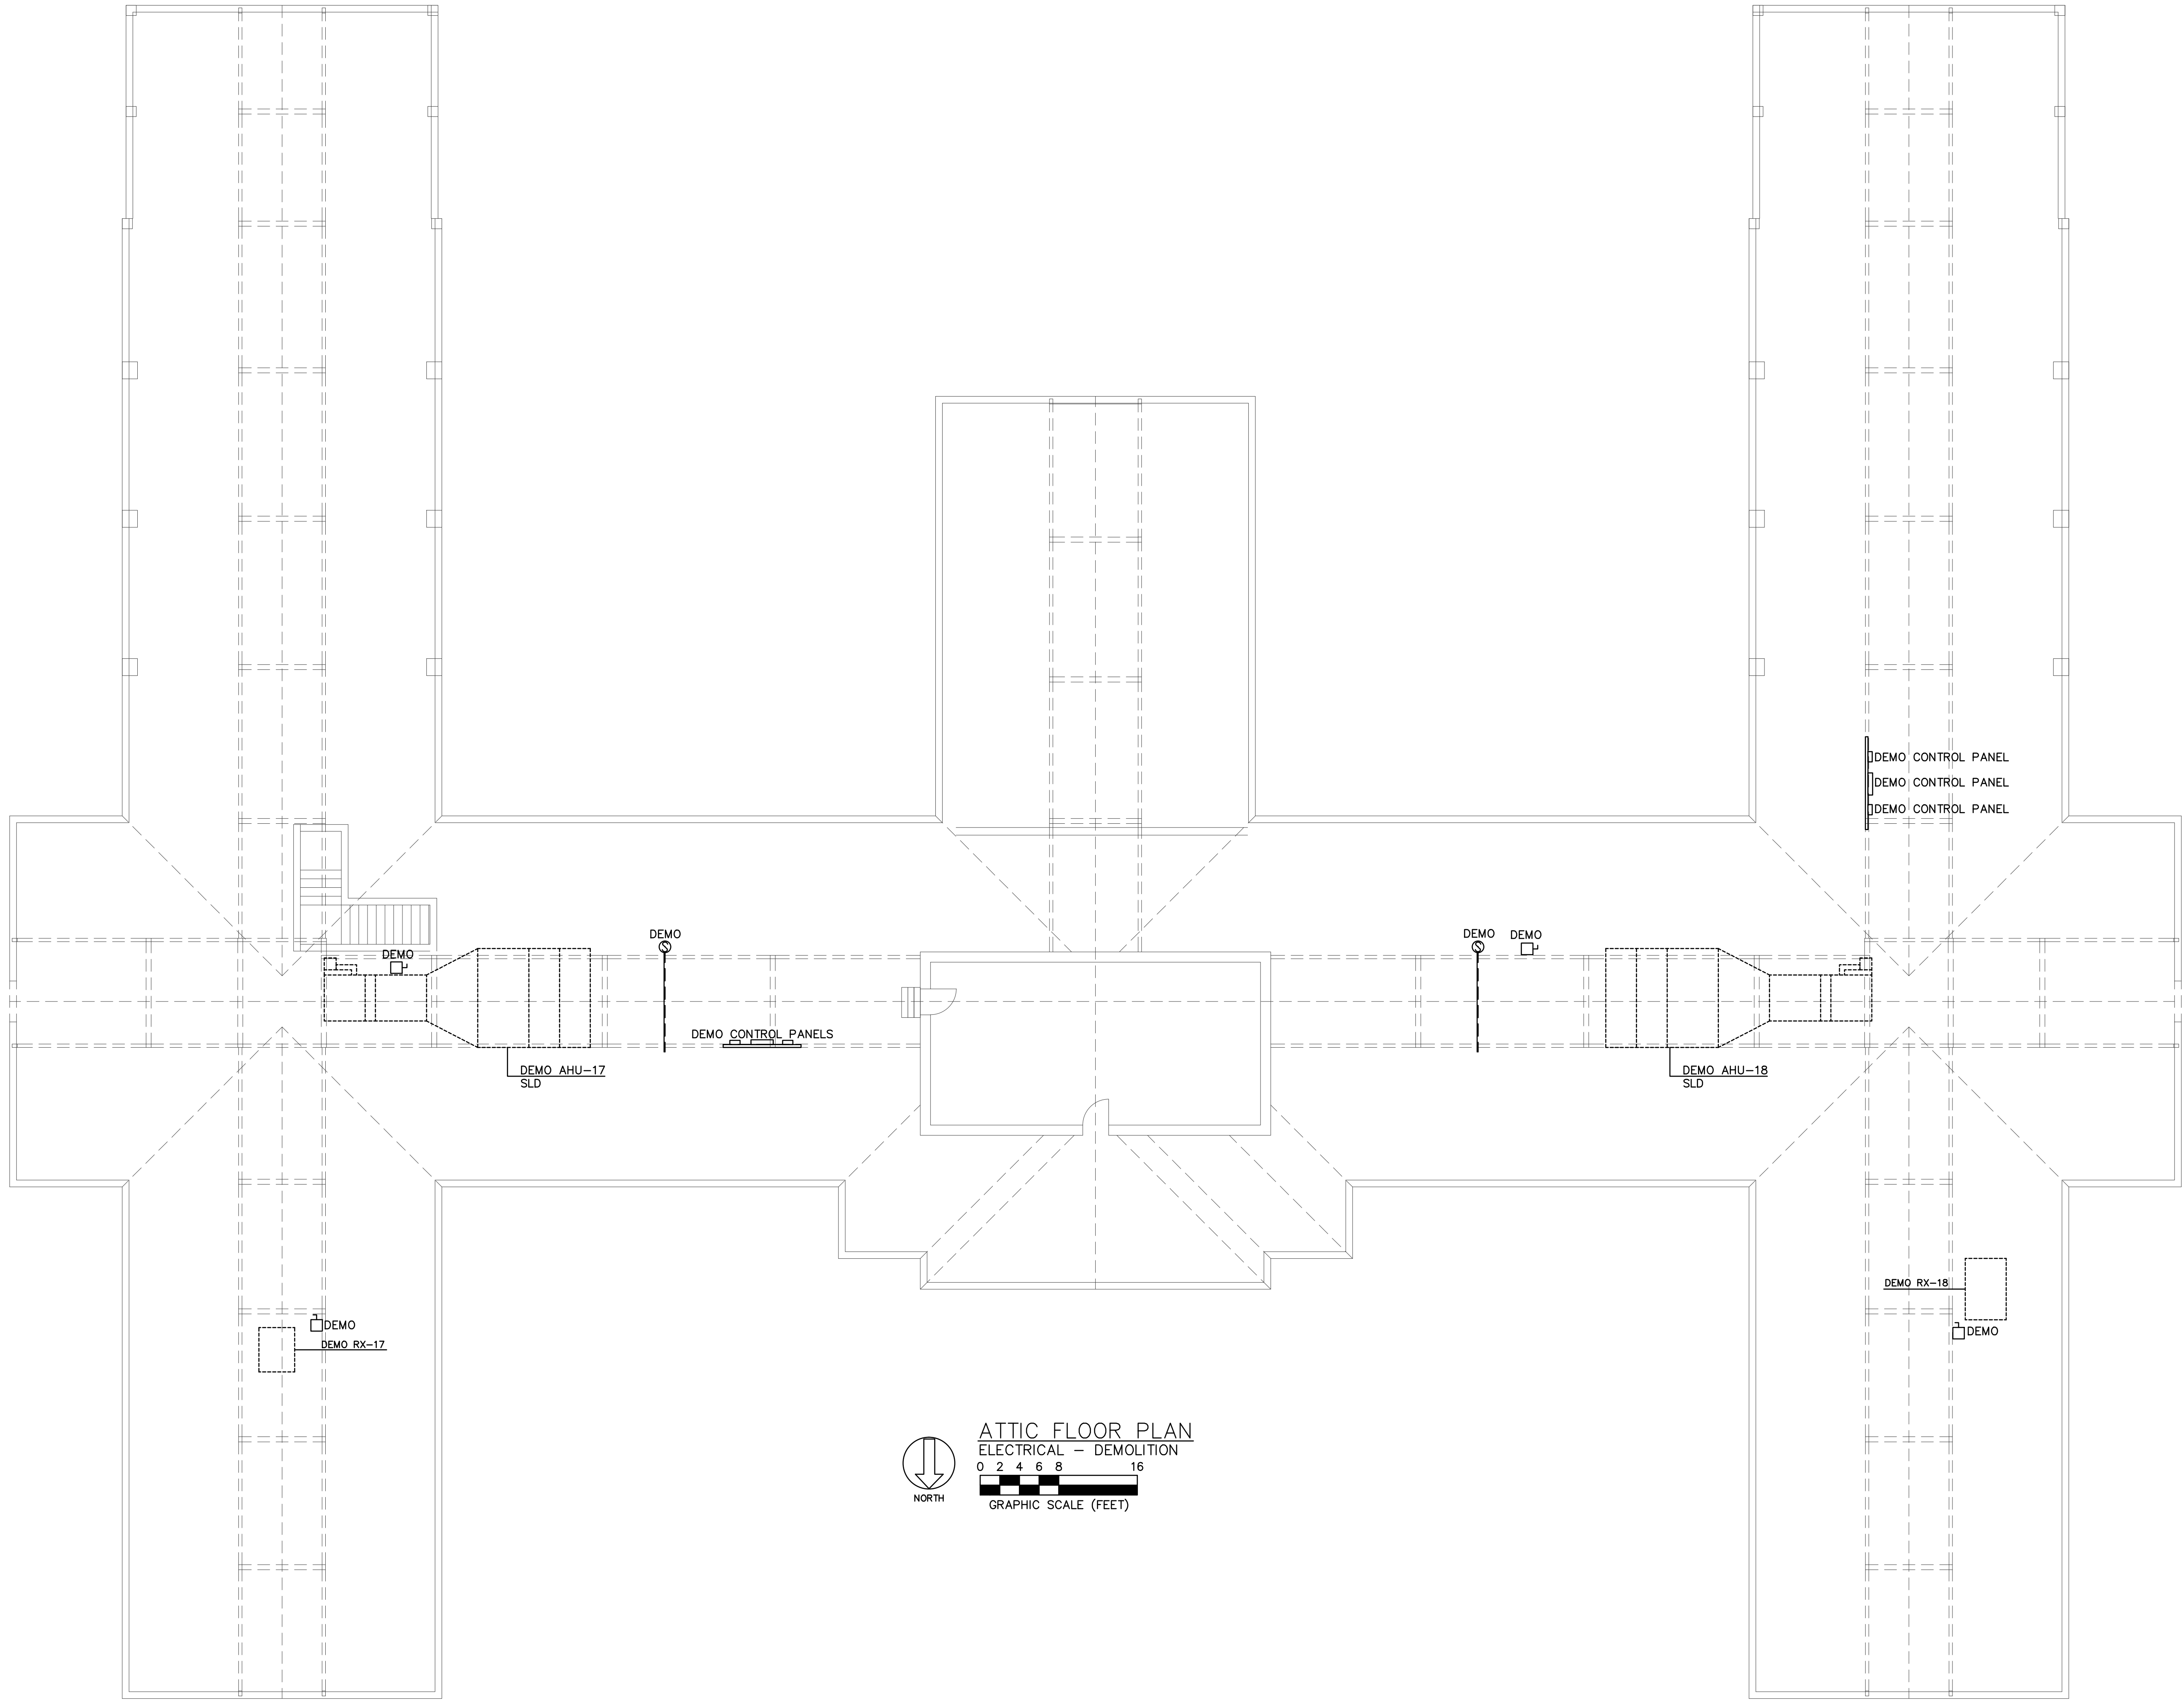

ATTIC FLOOR PLAN
ELECTRICAL - DEMOLITION
0 2 4 6 8 16
GRAPHIC SCALE (FEET)

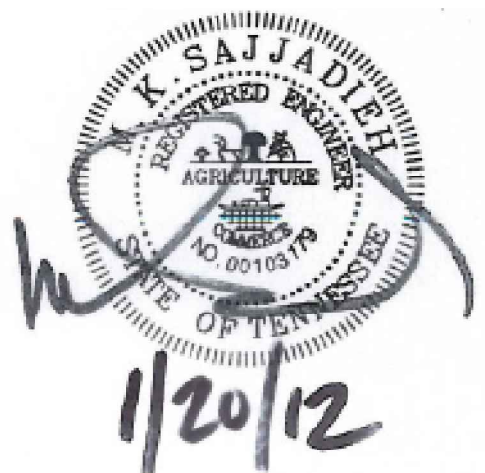



CONSTRUCTION DOCUMENTS

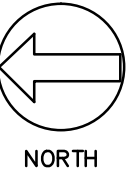

Revisions	Date



Tennessee Valley Healthcare System

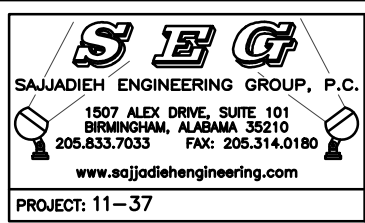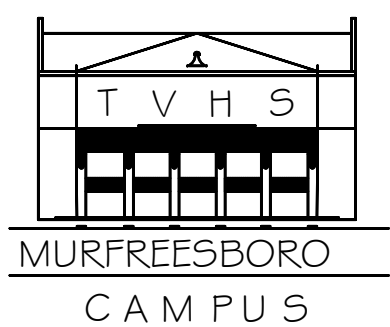

Approved: --

Approved: --

Drawing Title

ATTIC PLAN-
DEMOLITION - ELECTRICAL

Approved: Facility Manager

Approved: Director

Project Title

REPLACE ATTIC AHU's-
BLDG 6

Building Number

6

Checked

JJS

Drawn

AL

Location

VAMC - MURFREESBORO

Date

01/20/2012

Project No.

626A4-11-204

DRAWING NO.

6-E4

FILE NAME

--

Veterans
Administration