




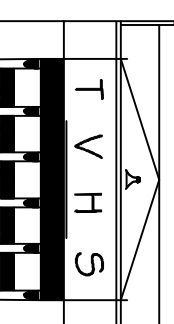
DRAWING NOTES:  
① SEE RISER DIAGRAM ON DRAWING 6-M9 FOR TIE-IN TO CHASE.

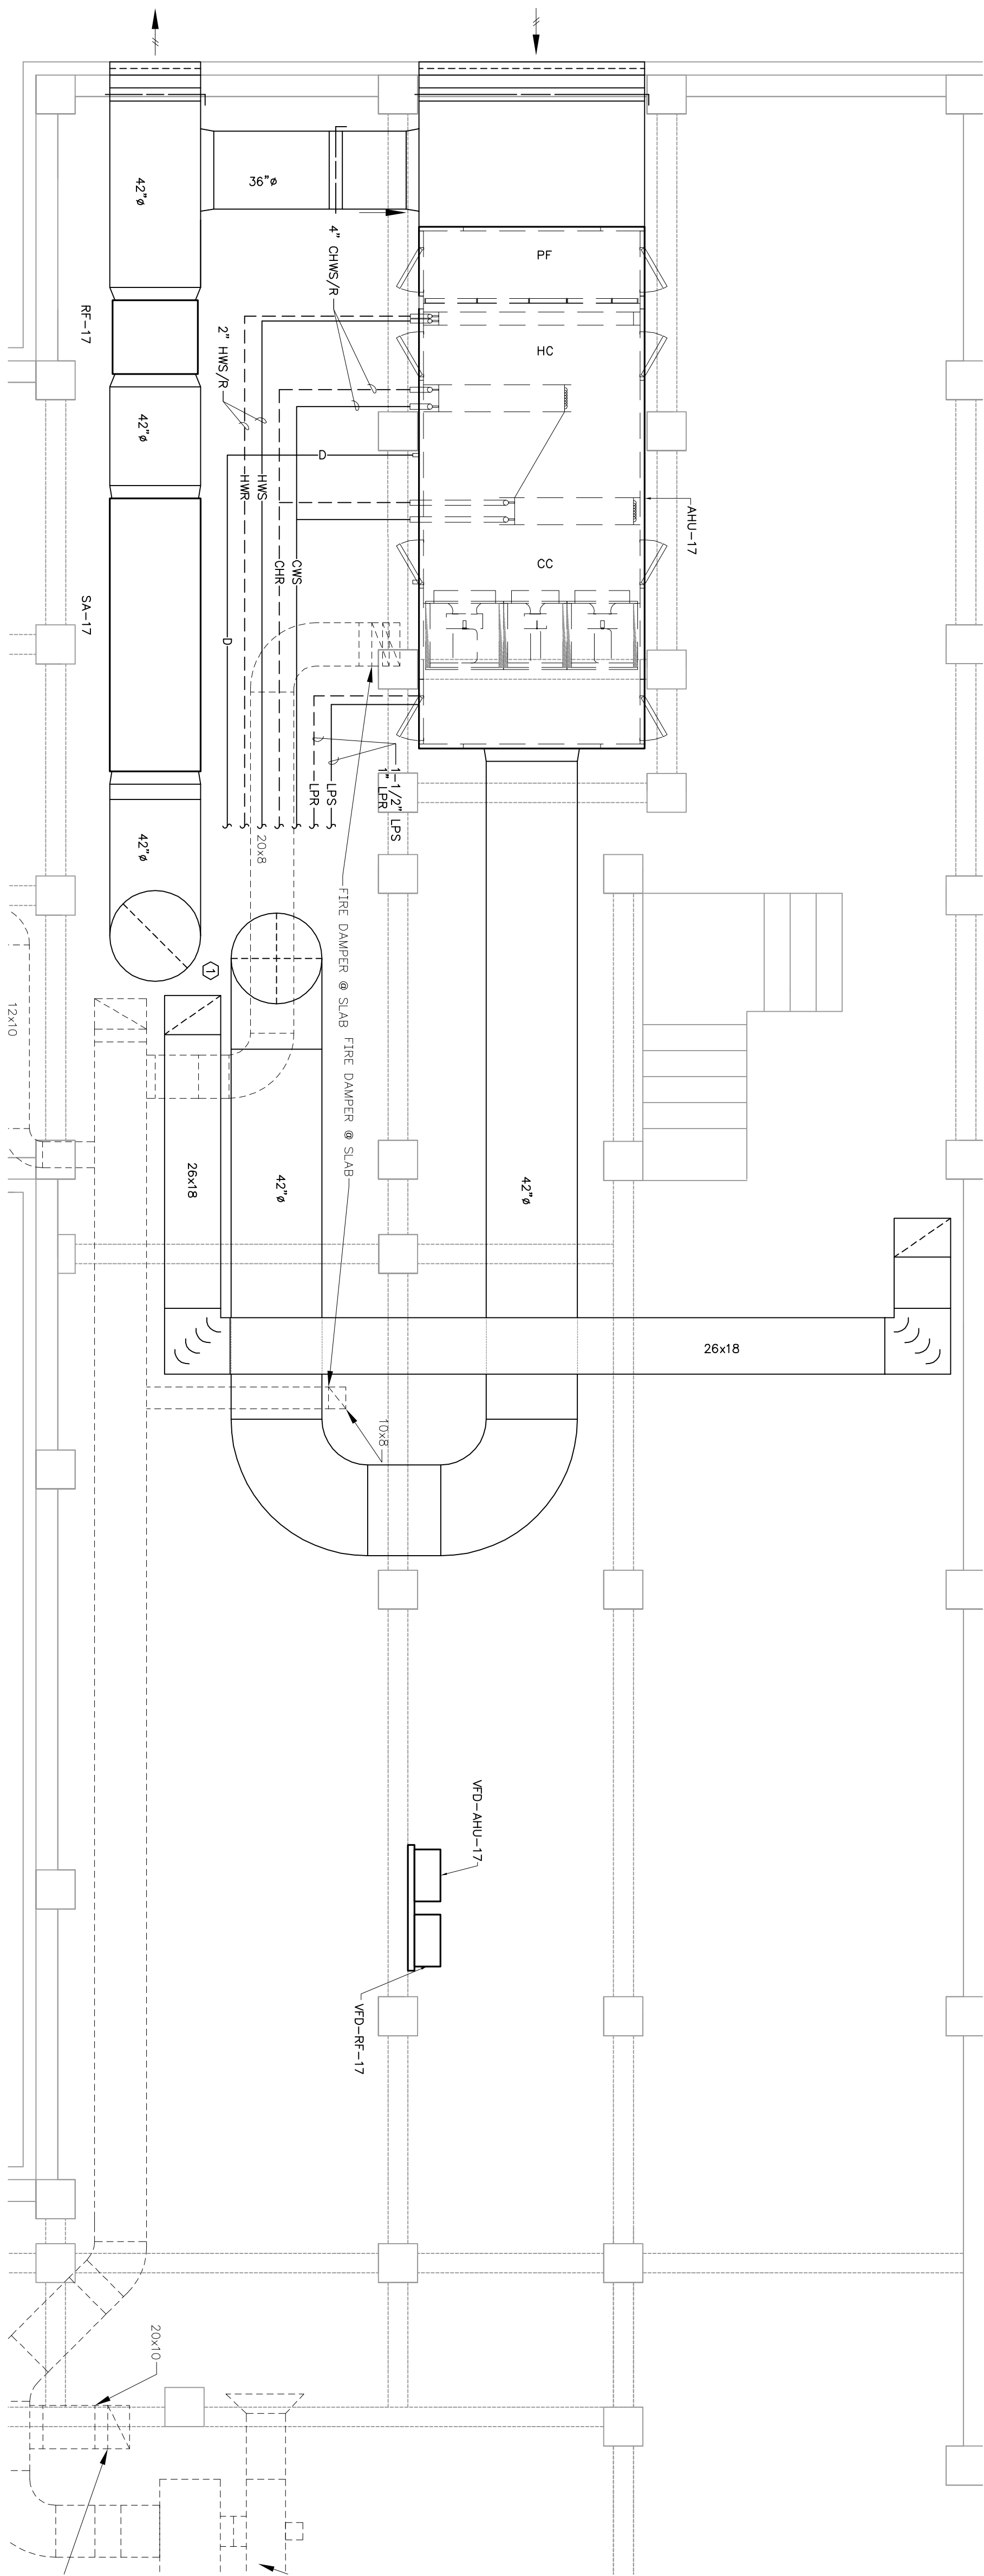

PARTIAL ATTIC FLOOR PLAN  
MECHANICAL - NEW WORK  
1/4" = 1'-0"

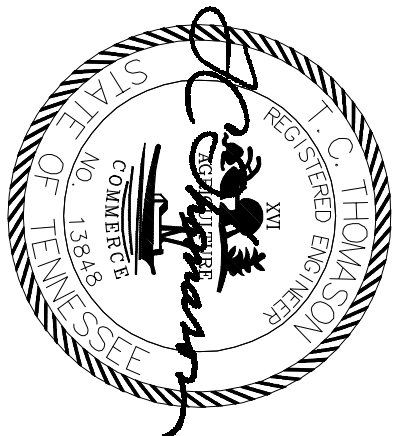

## CONSTRUCTION DOCUMENTS

Revisions		Date	
<div><div><div>Tennessee Valley Healthcare System</div></div><div><div>MURRETSBORO CAMPUS</div></div></div>			
Tennessee Valley Healthcare System MURRETSBORO CAMPUS		Drawing Title NEW WORK LARGE SCALE	
Approved: ---		Approved: Facility Manager	
Approved: ---		Approved: Director	
Project Title REPLACE ATTIC AHUS BUILDING 6		Building Number 6	
Created TCL		Drawn SP	
Location TMS - YORK CAMPUS		Project No. 62644-11-204	
Date 01/20/2012		Project No. 62644-11-204	
Drawing No. 6-M7		Drawing No. 6-M7	
File Name 1027101		File Name 1027101	
Veterans Administration			