



UPDATED TO AS-BUILT	9/2/10
4A132, REMOVE 4A133	2/5/12
4A, 4B, 4C, CHANGES	9/30/09
4B156A-1	9-2-04
4C123/130/135/137/138/144/147	9-15-05
THREE LAYER, FIRE SMOKE WALLS	8-18-98
REVISIONS	Notes

Drawing Title FOURTH FLOOR PLAN		Project Title AS-BUILT		Date 11-4-02	
SCALE: 1/16" = 1'-0"		Project No. AS-BUILTS		DRAWING NO. 100-4A	
Approved: Division Chief		Building Number 100	Checked	Drawn MAKI	Dwg. 6 of 7
Approved: Service Director		Location VAMC Bay Pines Bay Pines FL 33744			

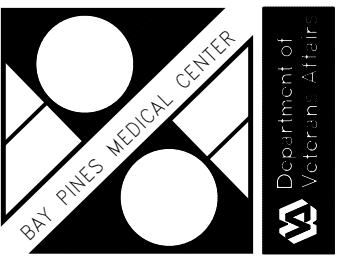



one-eighth inch = one foot
one-quarter inch = one foot
three-eighths inch = one foot
one-half inch = one foot
three-quarters inch = one foot
one inch = one foot
three inches = one foot

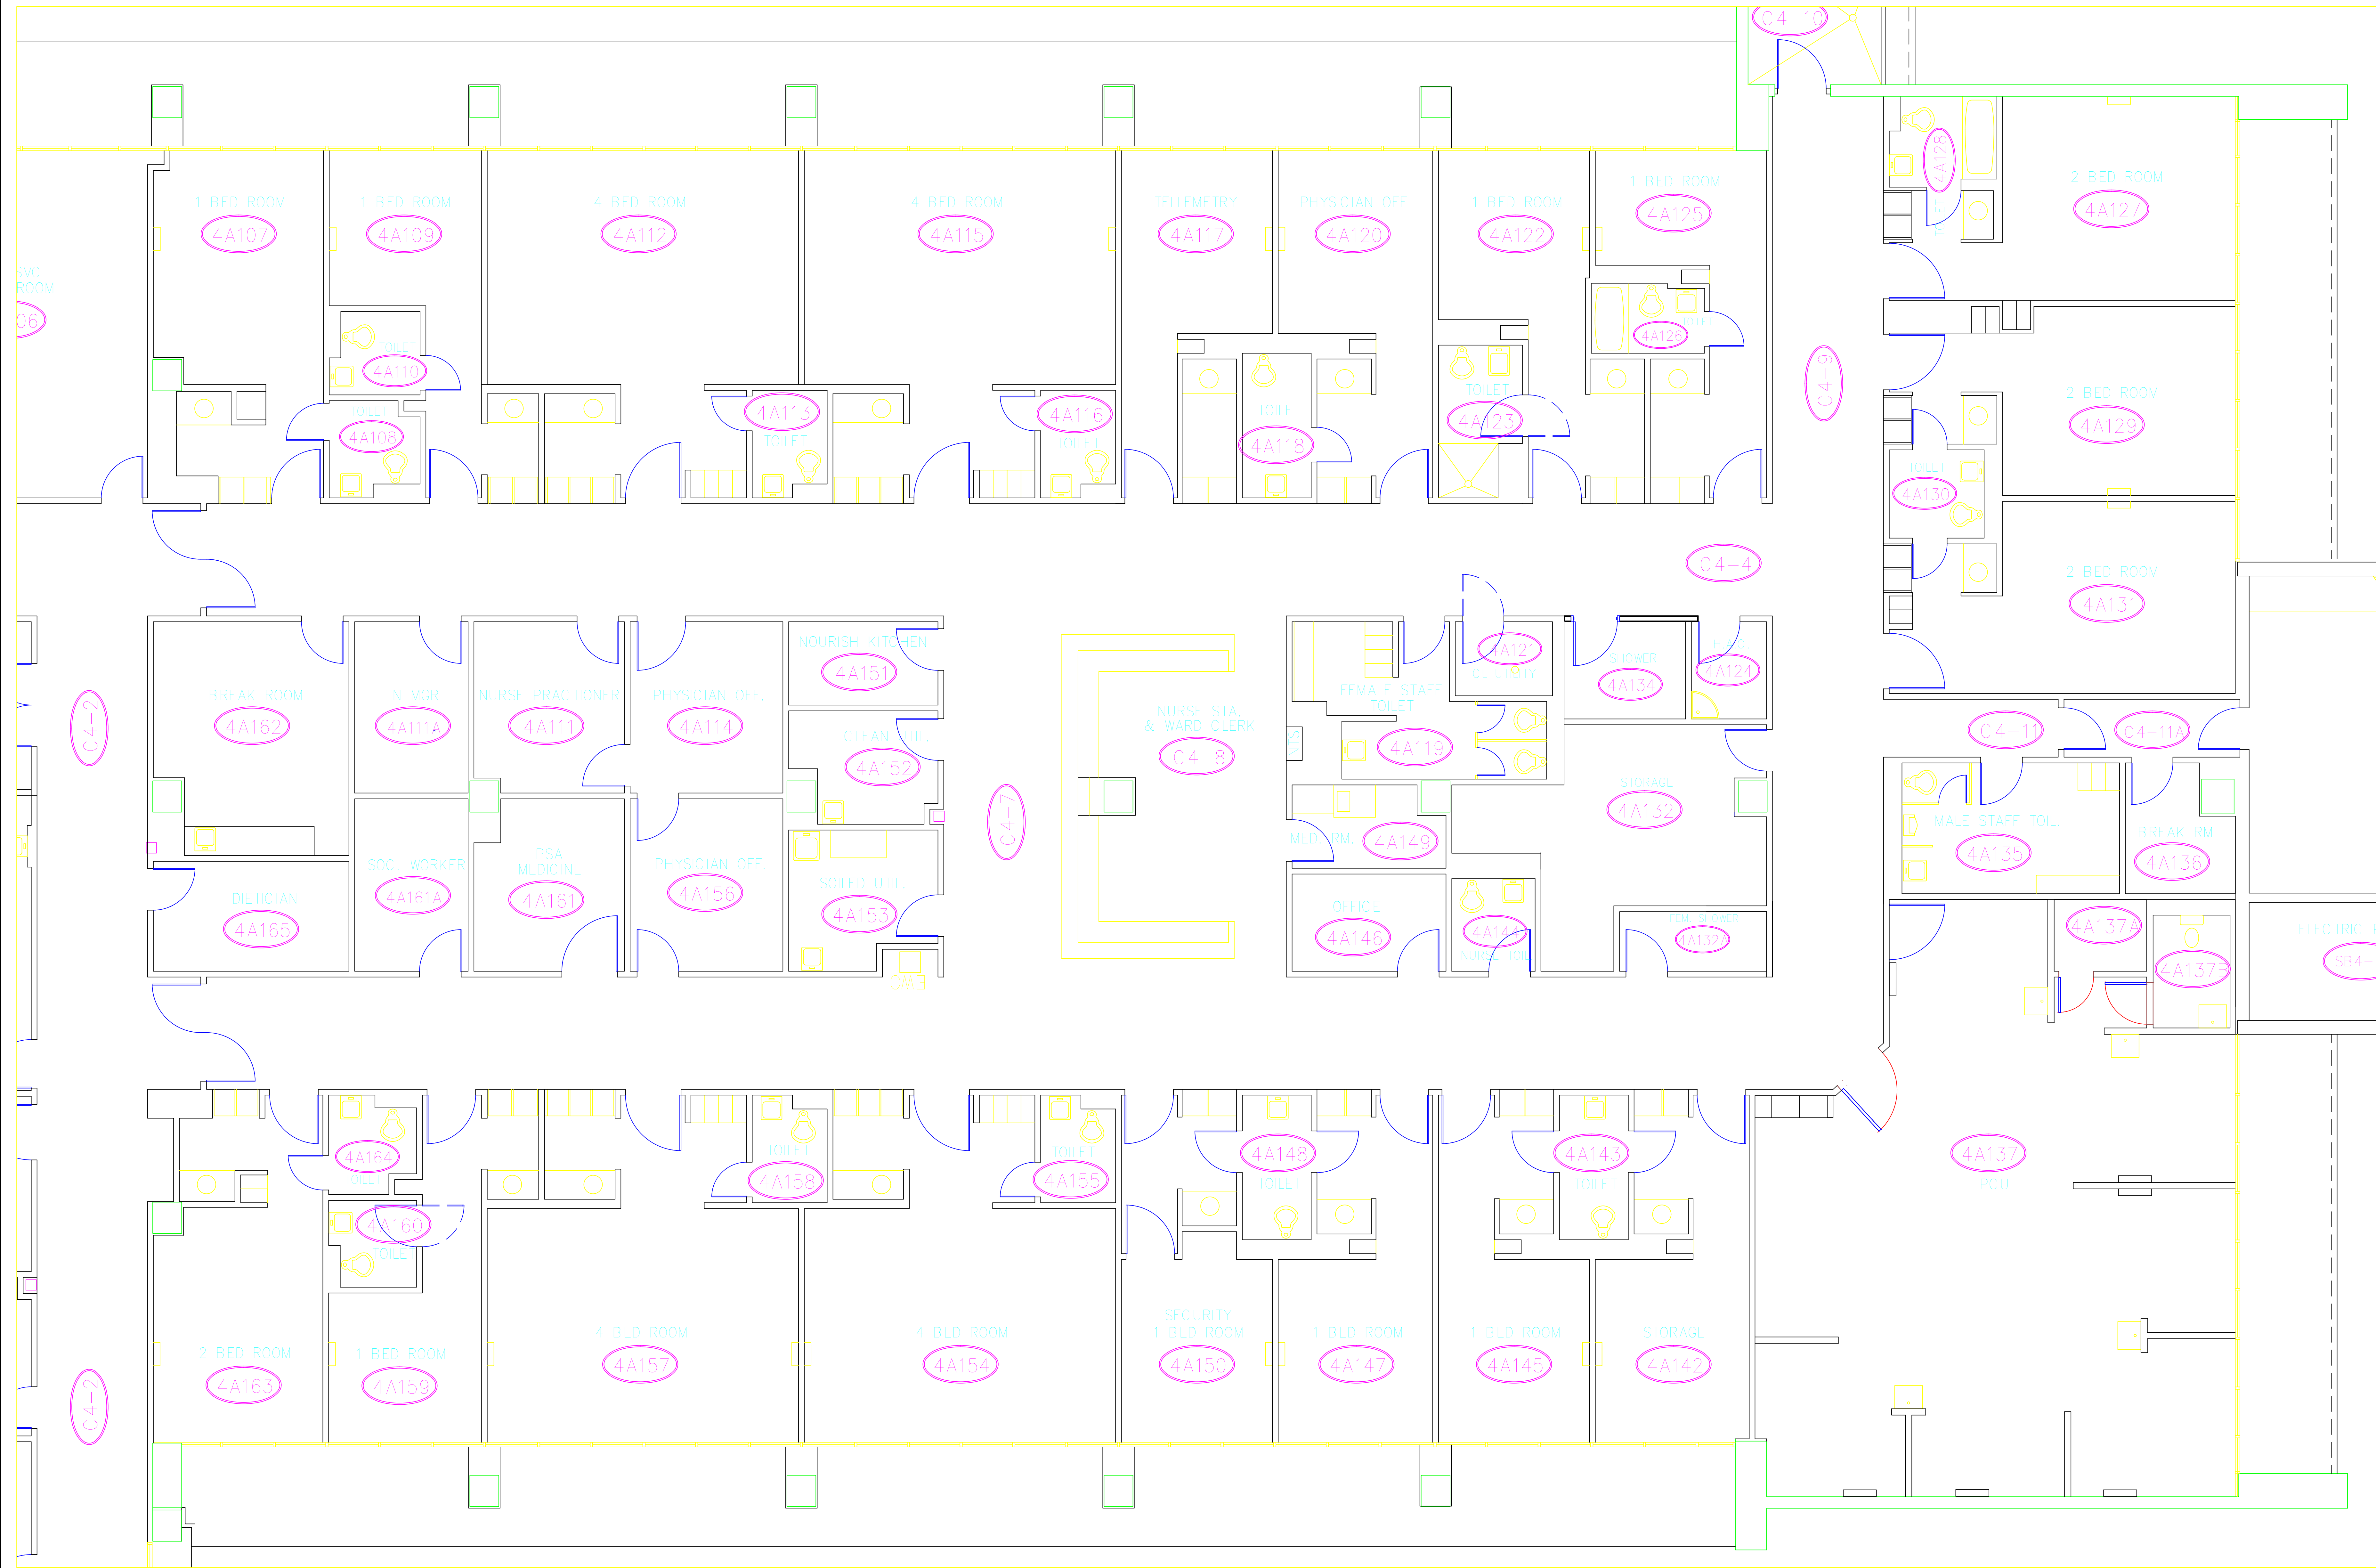

Drawing Title 4TH FLOOR PLAN A-WING		Project Title AS-BUILTS		Date 3-1-04	
SCALE: 1/4" = 1'-0"		Building Number 100		Project No.	
Approved: Division Chief		Checked MAKI		DRAWING NO. 100-4A	
Approved: Service Director		Location VAMC Bay Pines Bay Pines FL 33744		Dwg. X of X	

Revisions

Date

BAY PINES MEDICAL CENTER

Department of Veterans Affairs