


REMOVE EXISTING SIGN FROM BUILDING, (3) TOTAL (MEN, WOMEN, CHAPEL) SEE B5/LS502 FOR PICTURE OF TYPICAL SIGN. SEE NOTES FOR REMOVAL METHODS.

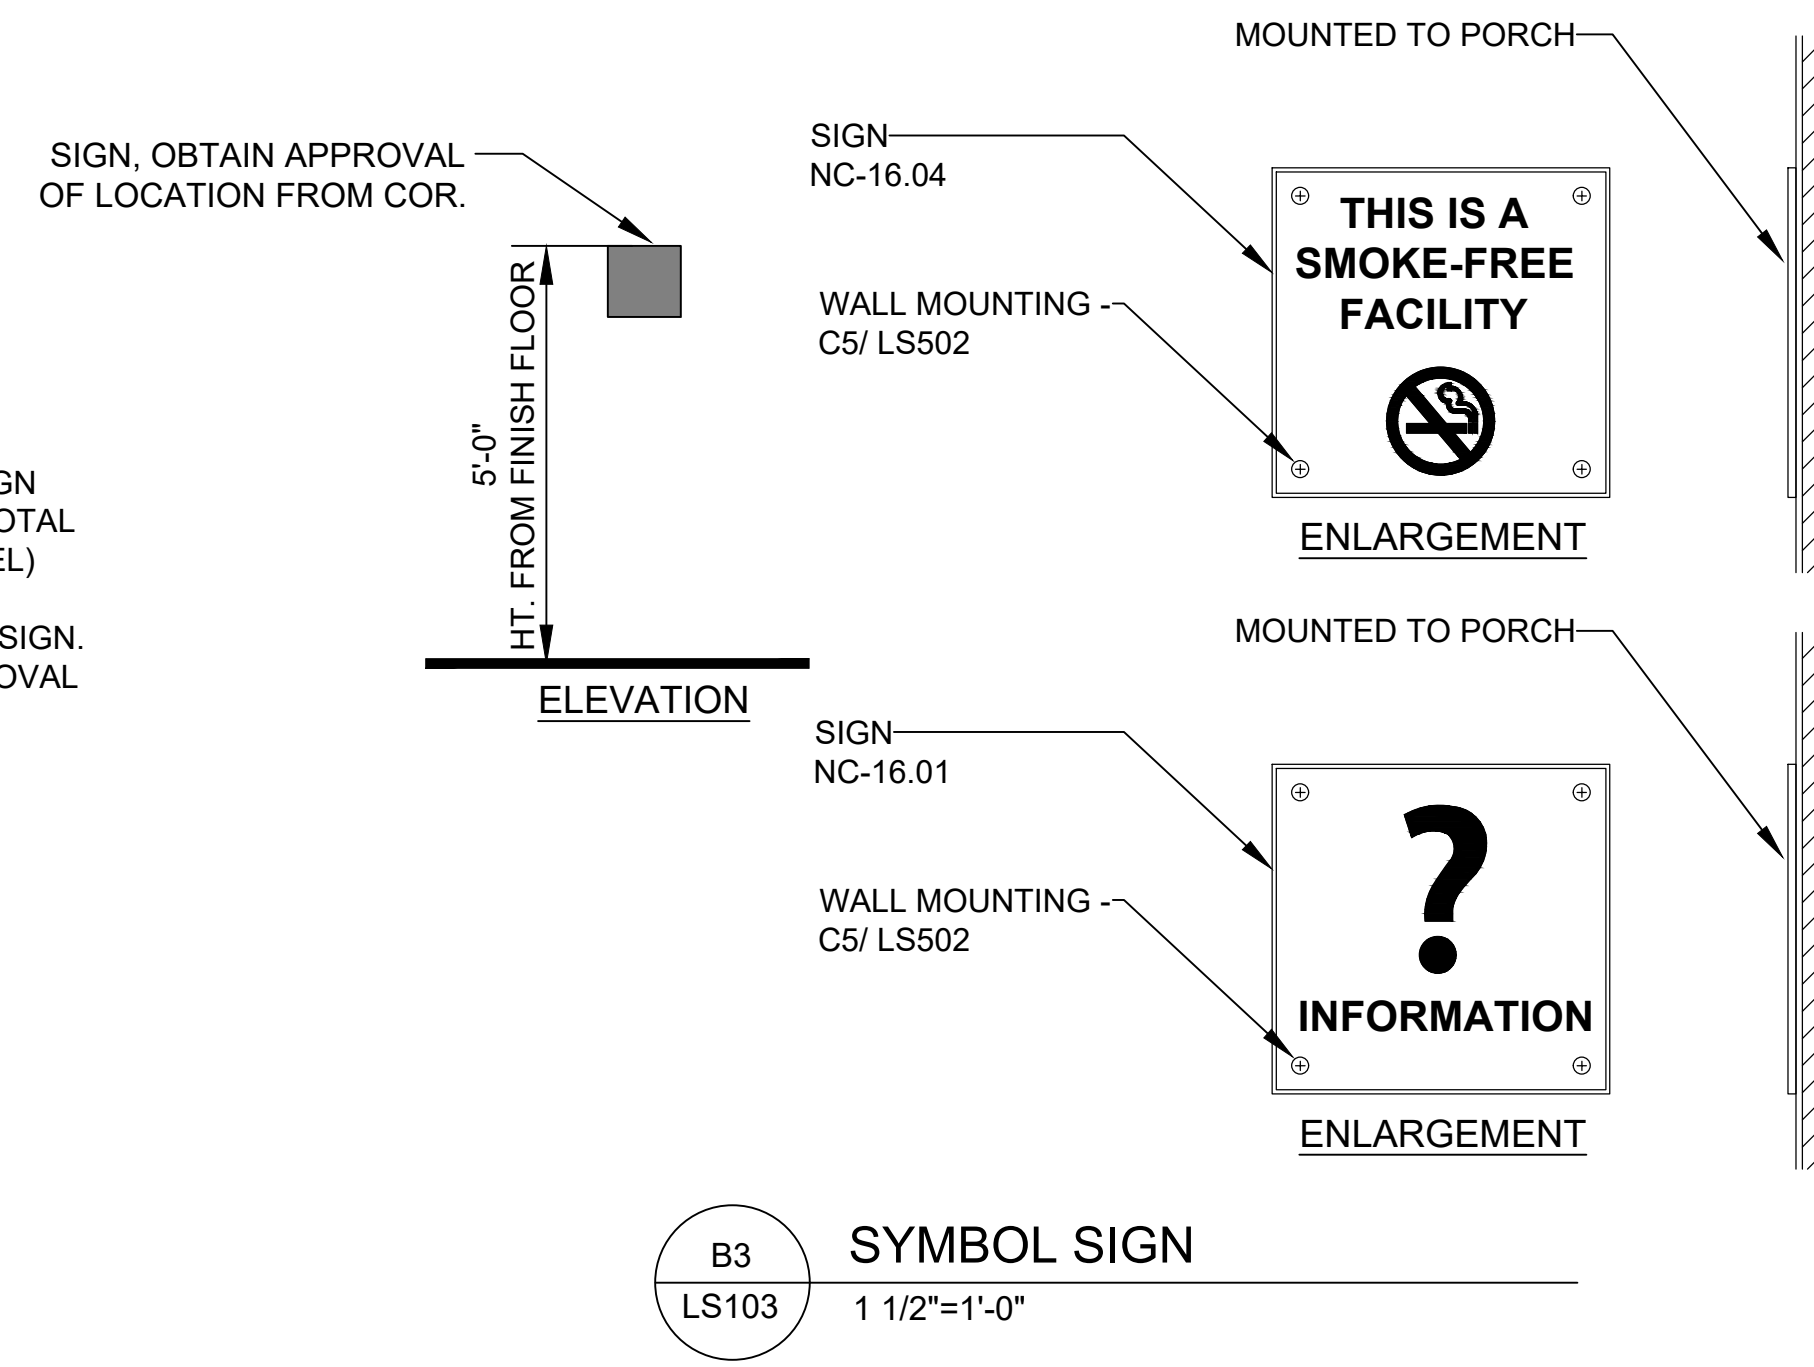

SIGN TO REMOVE, TYP. (3) TOTAL

REMOVAL NOTES:

1. CONTRACTOR SHALL REMOVE METAL SIGN PANELS FROM BUILDING FACE. REMOVE ALL GLUE AND FASTENERS. UTILIZE MECHANICAL METHODS FOR REMOVAL ONLY.
2. CONTRACTOR SHALL REPAIR ALL DAMAGED OR DISCOLORED BUILDING FACE AFTER THE SIGNS HAVE BEEN REMOVED. REPAIRS MAY INCLUDE STUCCO REPAIR, PAINT SEALANT, ETC. IN ORDER TO MATCH OTHER EXISTING SURROUNDING FINISHES.
3. CONTRACTOR SHALL SUBMIT ALL REPAIR PLANS FOR APPROVAL PRIOR TO PROCEEDING WITH WORK.




B1 BUILDING SIGN REMOVAL PLAN
LS103 N.T.S.

B5 EXISTING BUILDING SIGN TYPE TO BE REMOVED
LS103 N.T.S.




ANCHORS SHOULD BE SUITABLE FOR THE PARTICULAR TYPE OF WALL SURFACE WHERE THE SIGN IS BEING INSTALLED

ALUMINUM WALL PANEL SIGNS SHALL BE FASTENED WITH A MINIMUM OF (4) TAMPER RESISTANT MECHANICAL FASTENERS


C5 WALL MOUNTING: NON-ILLUMINATED SIGNS
LS103 1"=1'-0"

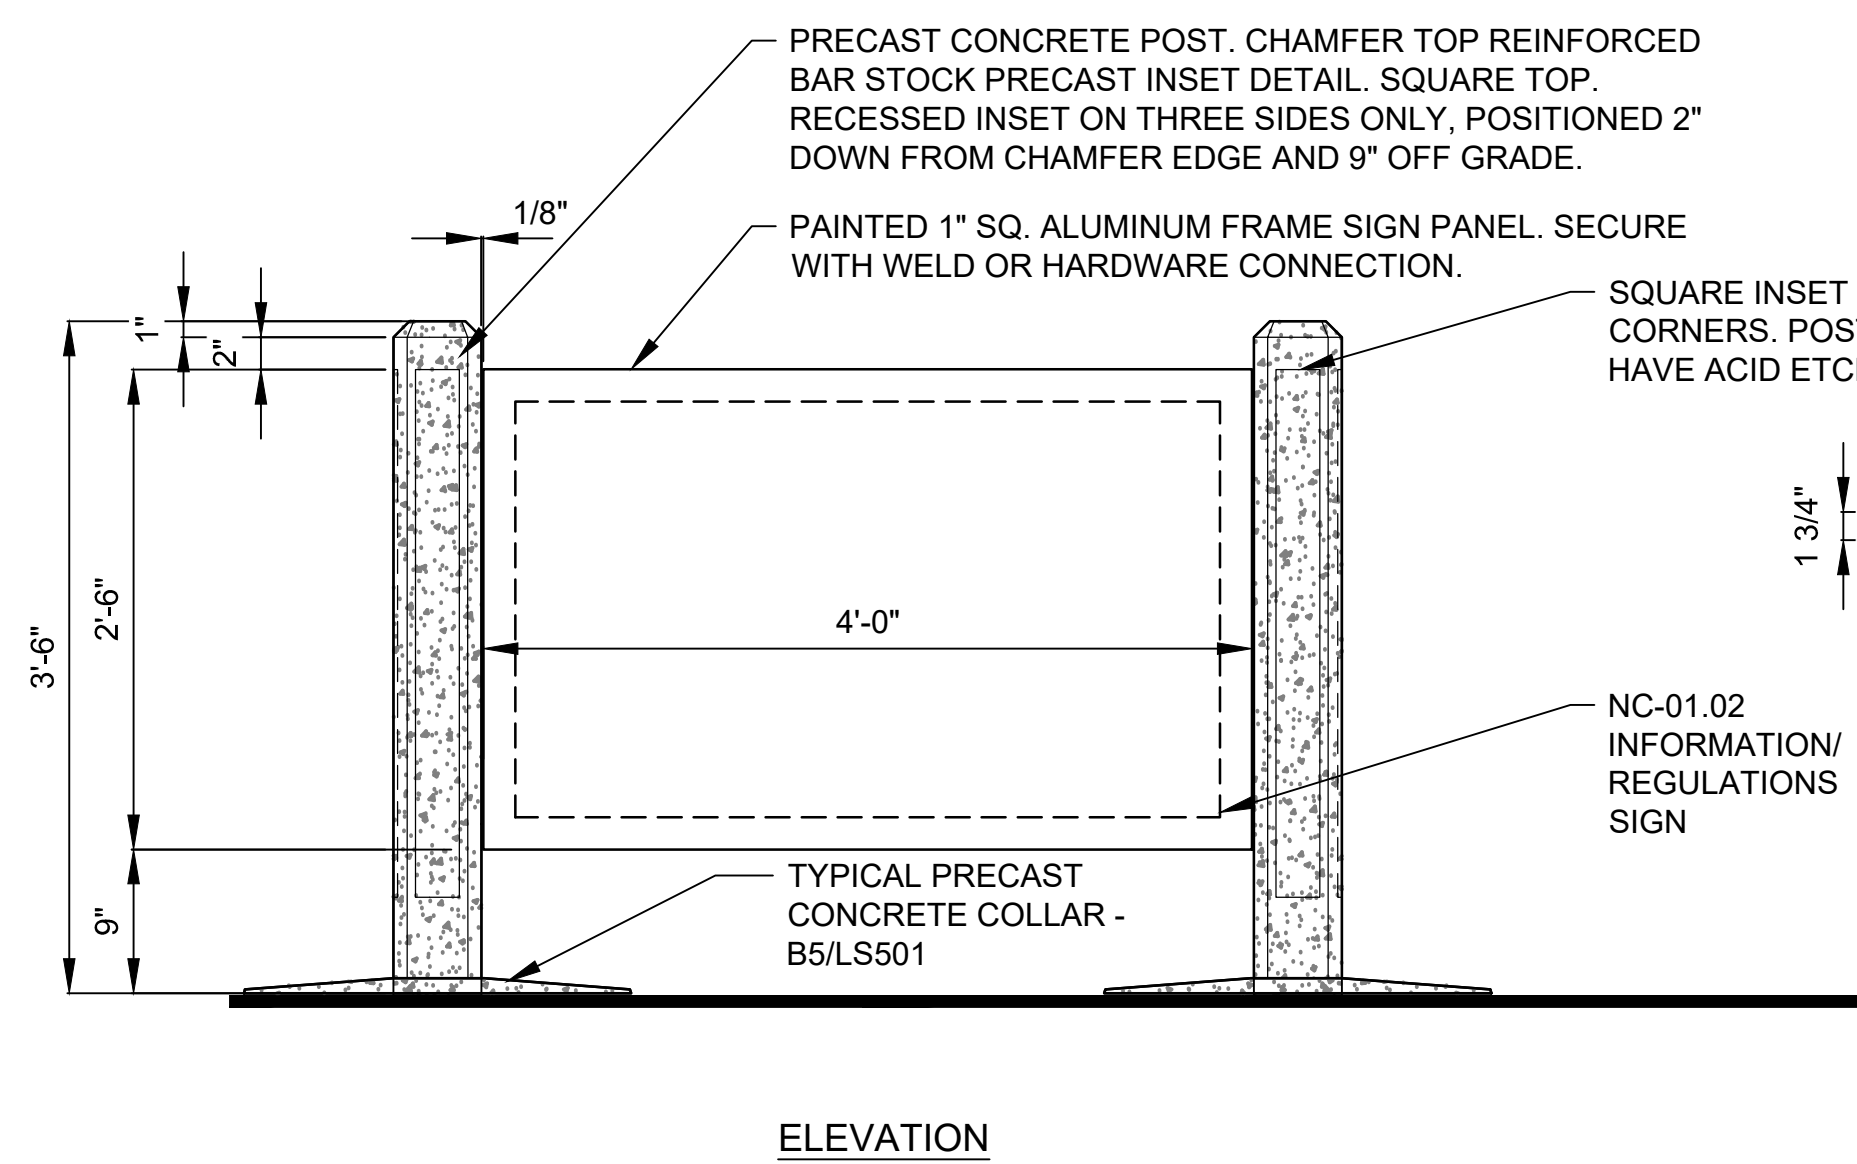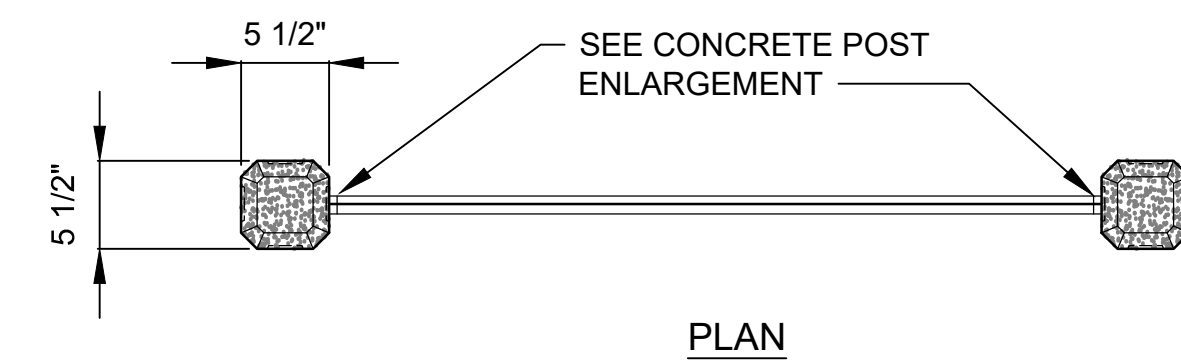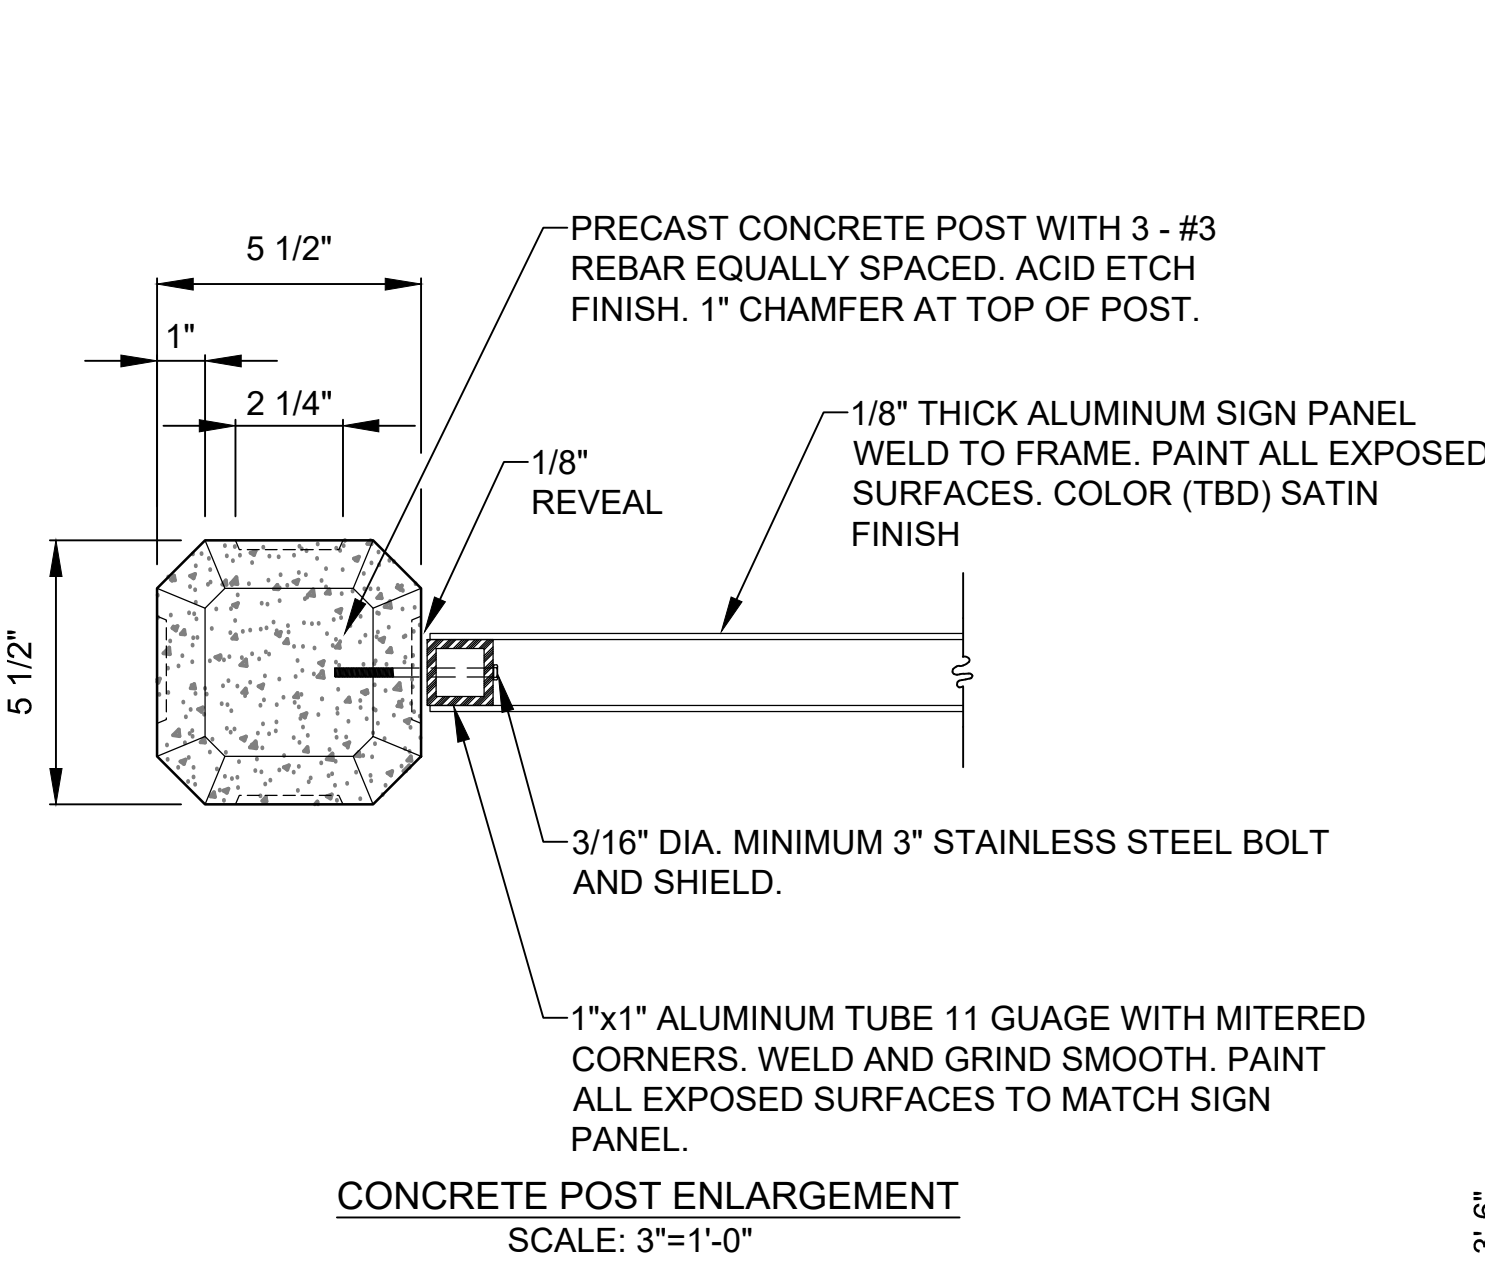


F3 PRECAST CONCRETE DOUBLE POST AND PANEL
LS501 NOT TO SCALE

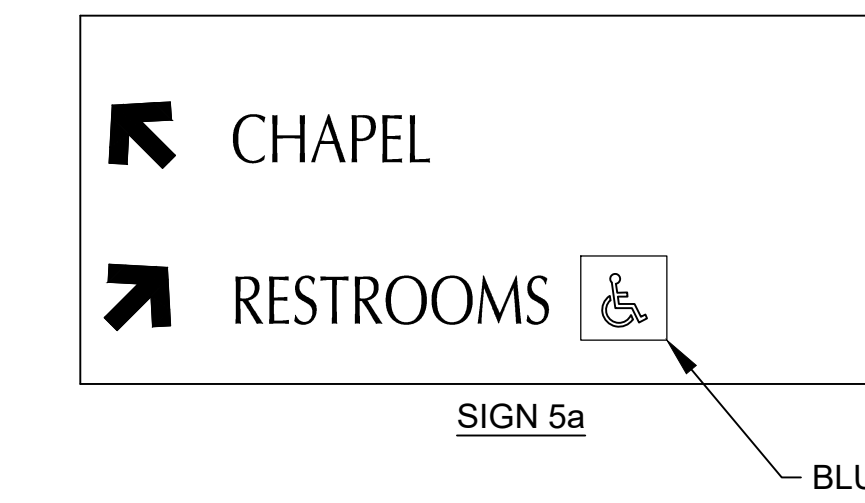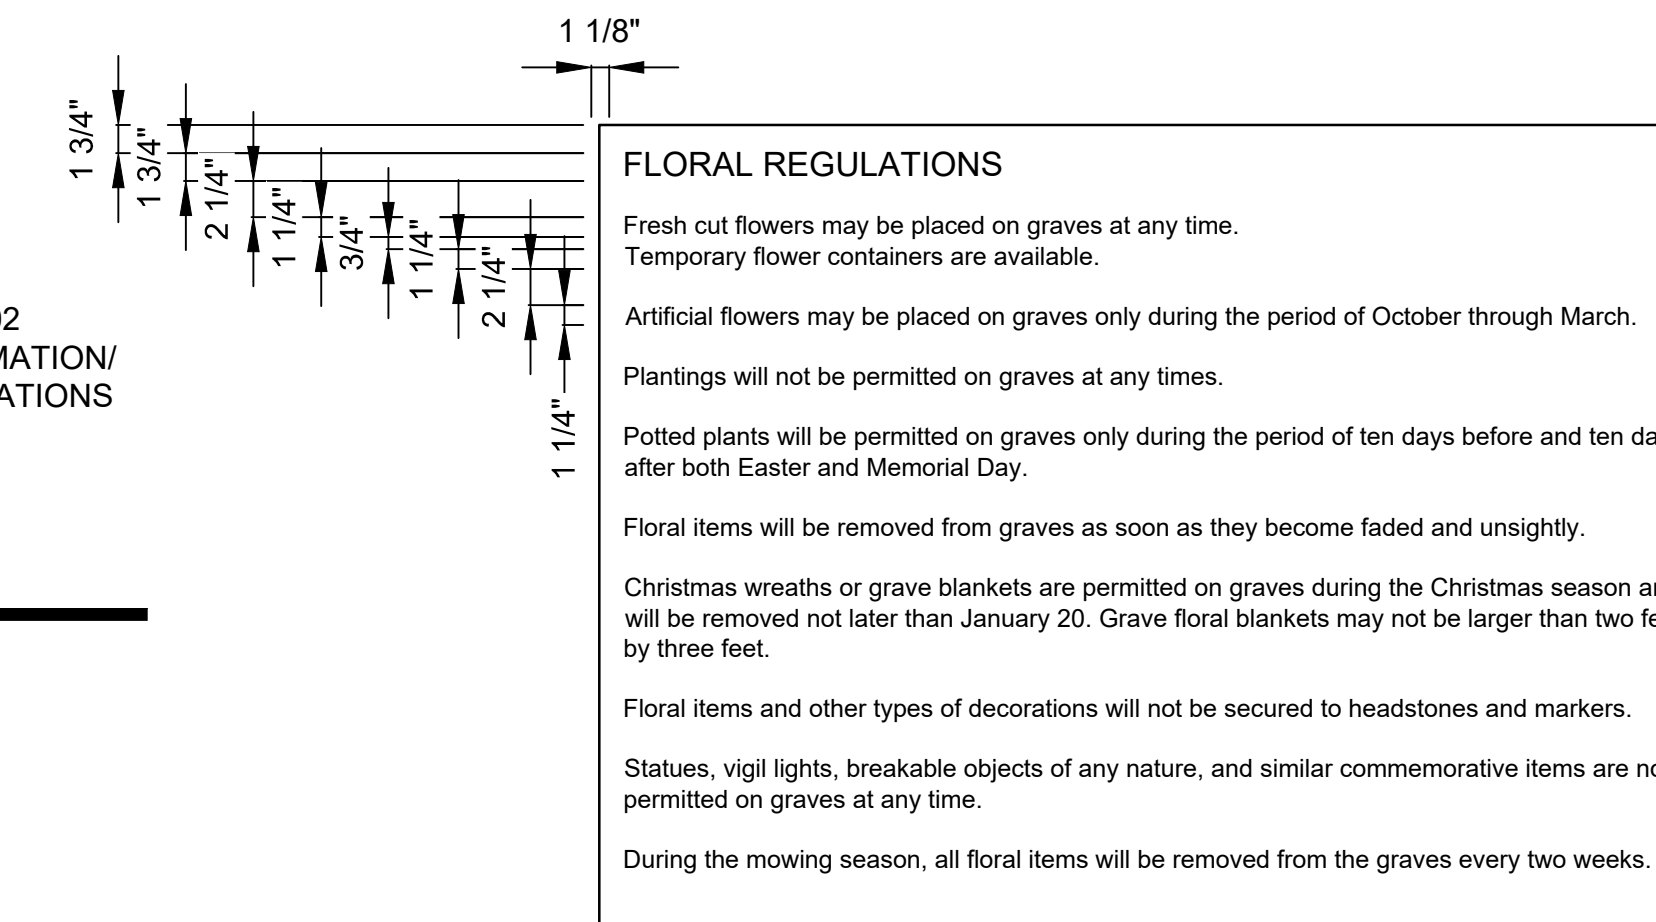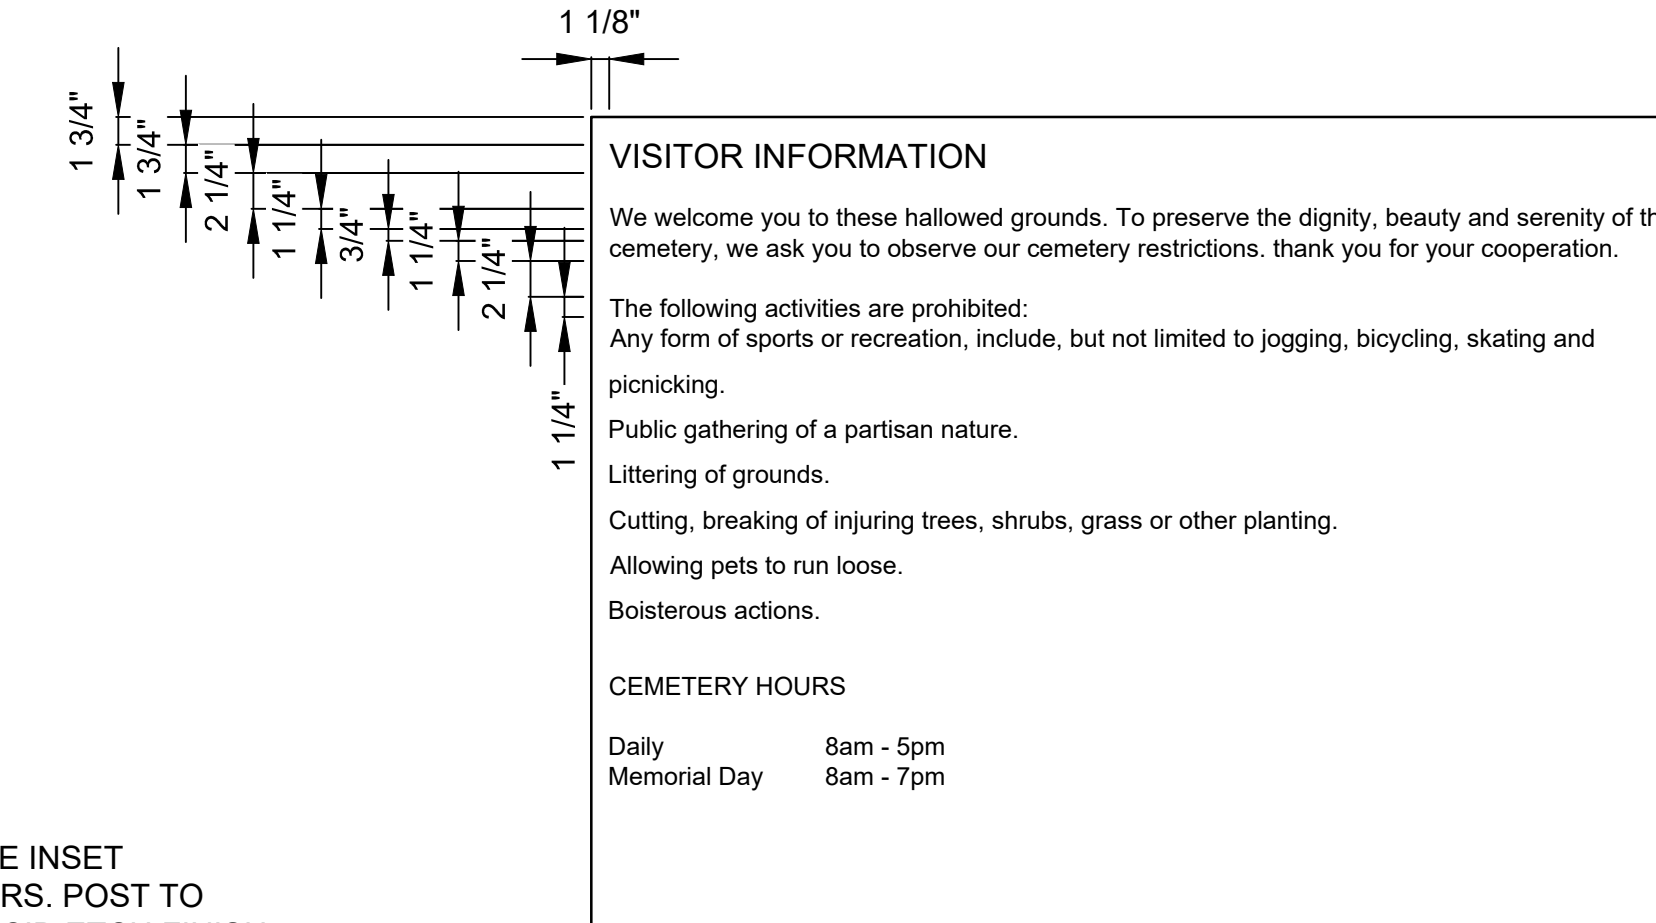


SIGN 5a BLUE BACKGROUND, TYPICAL

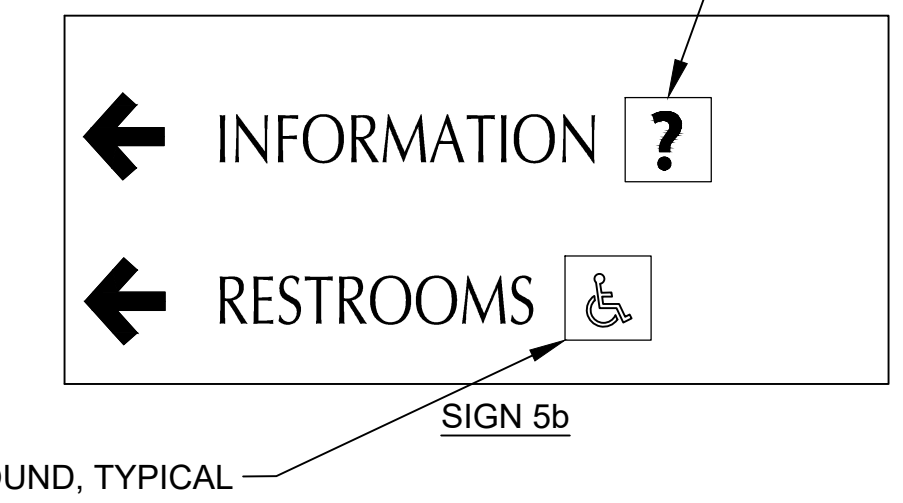


SIGN 5b BLUE BACKGROUND, TYPICAL

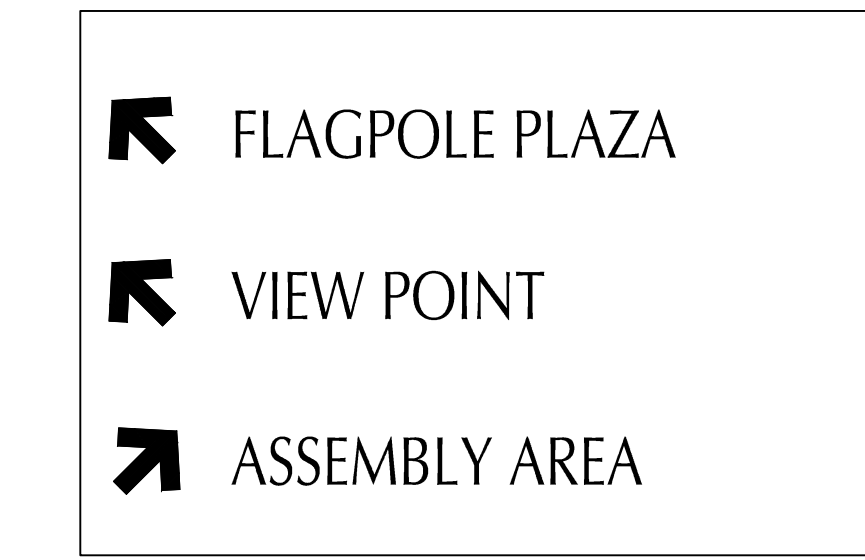

SIGN 6a


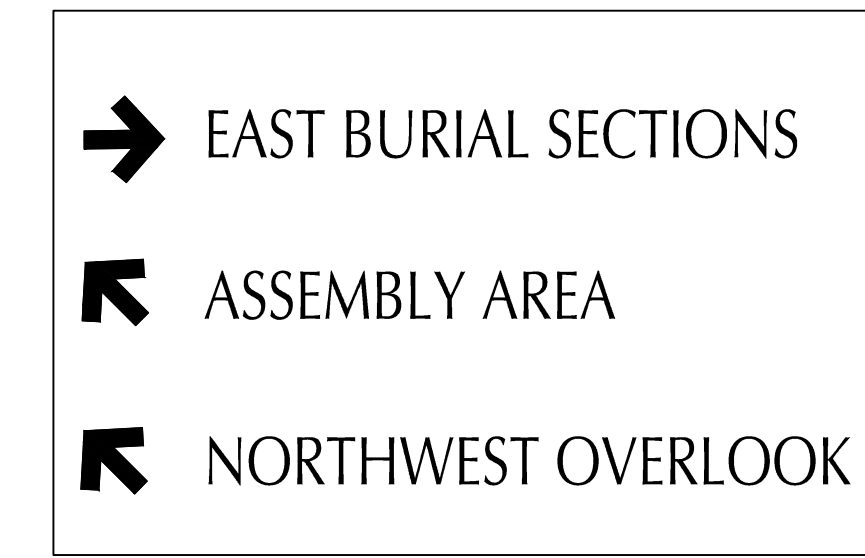


SIGN 6b


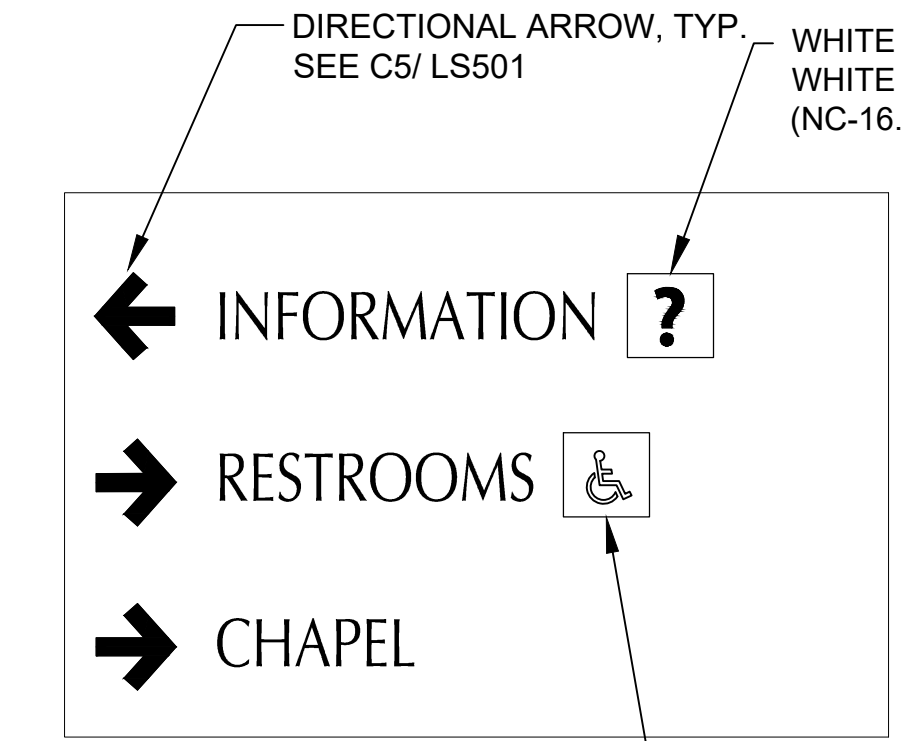


SIGN 6c


C8 DIRECTIONAL PANEL INFORMATION
LS501 1"=1'-0"

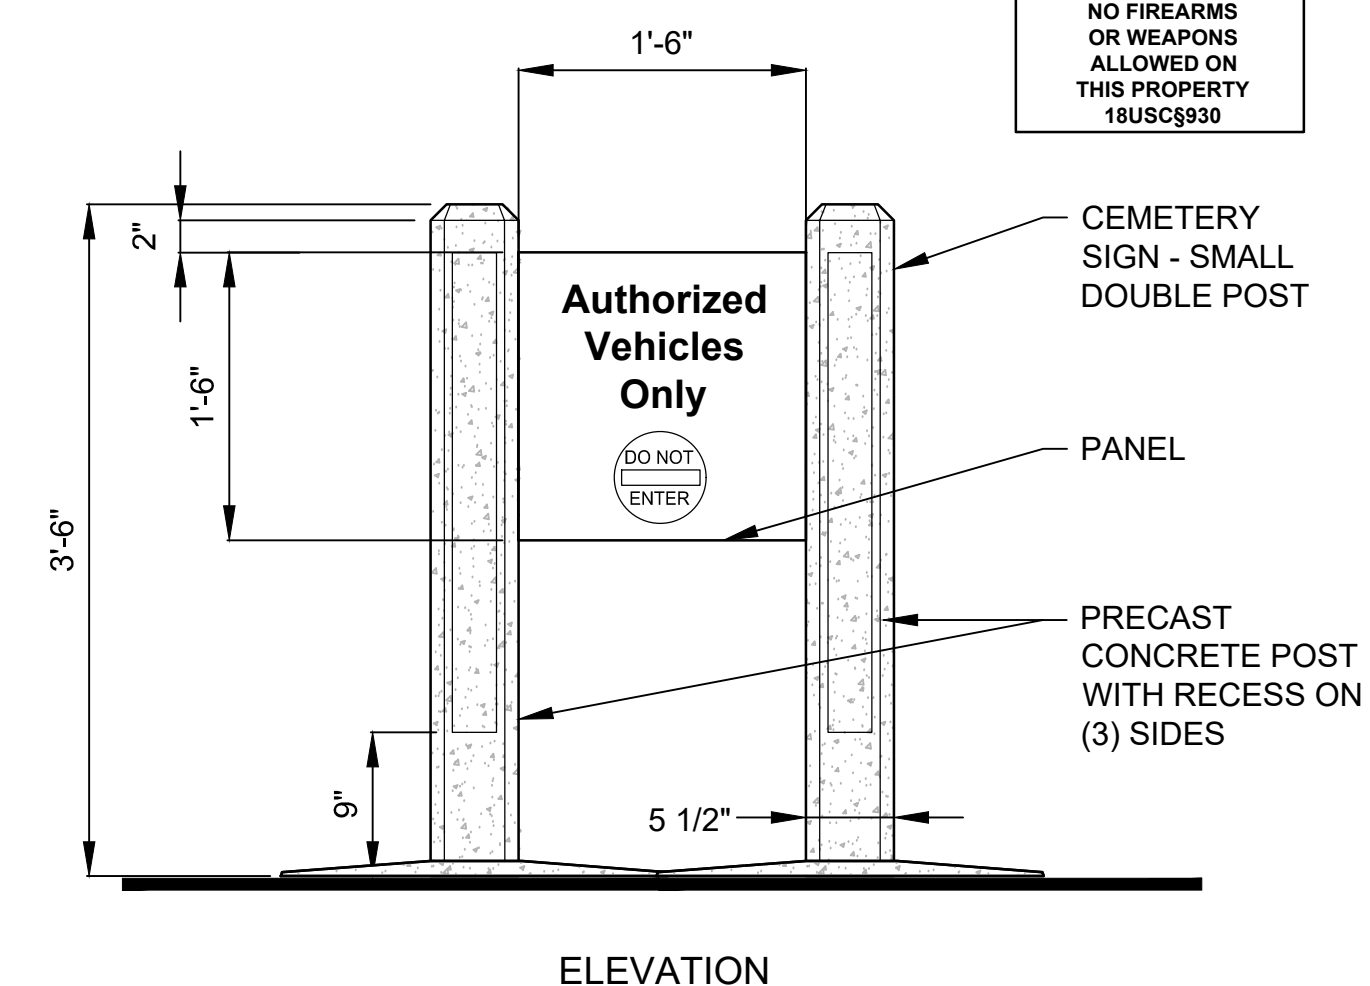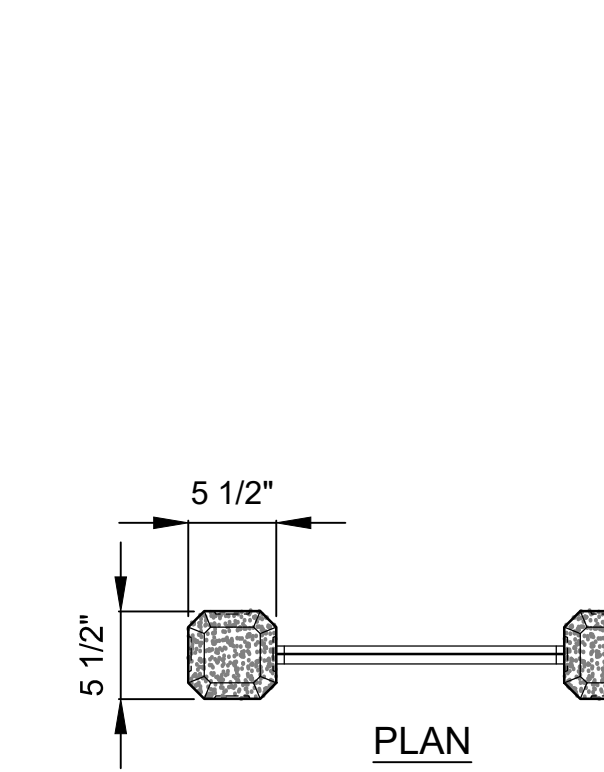

F8 SMALL DOUBLE POST SIGN
LS101 1"=1'-0"

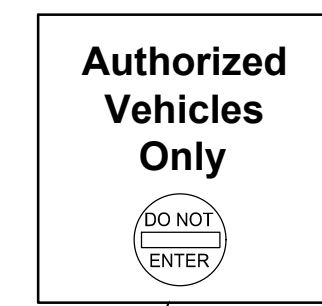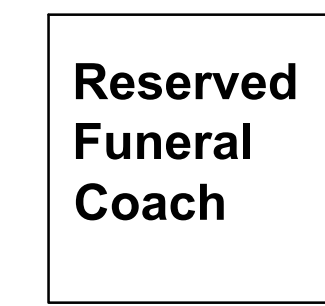


NC-03.01 MESSAGE LAYOUT G

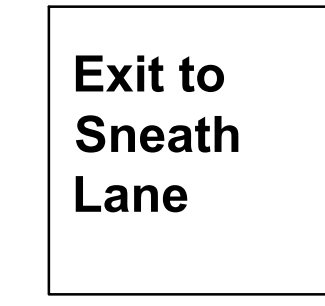

NC-01.03 MESSAGE LAYOUT D

I:\11-1898 WA NCA DDC\1898.036 Golden Gate NC Repair Road\Drawings\Landscaping\Shared\950301848-LS502.dwg 5:04:18 01-24-16 PM jmalley


Revisions	Date

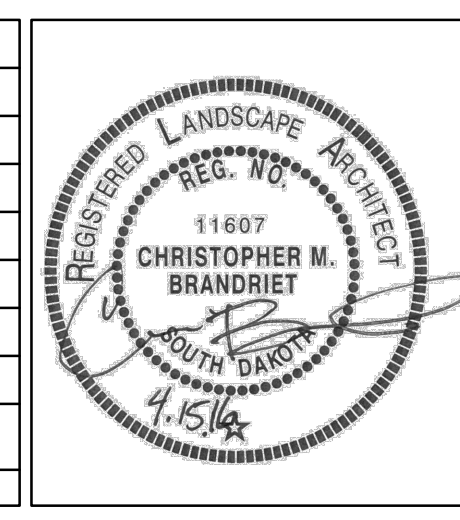

Architect/Engineers

517 7th street rapid city sd 57701
ph: 605.342.9470 fax: 605.342.2377
www.4front.biz
ARCHITECTURE | ENGINEERING



Subconsultant List
PROFESSIONAL LAND SERVICES, 901 SNEATH LANE, STE. 117, SAN BRUNO, CA 94066
NEIL O. ANDERSON AND ASSOCIATES, A TERRACON COMPANY, 5075 COMMERCIAL CIRCLE, STE. E, CONCORD, CA 94520

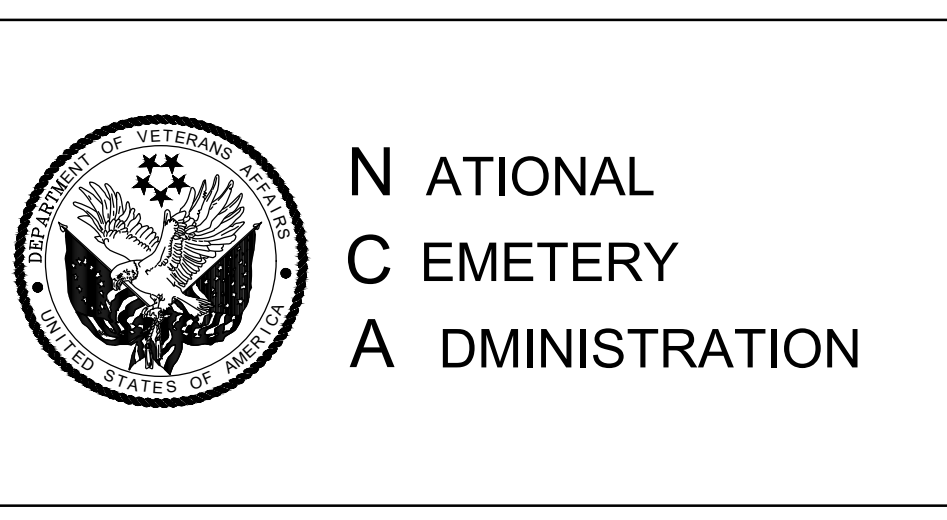

Drawing Title	SIGNAGE DETAILS #2		
Approved: Director, Office of Construction Management	Building Number	Checked	Drawn
		EH	CB/AW
Approved: Director, Project Management Service	Location		
	GOLDEN GATE NATIONAL CEMETERY SAN BRUNO, CALIFORNIA		

Project Title	REPAIR ROADS, CURBS, STORM DRAINAGE & REPLACE SIGNAGE		
Building Number		Checked	Drawn
		EH	CB/AW
Location	GOLDEN GATE NATIONAL CEMETERY SAN BRUNO, CALIFORNIA		


Date	APRIL 15, 2016
Project No.	895CM3048
DRAWING NO.	LS502
Dwg	139 Of 141

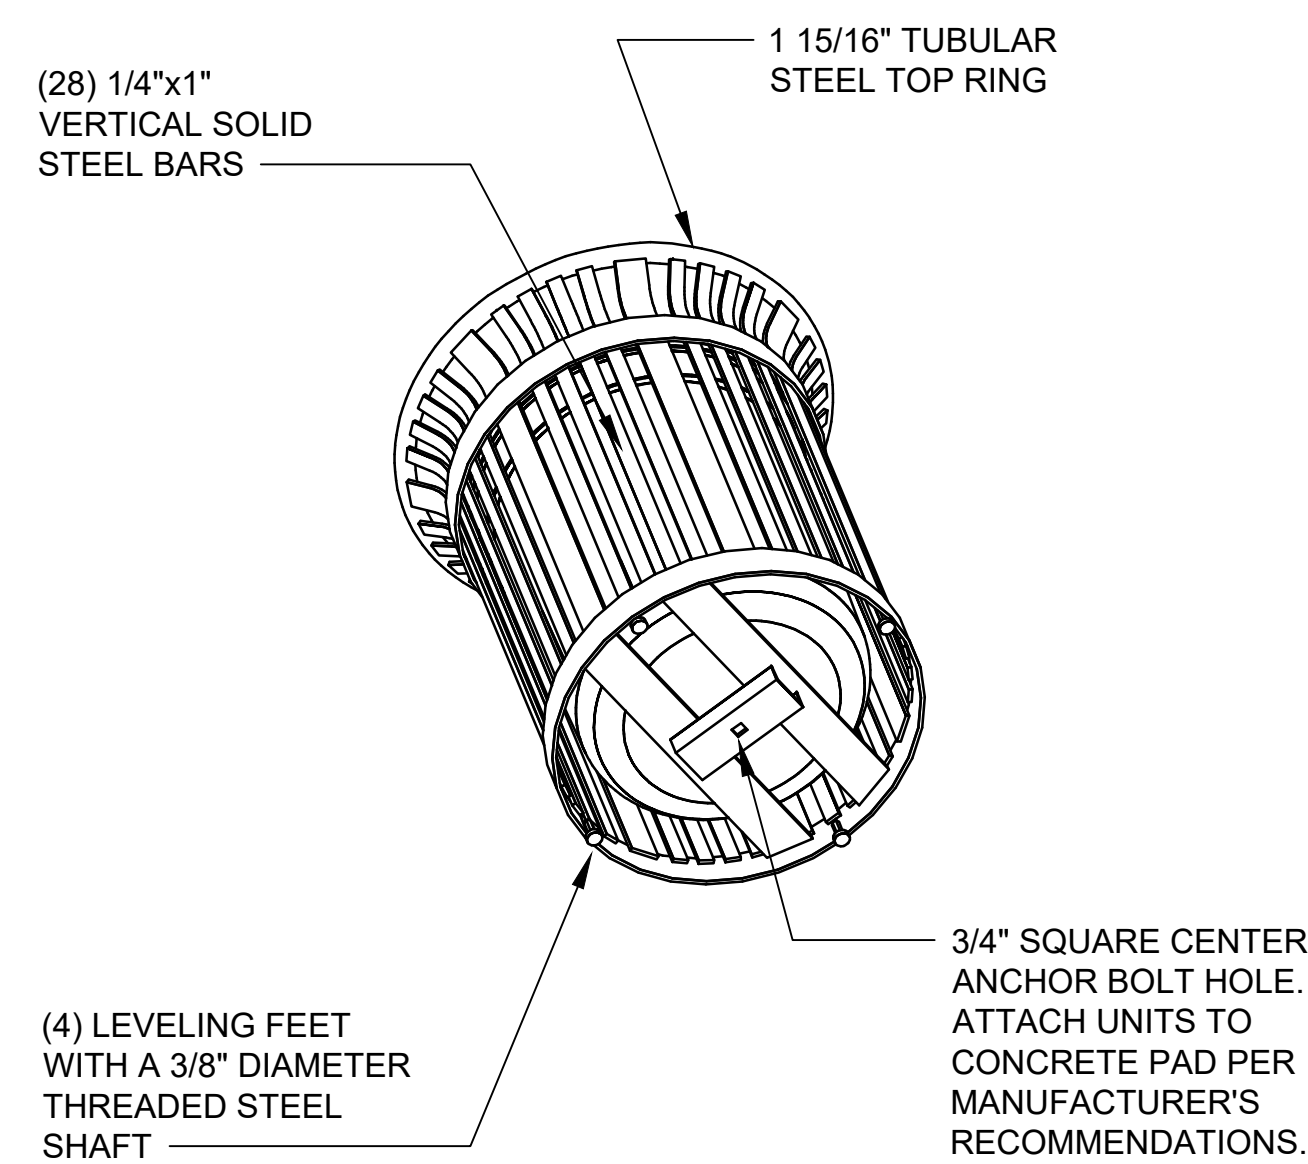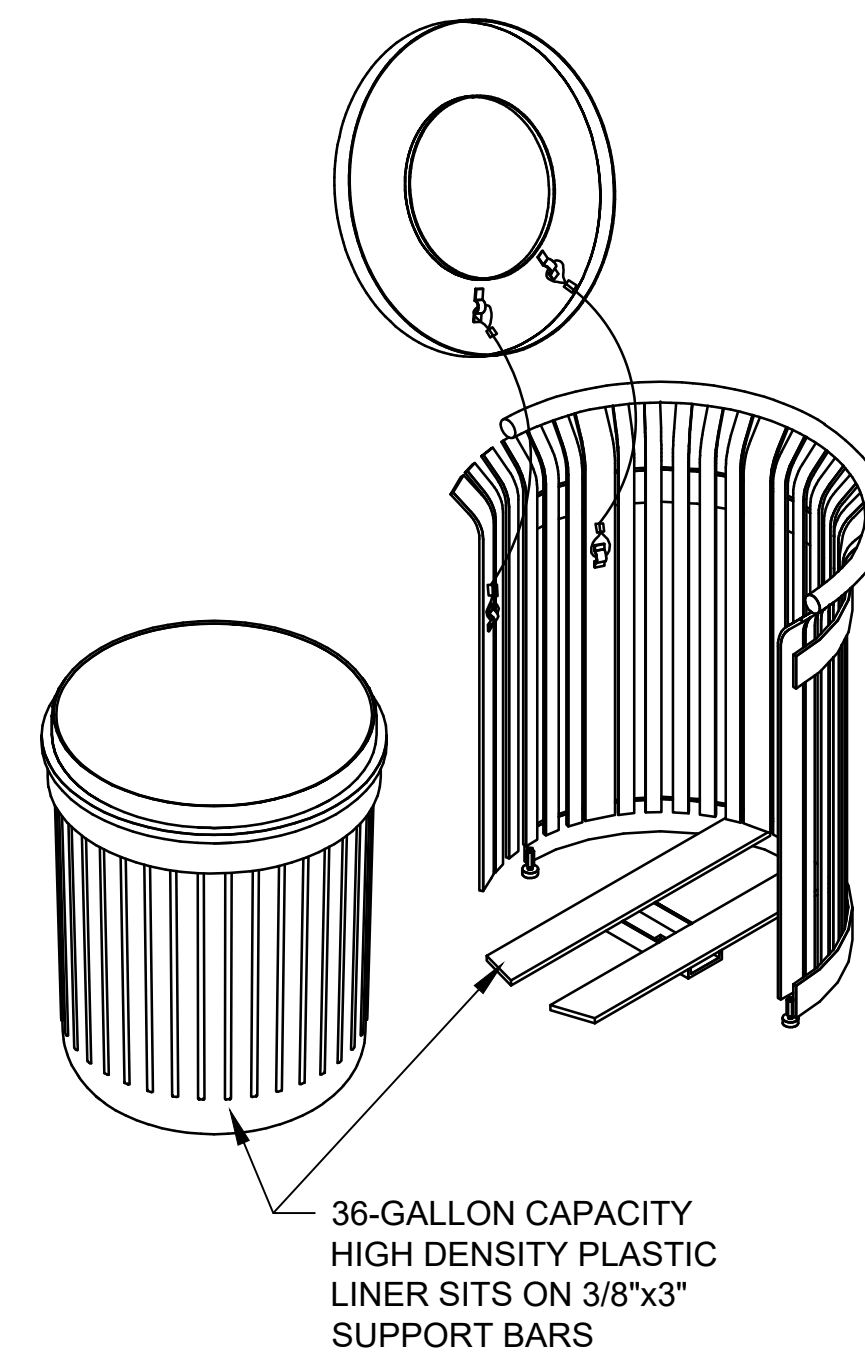



TRASH RECEPTACLE:
 IRONSITES® SERIES LITTER RECEPTACLE, MODEL NO. S-42, (36-GALLON CAPACITY). COLOR BLACK, OR APPROVED EQUAL.
 TO MATCH: VICTOR STANLEY
 P.O. BOX DRAWER 330 - DUNKIRK, MD 20754
 TEL (301) 855-8300 - FAX (410) 257-7579
 www.victorstanley.com

WHITE VINYL TEXT ON SINGLE CLEAR DECAL APPLIED TO STEEL BAND, (4) MIN. PER CAN, TYPEFACE SHALL BE OPTIMA BOLD, 1 1/2" HEIGHT LETTERS, TYP.

FLOWER VASE RECEPTACLE:
 IRONSITES® SERIES LITTER RECEPTACLE, MODEL NO. S-424, (36-GALLON CAPACITY) WITH HINGED LID. COLOR BLACK, OR APPROVED EQUAL.
 TO MATCH:
 VICTOR STANLEY
 P.O. BOX DRAWER 330 - DUNKIRK, MD 20754
 TEL (301) 855-8300 - FAX (410) 257-7579
 www.victorstanley.com

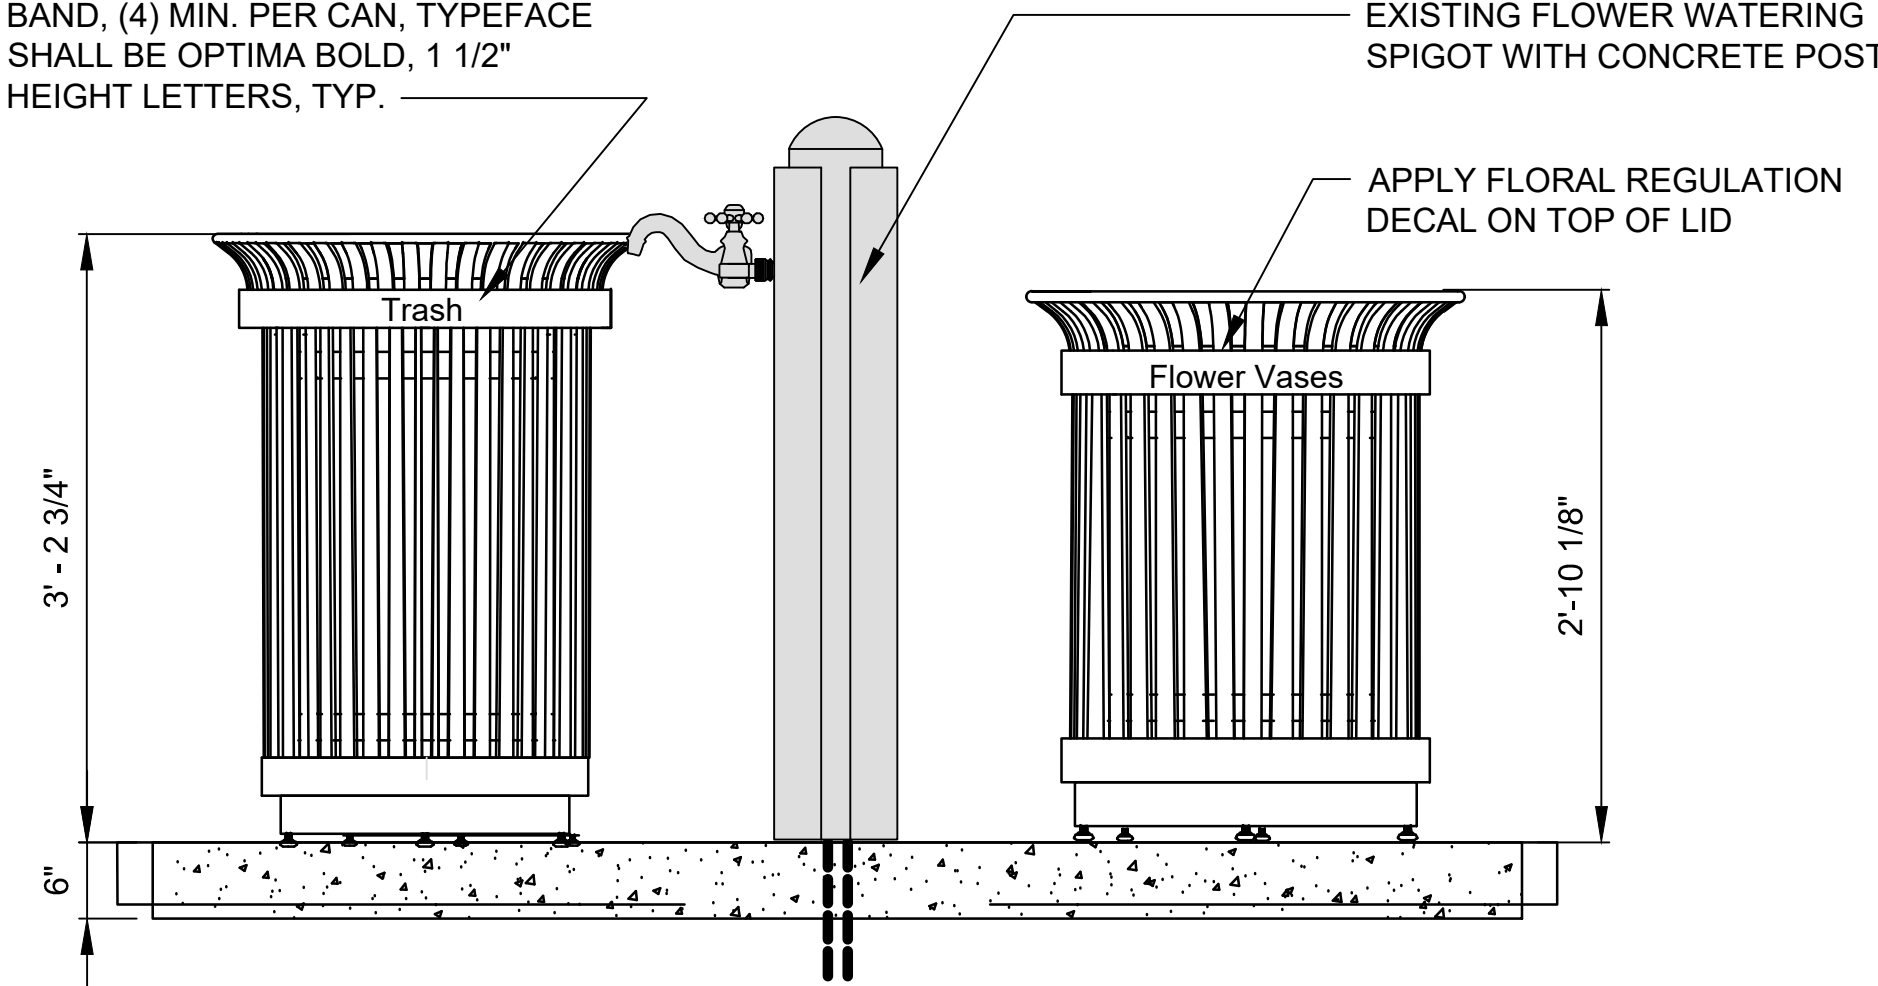


SECTION

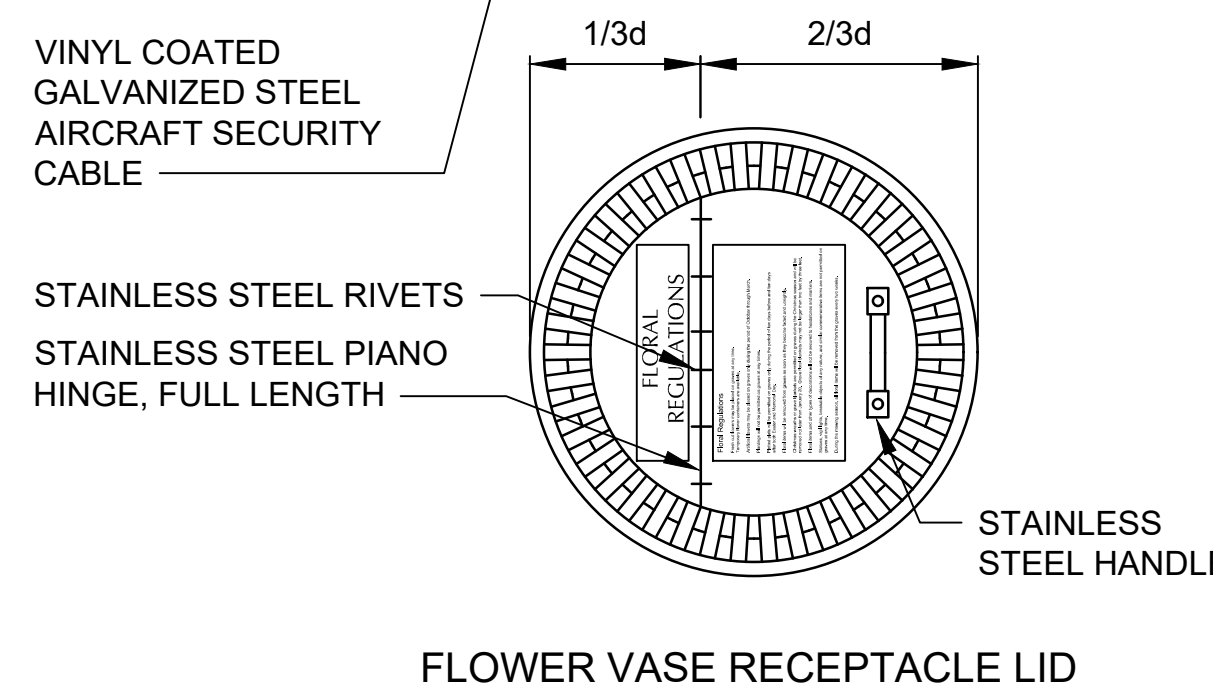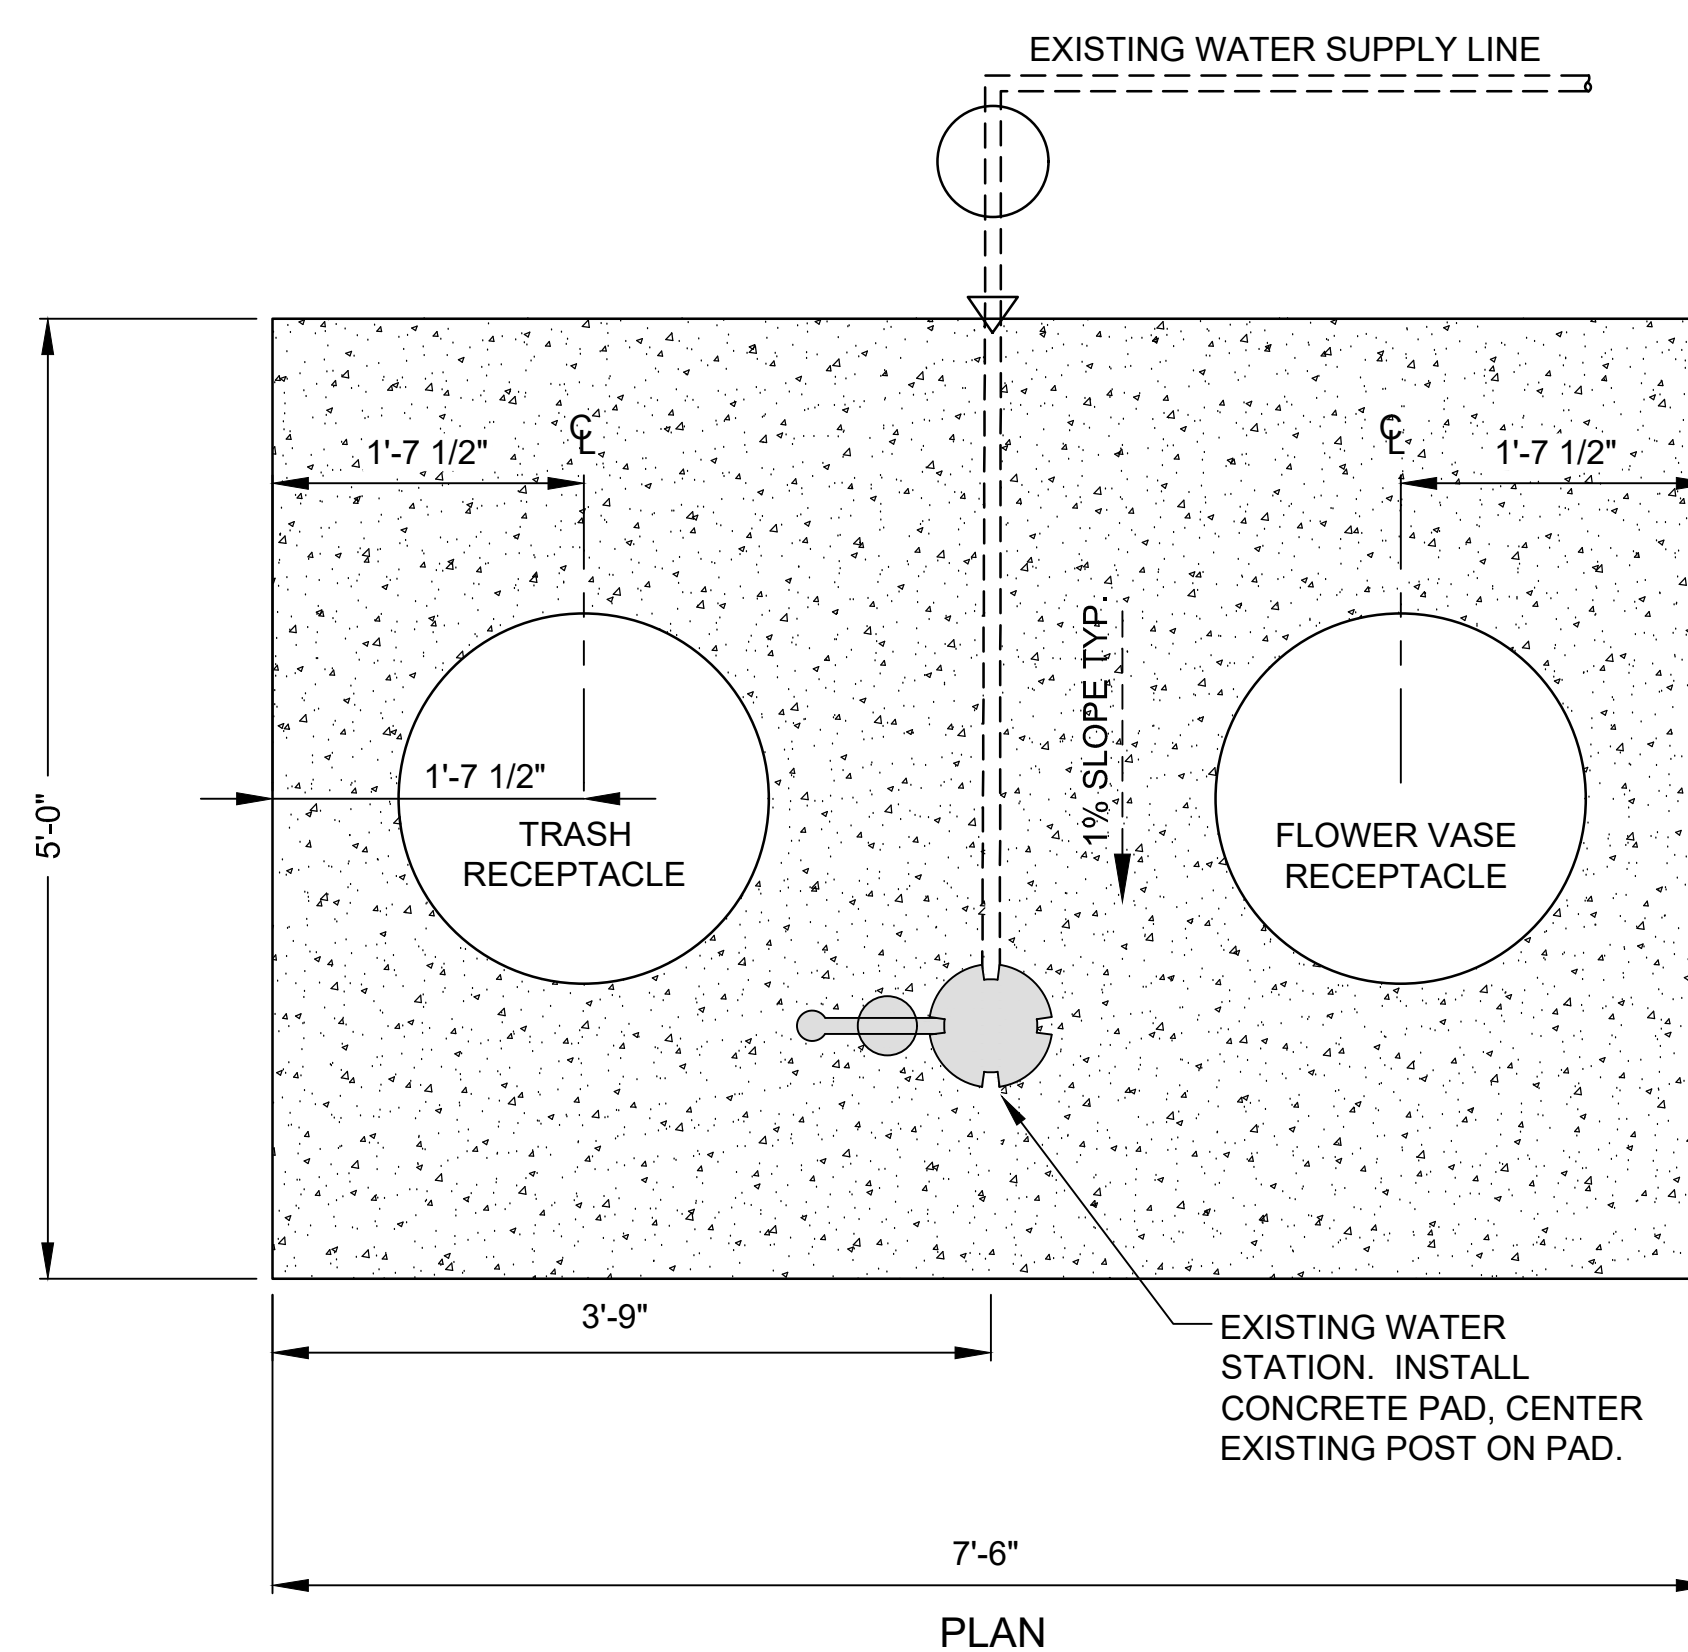

NOTES:

1. CONCRETE PAD TO SLOPE TOWARD ROAD.
2. SEE F6 / C-502 FOR CONCRETE PAD SECTION.

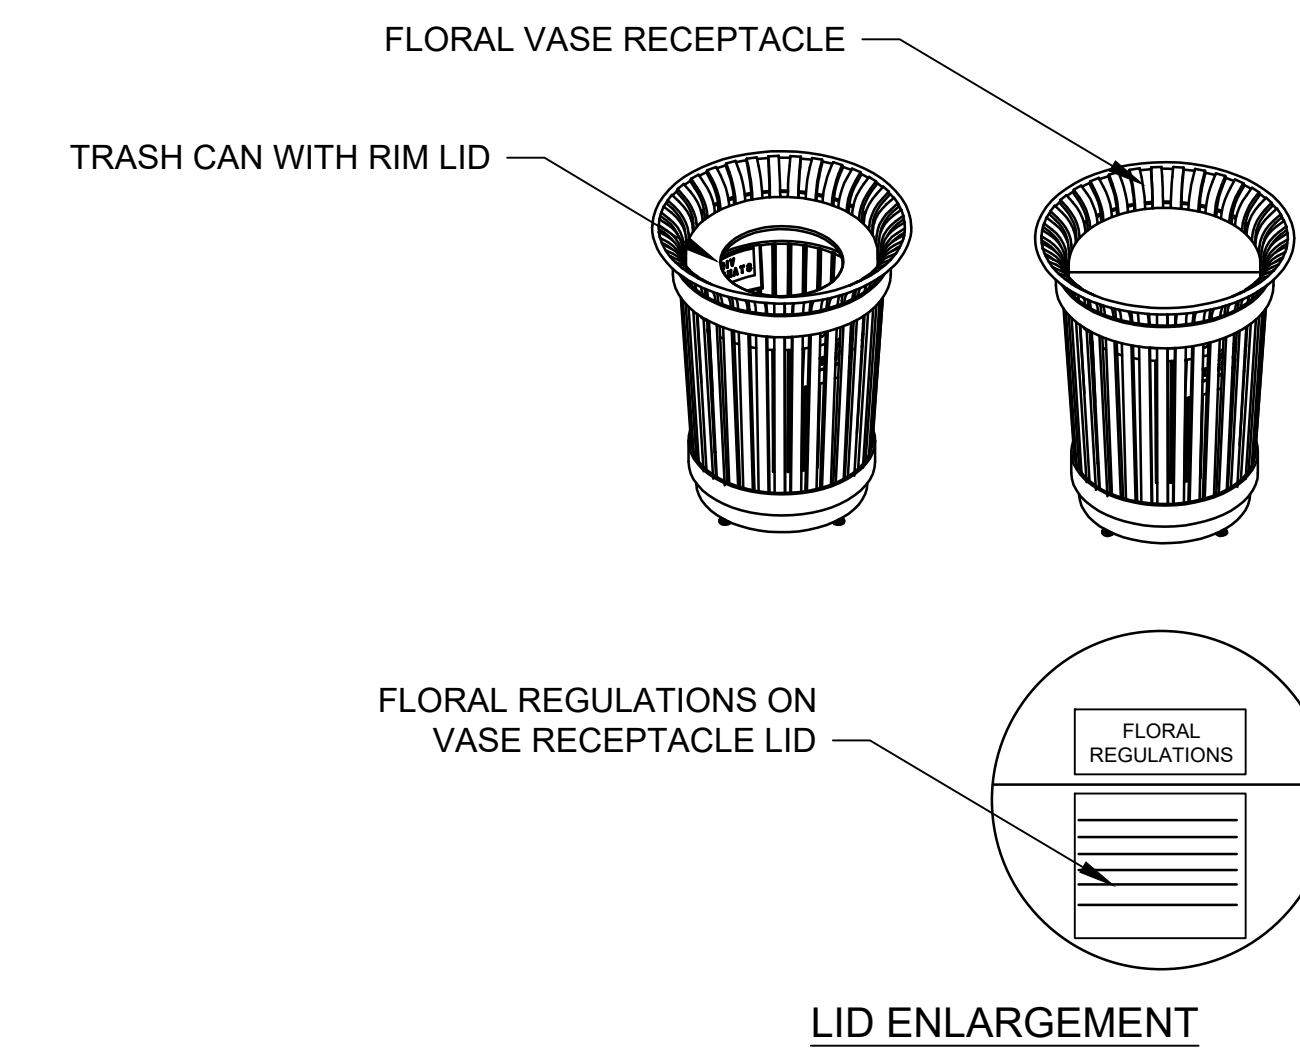

FLORAL REGULATIONS

Floral Regulations

Fresh cut flowers may be placed on graves at any time. Temporary flower containers are available.

Artificial flowers may be placed on graves only during the period of October through March.

Plantings will not be permitted on graves at any times.

Plotted plats will be permitted on graves only during the period of ten days before and ten days after both Easter and Memorial Day.

Floral items will be removed from graves as soon as they become faded and unsightly.

Christmas wreaths or grave blankets are permitted on graves during the Christmas season and will be removed not later than January 20. Grave floral blankets may not be larger than two feet by three feet.

Floral items and other types of decorations will not be secured to headstones and markers.

Statues, vigil lights, breakable objects of any nature, and similar commemorative items are not permitted on graves at any time.


During the mowing season, all floral items will be removed from the graves every two weeks.

FLORAL REGULATIONS ENLARGEMENT

E6
LS105 TRASH AND FLORAL VASE RECEPTACLE
NOT TO SCALE

I:\11-1898 WA NCA DDC\11898\11898-036 Golden Gate NC Repair Road\Drawings\Landscape\Sheet\895CM3048-LS503.dwg 2:03:16 11:22:19 AM jmalloy

Revisions	Date

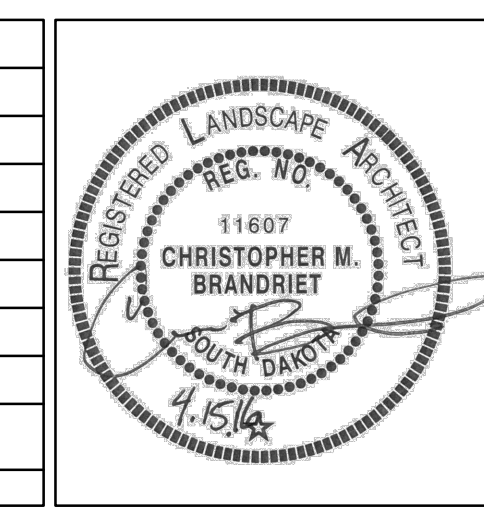


Architect/Engineers

517 7th street rapid city sd 57701
 ph: 605.342.9470 fax: 605.342.2377
 www.4front.biz

ARCHITECTURE | ENGINEERING

Subconsultant List

PROFESSIONAL LAND SERVICES, 901 SNEATH LANE, STE. 117, SAN BRUNO, CA 94066
NEIL O. ANDERSON AND ASSOCIATES, A TERRACON COMPANY, 5075 COMMERCIAL CIRCLE, STE. E, CONCORD, CA 94520

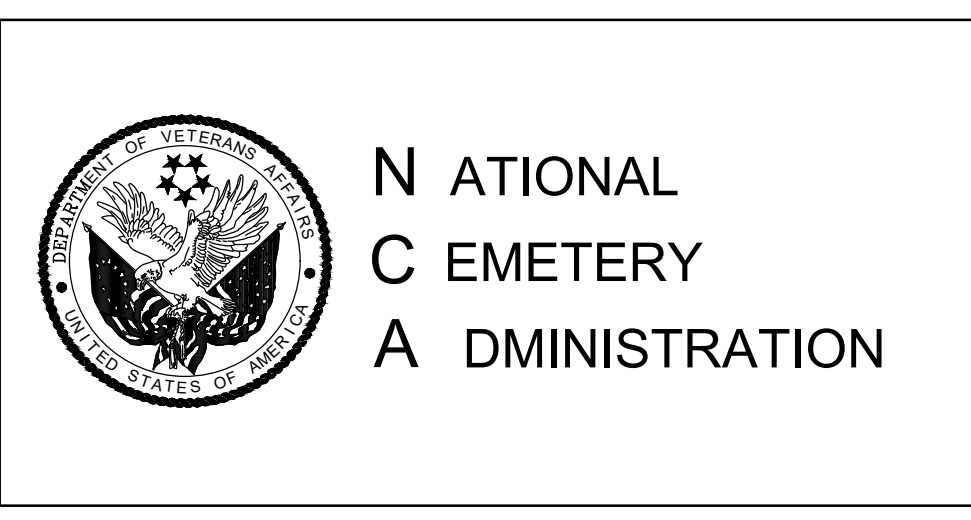


Drawing Title	
SITE FURNISHING DETAILS	
Approved: Director, Office of Construction Management	
Approved: Director, Project Management Service	

Project Title		
REPAIR ROADS, CURBS, STORM DRAINAGE & REPLACE SIGNAGE		
Building Number	Checked	Drawn
----	EH	CB/AW
Location		
GOLDEN GATE NATIONAL CEMETERY SAN BRUNO, CALIFORNIA		

Date:	APRIL 15, 2016
Project No.	895CM3048
DRAWING NO.	LS503
Dwg. 140 of 141	


LEGEND

 ADDITIONAL IRRIGATION ZONES AND COVERAGE - SEE I-101

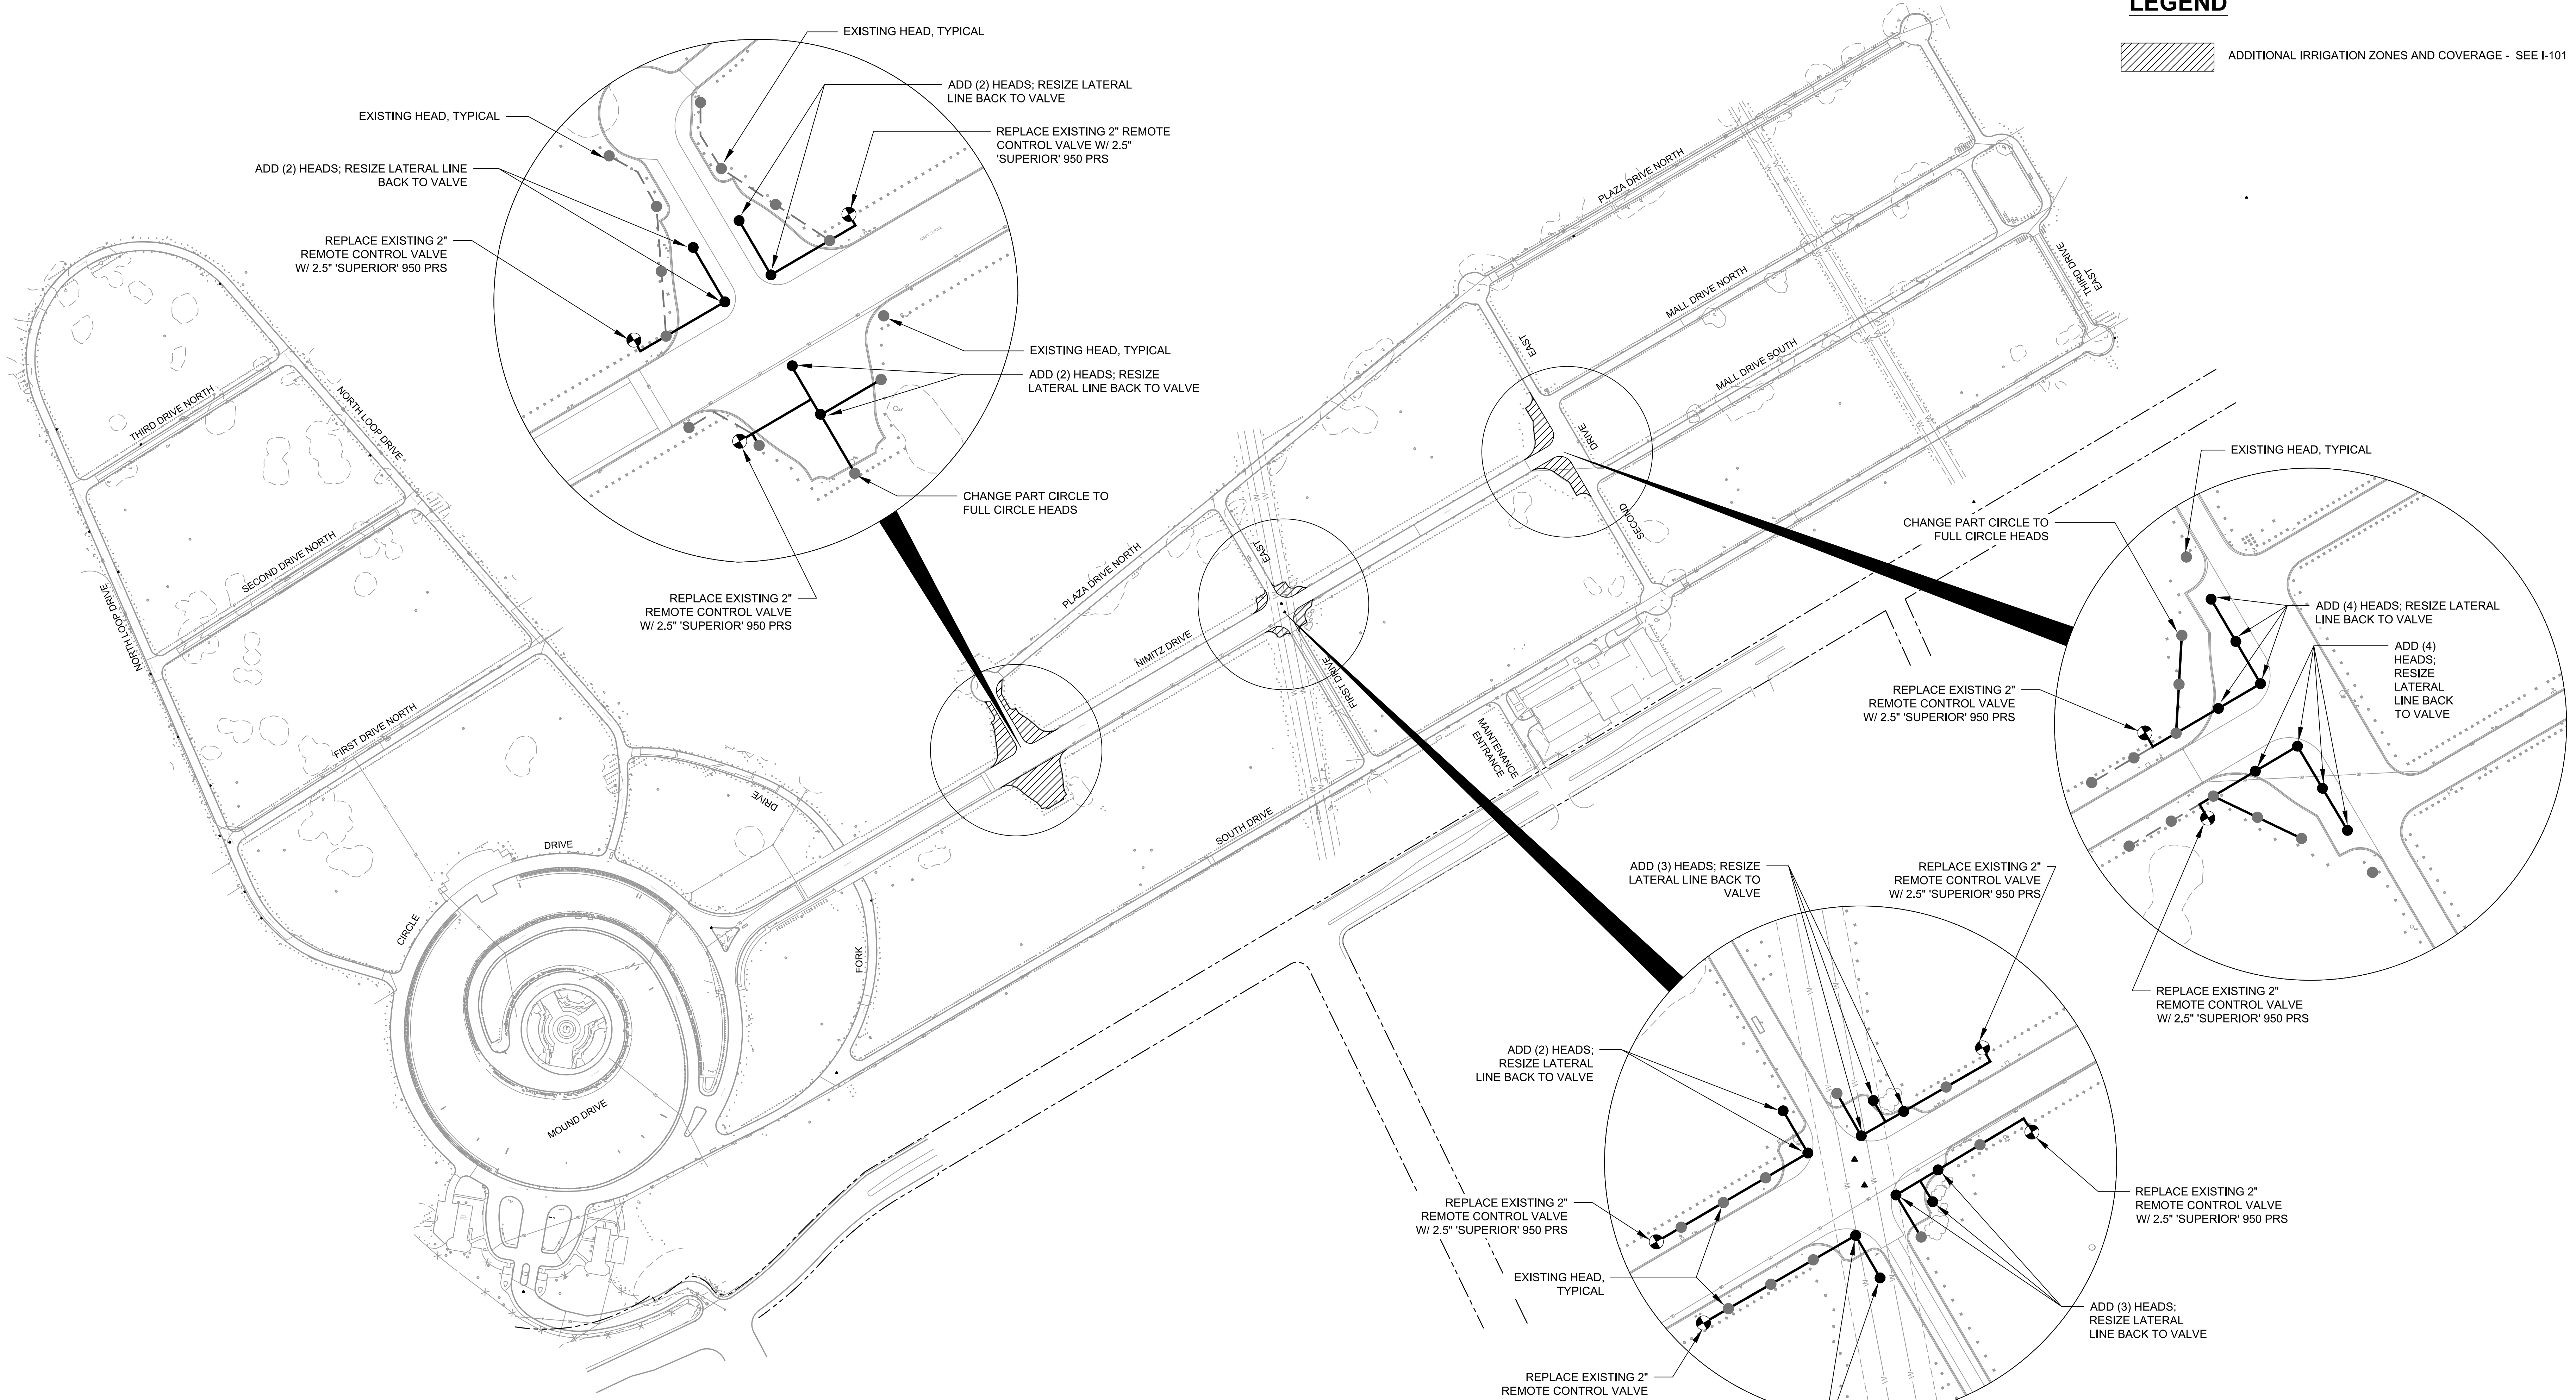


IRRIGATION NOTES

1. PROVIDE IRRIGATION SHOP DRAWINGS FOR APPROVAL OF COR.
2. MODIFY EXISTING IRRIGATION ZONES BY ADDING TURF ROTOR HEADS TO PROVIDE HEAD-TO-HEAD COVERAGE. BASIS OF DESIGN 'RAINBIRD' 8005-14.
3. ADJUST LOCATIONS OF ADJACENT EXISTING HEADS AS REQUIRED. FLAG LOCATIONS OF HEADS IN FIELD FOR APPROVAL OF COR PRIOR TO INSTALLATION.
4. EXCHANGE PART CIRCLE HEADS WITH FULL CIRCLE HEADS AS REQUIRED. EXCHANGE NOZZLES ON EXISTING HEADS TO PROVIDE MATCHED PRECIPITATION RATES FOR ALL HEADS ON SAME VALVE.
5. UPSIZE LATERAL LINES BACK TO EXISTING REMOVE CONTROL VALVES TO ACCOMMODATE INCREASED FLOW (GPM).

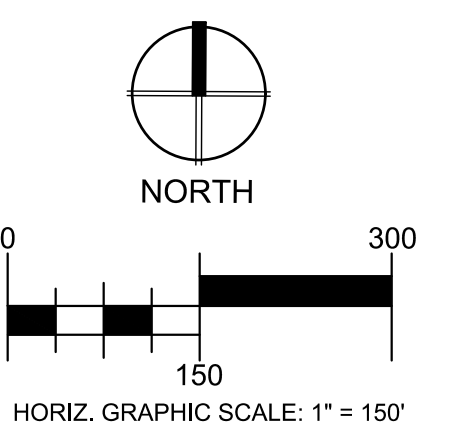


L:\10-1098-VA-NCA\10101-1098\038 Golden Gate, NC Regain Roads\Drawings\Landscaping\Sheets\895CM3048-I-101.dwg 6/25/16 10:29:32 AM jmalley

Revisions	Date

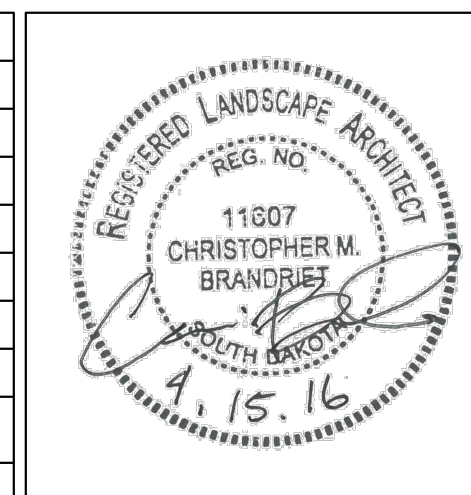


Architect/Engineers



517 7th street rapid city sd 57701
 ph: 605.342.9470 fax: 605.342.2377
 www.4front.biz
 ARCHITECTURE | ENGINEERING

Subconsultant List
PROFESSIONAL LAND SERVICES, 901 SNEATH LANE, STE. 117, SAN BRUNO, CA 94066
NEIL O. ANDERSON AND ASSOCIATES, A TERRACON COMPANY, 5075 COMMERCIAL CIRCLE, STE. E, CONCORD, CA 94520



**NATIONAL
 CEMETERY
 ADMINISTRATION**

Drawing Title		Project Title		Date:
IRRIGATION PLAN		REPAIR ROADS, CURBS, STORM DRAINAGE & REPLACE SIGNAGE		APRIL 15, 2016
Approved: Director, Office of Construction Management		Building Number	Checked	Drawn
		---	EH	CB/AW
Approved: Director, Project Management Service		Location		
		GOLDEN GATE NATIONAL CEMETERY SAN BRUNO, CALIFORNIA		

Project No.	DRAWING NO.
895CM3048	I-101
Dwg. 141 Of 141	