



0
three inches = one foot
A
0
one and one-half inches = one foot
B
0
one inch = one foot
C
0
three-quarters inch = one foot
D
0
one-half inch = one foot
E
0
three-eighths inch = one foot
F
0
one-quarter inch = one foot
8
0
one-eighth inch = one foot
16

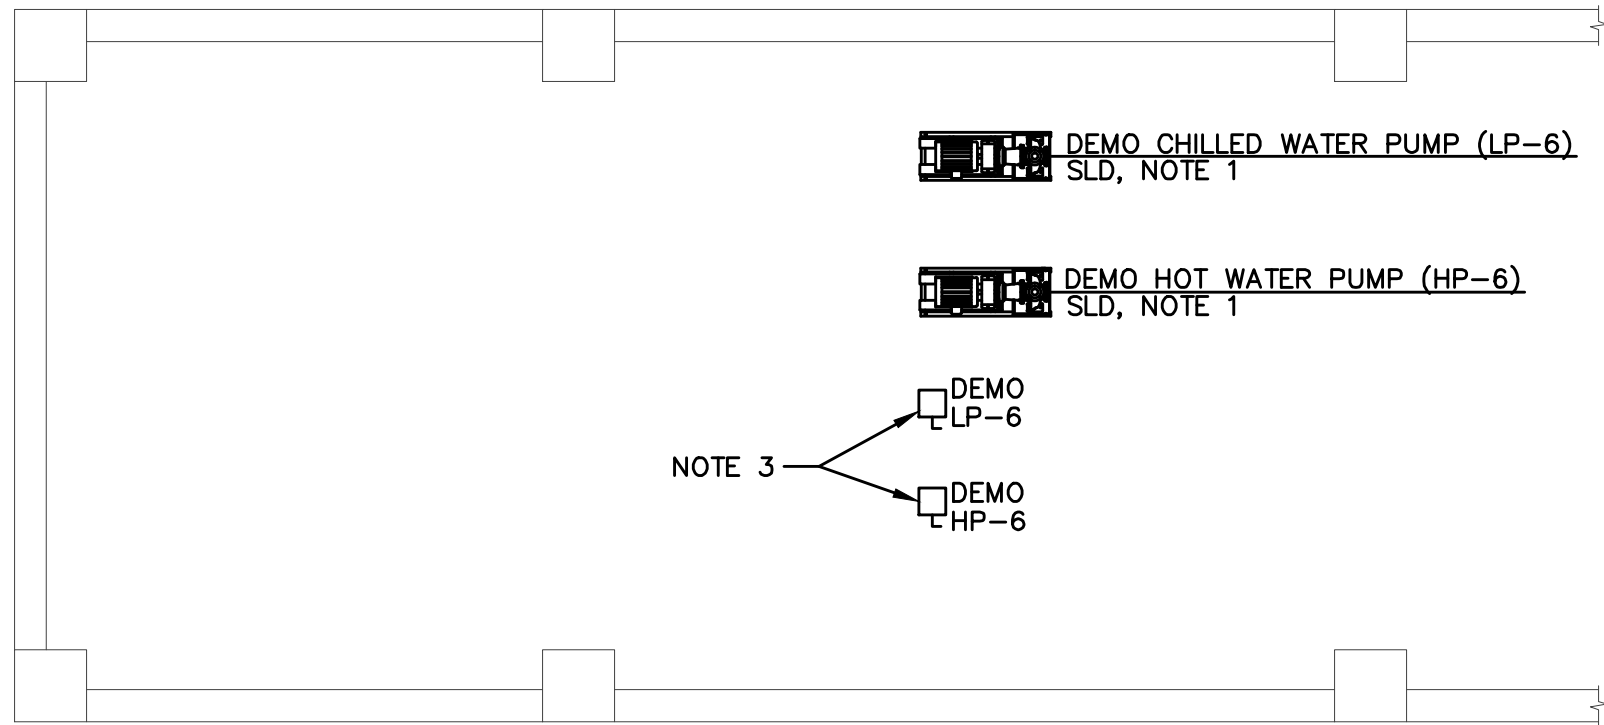


 PARTIAL PUMP ROOM FLOOR PLAN
ELECTRICAL — DEMOLITION
NOT TO SCALE

NOTES:


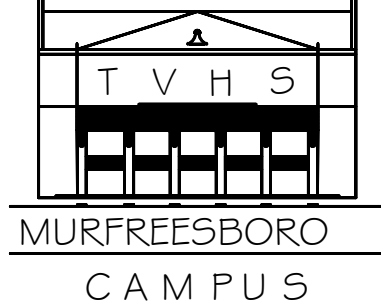
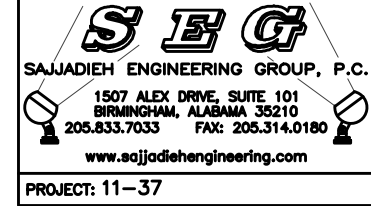
1. REMOVE DISCONNECT SWITCH FOR PUMPS. REMOVE CONDUCTORS AND CONDUITS BACK TO MOTOR CONTROL CENTER (MCC-6120) LOCATED ON GROUND FLOOR OF MECHANICAL ROOM G11. MARK COMBINATION CIRCUIT BREAKER/STARTER "SPARE".
2. INSTALL VFD AND DISCONNECT SWITCH ON UNISTRUT. SUPPORT UNISTRUT FROM FLOOR. SEE DETAIL ON SHEET 6-E1. COORDINATE EXACT LOCATION WITH MECHANICAL CONTRACTOR AND EQUIPMENT.
3. REMOVE EXISTING DISCONNECT SWITCHES AND MOUNTING STRUCTURE.

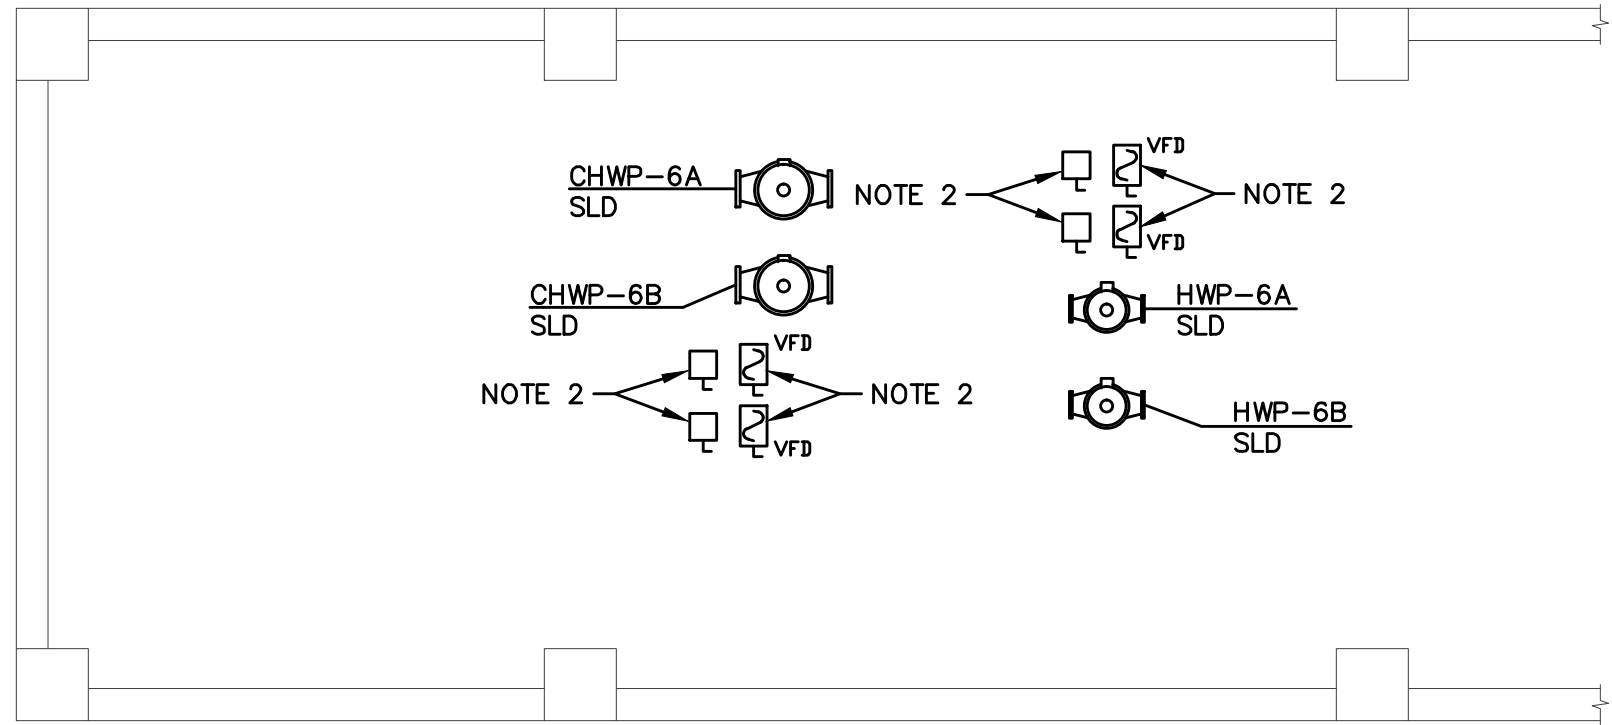

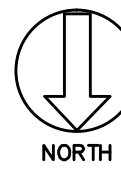 PARTIAL PUMP ROOM FLOOR PLAN
ELECTRICAL — NEW WORK
NOT TO SCALE



CONSTRUCTION DOCUMENTS

REV. A — ADDENDUM #1	3/21/12	<div><div>Tennessee Valley Healthcare System</div></div>	 <div>Approved: —</div> <div>Approved: —</div>	Drawing Title PARTIAL PUMP ROOM PLAN- ELECTRICAL Approved: Facility Manager Approved: Director	Project Title REPLACE ATTIC AHU'S- BLDG 6 Building Number 6 Checked JJB Drawn AL Location VAMC — MURFREESBORO	Date 03/21/2012 Project No. 626A4-11-204 DRAWING NO. 6-E5 FILE NAME —	Veterans Administration
----------------------	---------	--	---	--	---	--	----------------------------