


1 EXISTING UNDERGROUND CONDUITS.

3 EXISTING MAN HOLE, TYPICAL.

4 EXISTING MAINTENANCE BUILDING.

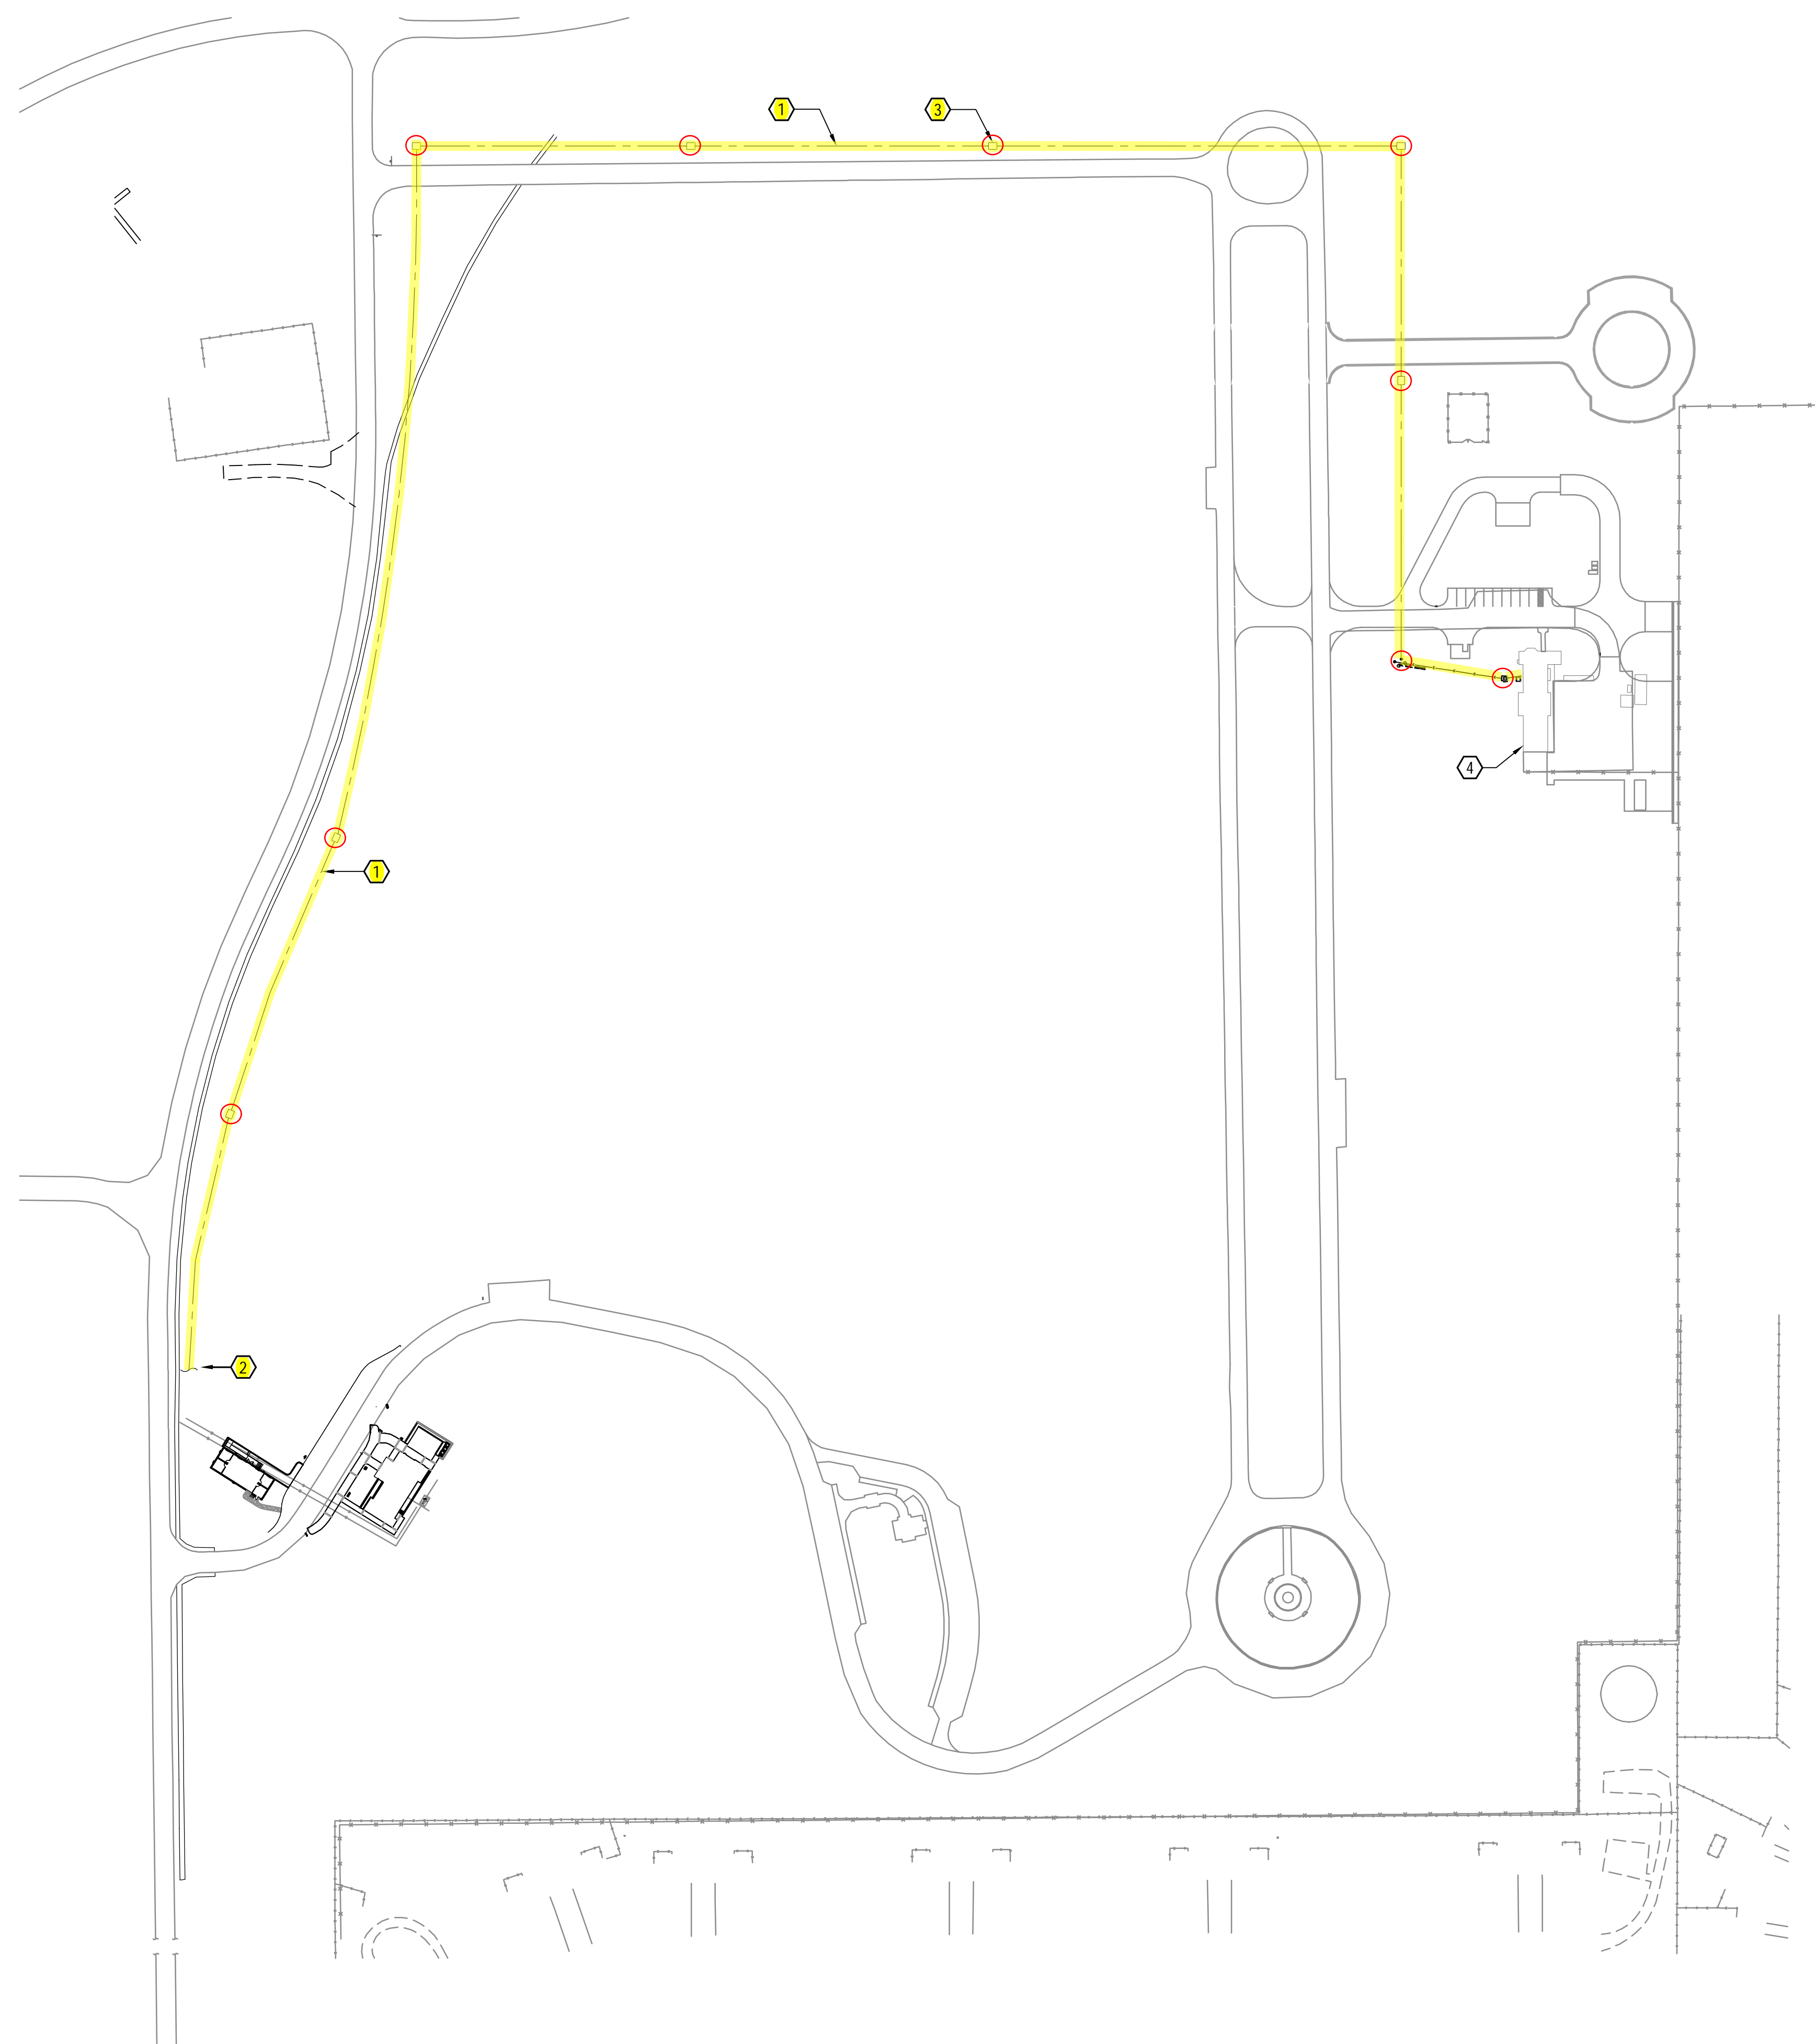

SCALE: 1" = 100'-0"

AS-BUILT DRAWINGS - JANUARY 2011

PREPARED FROM AS-BUILT DRAWINGS
PROVIDED BY US BUILDERS GROUP,
JANUARY, 2011.

Drawing Title OVERALL SITE ELECTRICAL PLAN	Project Title BILOXI NATIONAL CEMETERY REPLACE ADMINISTRATION BUILDING			Date: SEPTEMBER 21, 2009
	Approved: Director, Office of Construction Management			Project No. 832CM3018
Approved: Director, Project Management Service	Building Number 1001	Checked	Drawn	DRAWING NO. L-E1
	Location BILOXI NATIONAL CEMETERY BILOXI, MISSISSIPPI			Dwg. 59 Of 62

[illegible]

Subconsultant List		
DEYFUESS & BLACKFORD	3540 FOLSOM BOULEVARD, SACRAMENTO, CA 95816	(916)453-1234
CAPITAL ENGINEERING CONSULTANTS	11020 SUN CENTER DRIVE, RANCHO CORDOVA, CA 95670	(916) 851-3500
ECOM ENGINEERING INC.	1796 TRIBUTE ROAD, SUITE 100 SACRAMENTO, CA (916)	641-5600
BUCHLER & BUEHLER ASSOCIATES	600 Q STREET, STE. 200, SACRAMENTO, CA 95814	(916) 443-0303
SOUTHERN GEOMATICS, INC	21 TRUETT DRIVE, COVINGTON, LA 70435	(985) 264-7391
W.L. BURLE ENGINEERS, PA	111 S. WALNUT STREET, GREENVILLE, MS 38702	(662) 332-2619
THE SIERRA WEST GROUP, LLC	2730 GATEWAY OAKS DRIVE, STE. 110 SACRAMENTO, CA, 95833	(916) 925-4000



NATIONAL
CEMETERY
ADMINISTRATION