




ATTIC FLOOR PLAN
SCALE 1/4"=1'-0"

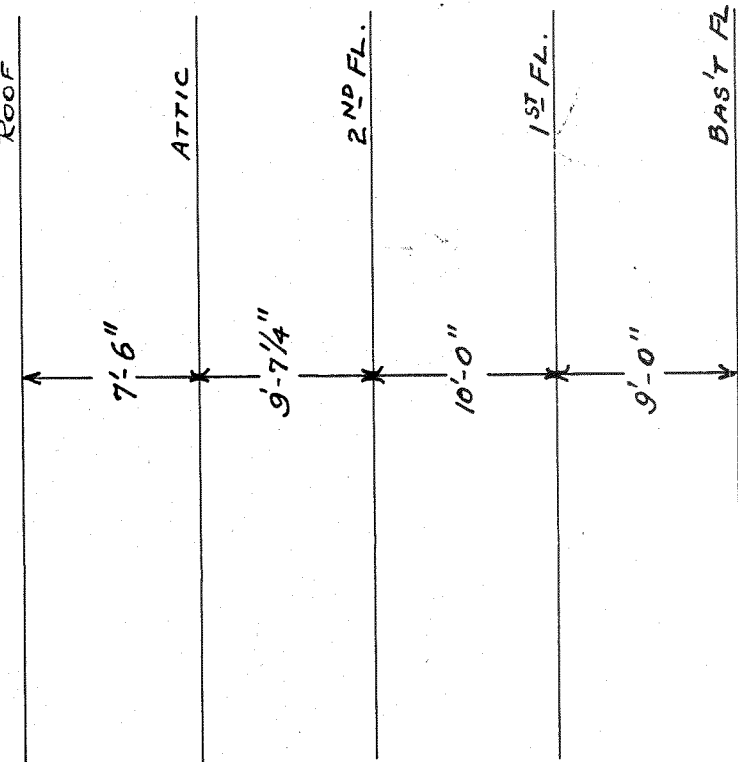


CEILING HEIGHTS
NOT TO SCALE

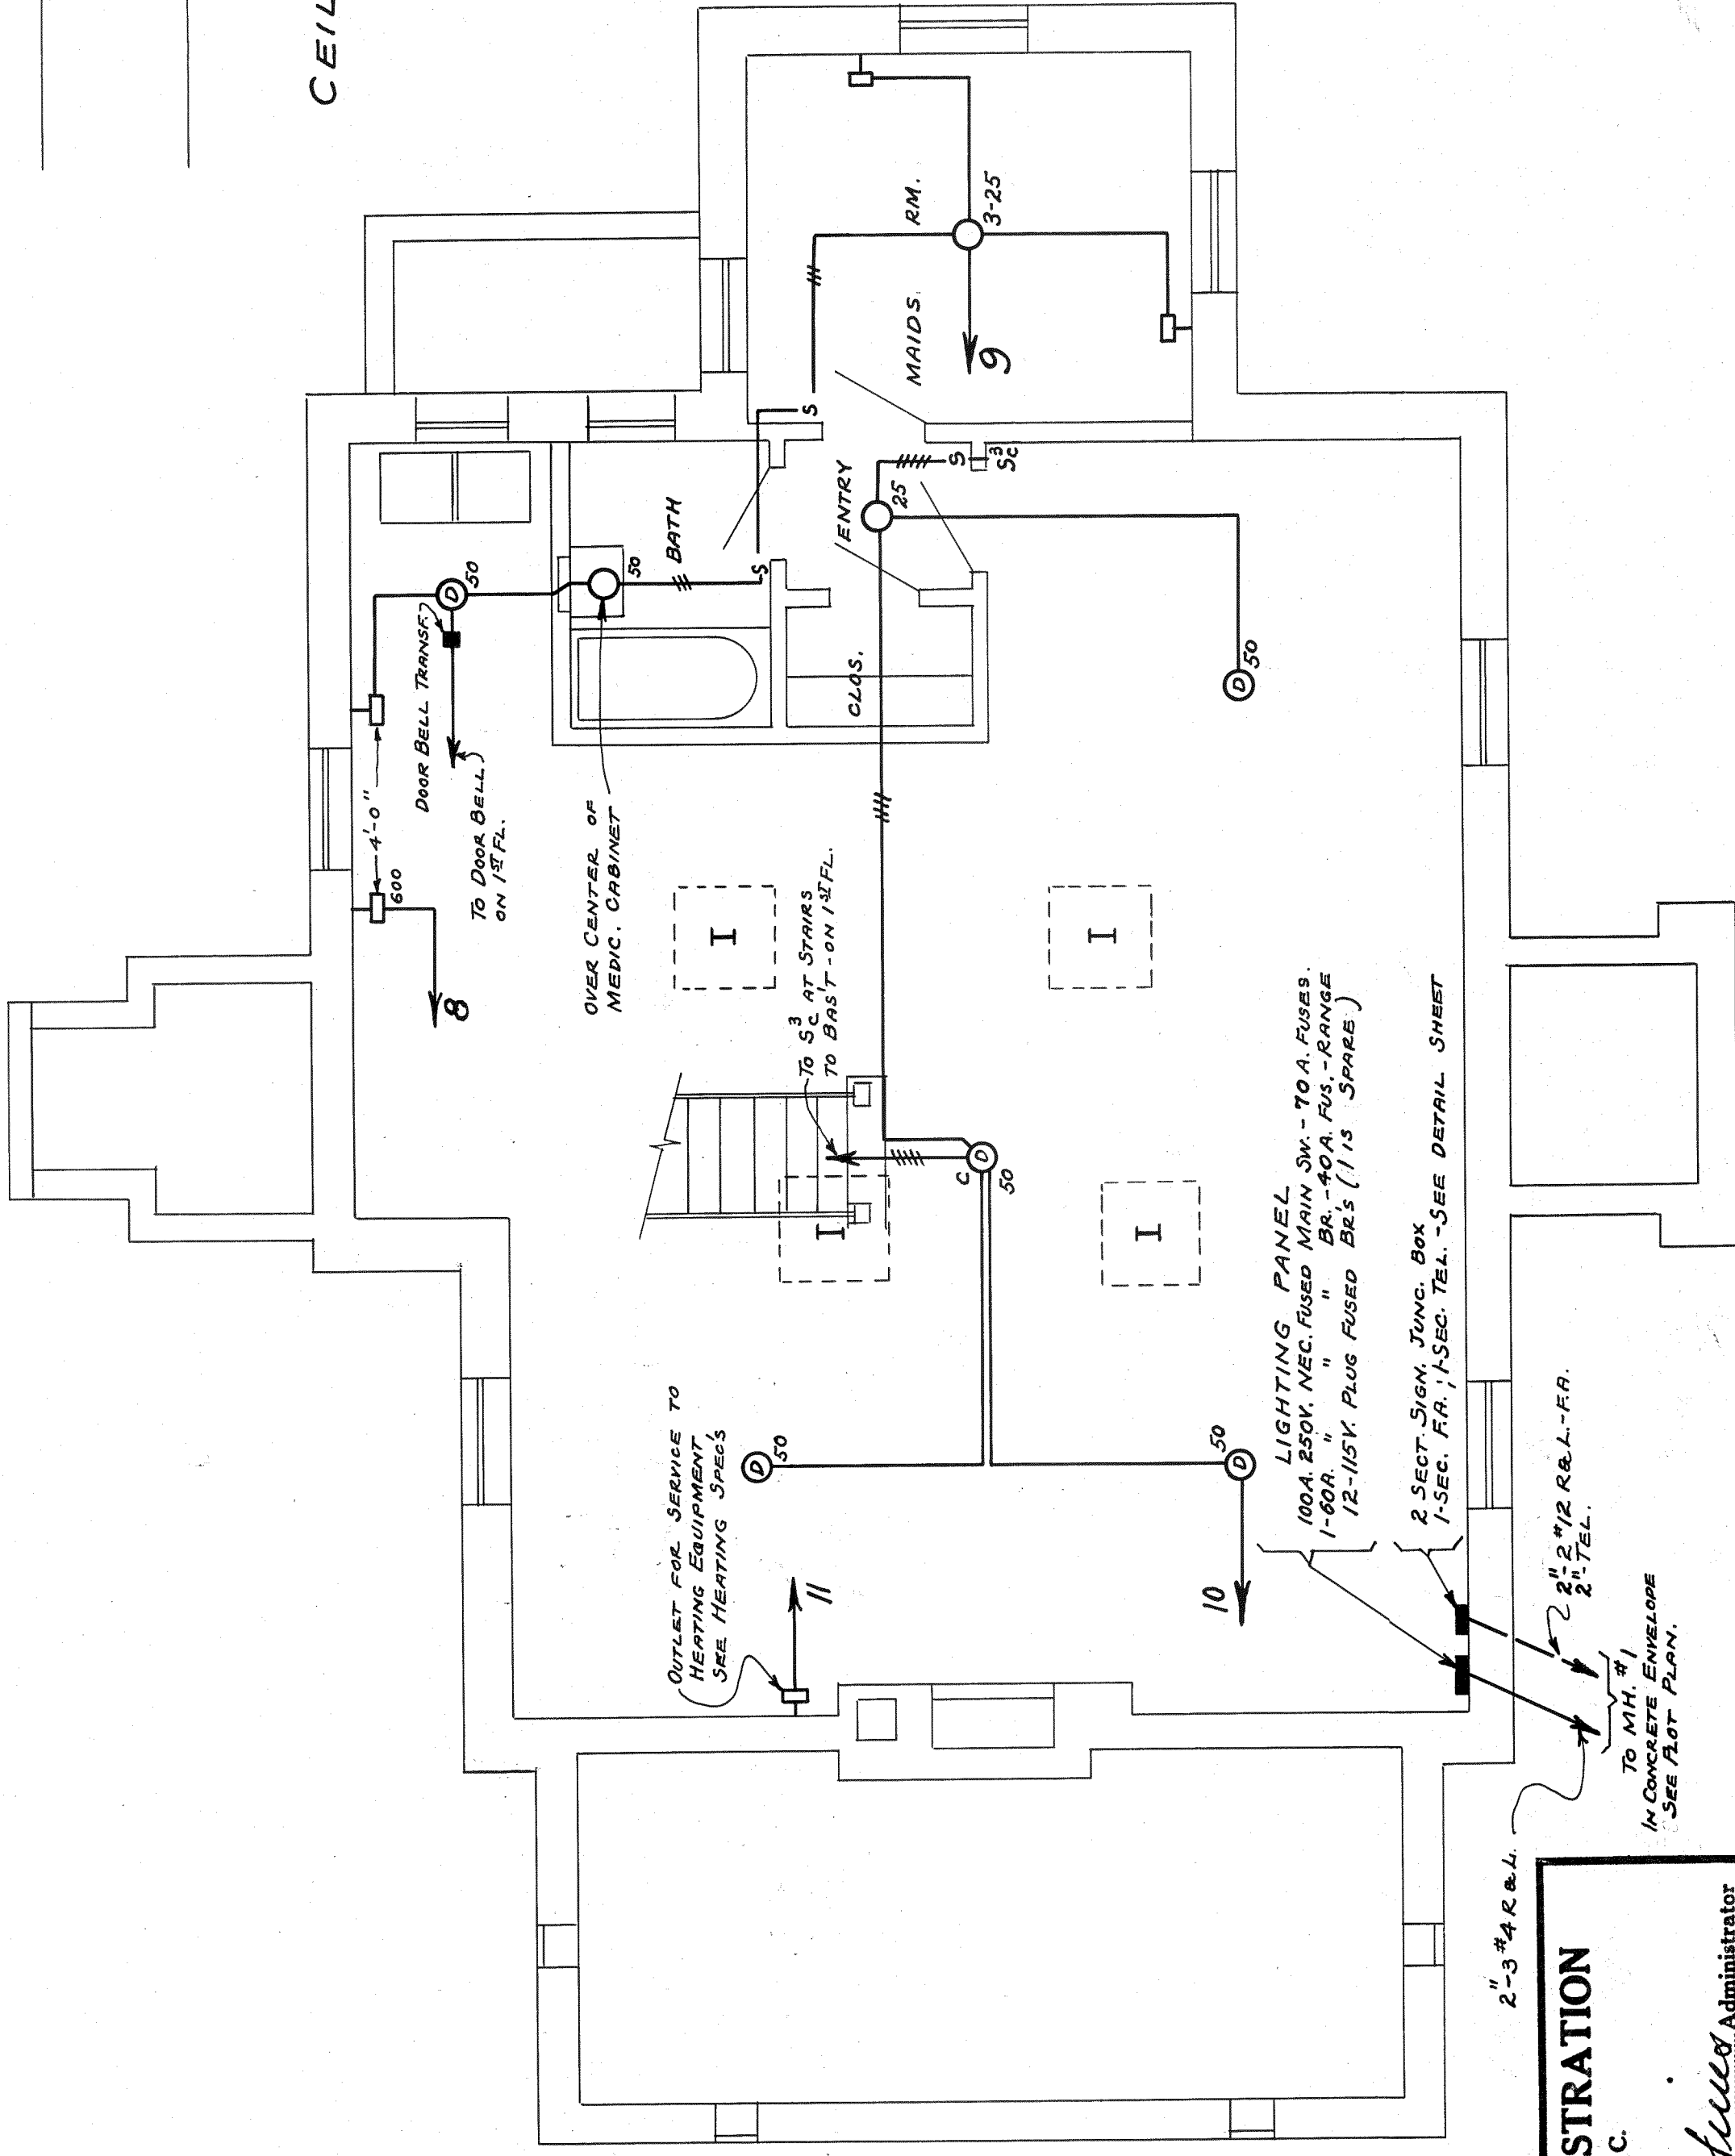

BASEMENT FLOOR PLAN
SCALE 1/4"=1'-0"

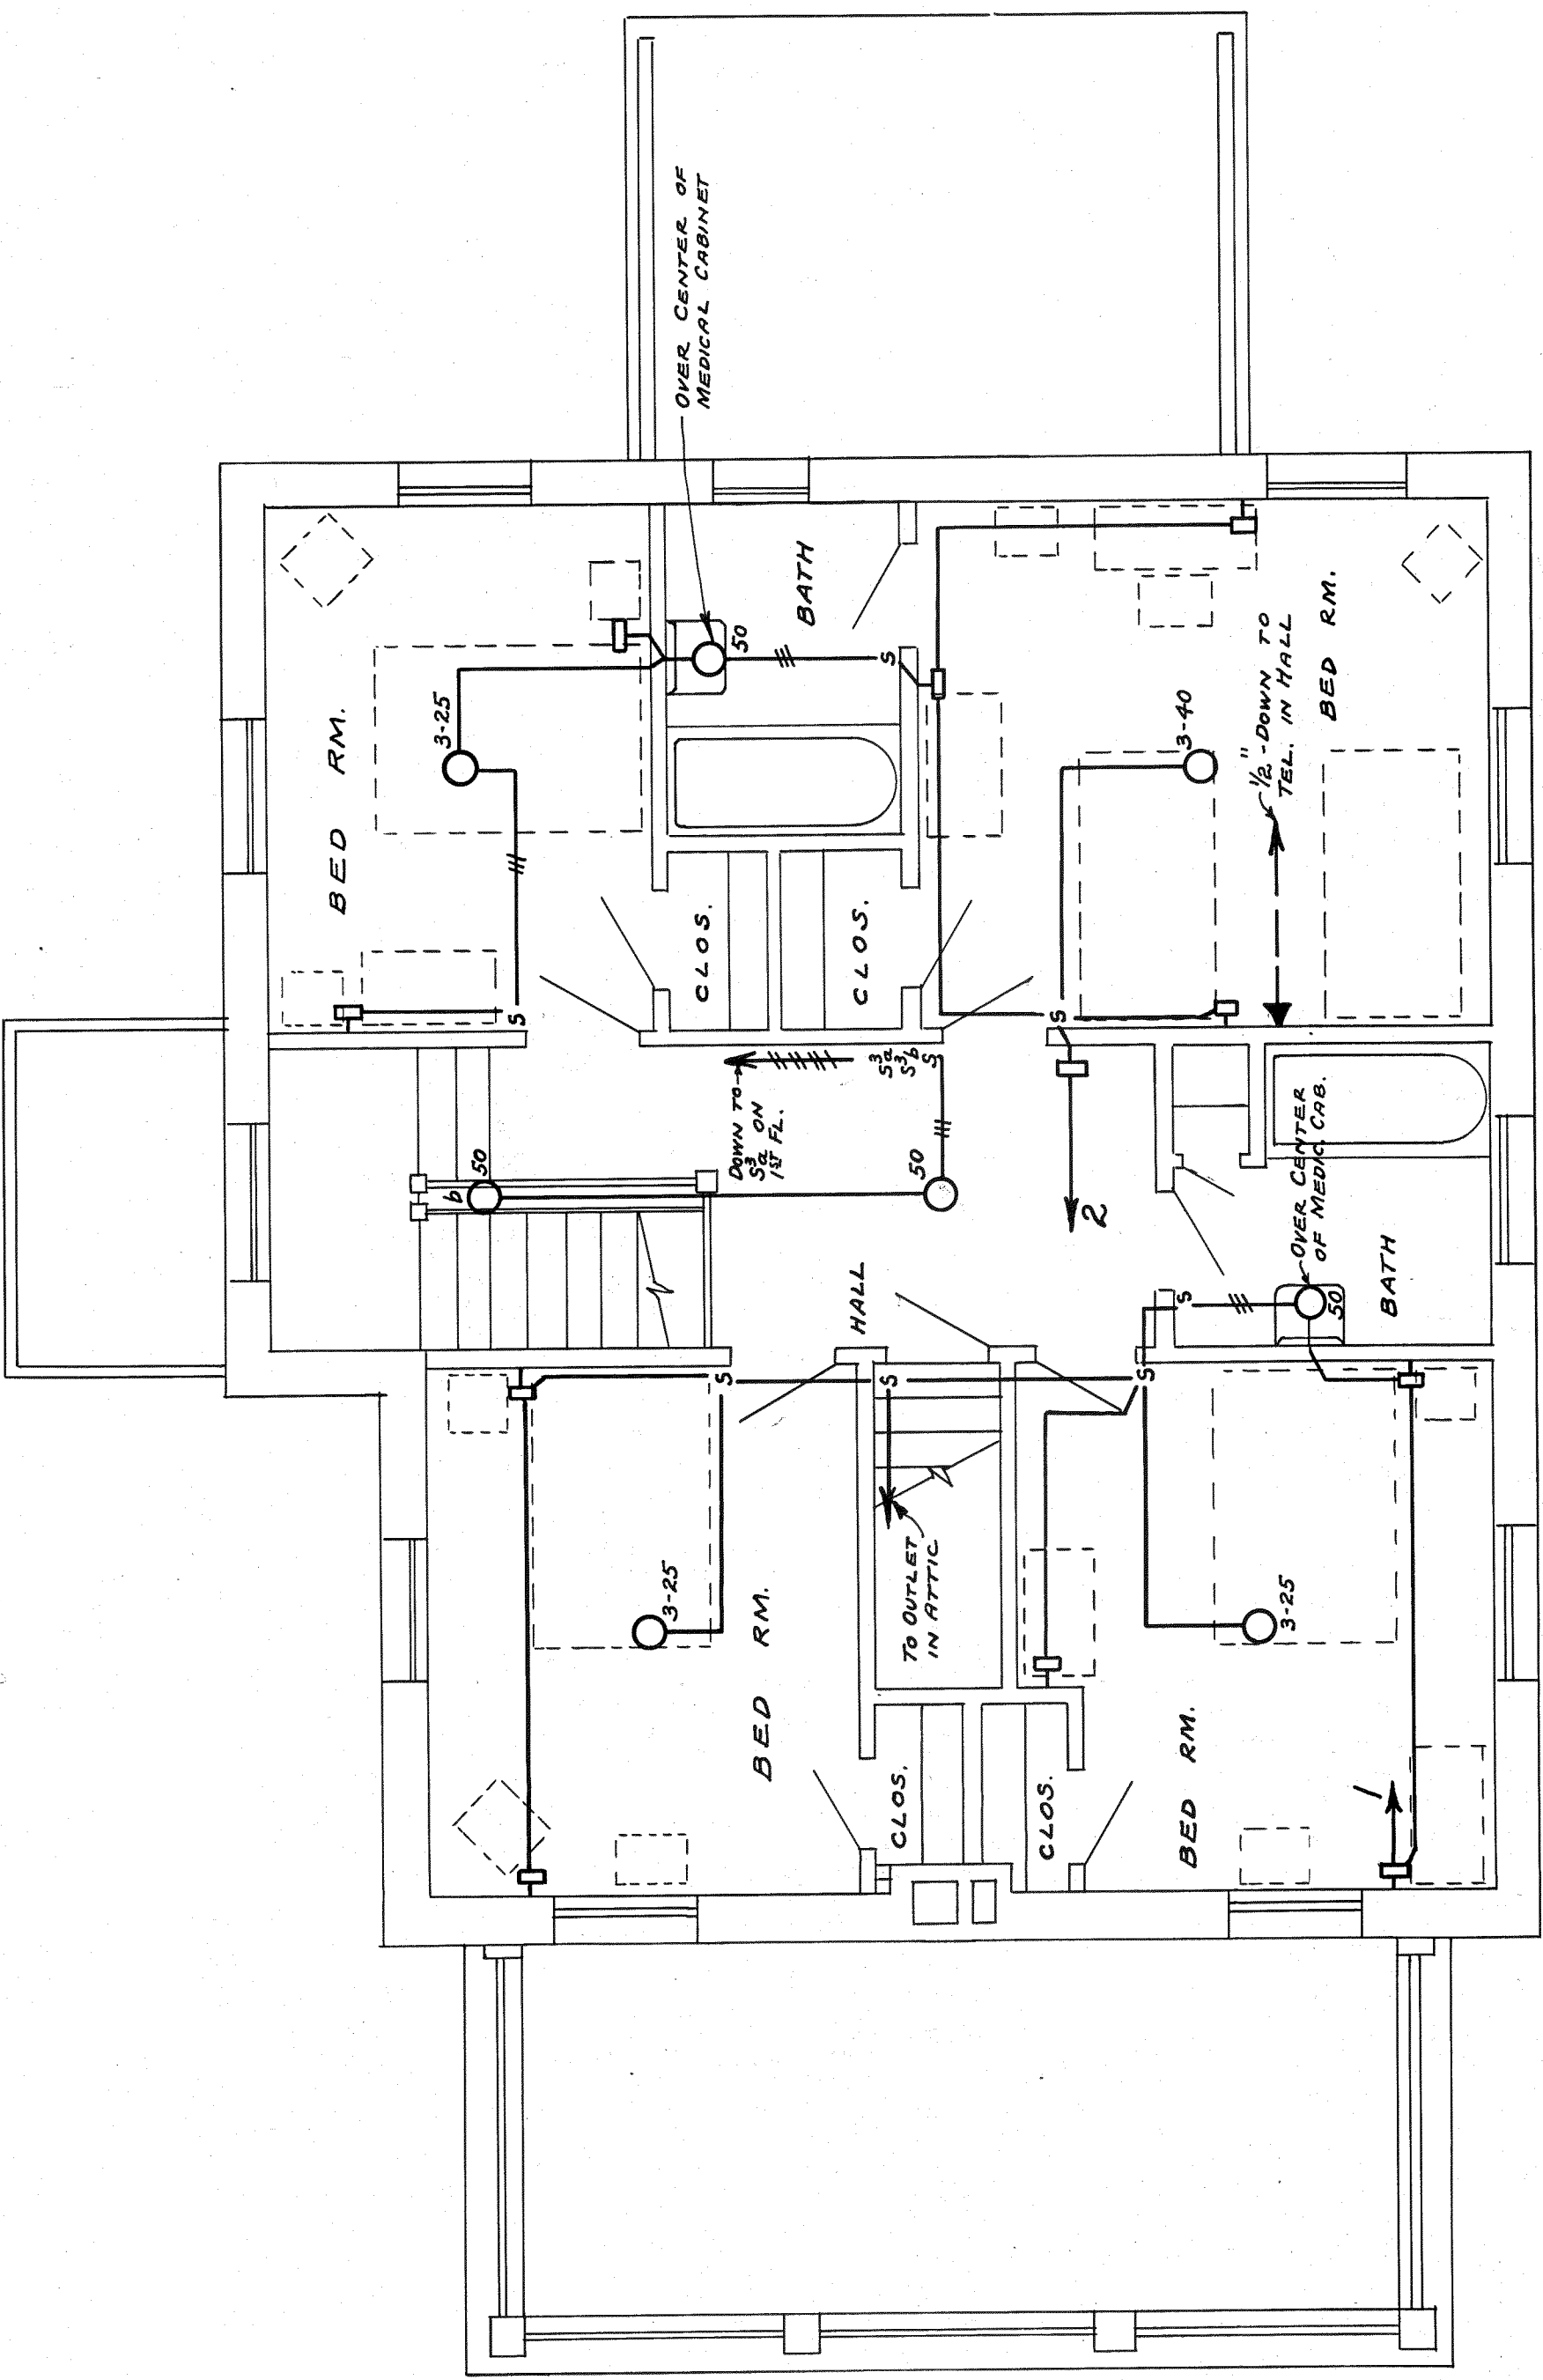

SECOND FLOOR PLAN
SCALE 1/4"=1'-0"

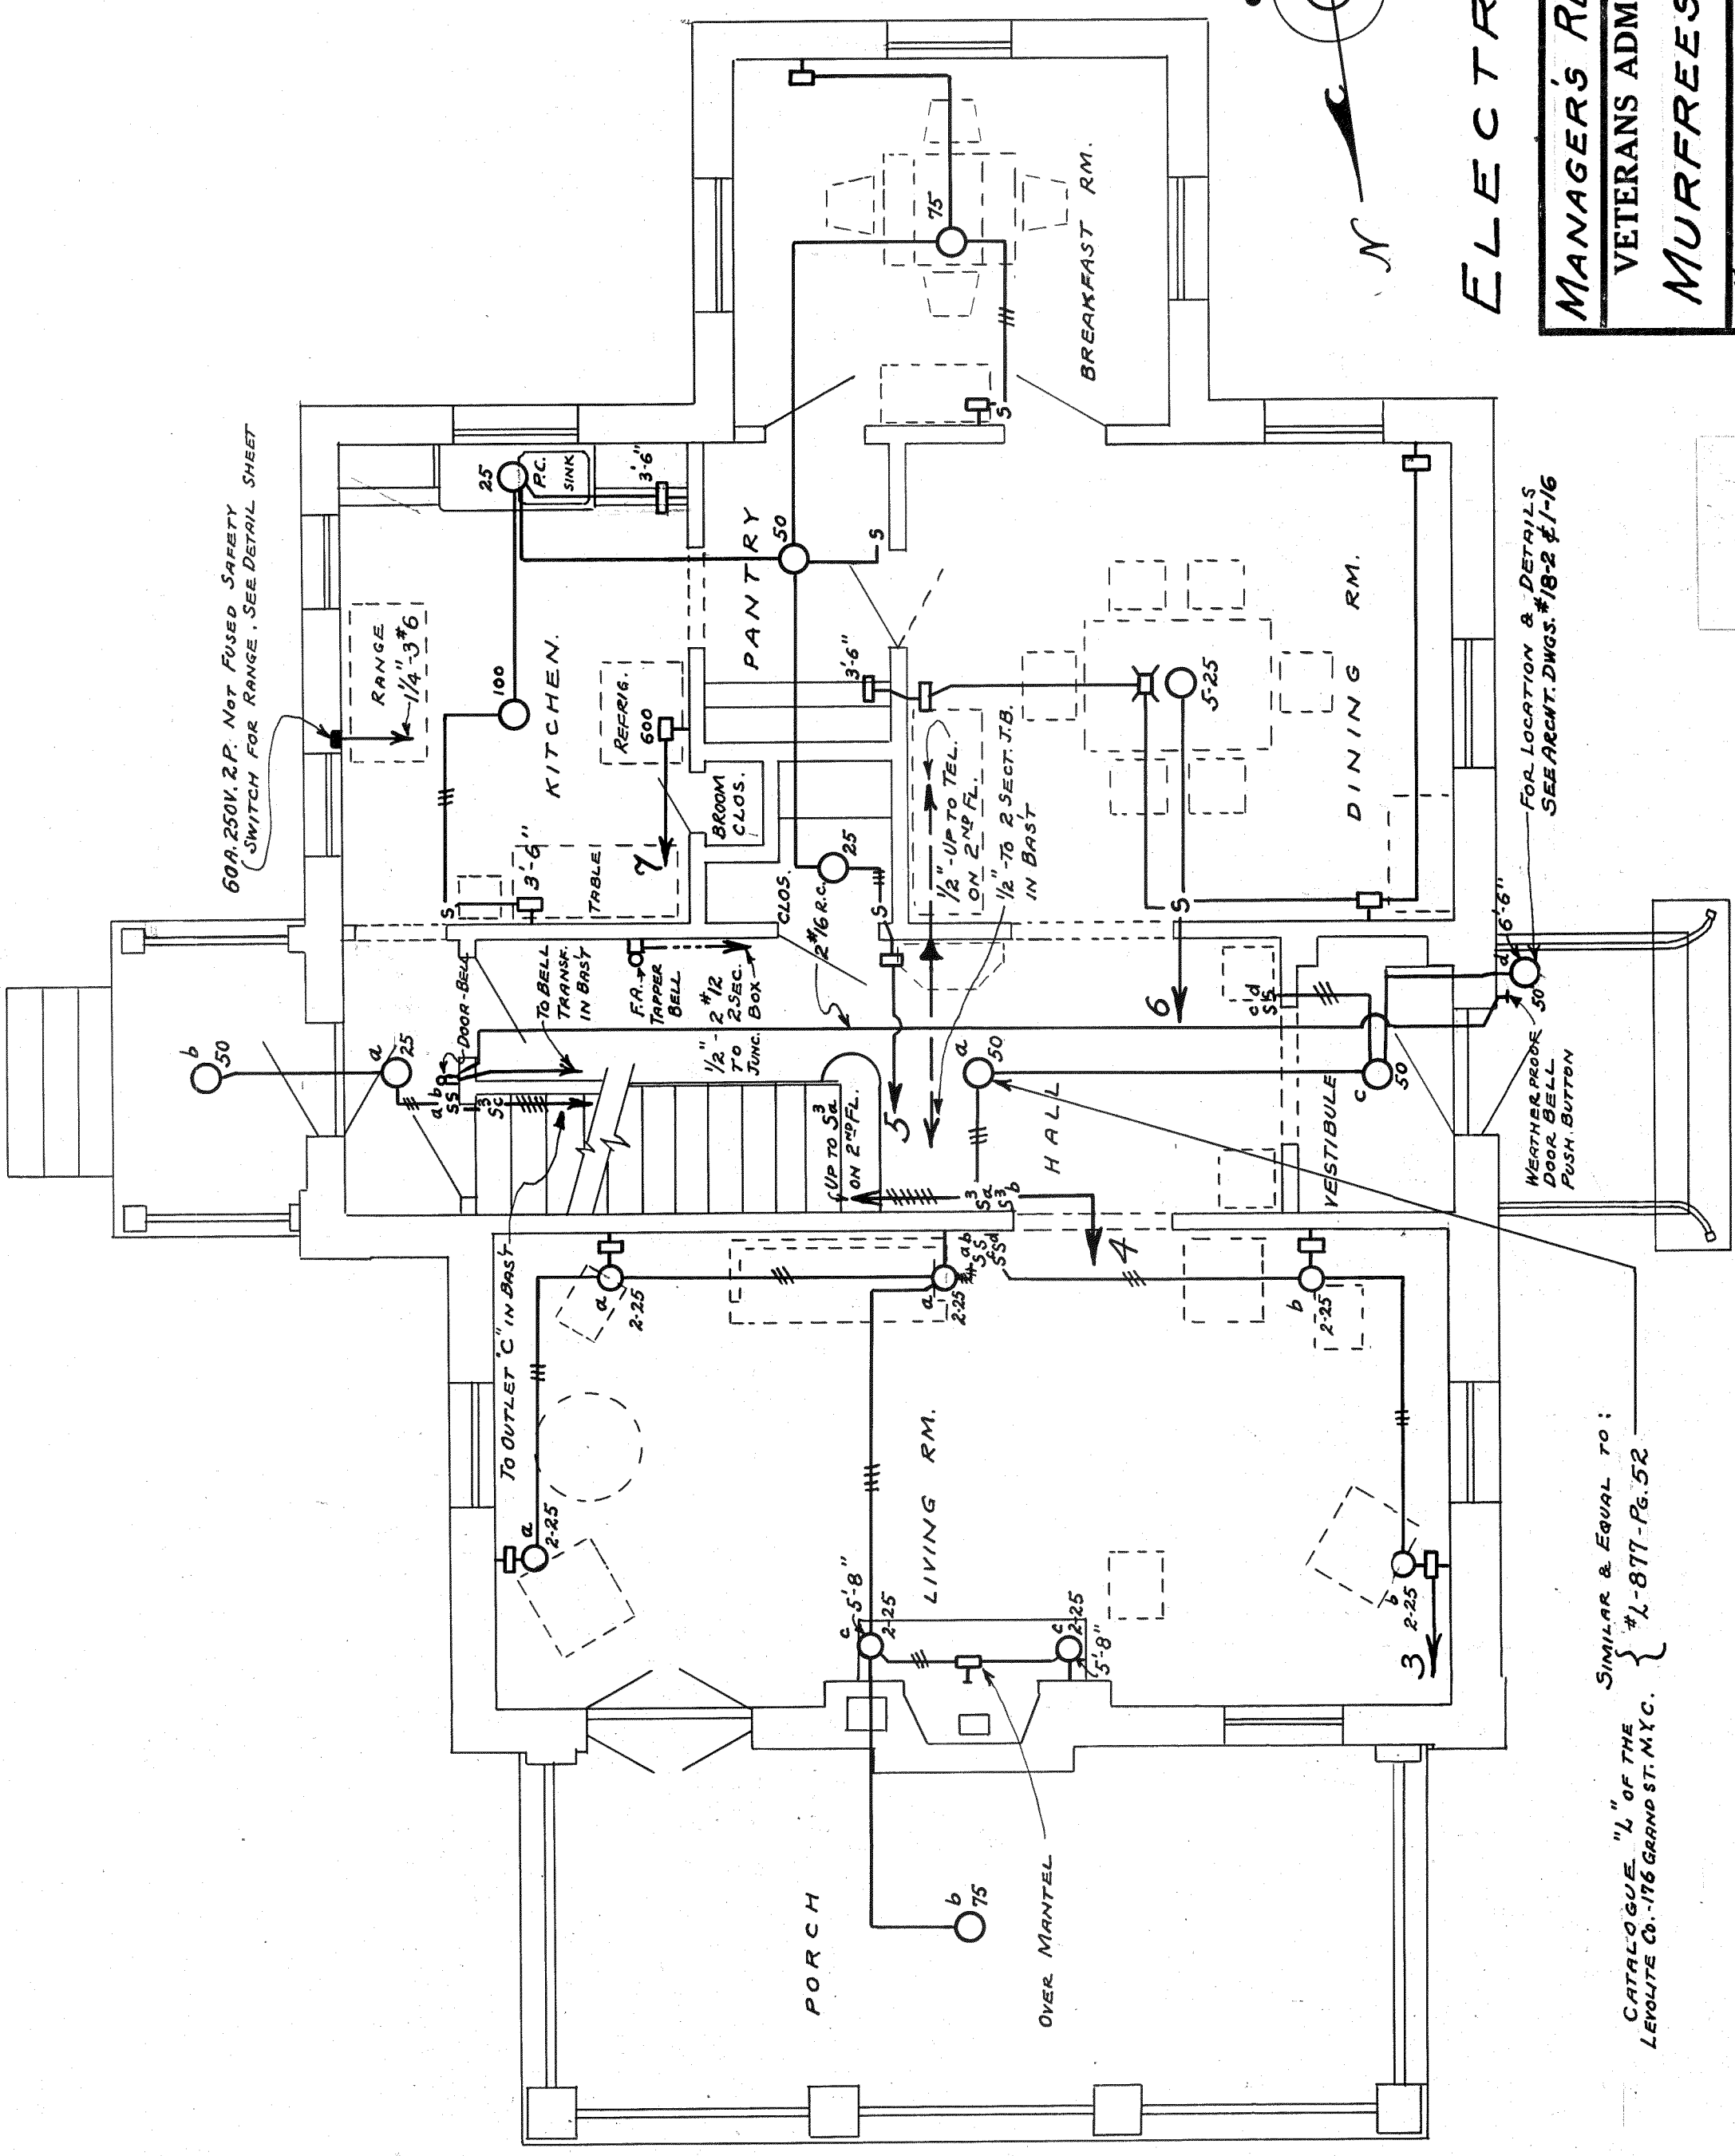

FIRST FLOOR PLAN
SCALE 1/4"=1'-0"

ELECTRICAL

MANAGER'S RESIDENCE Bldg. No. 18.			
VETERANS ADMINISTRATION FACILITY			
MURFREESBORO, TENN.			
Drawn	REVISIONS	NUMBER	
Traced & R.L.			
Set			
Date			
Sub-division			
Proj. No.			
1-2-2-1286			
18-5			
SHEET 5 OF 5			
Proj. No. 1410			

RETURN TRACINGS TO PLAN FILES

FILE FOLDER NO. 3

VETERANS ADMINISTRATION
WASHINGTON, D. C.

APPROVED *Charles G. M. M. M.* Administrator

W. E. G. G. Assistant Administrator

W. E. G. G. Director of Construction

W. E. G. G. Chief, Technical Division