


CURTAIN TRACK —
TYP ALL EXAM ROOMS

EXAM 7 4A-370M

* NOTE:


LOCATION OF FURNITURE & ACCESSORIES TO BE
CONFIRMED BY OWNER FOR EACH ROOM

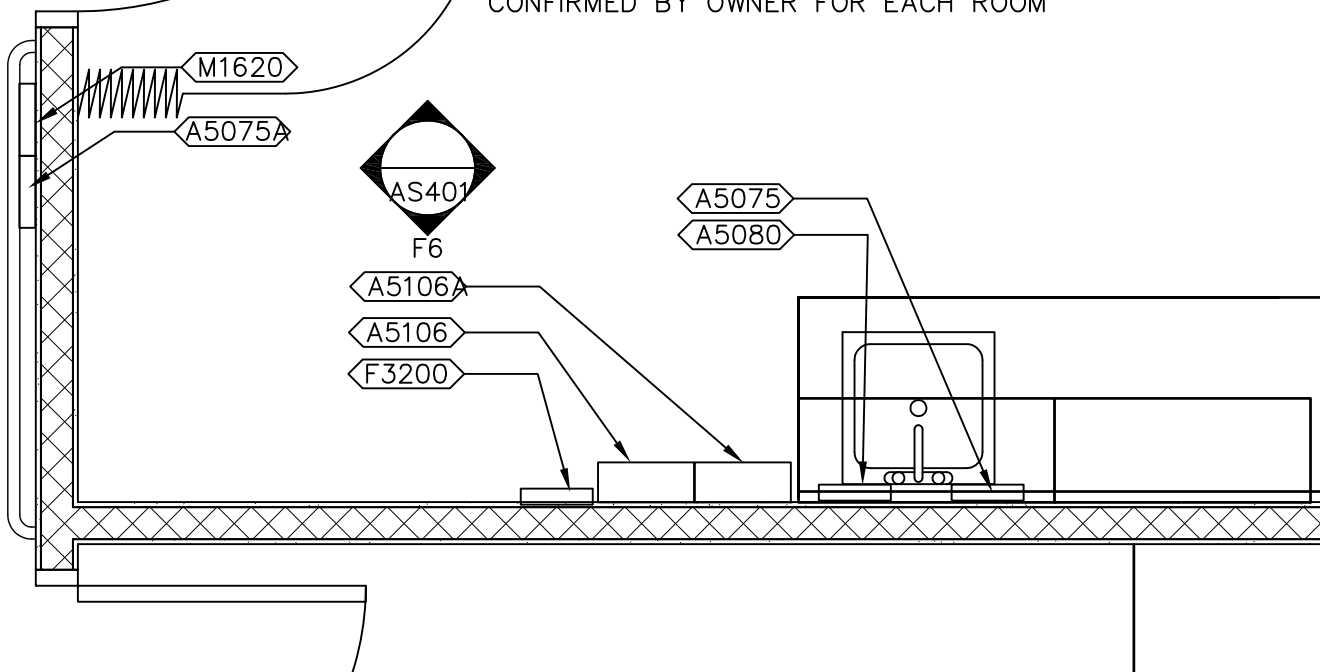

ENLARGED PLAN EXAM ROOM (TYP.)

F8

0' 1' 2' 3' 1/2" = 1'-0"

Drawing Title ENLARGED FLOOR PLANS	Project Title GERIATRICS-WOUND CARE CLINIC	Project Number 580-17-100 Building Number 100	Office of Construction and Facilities Management  Department of Veterans Affairs
Approved: Chief Engineer/Division Manager	Location VA Medical Center, Houston, TX Date 1/25/2017	Drawing Number ASI-1 Dwg. of	
	Checked ML	Drawn ML	