



**FEIT**  
**PLUMBING CO**  
50 WELDON PARKWAY  
MARYLAND HEIGHTS, MO 63043  
314-567-1200 F: 314-567-3372

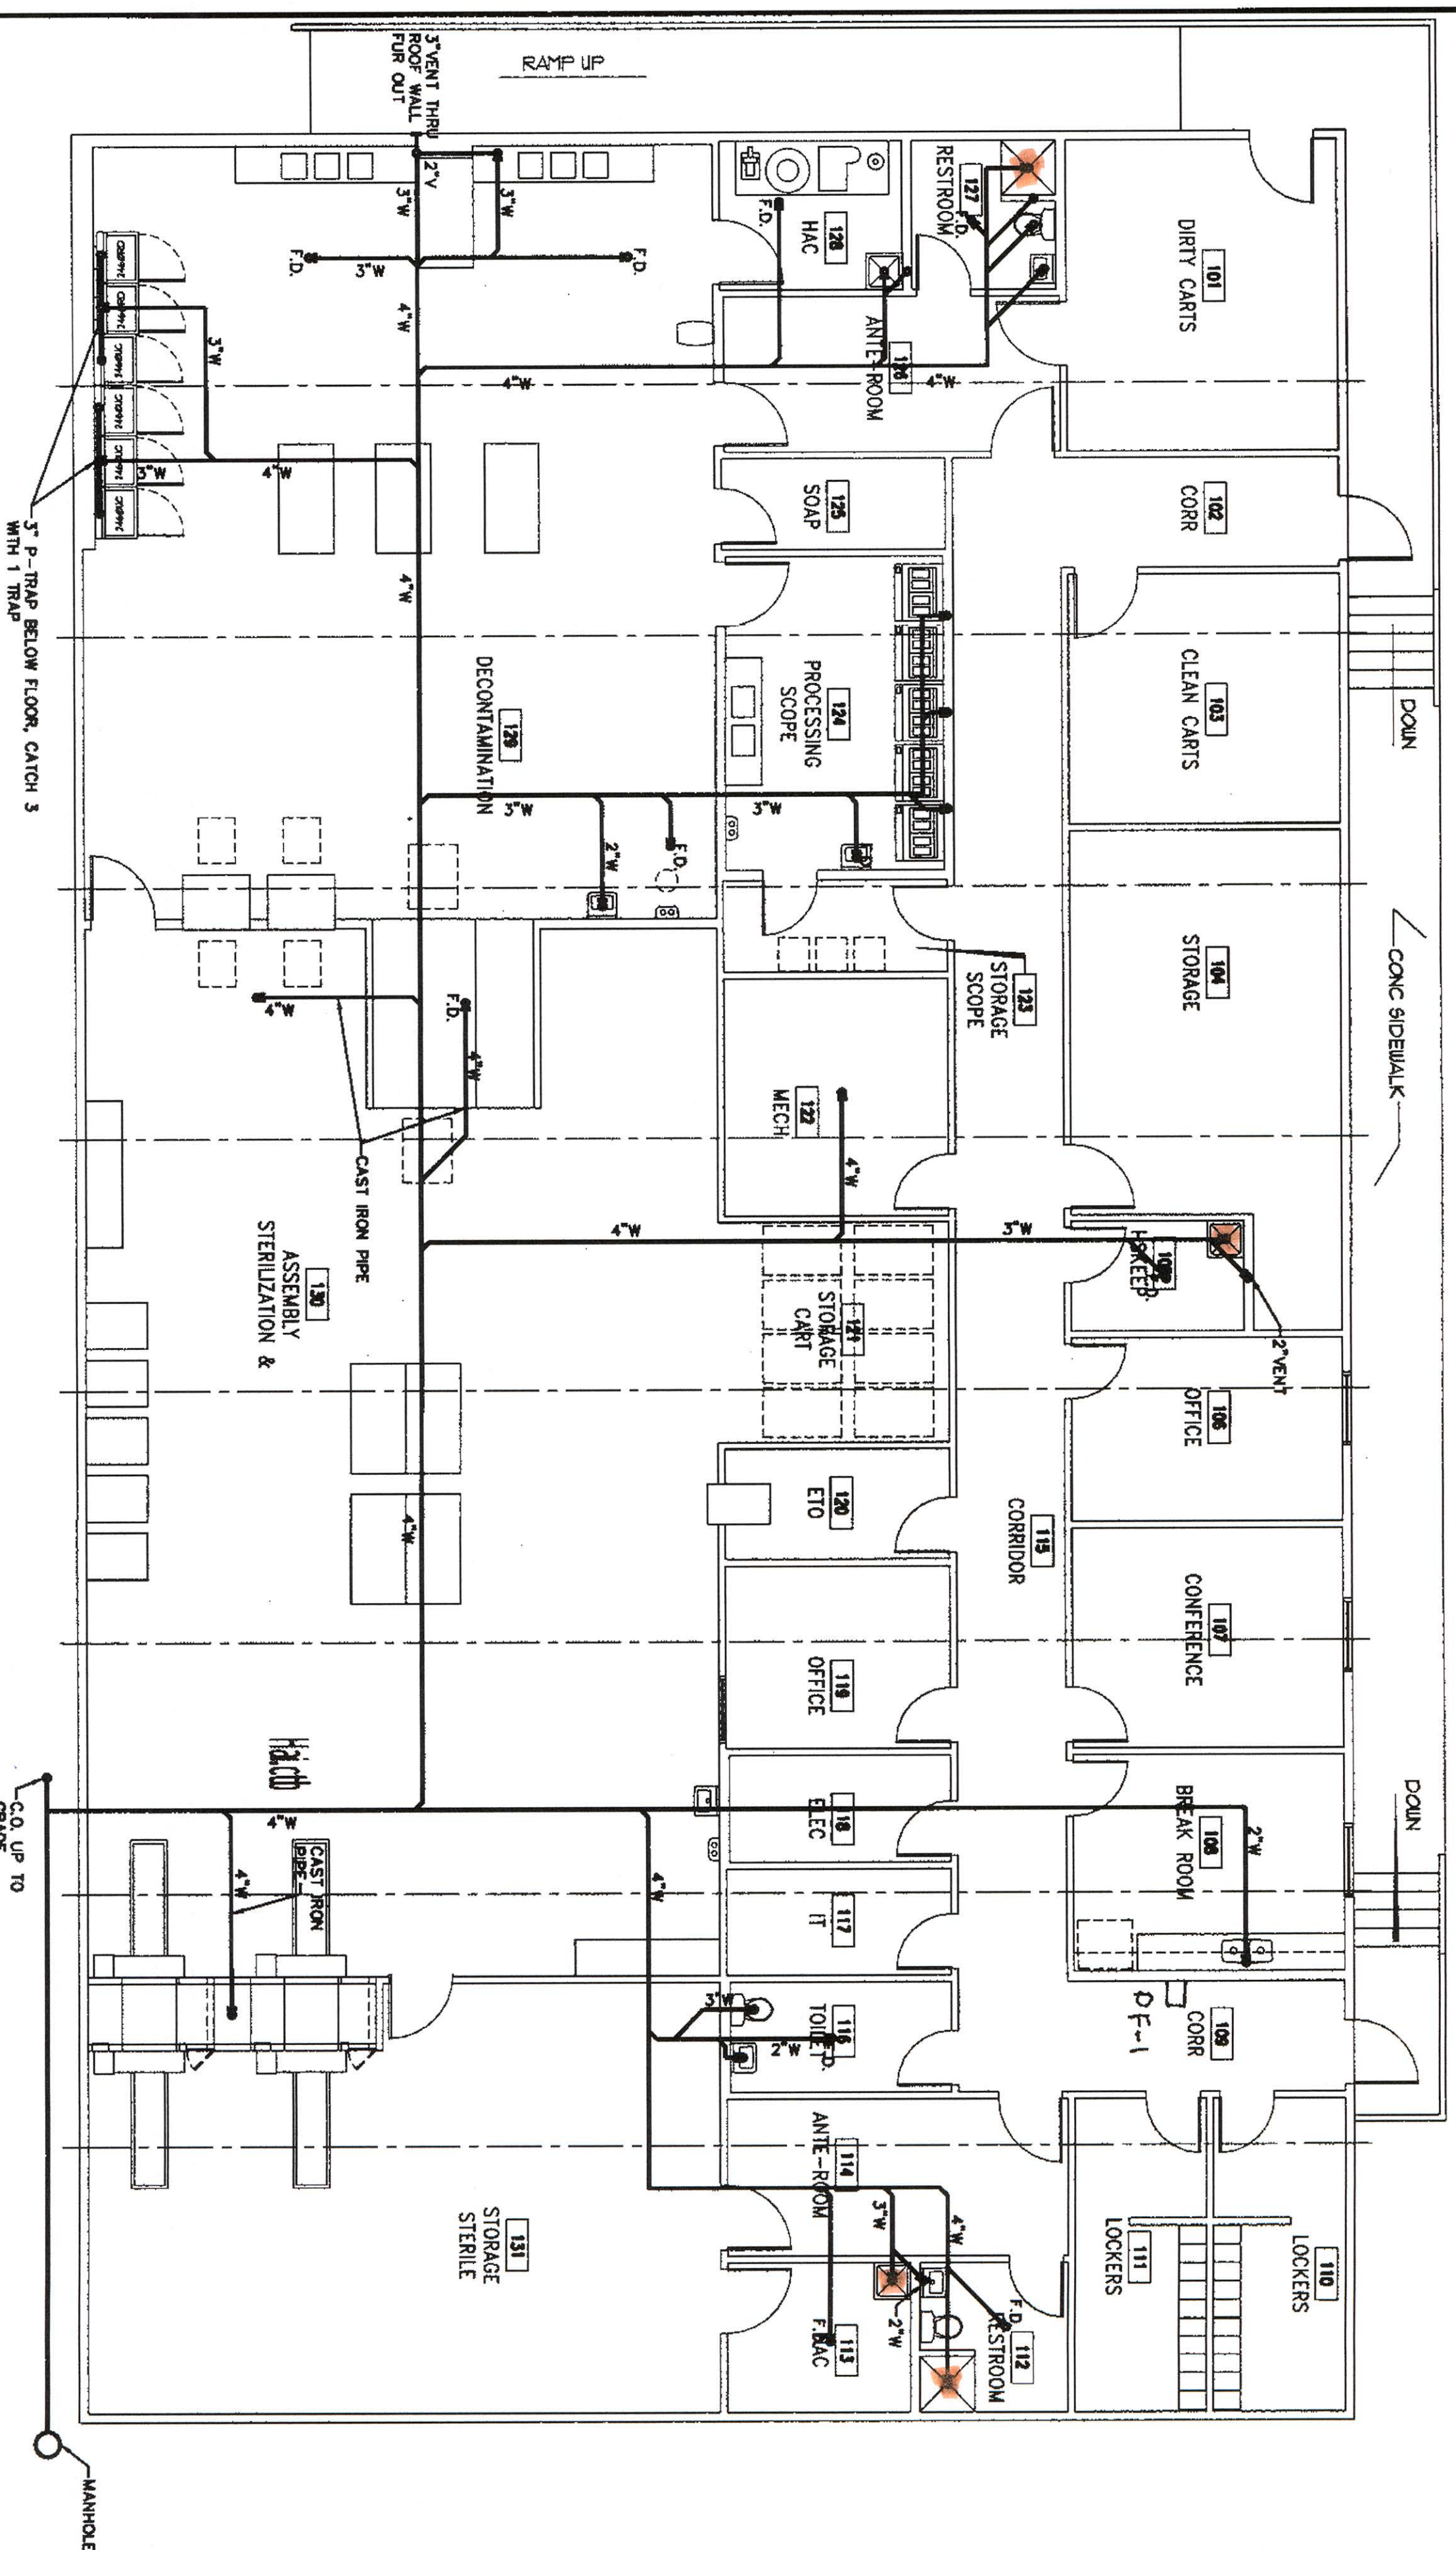

**1 UNDERFLOOR PLUMBING PLAN**  
P1 SCALE: 1/8" = 1'-0"

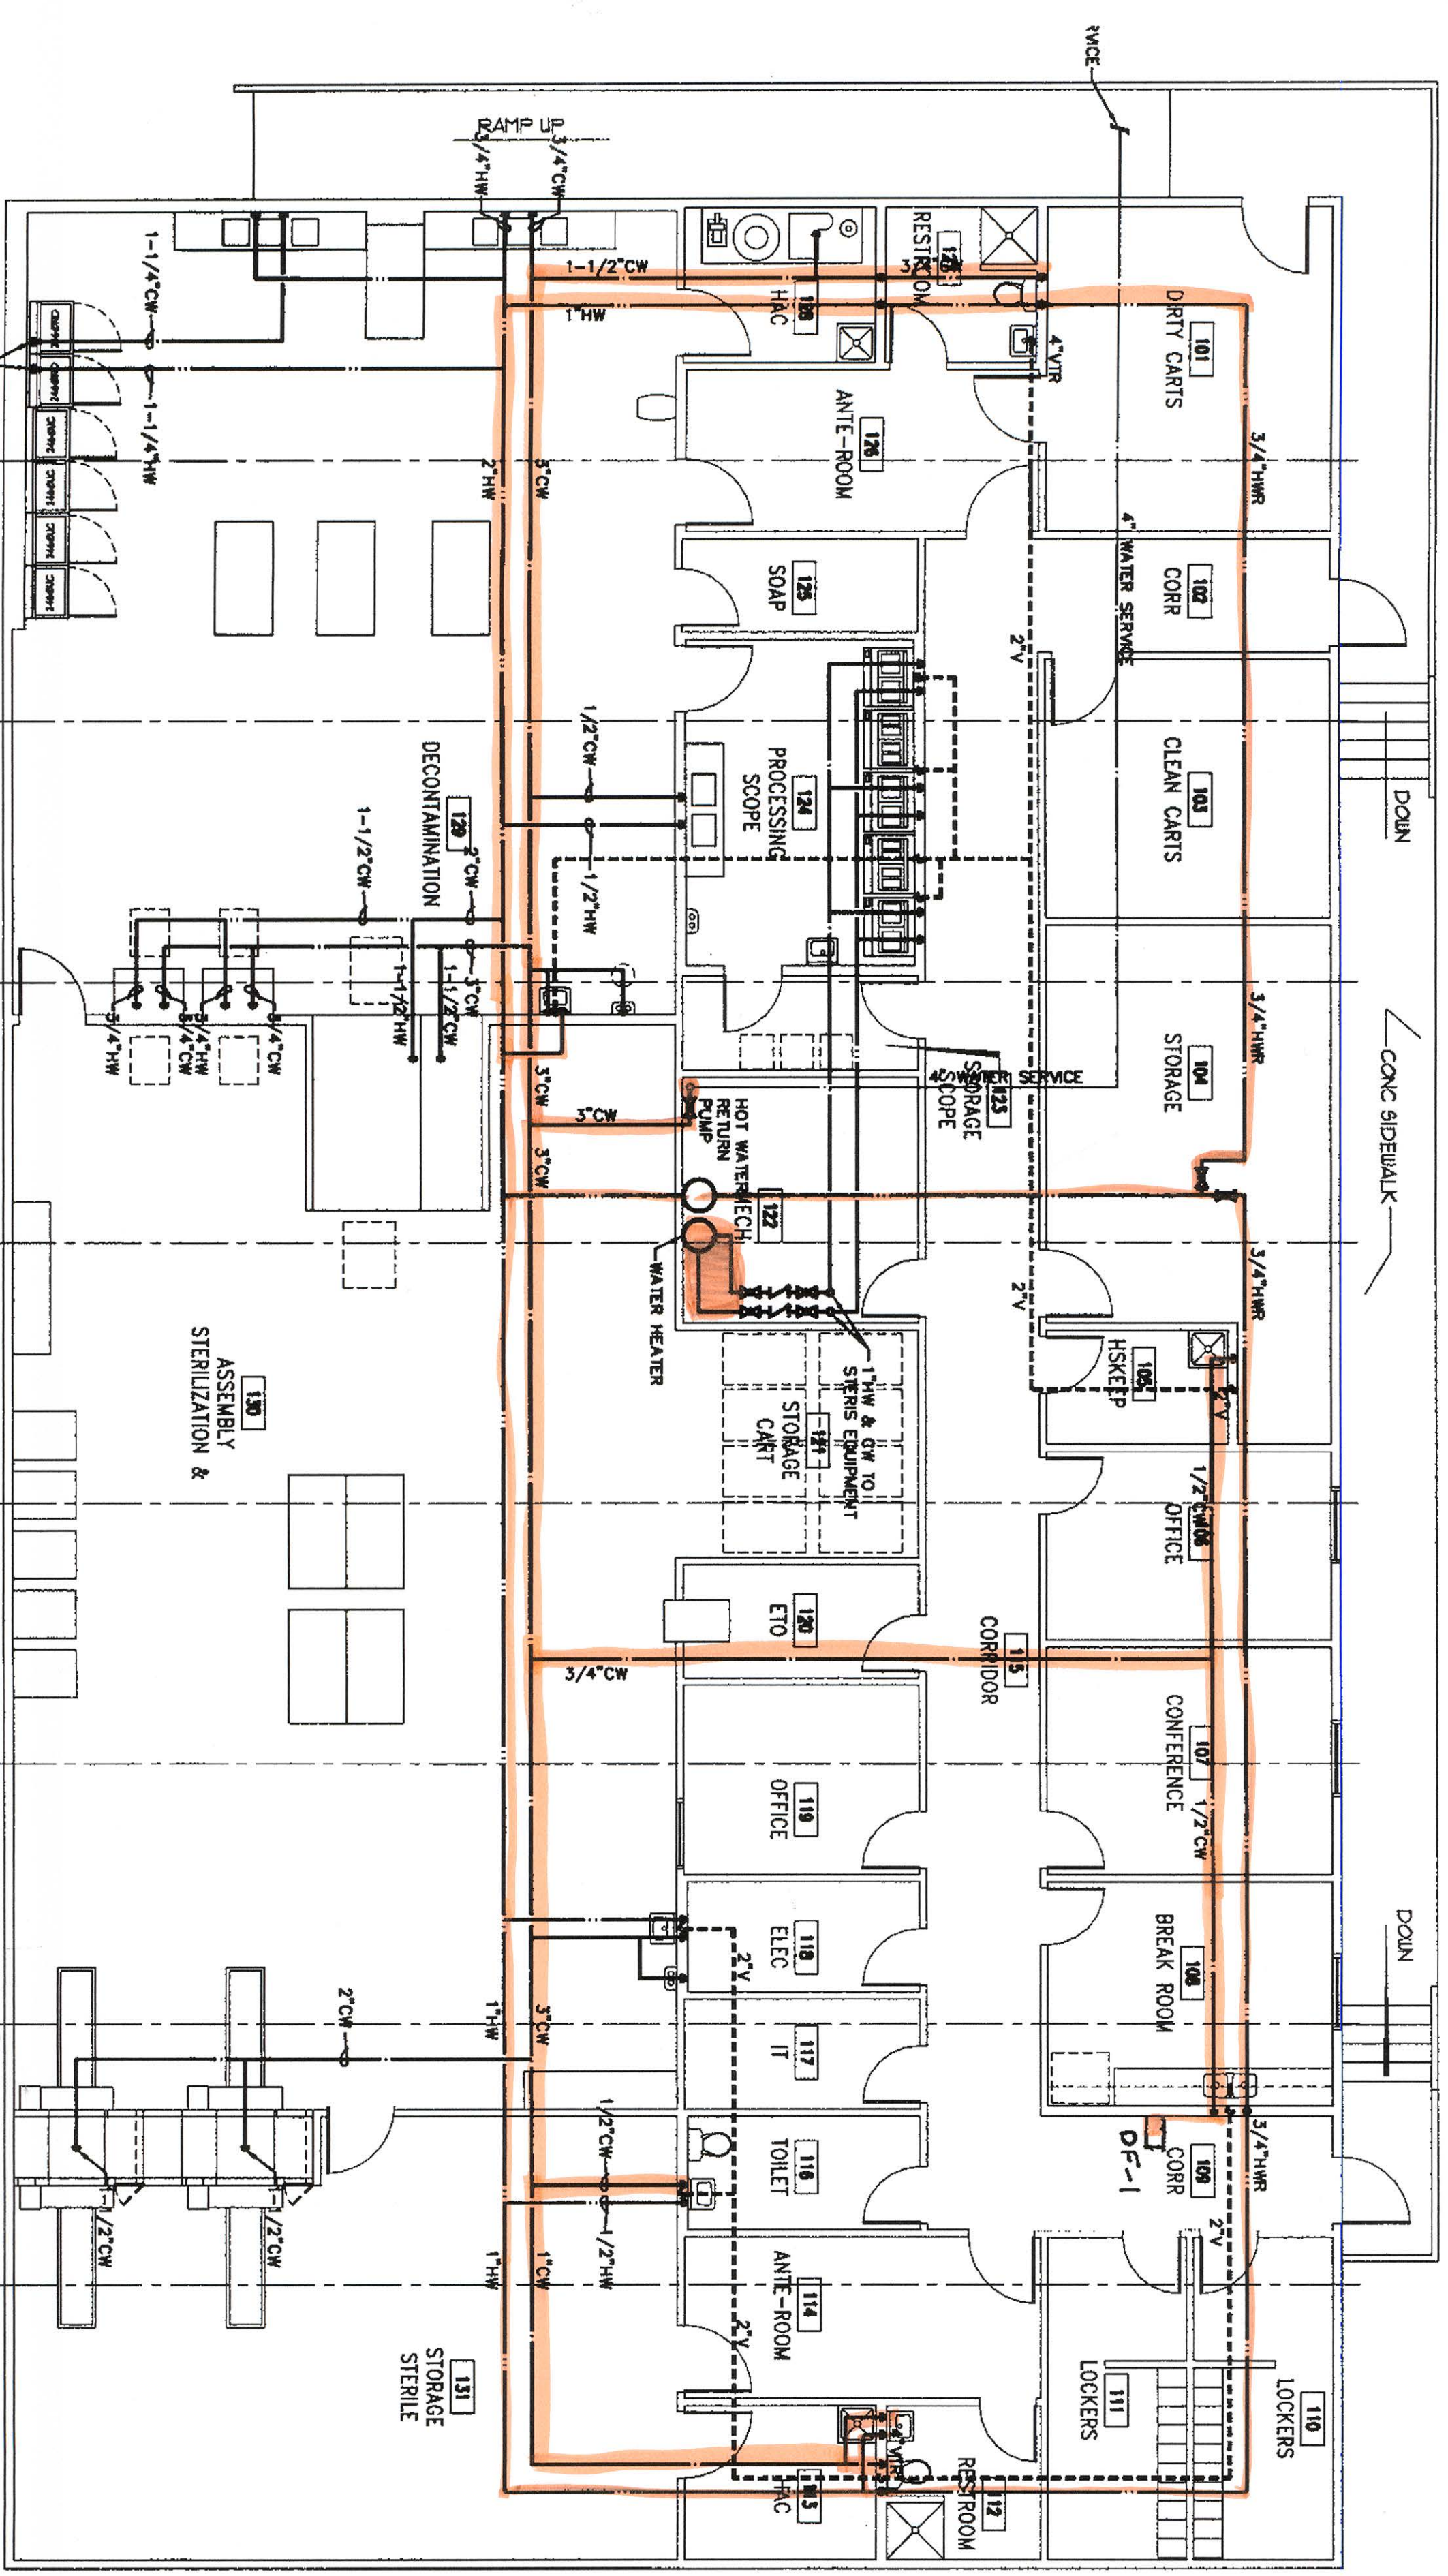


**1 PLUMBING FLOOR PLAN**  
P1 SCALE: 1/8" = 1'-0"



DESIGN/BUILD CONTRACTOR

**JW Fuller Construction / L. Wolf Co.**  
A Joint Venture

ARCHITECT:

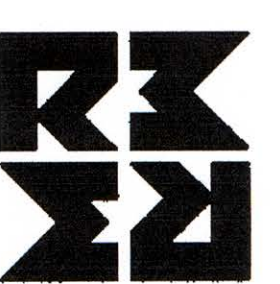

**MICHAEL ROTH & ASSOCIATES,  
ARCHITECTS & PLANNERS, INC.**  
200 SOUTH HANLEY ROAD, STE. 1105, CLAYTON, MISSOURI 63105, 314-862-2112

Drawing Title

Approved Project Director

Project Title  
**RENOVATE SPD DESIGN / BUILD  
BUILDING NO. 1**

Project Number  
**657-10-121JC**

Building Number  
**1**

Drawing Number  
**P1.1**

Office of  
Facilities  
Management

Location  
St. Louis, Missouri

Date  
APRIL 29, 2011

Checked  
M/R/MAR

Drawn  
MMK

Dwg.  
of

