

VA FORM 08-8231

Project Number	672-12-101
Building Number	
Dwg. Number	D4
Revision	
Date	
Project Name	EXPAND EMERGENCY DEPARTMENT & OBSERVATION UNIT
Location	VMMC
Checked	R. G. M.
Drawn	
Project Manager	Miguel A. Cordero
Chief Project Section	Wilfredo Quiñones
Chief PMS	

CONSULTANTS:

PF&A
PFA DESIGN
ACQUISITION PLANNING INTERIORS
Interior Design Consultant
www.pfa-architect.com

BABILONIA ENGINEERING GROUP / CONSULTING ENGINEERS
1223 PONCE DE LEON, SAN JUAN, PR 00926-1305
(787) 751-0003 / WWW.BABILONIAGROUP.COM
RICARDO RODRIGUEZ DEL VALLE / CONSULTING ENGINEERS
P.O. BOX 9448, SAN JUAN, PUERTO RICO, 00908

ARCHITECT/ENGINEERS:

MENDEZ BRUNNER BADILLO
ARCHITECTS & ENGINEERS
CORONADO ASTOR BLDG., 1018 ASTOR RD. SAN JUAN, P.R. 00907

Drawing Title

DEMOLITION PARTIAL FLOOR PLAN 3

Project Title

EXPAND EMERGENCY DEPARTMENT & OBSERVATION UNIT

Project Number

672-12-101

Office of Construction and Facilities Management

Department of Veterans Affairs


CONSTRUCTION BID DOCUMENTS

KEY PLAN

GRAPHIC SCALE

SC: 1/4"=1'-0"

COORDINATES FOR WALL FINISHES

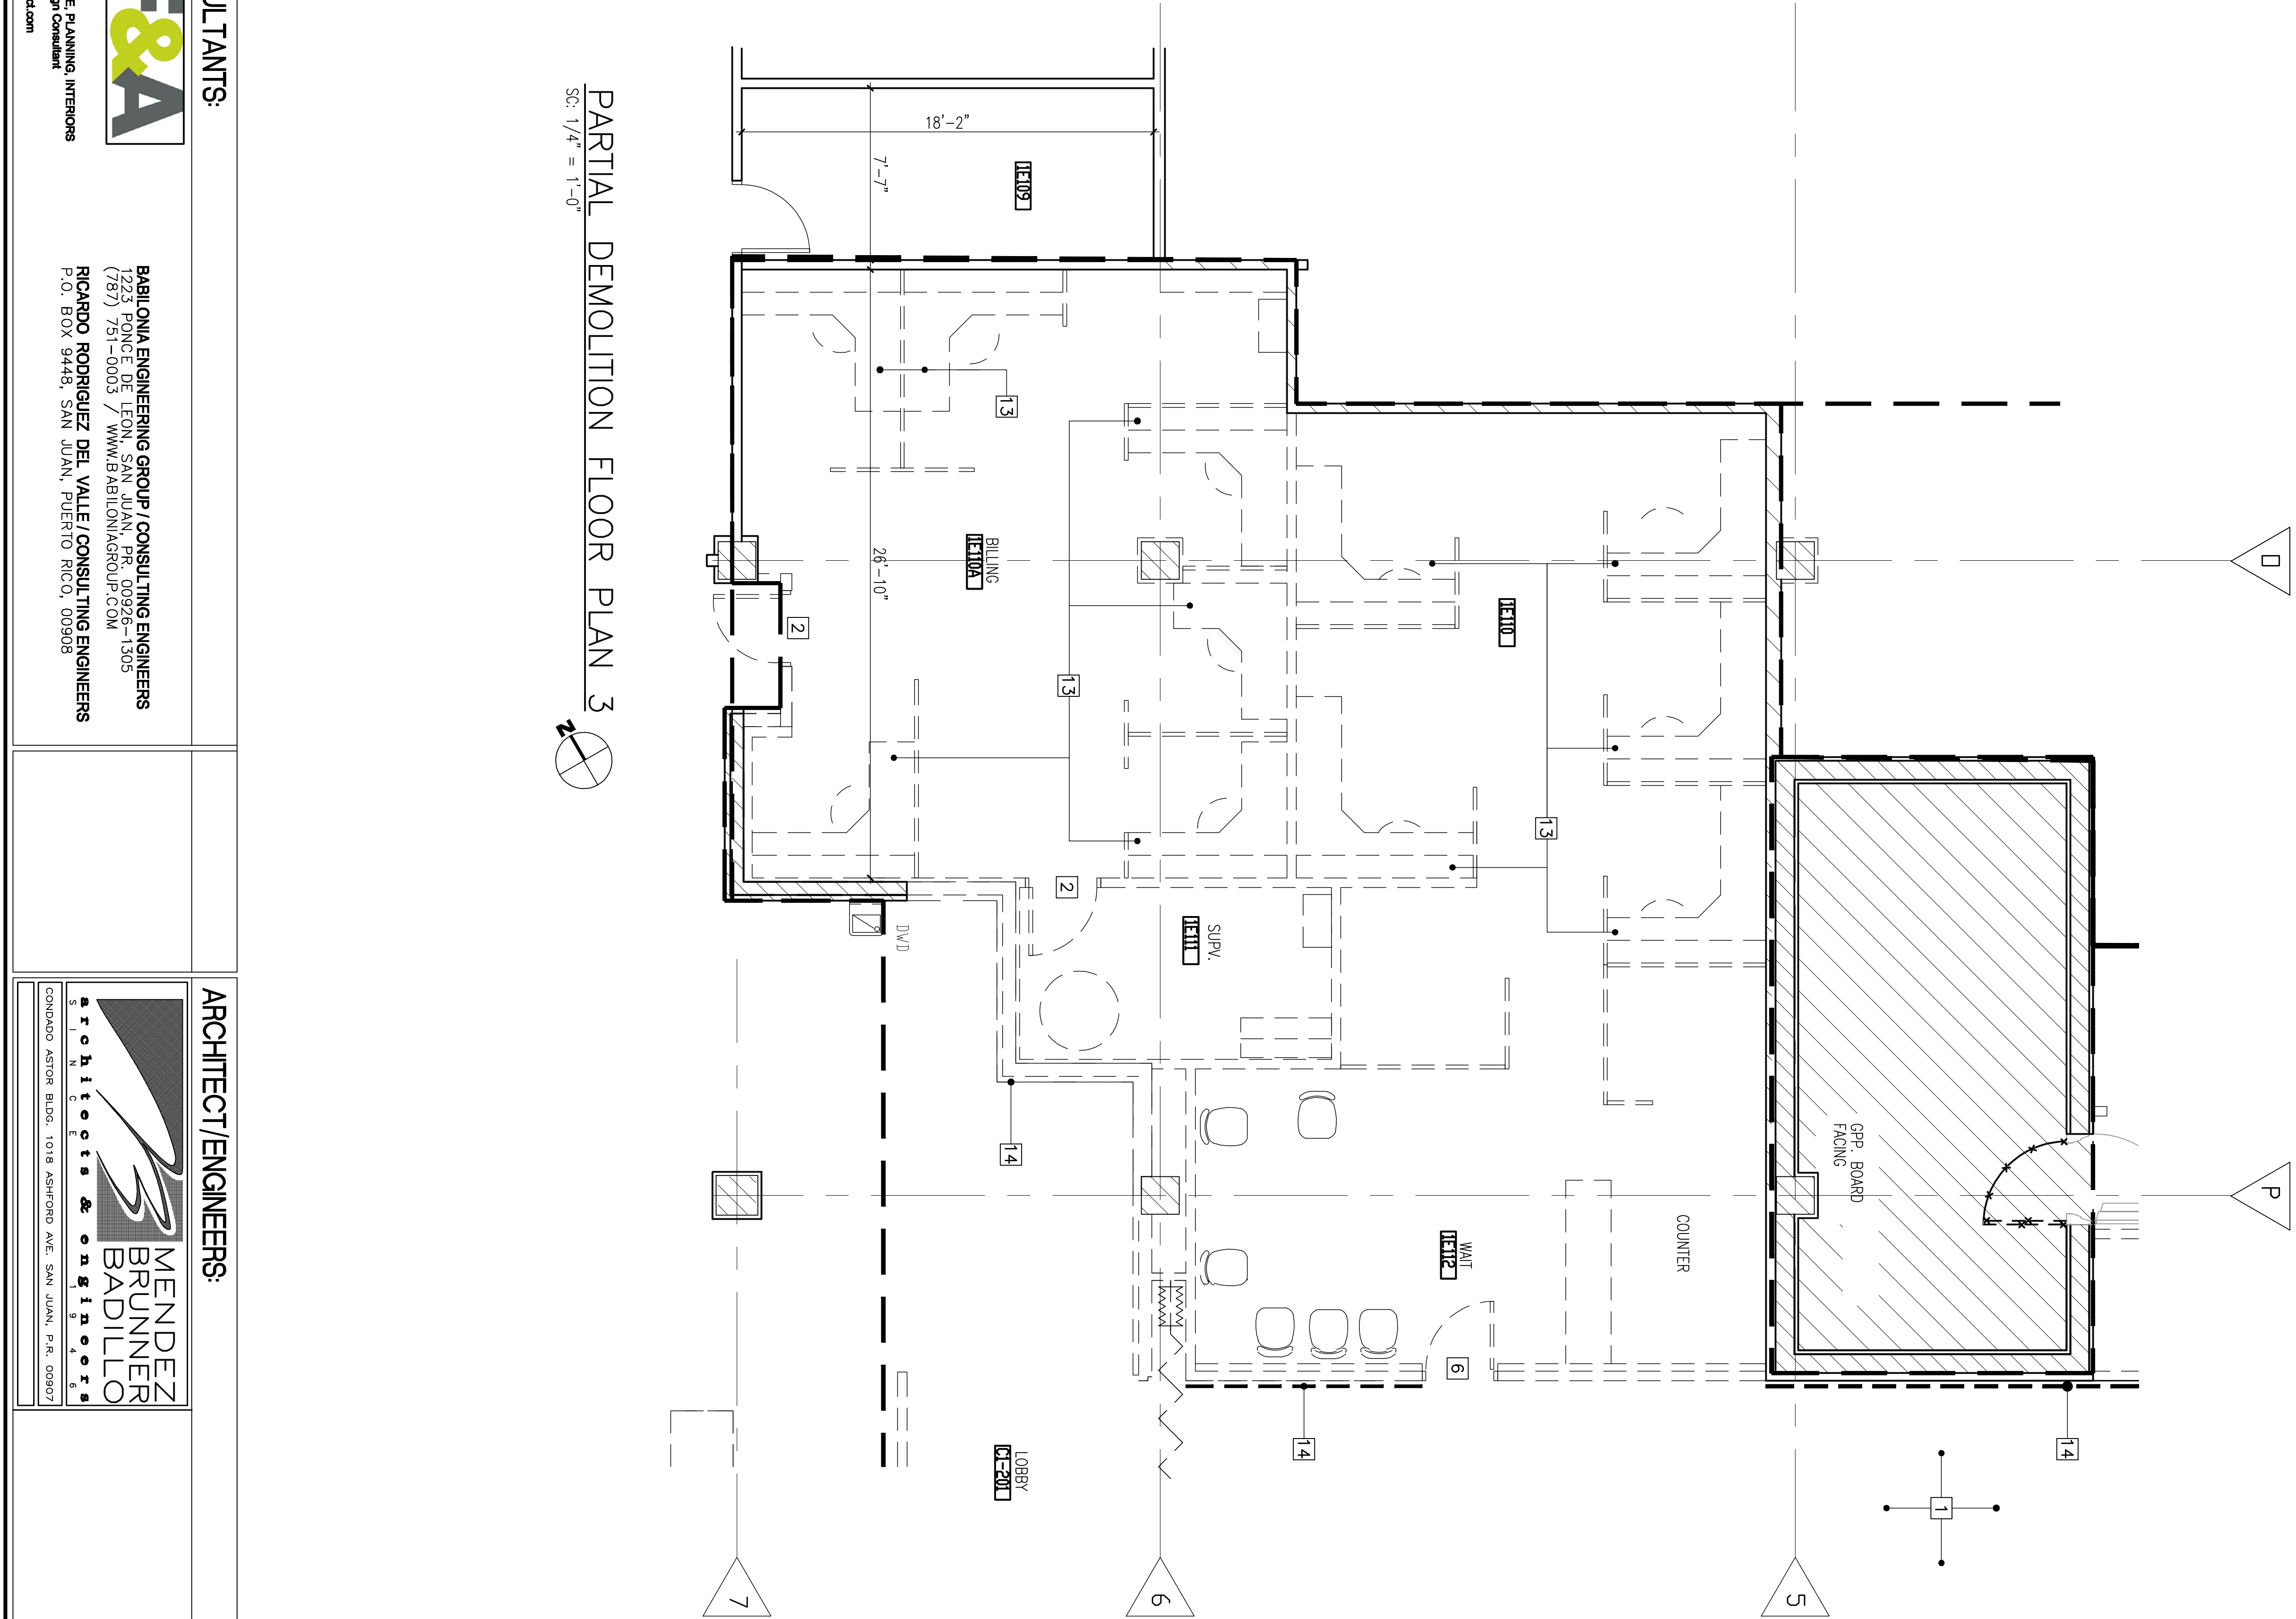

LEGEND

ROOM IDENTIFICATION

COLUMN GRIDS

WAITING AREA CHAIRS TO BE REMOVED

EXISTING WALLS TO REMAIN

COLUMN TO REMAIN

EXISTING CONCRETE CMU OR GYP. BS. WALL TO BE DEMOLISHED AS SHOWN IN DRAWINGS

SLIDING CURTAIN

WALL HANDRAIL (HANDICAPPED) TO BE REMOVED

DETAIL

BUILDING SECTION