

VA FORM 08-6231

Project Number	672-15-101
Building Number	
Drawing Number	D7
Sheet of	1
Date	AUGUST 11, 2016
Checked	R. G. M.
Drawn	
Design	

CONSULTANTS:

PF&A
ARCHITECTURE PLANNING INTERIORS
Interior Design Consultant
www.pfa-architect.com

BABILONIA ENGINEERING GROUP / CONSULTING ENGINEERS
1723 PONCE DE LEON, SAN JUAN, PR 00926-1305
(787) 751-0003 / WWW.BABILONIAGROUP.COM
RICARDO RODRIGUEZ DEL VALLE / CONSULTING ENGINEERS
P.O. BOX 9448, SAN JUAN, PUERTO RICO, 00908

ARCHITECT/ENGINEERS:

MENDEZ BRUNNER BADILLO
ARCHITECTS & ENGINEERS
CORONADO ASTOR BLDG., 1018 ASHFORD AVE. SAN JUAN, P.R. 00907

Drawing Title

DEMOLITION PARTIAL FLOOR PLAN 6

Approved: **HIRAN LOPEZ**
Project Manager
Miguel A. Cordero
Chief Project Section
Vilfredo Quiroga
Chief PMS

Project Title



EXPAND EMERGENCY DEPARTMENT & OBSERVATION UNIT

Location: **VMMC**
VETERANS MEDICAL CENTER
Date: **AUGUST 11, 2016**
Checked: **R. G. M.**
Drawn:

Project Number
672-15-101

Office of Construction and Facilities Management
Department of Veterans Affairs

PARTIAL DEMOLITION FLOOR PLAN 6
SC: 1/4" = 1'-0"

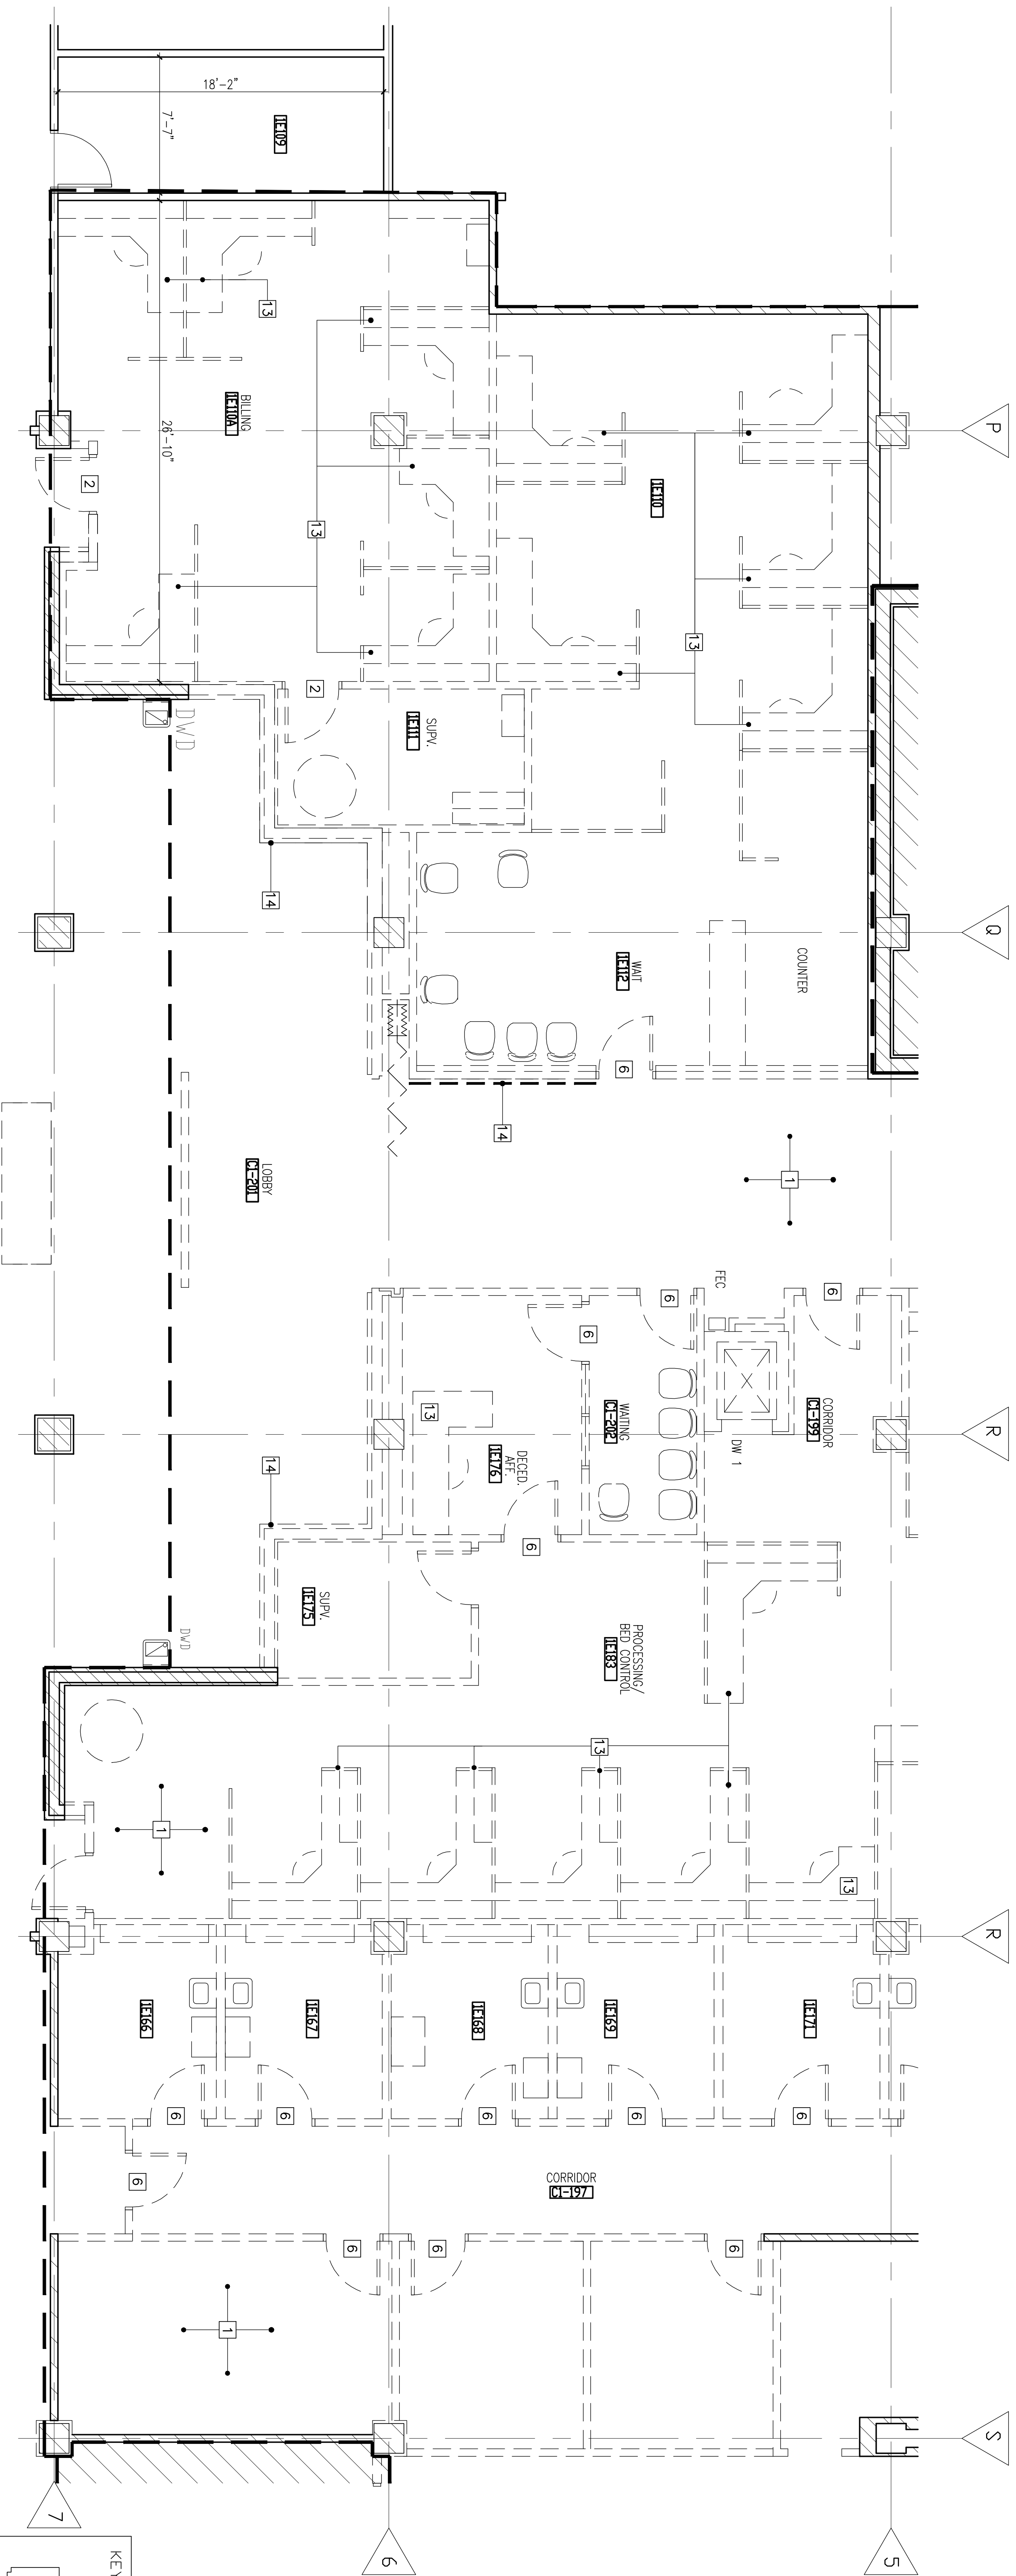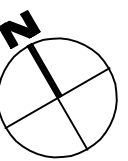

LEGEND

- ROOM IDENTIFICATION
- COLUMN GRIDS
- WAITING AREA CHAIRS TO BE REMOVED
- EXISTING WALLS TO REMAIN
- COLUMN TO REMAIN
- EXISTING CONCRETE CMU OR GRC BS. WALL TO BE DEMOLISHED AS SHOWN IN DRAWINGS
- SLIDING CURTAIN
- WALL HANDRAIL (HANDICAPPED) TO BE REMOVED
- DETAIL
- BUILDING SECTION

KEY PLAN

D E F
C B A

GRAPHIC SCALE
0' 1' 2' 4' 6' 8' 10' 12'
SC: 1/4" = 1'-0"

COORDINATES FOR WALL FINISHES
A B
C

CONSTRUCTION BID DOCUMENTS