

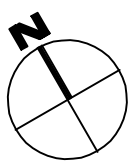
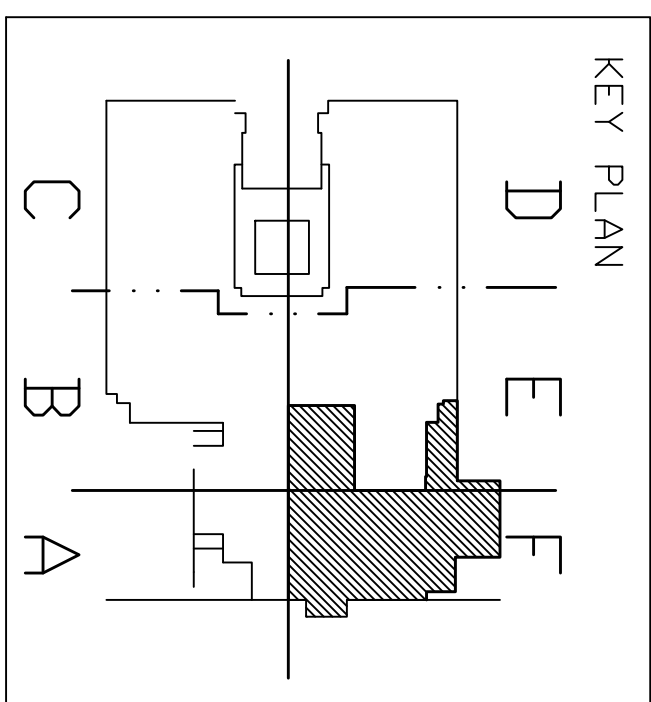


DEMOLITION GENERAL REFLECTED CEILING PLAN  
SC: 1/8" = 1'-0"

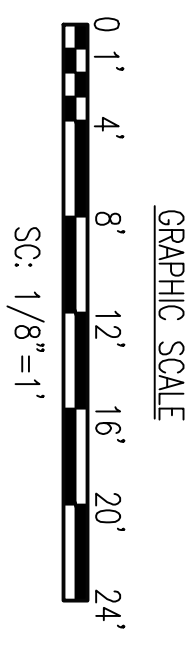

- LEGEND**
- 2' x 4' Acoustical Hung Ceiling
  - 2' x 2' Acoustic Ceiling Tile
  - Gypsum Board Ceiling
  - Existing 2' x 4' Lighting Fixtures
  - Wall Lighting Fixtures
  - Lamps (Refer to Electrical Drawings)
  - A/C Supply Grille
  - A/C Return Grille
  - Fire Protection Heads
  - Smoke Detector
  - Exit Sign
  - A/C Supply Grille
  - Ceiling Lamp

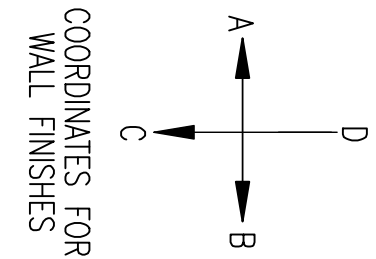

Revisions	Date

**CONSULTANTS:**

**PF&A**  
PF&A DESIGN  
ARCHITECTURE PLANNING INTERIORS  
Healthcare Design Consultants  
www.pfa-architect.com

**BABILONA ENGINEERING GROUP / CONSULTING ENGINEERS**  
1223 Ponce de Leon, San Juan, PR 00926-1305  
(787) 751-0003 / www.babilonagroup.com  
**RICARDO RODRIGUEZ DEL VALLE / CONSULTING ENGINEERS**  
P.O. BOX 9448, SAN JUAN, PUERTO RICO, 00908

**ARCHITECT/ENGINEERS:**

**MENDEZ BRUNER BADILLO**  
architects & engineers  
CONDOMINIO ASTOR BLDG., 1018 ASPENWOOD AVE., SAN JUAN, P.R. 00907

**Drawing Title**

**GENERAL DEMOLITION REFLECTED CEILING PLAN**

Approved: **HIRSH LOPEZ**  
Project Manager  
**Miguel A. Cordero**  
Chief Project Section  
**Wilfredo Quiñones**  
Chief FWS

**Project Title**

**EXPAND EMERGENCY DEPARTMENT & OBSERVATION UNIT**

Location: **VMMC**  
www.vmmc.com

Date: **AUGUST-11-2016**

Checked: **R. G. AL**

Drawn: **D8**

**Project Number**

**Building Number**

**D8**

**Office of Construction and Facilities Management**  
Department of Veterans Affairs