



Revision	Date

CONSULTANTS:

ARCHITECT/ENGINEERS:

In House Design

Drawing Title
FLOOR PLAN

Project Title
Remedy Boiler Plant Deficiencies

Project Number
564-16-103

Building Number
10

VHSO
Engineering
Service
Project

Approved Project Director

Fayetteville, AR

Drawing Number
AP101

Location


Checked
TMB

Drawn
JCH

Dwg 1 of —



SECOND FLOOR
SCALE: N15

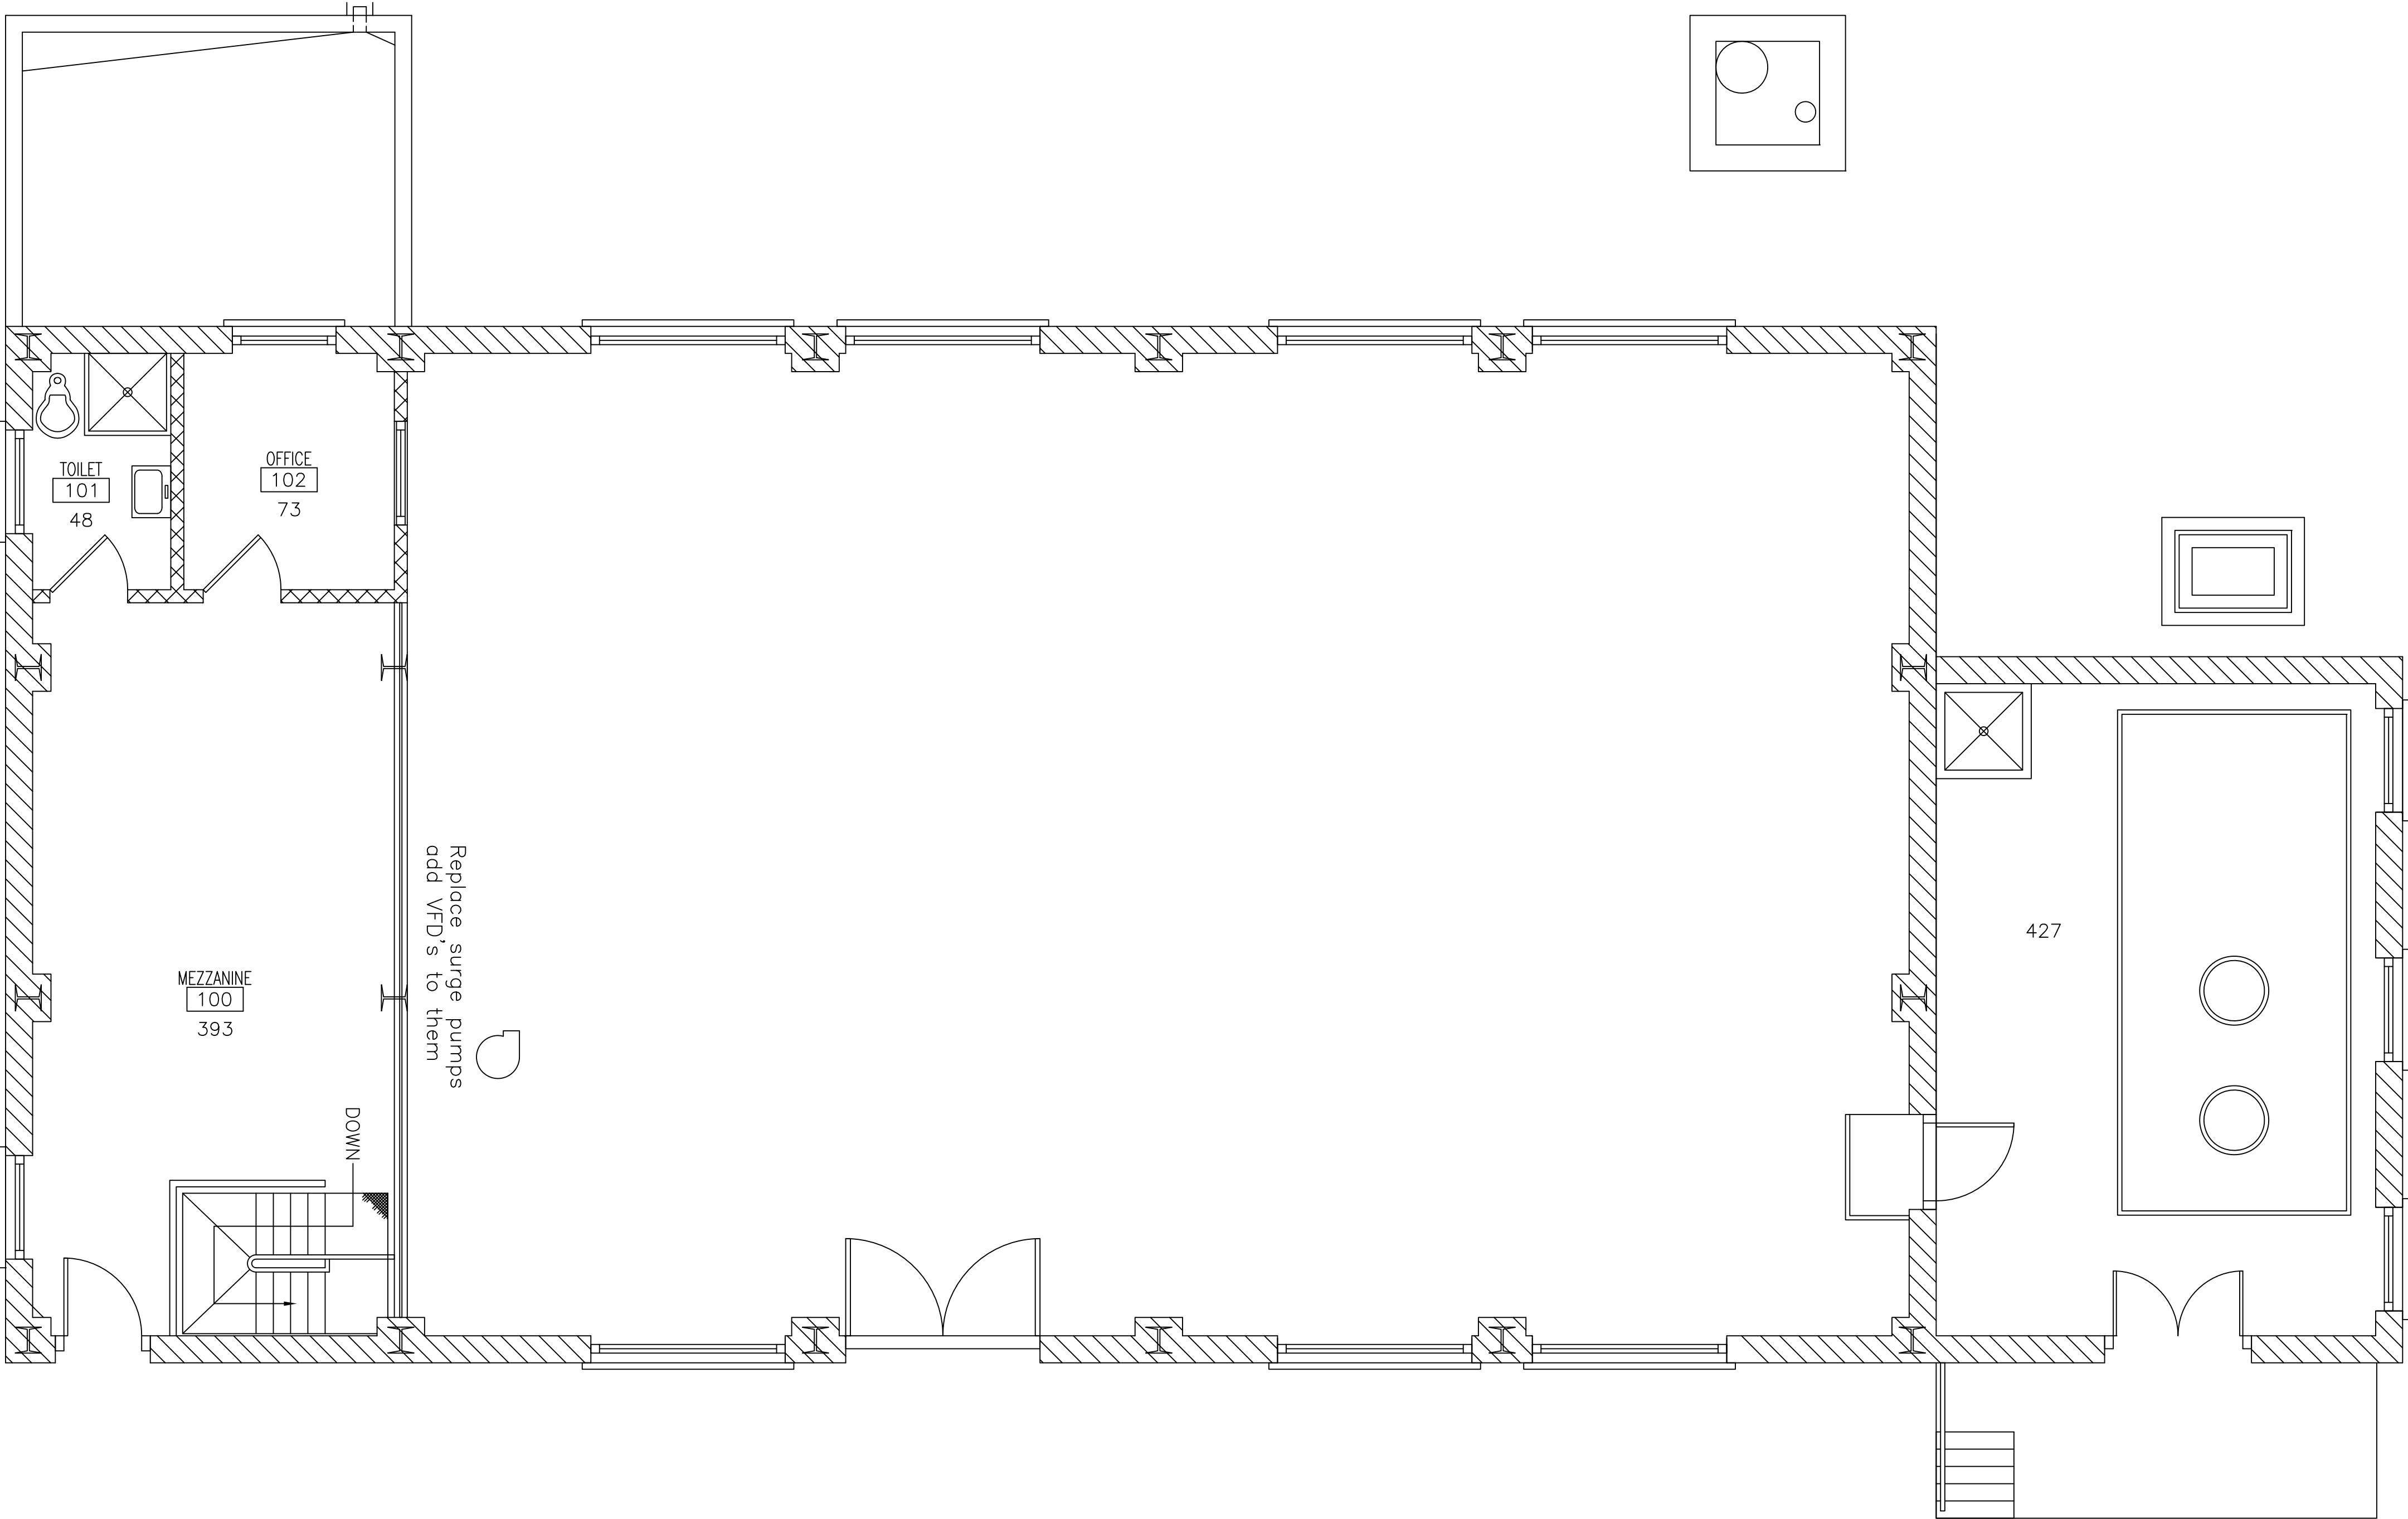

FIRST FLOOR
SCALE: N15

