



## ELECTRICAL SYMBOLS – LIGHTING PLAN

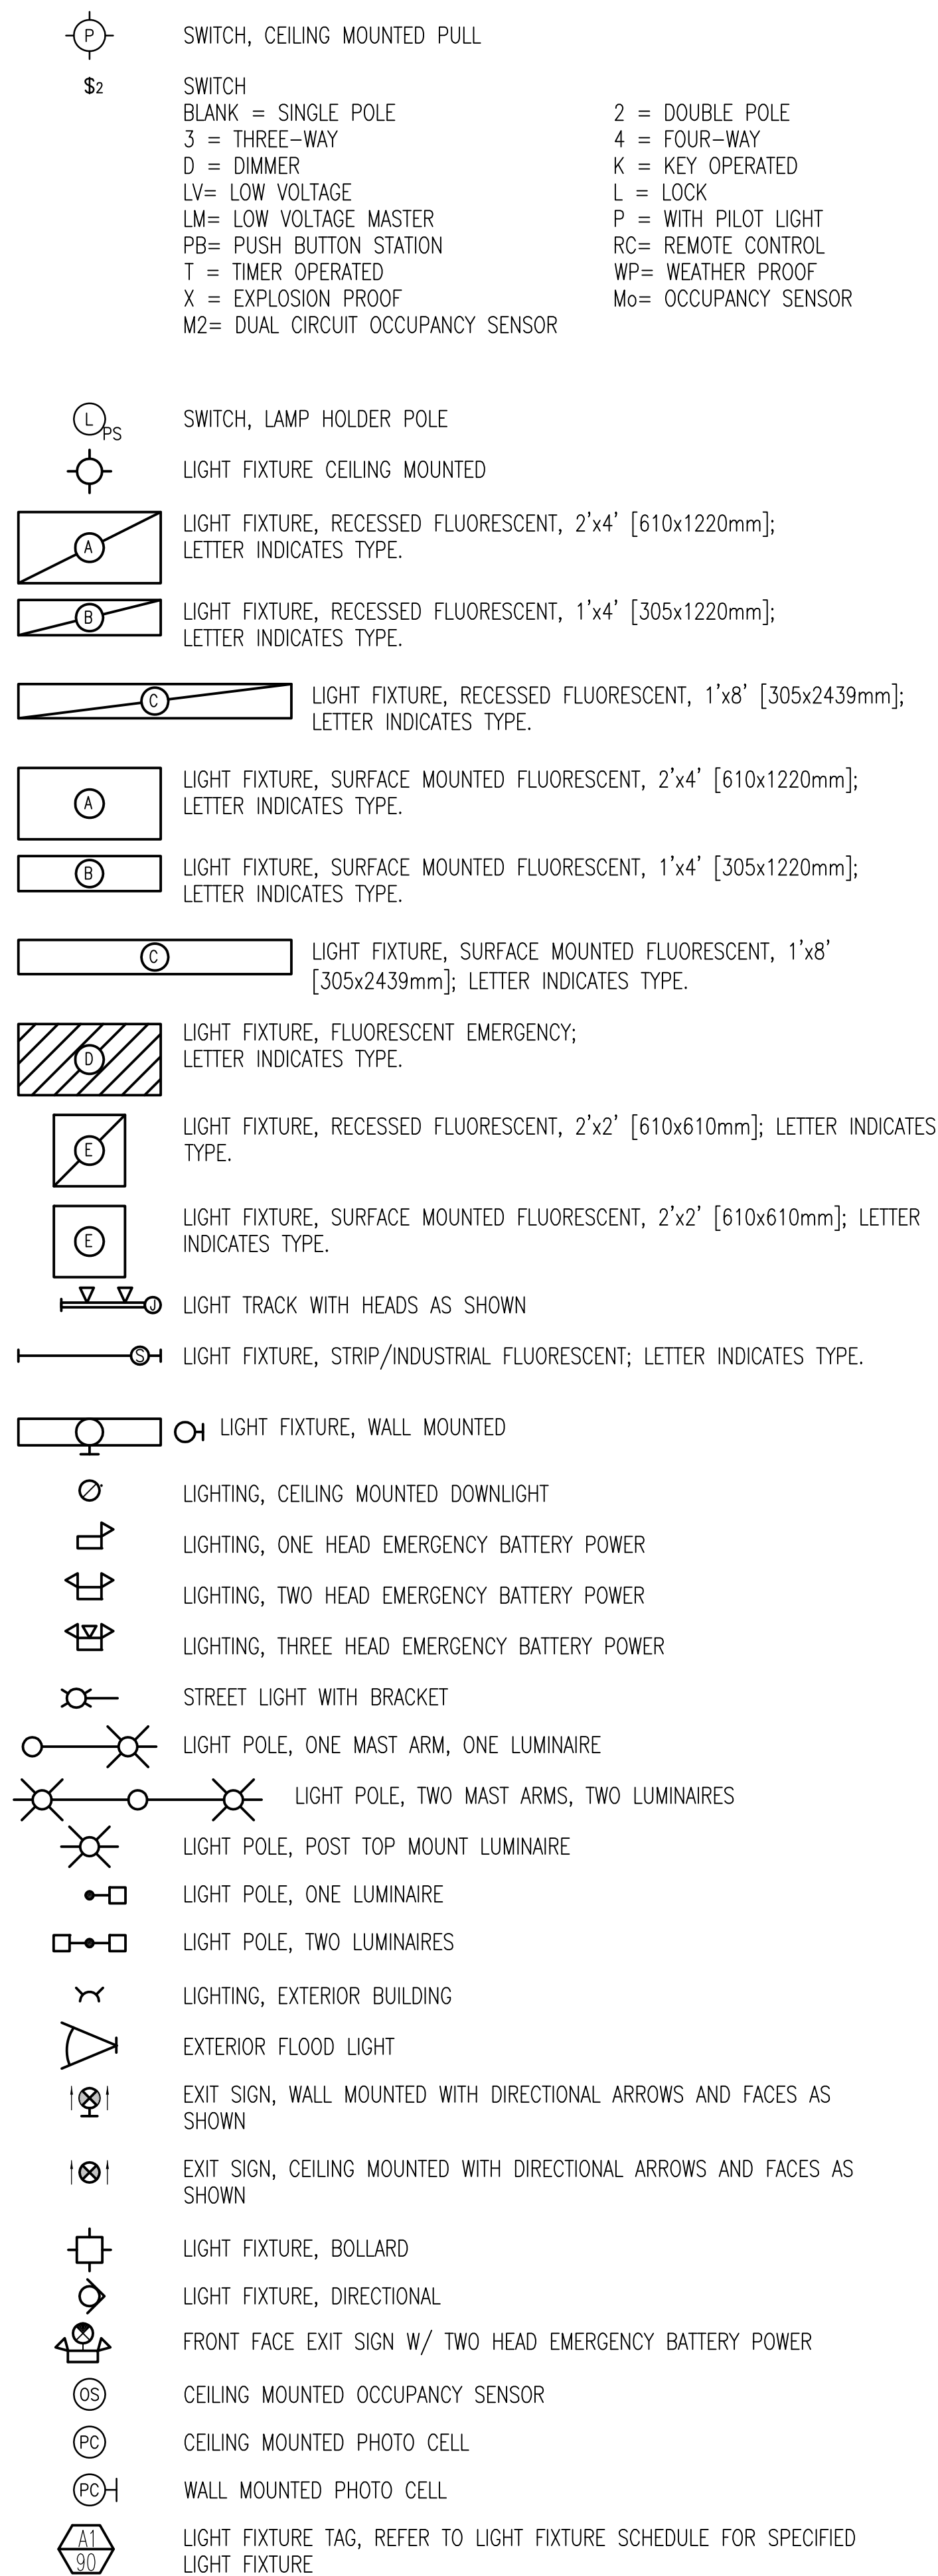


## ELECTRICAL SYMBOLS – POWER PLAN





## ELECTRICAL SYMBOLS – POWER PLAN

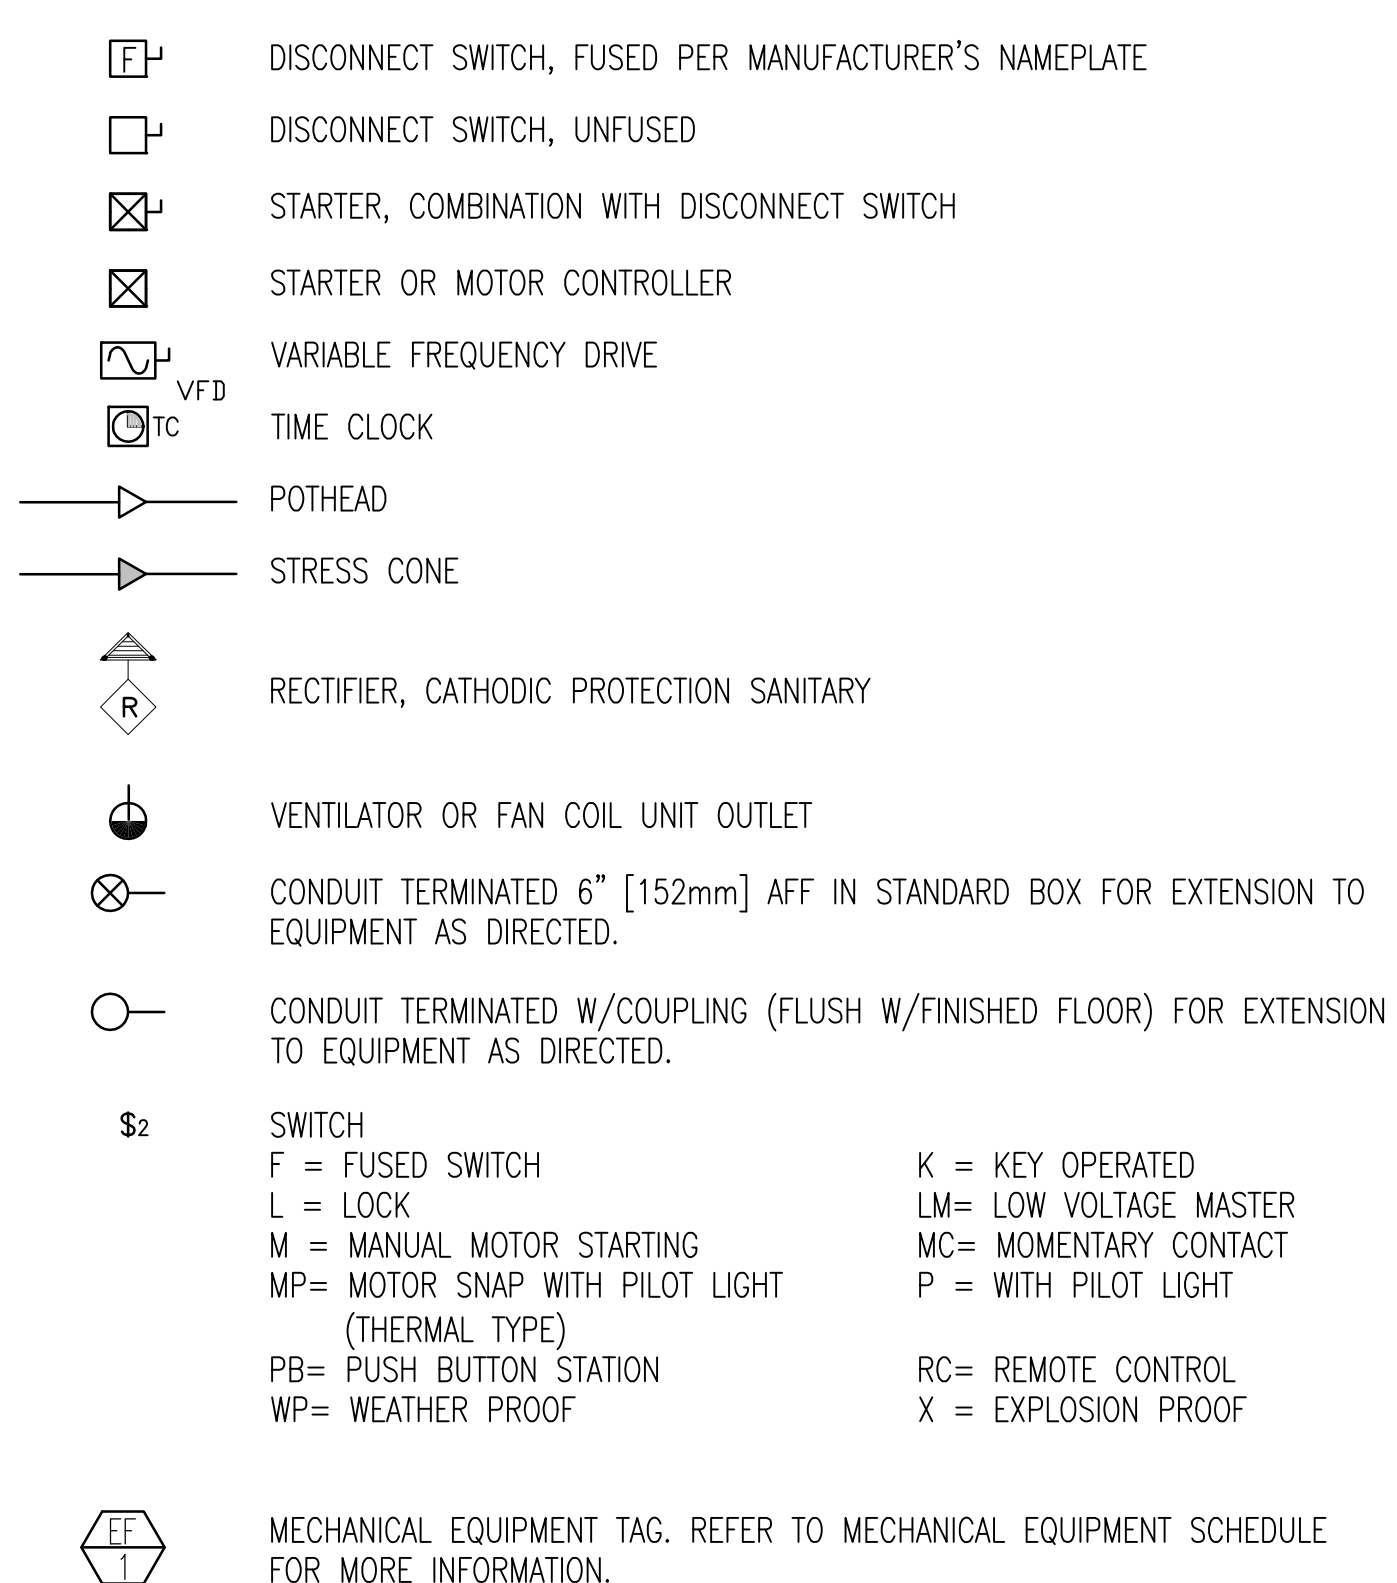

## ELECTRICAL SYMBOLS – DIAGRAM & FIRE/SAFETY

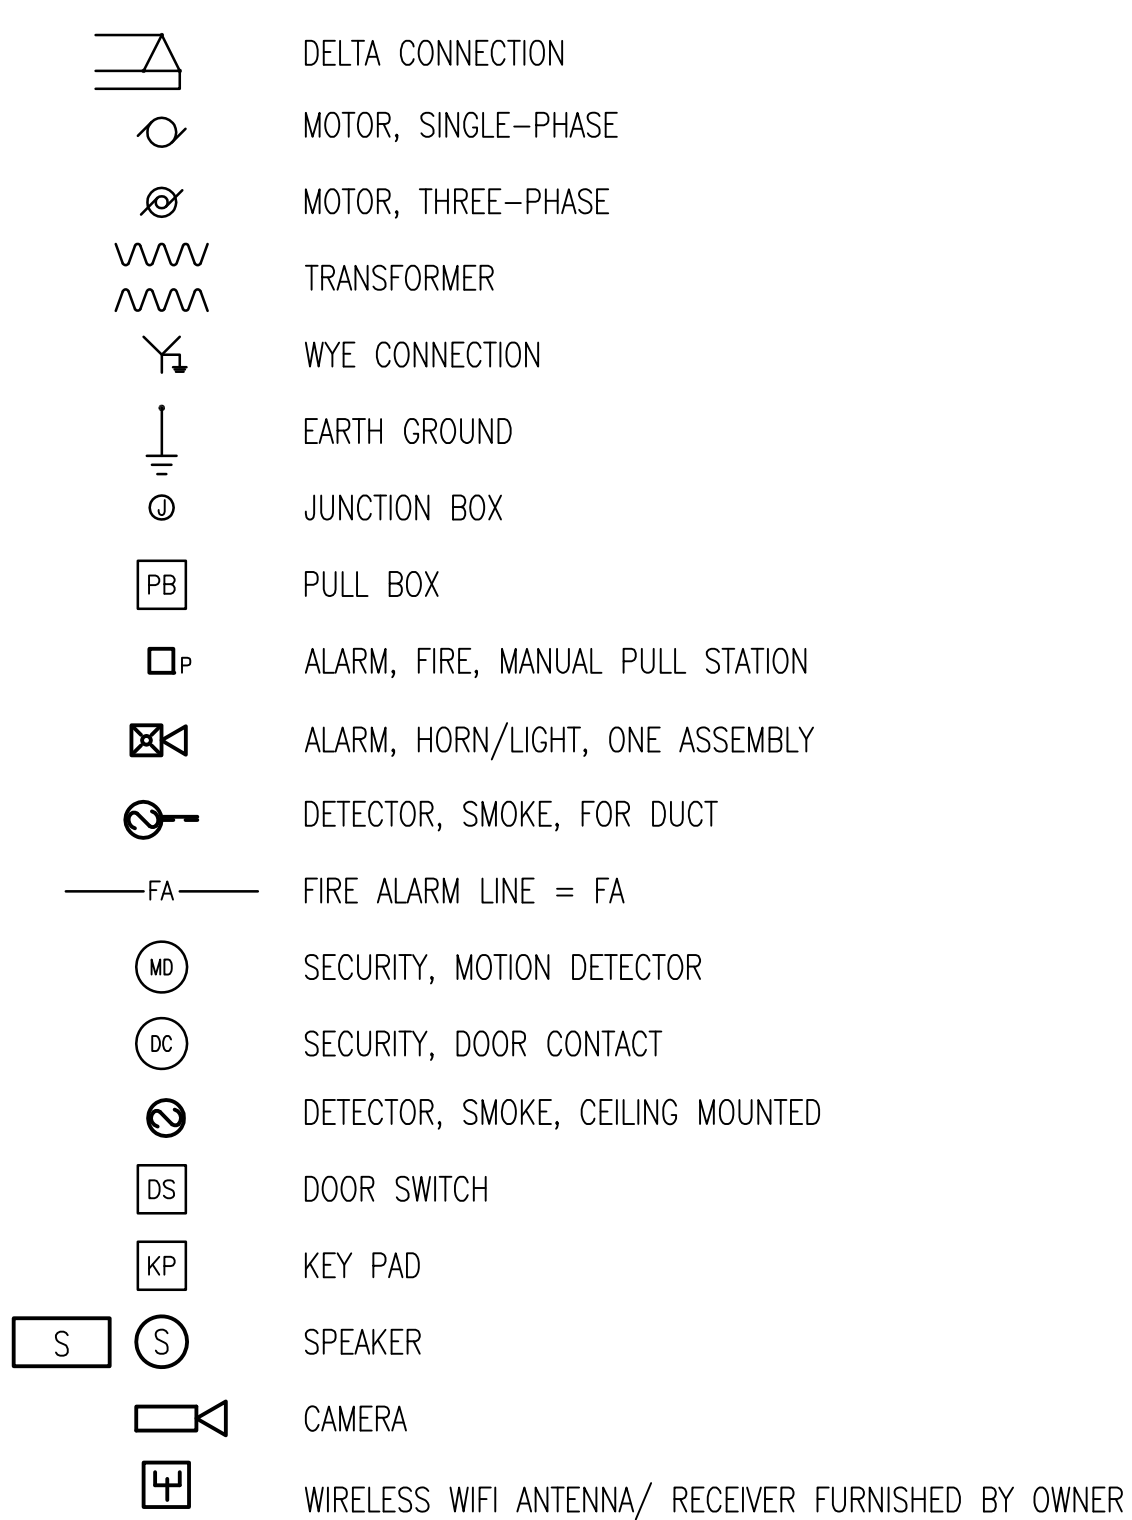[illegible]

**CONSULTANTS:**

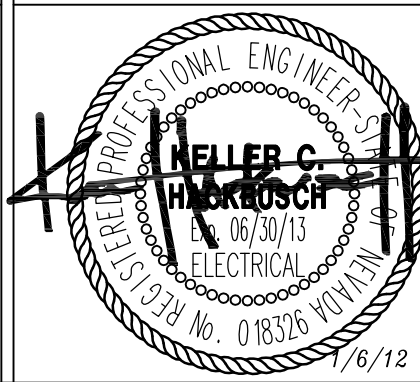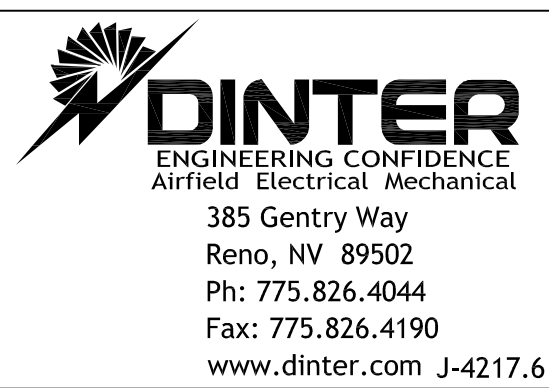

ARCHITECT/ENGINEERS:



Drawing Title	ELECTRICAL SYMBOLS LIST AND ABBREVIATIONS
---------------	---

Approved: Project Director

Project Title	VA SIERRA NEVADA HEALTH CARE SYSTEM - CANTEEN RELOCATION DESIGN - , RENO, NEVADA
---------------	--

Location  
975 KIRMAN AVE RENO NEVADA 89502

Date  
06 JAN, 2012

Checked  
ERG

Drawn  
RLB

Project Number  
654-11-227

Building Number  
XXXX

Drawing Number  
E 1.0.1

Office of  
Construction  
and Facilities  
Management

