
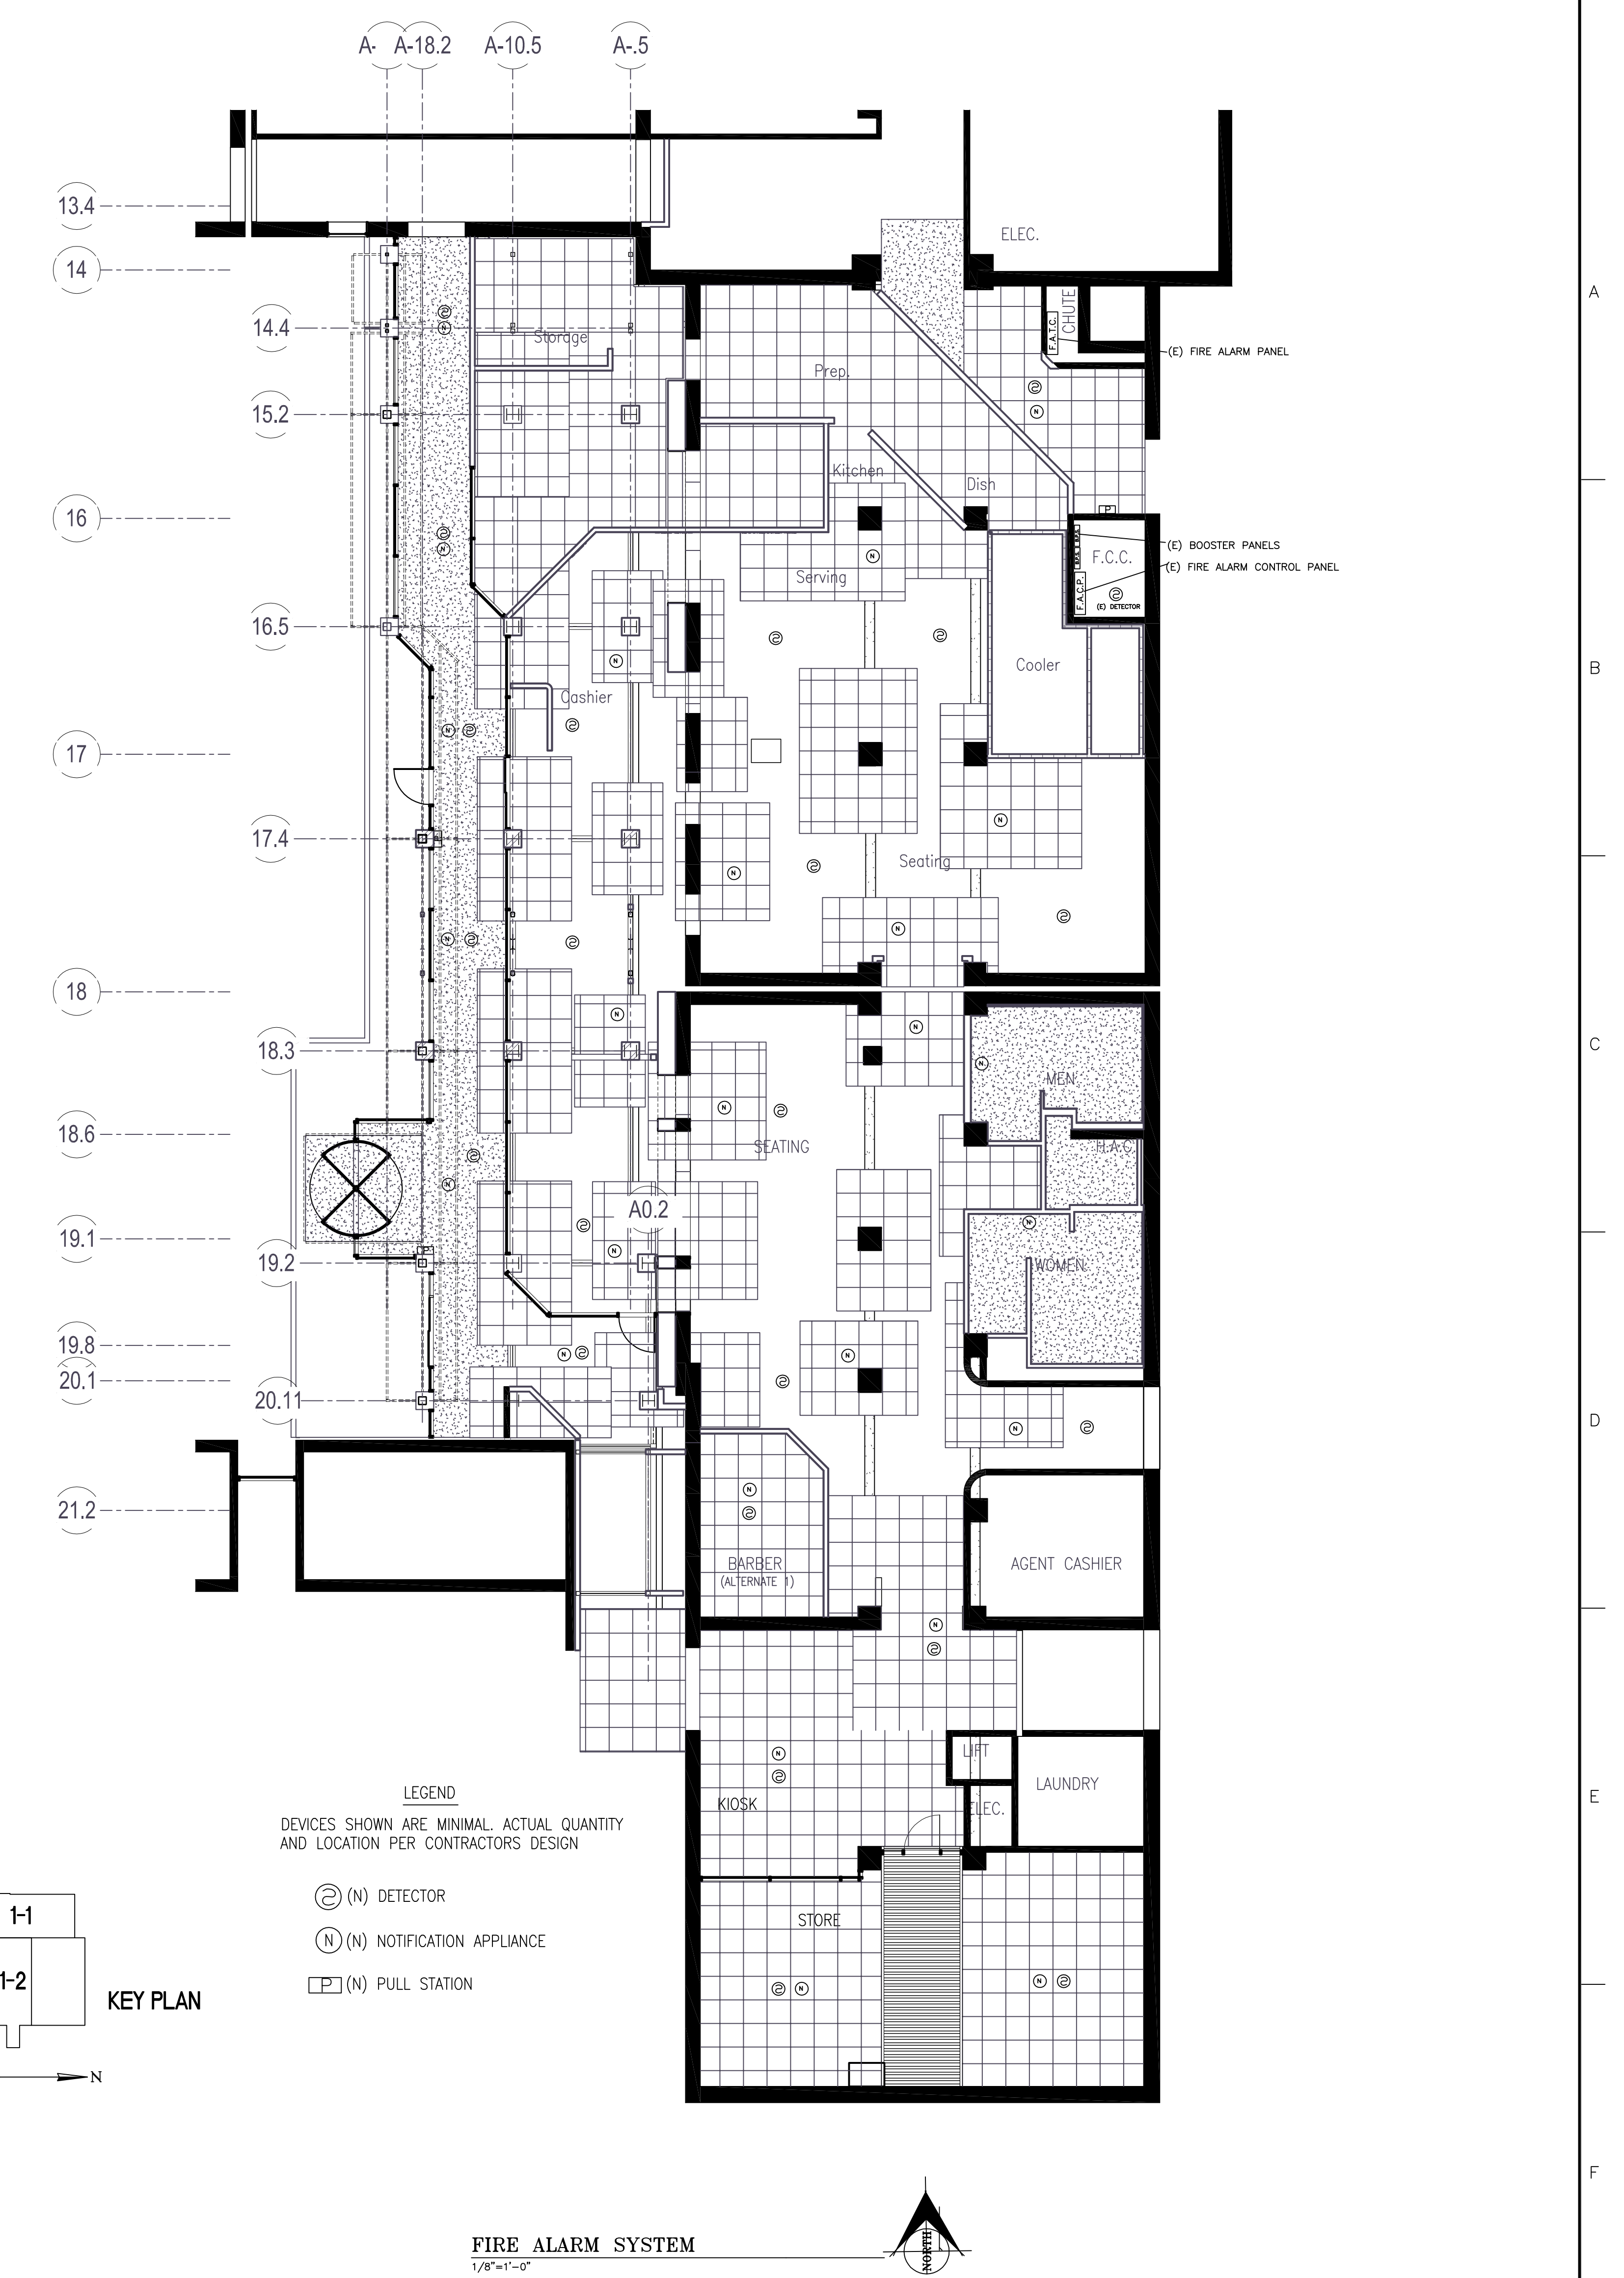
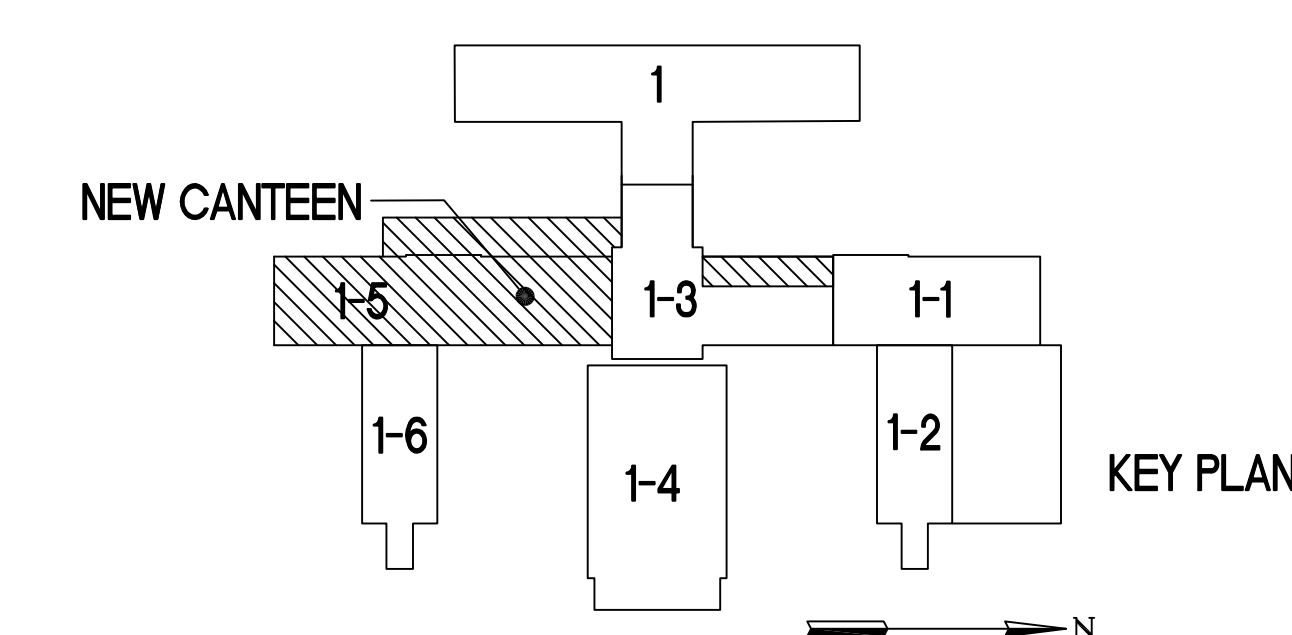


three inches = one foot
one and one half inches = one foot
one inch = one foot
three quarters inch = one foot
one half inch = one foot
three eighths inch = one foot
one quarter inch = one foot
one eighth inch = one foot

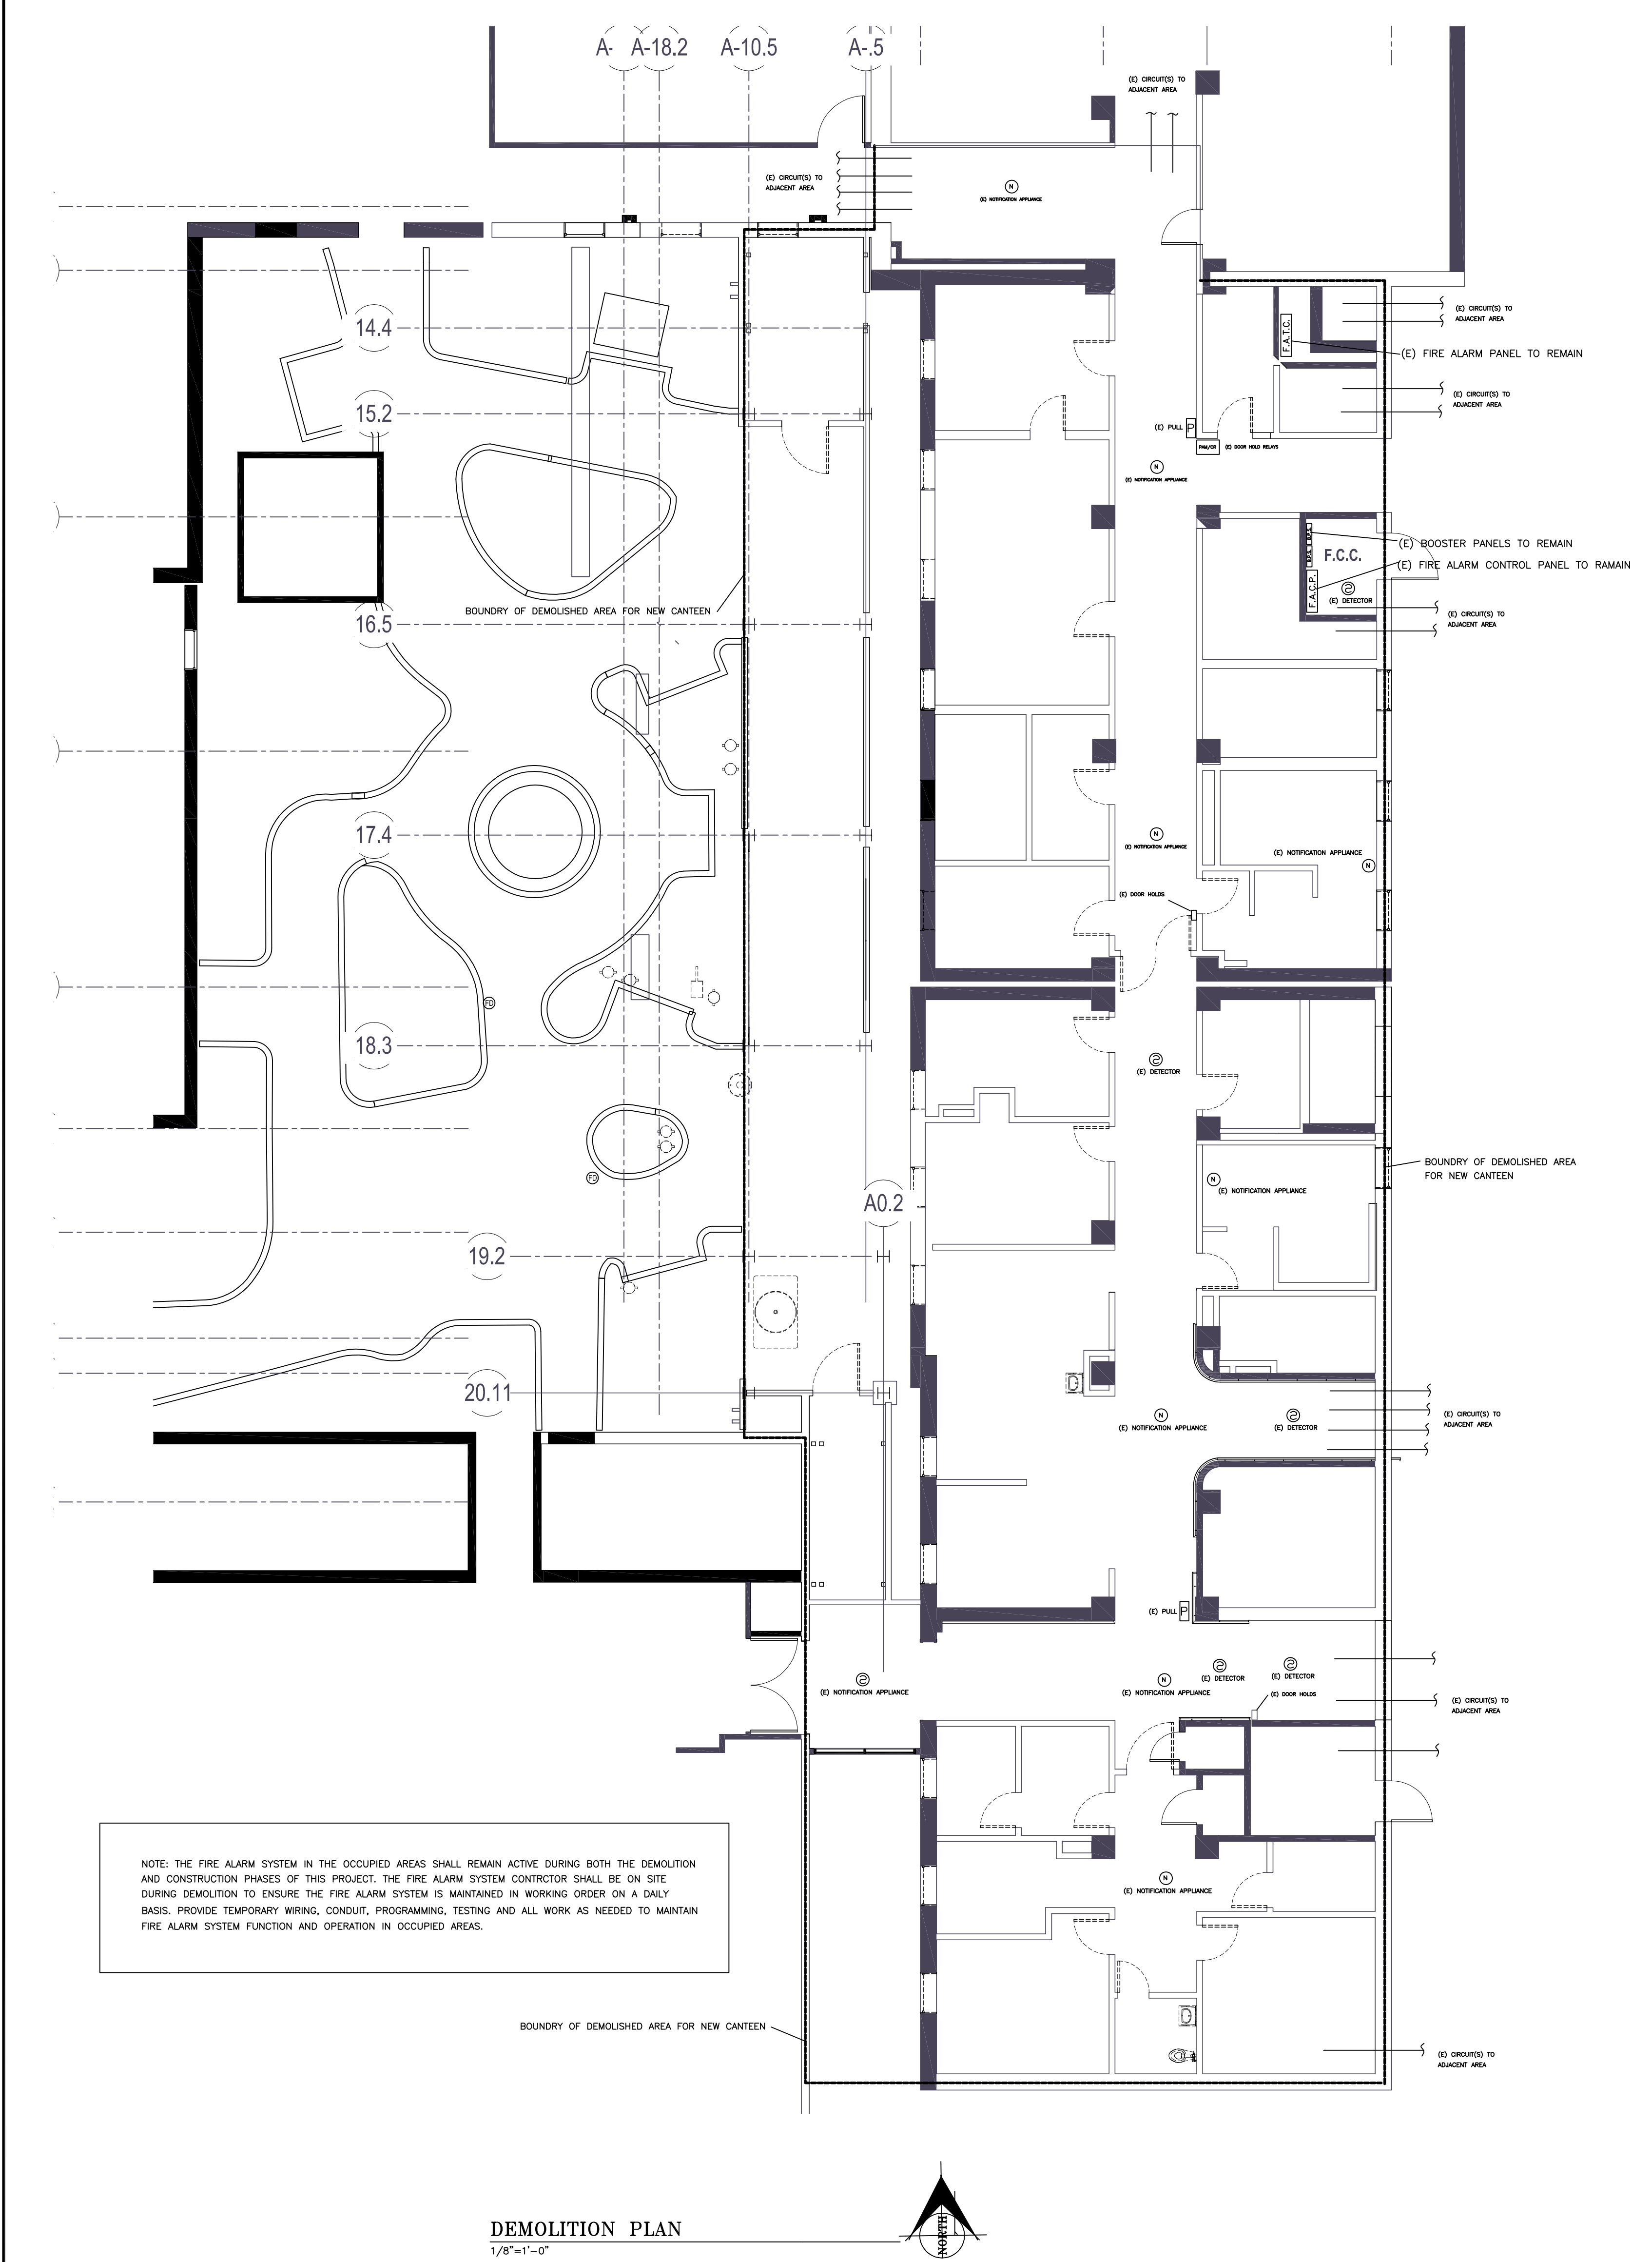

CONSULTANTS: ARTINEERING LANCE DEHNE, P.E. (775) 825- 0454 960 RIDGEVIEW DRIVE RENO, NEVADA 89511		ARCHITECT/ENGINEERS: VanWoert Bigotti archite 1400 S. VIRGINIA ST. SUITE C RENO, NEVADA 89502 P: 775.328.1100 F: 775.328.1100 WWW.VANWOERTBIGOTTI.COM		Project Title: VA SIERRA NEVADA HEALTH CARE SYSTEM - CANTEN RELOCATION DESIGN - , RENO, NEVADA Location: 975 KIRMAN AVE, RENO, NEVADA 89502 Date: 06 JAN 2012 Checked: LMD Drawn: ART Project Number: 654-11-227 Building Number: 1 Drawing Number: FP20 Dwg. 2 of 3		Office of Construction and Facilities Management Department of Veterans Affairs	
Revisions:		Demolition Plan 1/8"=1'-0"		Fire Alarm System 1/8"=1'-0"		FULLY SPRINKLERED	