

GENERAL RCP NOTES:

- A. CEILING HEIGHTS AT 8'-0" AFF UNO.
- B. SEE THIS SHEET AND AE01 FOR REFLECTED CEILING PLAN LEGEND.
- C. DIMENSIONS ARE TO FACE OF GYP BO UNO.
- D. MECHANICAL, ELECTRICAL, PLUMBING, TECHNOLOGY, FIRE ALARM AND FIRE PROTECTION SYMBOLS SHOWN ARE FOR COORDINATION PURPOSES ONLY AND DOES NOT REPRESENT THE SCOPE OF CONTRACT DOCUMENTS FOR MECHANICAL, ELECTRICAL, PLUMBING, TECHNOLOGY, FIRE ALARM AND FIRE PROTECTION WORK. REFER TO THE APPLICABLE DISCIPLINE'S CONTRACT DOCUMENTS FOR MECHANICAL, ELECTRICAL, PLUMBING, TECHNOLOGY, FIRE ALARM AND FIRE PROTECTION WORK.
- E. PROVIDE ACCESS PANELS IN HARD CEILINGS AS REQUIRED COORDINATE LOCATIONS WITH MECHANICAL, ELECTRICAL, PLUMBING & FIRE PROTECTION DRAWINGS.
- F. PROVIDE SEISMIC RESTRAINT FOR SUSPENDED CEILINGS. (SEE E3/AE540)
- G. LIGHT FIXTURES MOUNTED IN SUSPENDED CEILINGS SHALL BE LOCATED IN CENTERS OF CEILING PANELS UNLESS NOTED OTHERWISE.

FIRE PROTECTION SYMBOL LIST


- SYMBOL: DESCRIPTION:
- CHROME RECESSED SPRINKLER
- AUTOMATIC SPRINKLER SYSTEM COMPLYING WITH ICC-ES EVALUATION REPORT ESR-2397
- BRASS UPRIGHT SPRINKLER
- CORROSION RESISTANT BRASS UPRIGHT SPRINKLER
- BRASS HORIZONTAL SIDEWALL SPRINKLER
- CHROME HORIZONTAL SIDEWALL SPRINKLER
- PHOTOELECTRIC SMOKE DETECTOR
- HD HEAT DETECTOR
- CEILING MOUNTED VISUAL APPLIANCE
- CEILING MOUNTED SPEAKER/VISUAL APPLIANCE
- CEILING MOUNTED SPEAKER/VISUAL APPLIANCE

KEYED NOTES - RCP

- 1 ALIGN
- 2 CURB/CURB TRACK (SEE E6/AE540)
- 3 RECESSED SHADE (MOTORIZED) (SEE SCHEDULE OF FINISHES 090600)
- 4 RECESSED SHADE (NON-MOTORIZED) (SEE SCHEDULE OF FINISHES 090600)
- 5 SURFACE MOUNTED SHADE (NON-MOTORIZED) (SEE SCHEDULE OF FINISHES 090600)
- 6 SURFACE MOUNTED SHADE w/ (MOTORIZED) BLACK-OUT (SEE SCHEDULE OF FINISHES 090600)
- 7 SECURITY GRILLE (SEE SHEET AE641)
- 8 SURFACE MOUNTED DOUBLE SHADE (NON-MOTORIZED) (SEE SCHEDULE OF FINISHES 090600)
- 9 SURFACE MOUNTED DOUBLE SHADE (MOTORIZED) (SEE SCHEDULE OF FINISHES 090600)
- 10 RECESSED DOUBLE SHADE (MOTORIZED) (SEE SCHEDULE OF FINISHES 090600)
- 11 RECESSED DOUBLE SHADE (NON-MOTORIZED) (SEE SCHEDULE OF FINISHES 090600)
- 12 SURFACE MOUNTED SHADE (MOTORIZED) (SEE SCHEDULE OF FINISHES 090600)
- 13 CEILING MOUNTED MULTIMEDIA / DATA PROJECTOR (SEE E3/AE541)
- 14 RECESSED RETRACTABLE PROJECTION SCREEN (SEE F5/AE540)
- 15 CEILING TRACK FOR DENTAL OPERATING LIGHT (SEE C1/AE541)
- 16 OXYGEN & VACUUM OUTLETS - CEILING MOUNTED (SEE PLUMB DWGS)
- 17 CEILING TRACKS FOR RADIOLOGY EQUIPMENT (SEE C3/AE541)
- 18 EXHAUST FAN
- 19 CEILING MOUNTED EXAM LIGHT (SEE F5/AE541)
- 20 EXPANSION JOINT (SEE SHEET A1/AE540)
- 21 OVERHEAD LIFT (SEE A1/AE541)
- 22 BRICK SOFFIT (SEE D4/AE531)
- 23 EXPOSED STRUCTURE ABOVE (SEE STRUCT DWGS)
- 24 CONCEALED OVERHEAD COILING GRILLE (SEE F8/AE613)
- 25 CANOPY LIGHT FIXTURE (SEE ELEC DWGS)
- 26 DECORATIVE EXTERIOR FINISH SYSTEM (DEFS) (SEE F4/AE310)
- 27 CONTROL JOINT (SEE E4/AE540)
- 28 CONCEALED OVERHEAD COILING DOOR (SEE F7/AE613)
- 29 BRICK VENEER (SEE D4/AE531)
- 30 T & G HARDWOOD (SEE DTL SHT AE540)
- 31 FIRE & SMOKE CURTAIN (SEE D6/F8 & E9/AE615)
- 32 FAN COIL UNIT
- 33 MECHANICAL UNIT
- 34 METAL SOFFIT
- 35 SOFFIT VENT
- 36 STANDARD SLEEVE (SEE F4/AE310)

MEPT SYMBOLS LIST

- SYMBOL: DESCRIPTION:
- LIGHT FIXTURE, RECESSED FLUORESCENT, 2x4'
- LIGHT FIXTURE, RECESSED FLUORESCENT, 2x2'
- LIGHT FIXTURE, RECESSED FLUORESCENT, 6'x4'
- LIGHT FIXTURE, RECESSED FLUORESCENT, 6'x2'
- LIGHT FIXTURE, RECESSED FLUORESCENT, 3'DIA.
- LIGHT FIXTURE, RECESSED DOWNLIGHT, 6'DIA.
- 4' INDUSTRIAL LUMINAIRE
- LIGHTING, TWO HEAD EMERGENCY BATTERY POWER
- NOTE: CROSSHATCHING INDICATES LUMINAIRE IS CONNECTED TO AN EMERGENCY CIRCUIT
- EXIT SIGN, CEILING MOUNTED
- PHOTO CELL
- DAYLIGHT SENSOR
- OCCUPANCY SENSOR
- RECEPTACLE, DUPLEX
- MOTION DETECTOR CEILING MOUNTED
- SPEAKER CEILING MOUNTED
- CONNECTION FOR OFGI CAMERA
- WIRELESS ACCESS POINT
- FCU WITH STAMPED FACE RETURN
- LINEAR SUPPLY DIFFUSER (OR RETURN)
- 2'x4' RADIANT CEILING PANEL
- SUPPLY DIFFUSER
- RETURN GRILLE OR REGISTER
- EXHAUST GRILLE OR REGISTER
- CEILING MOUNTED PROJECTOR
- UNIT HEATER

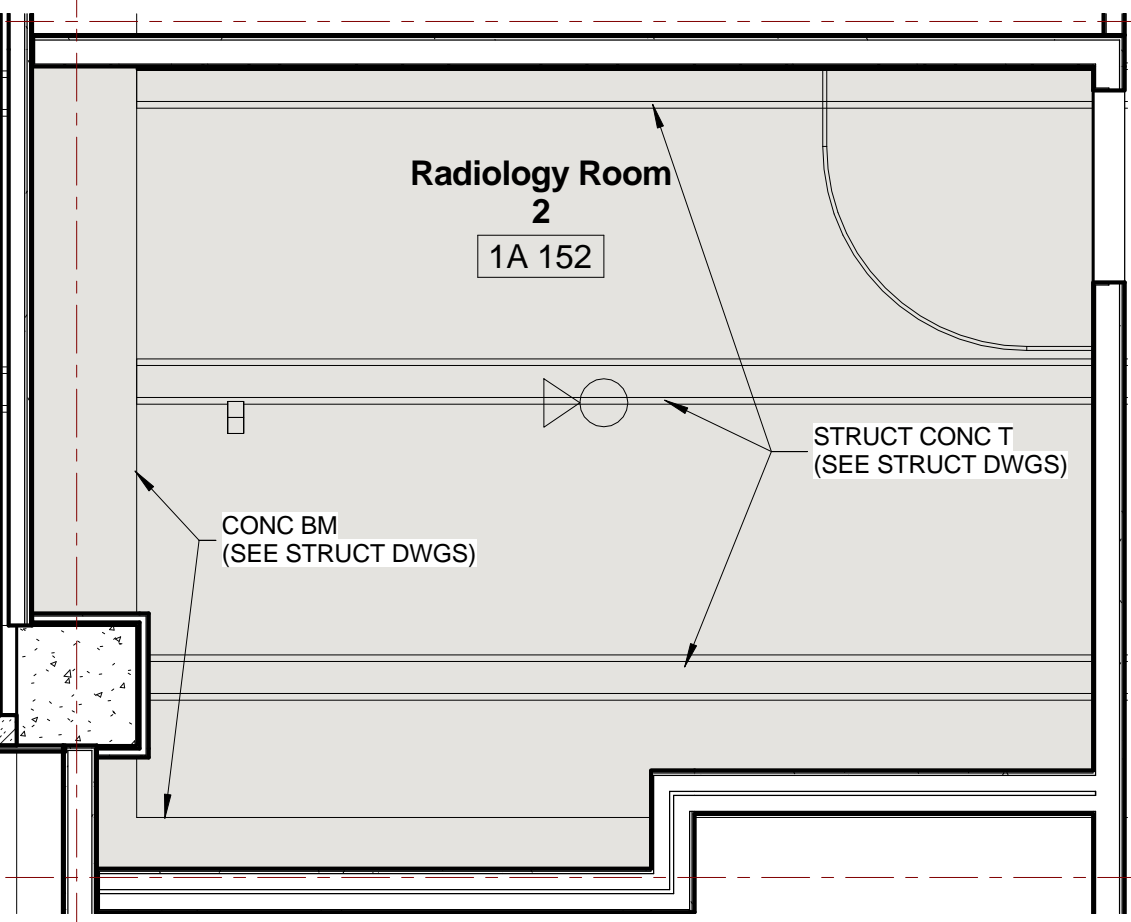

NOTE: PROVIDE 1/32" LEAD CONFORMING TO ALL CONCRETE SURFACES AT UNDERSIDE OF SECOND FLOOR SLAB.


3 E7 RADIOLGY ROOM 1A 152 RADIATION PLAN
AE452 F1 1/4" = 1'-0"

F1 AREA 1 RCP - RADIOLOGY, LAB & PATHOLOGY
AE201 C1 1/4" = 1'-0"

CONSULTANTS:

- STRUCTURAL ENGINEER:
KPF CONSULTING ENGINEERS
1630 DES PERES ROAD, SUITE 100
ST. LOUIS, MO 63131
PHONE: (314) 835-0524
- MECHANICAL/ELECTRICAL/PLUMBING:
KJWW ENGINEERING CONSULTANTS
#15 SUNNEN DRIVE, SUITE 104
ST. LOUIS, MO 63143
PHONE: (314) 645-1132
- CODE CONSULTANT/FIRE PROTECTION:
CODE CONSULTANTS, INC.
2043 WOODLAND PARKWAY, SUITE 300
ST. LOUIS, MO 63146
PHONE: (314) 991-2633
- CIVIL ENGINEER:
KJWW ENGINEERING CONSULTANTS
257 CHESTERFIELD BUSINESS PARKWAY
CHESTERFIELD, MO 63005
PHONE: (314) 630-9100
- AUTOMATIC TRANSPORT:
LERCH BATES INC.
8389 S. LINCOLN STREET, SUITE 207
LITTLETON, CO 80122
PHONE: (720) 283-8182
- HAZARDOUS MATERIALS:
ALTEC ENVIRONMENTAL CONSULTING, LLC
P.O. BOX 17867
SHREVEPORT, LA 71138-0867
PHONE: (318) 687-3771
- IRRIGATION CONSULTANT:
KJWW ENGINEERING CONSULTANTS
1204 WASHINGTON AVENUE, SUITE 200
ST. LOUIS, MO 63103
PHONE: (314) 662-9344

CERTIFICATE OF AUTHORITY: 000842

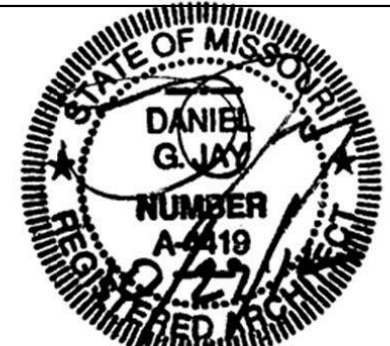

ARCHITECT:



THE SEAL (S) AND SIGNATURE(S) APPLY ONLY TO THE DOCUMENT TO WHICH THEY ARE AFFIXED, AND WE EXPRESSLY DISCLAIM ANY RESPONSIBILITY FOR ALL OTHER PLANS, SPECIFICATIONS, ESTIMATES, REPORTS, OR OTHER DOCUMENTS OR INSTRUMENTS RELATING TO OR INTENDED TO BE USED FOR ANY PART OF PARTS OF THE PROJECT.
© COPYRIGHT 2012 CHRISTNER INC.

Drawing Title
FIRST FLOOR - ENLARGED
REFLECTED CEILING PLAN - AREA 1

Approved: Project Director
John Sanders

Project Title
CLINIC BUILDING

Location
JEFFERSON BARRACKS DIVISION

Project Number
657-313D

Drawing Number
AE451

Office of
Construction
and Facilities
Management
Department of
Veterans Affairs