


VAMC
Coatesville
1400 Blackhorse Hill Road
Coatesville, PA 19320-2096
BUILDING 17
EMERGENCY MEP CHILLER CONNECTION
PROJECT #542-09-117

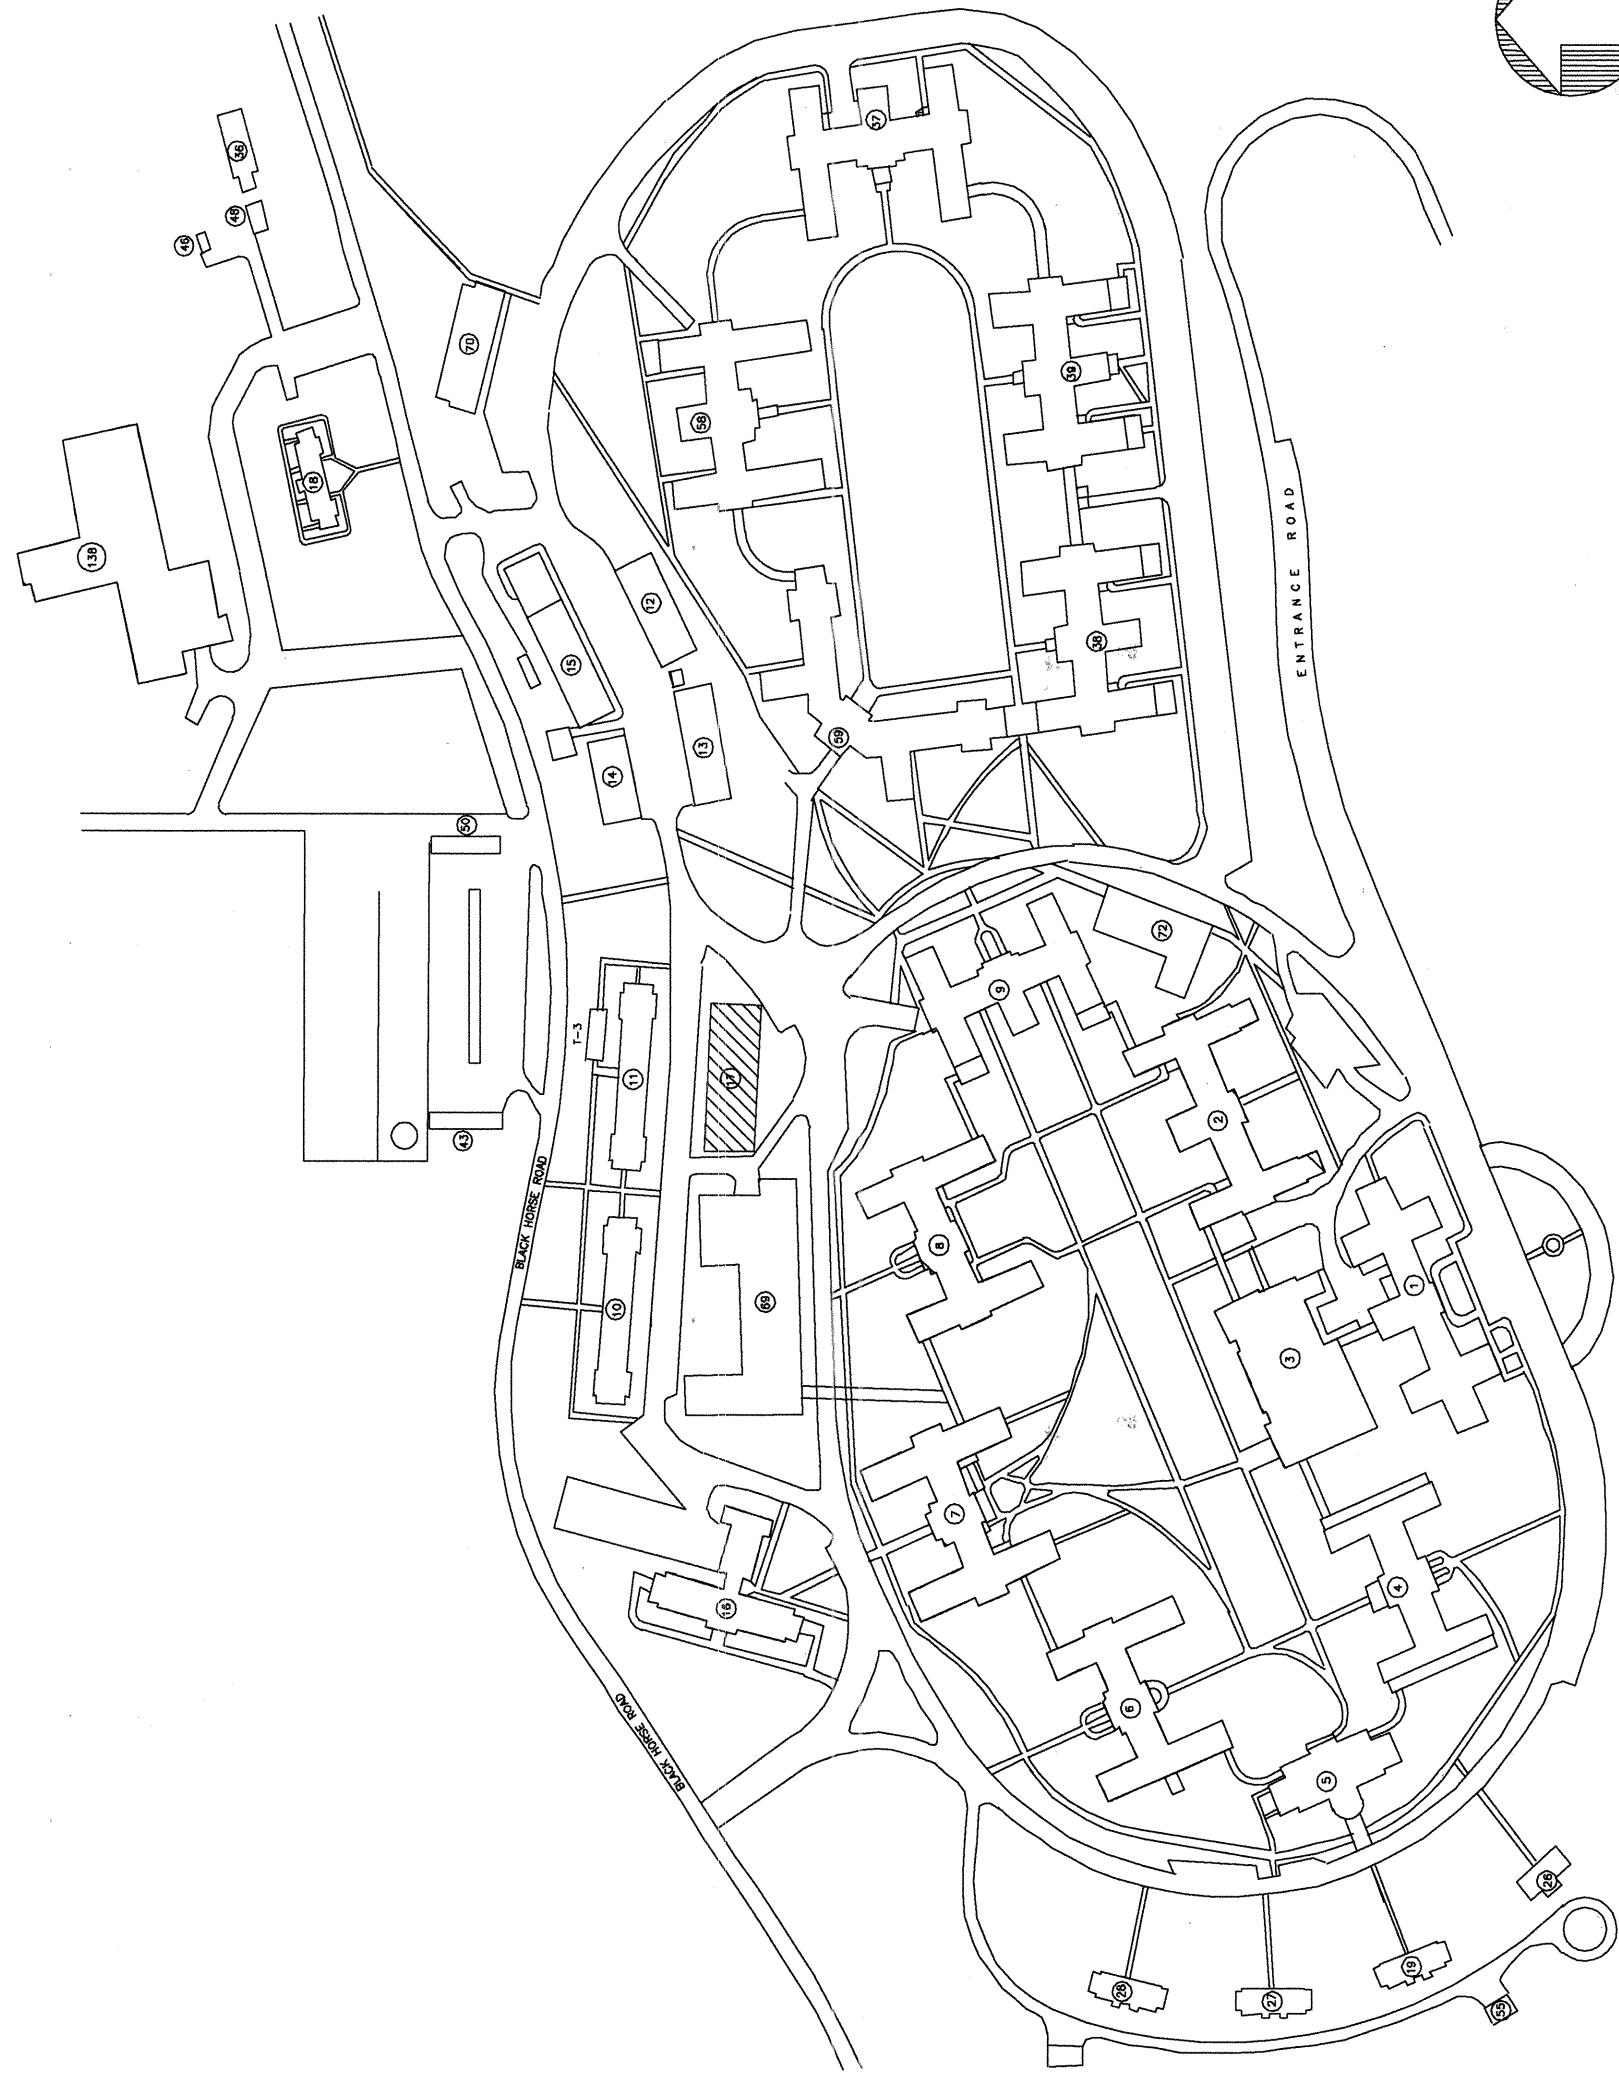

- DRAWING INDEX
- M-1 SYMBOLS, ABBREVIATIONS, NOTES, SCHEDULE AND DETAILS
 - M-2 BUILDING 17 MER NEW WORK PLAN
 - E-1 SYMBOLS AND DETAILS
 - E-2 FLOOR PLAN AND NOTES
 - E-3 ONE-LINE DIAGRAM, SCHEDULE AND DETAIL

FINAL CONSTRUCTION DOCUMENTS

Project Title EMERGENCY CHILLER MEP CONNECTION		Drawing Title COVER SHEET		DESIGN TECH INC. Engineering Services 10010 Kensington Parkway, Suite 200 P.O. Box 1000 Phone: 814-946-2068 Fax: 814-946-2069 Project # 1000		PROJECT MANAGER (CDTR) John Sauser		CHIEF ARMED SEC. CONTRACTING OFFICER Edward J. Smith		GENERAL PROPERTIES SECTION Steve Gray		INFECTION CONTROL COORDINATOR Janice Myers		Date	
Project No. 542-09-117		Drawing No. CS-1		Approved: Chief Engineering Service Stephen J. Blanchard		SUPERVISOR PROJECT SECTION Michael Carcano		GENERAL UTILITIES SECTION William Gulliver		GENERAL UTILITIES SECTION William Gulliver		SAFETY/OCCUPATIONAL HEALTH MGR Scott McNeil		Date	
Building Number 17		Checked Gary W. Javansky		Approved: Medical Center Director Gary W. Javansky		SUPERVISOR, BUILDING / M&O Kathy Seaba		VA POLICE CHIEF Gerald Bonner		PATIENT CARE SECTION Peter Buck		PATIENT SAFETY MANAGER Lyn Ordanez		Date	
Location COATESVILLE, PENNSYLVANIA		Drawn		Checked										Revisions	