

GENERAL NOTES


1. PROVIDE ALL SHOP DRAWINGS, SPRINKLERS, PIPE, FITTINGS, OFFSETS, HANGERS, EARTHQUAKE BRACING, DEVICES AND APPURTENANCES NECESSARY FOR A COMPLETE SYSTEM AS COORDINATED WITH ALL OTHER TRADES AND AS APPROVED BY THE AUTHORITY HAVING JURISDICTION.
2. ALL PIPING IS CONCEALED ABOVE CEILINGS, WHERE CEILINGS OCCUR, UNO.
3. SPRINKLERS IN 2X4 CEILING TILES SHALL BE LOCATED AT THE QUARTER POINTS OF THE TILE +/- 1". SPRINKLERS IN OTHER TYPES OF CEILINGS SHALL BE ALIGNED WITH OTHER CEILING ELEMENTS.

SPRINKLER LEGEND

- ⊙ = 1/2" QR PENDENT, WHITE RECESSED
 - = 1/2" QR BRASS UPRIGHT SPRINKLER
 - ▶ = 1/2" QR SIDEWALL, RECESSED, CHROME
- NOTE: ALL SPRINKLERS SHALL BE FM APPROVED

KEY NOTES

- ① UNDER BASE BID, REROUTE EXISTING PIPING AROUND NEW CART LIFT AS NECESSARY. NO WORK IF BID OPTION 2 IS TAKEN.
- ② WORK SHOWN IN THIS AREA IS UNDER BASE BID. ARRANGEMENTS WILL DIFFER SLIGHTLY IF BID OPTION 4 IS TAKEN.

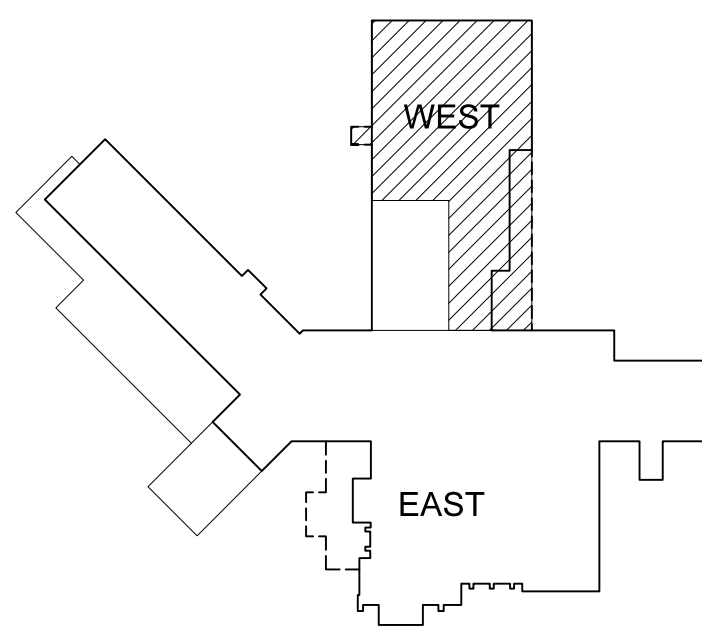

KEY PLAN
NOT TO SCALE

BASEMENT FIRE PROTECTION PLAN - WEST
Scale: 1/8" = 1'-0"
0 2 4 8' 16'

NAC | ARCHITECTURE

1203 W RIVERSIDE AVE | SPOKANE, WA 99201-1107 | P: 509.338.8240 | F: 509.338.8261

DEPARTMENT OF VETERANS AFFAIRS
MEDICAL CENTER

SPOKANE, WA 99205-6197

DEPARTMENT OF ENGINEERING OPERATIONS


MAIN OFFICE: 509-434-7900

CONSTRUCT ENDOSCOPY &
CENTRAL PROCESSING ADDITION,
VAMC SPOKANE

PROJECT NUMBER
668-309

SHEET TITLE
BASEMENT FIRE PROTECTION PLAN - WEST

SEAL

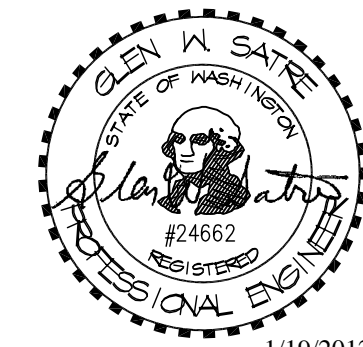

DESIGN GWS

DRAWN GWS

APPROVED GWS

DATE 1-19-2012


FILE NO.

NAC# 111-10028


SHEET NO.

FP
101

SHEET 147 OF 199

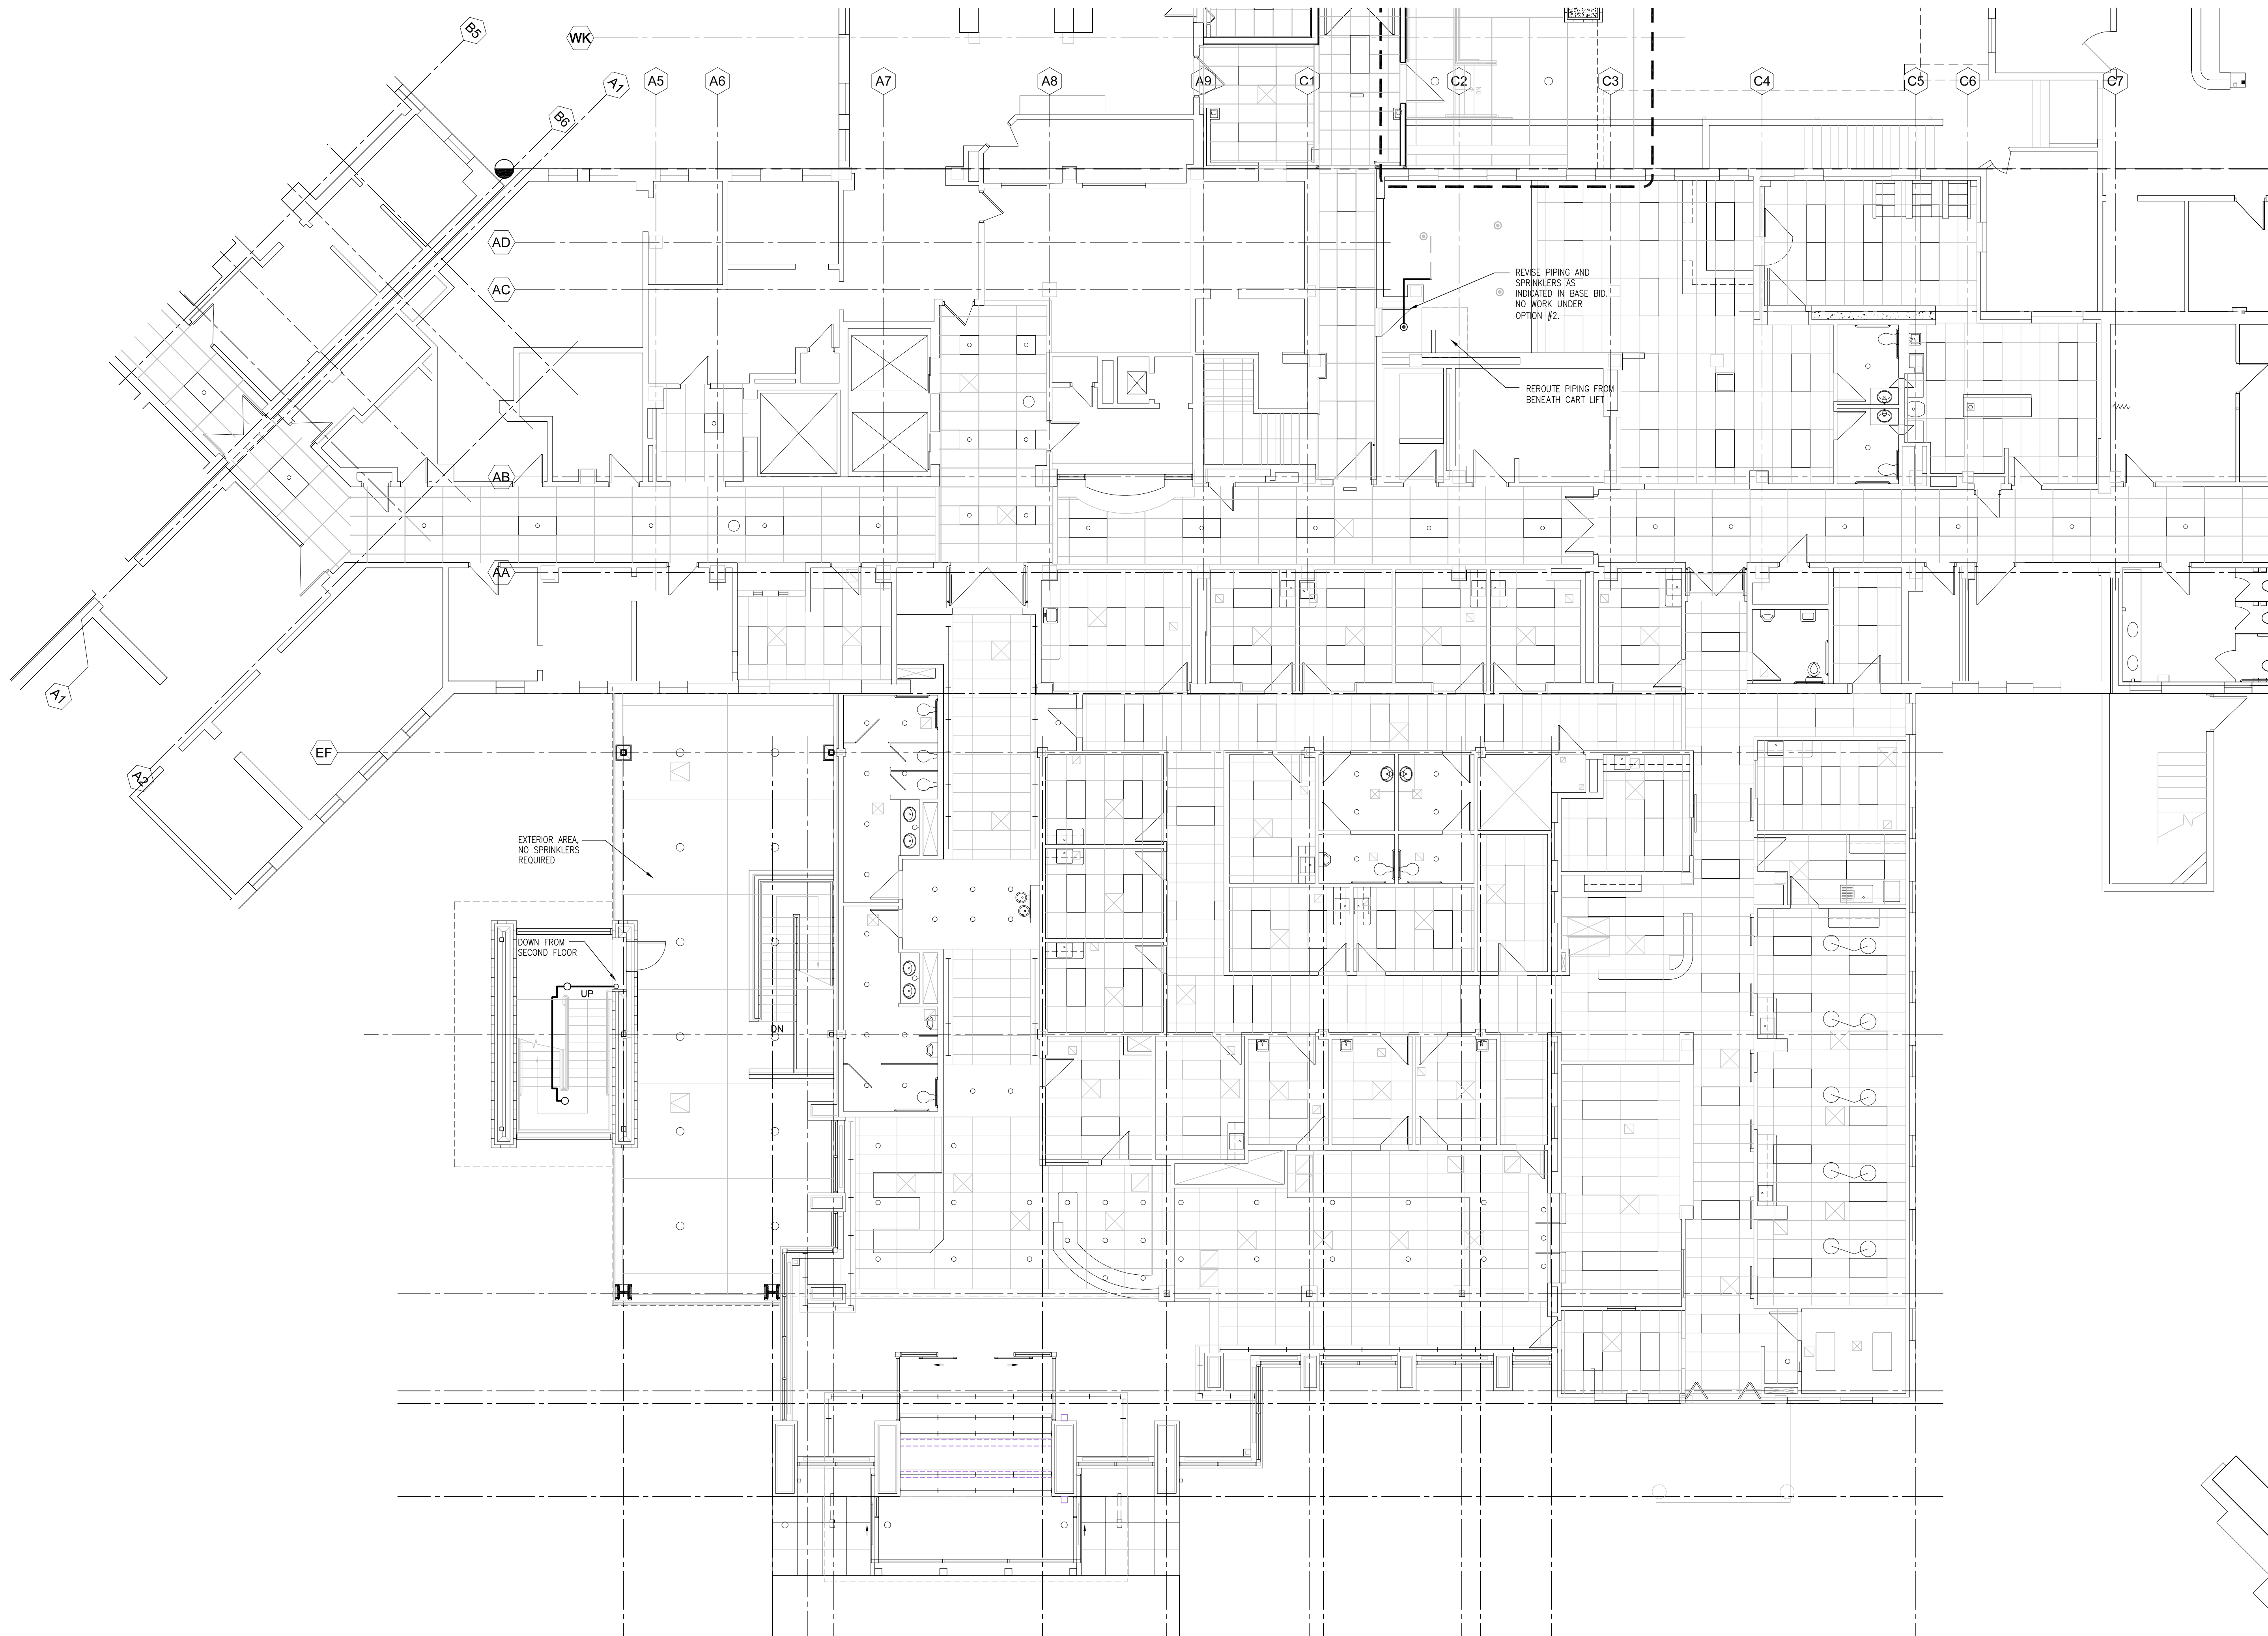

FIRST FLOOR FIRE PROTECTION PLAN - EAST
Scale: 1/8" = 1'-0"
0 2 4 8' 16'

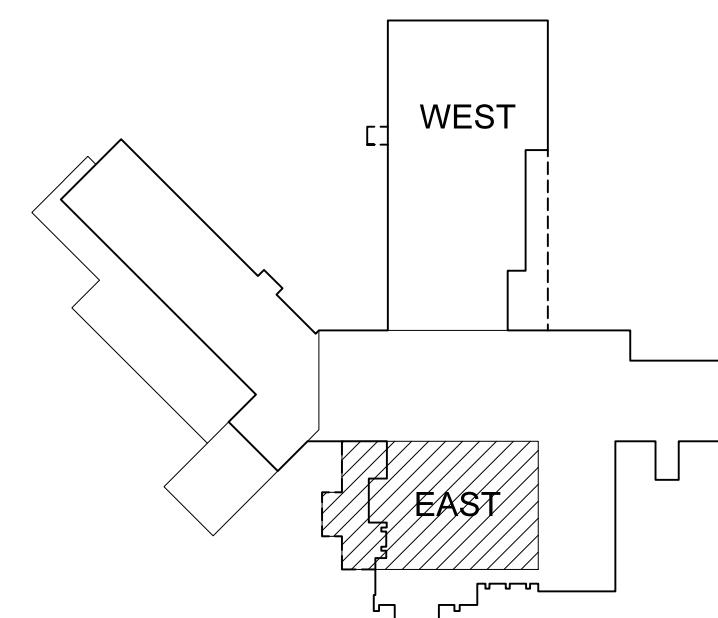

KEY PLAN
NOT TO SCALE XKEYPLAN

1203 N RIVERSIDE AVE | SPOKANE, WA 99201-1107 | P: 509.338.8240 | F: 509.338.8261

NAC | ARCHITECTURE

REV.	DATE	DESCRIPTION
1	3/12/2010	COORDINATION REVISIONS
2	3/18/2010	REVISION NOTES

DEPARTMENT OF VETERANS AFFAIRS
MEDICAL CENTER

DEPARTMENT OF ENGINEERING OPERATIONS
SPOKANE, WA 99205-6197
MAIN OFFICE: 509-434-7900
FAX: 509-434-7135

CONSTRUCT ENDOSCOPY &
CENTRAL PROCESSING ADDITION,
VAMC SPOKANE

PROJECT NUMBER
668-309

SHEET TITLE
1ST FLOOR FIRE PROTECTION PLAN - EAST


SEAL

1/19/2012

DESIGN	GWS
DRAWN	GWS
APPROVED	GWS
DATE	1-19-2012
FILE NO.	NAC# 111-10028

SHEET NO.
FP 102

SHEET 148 OF 199

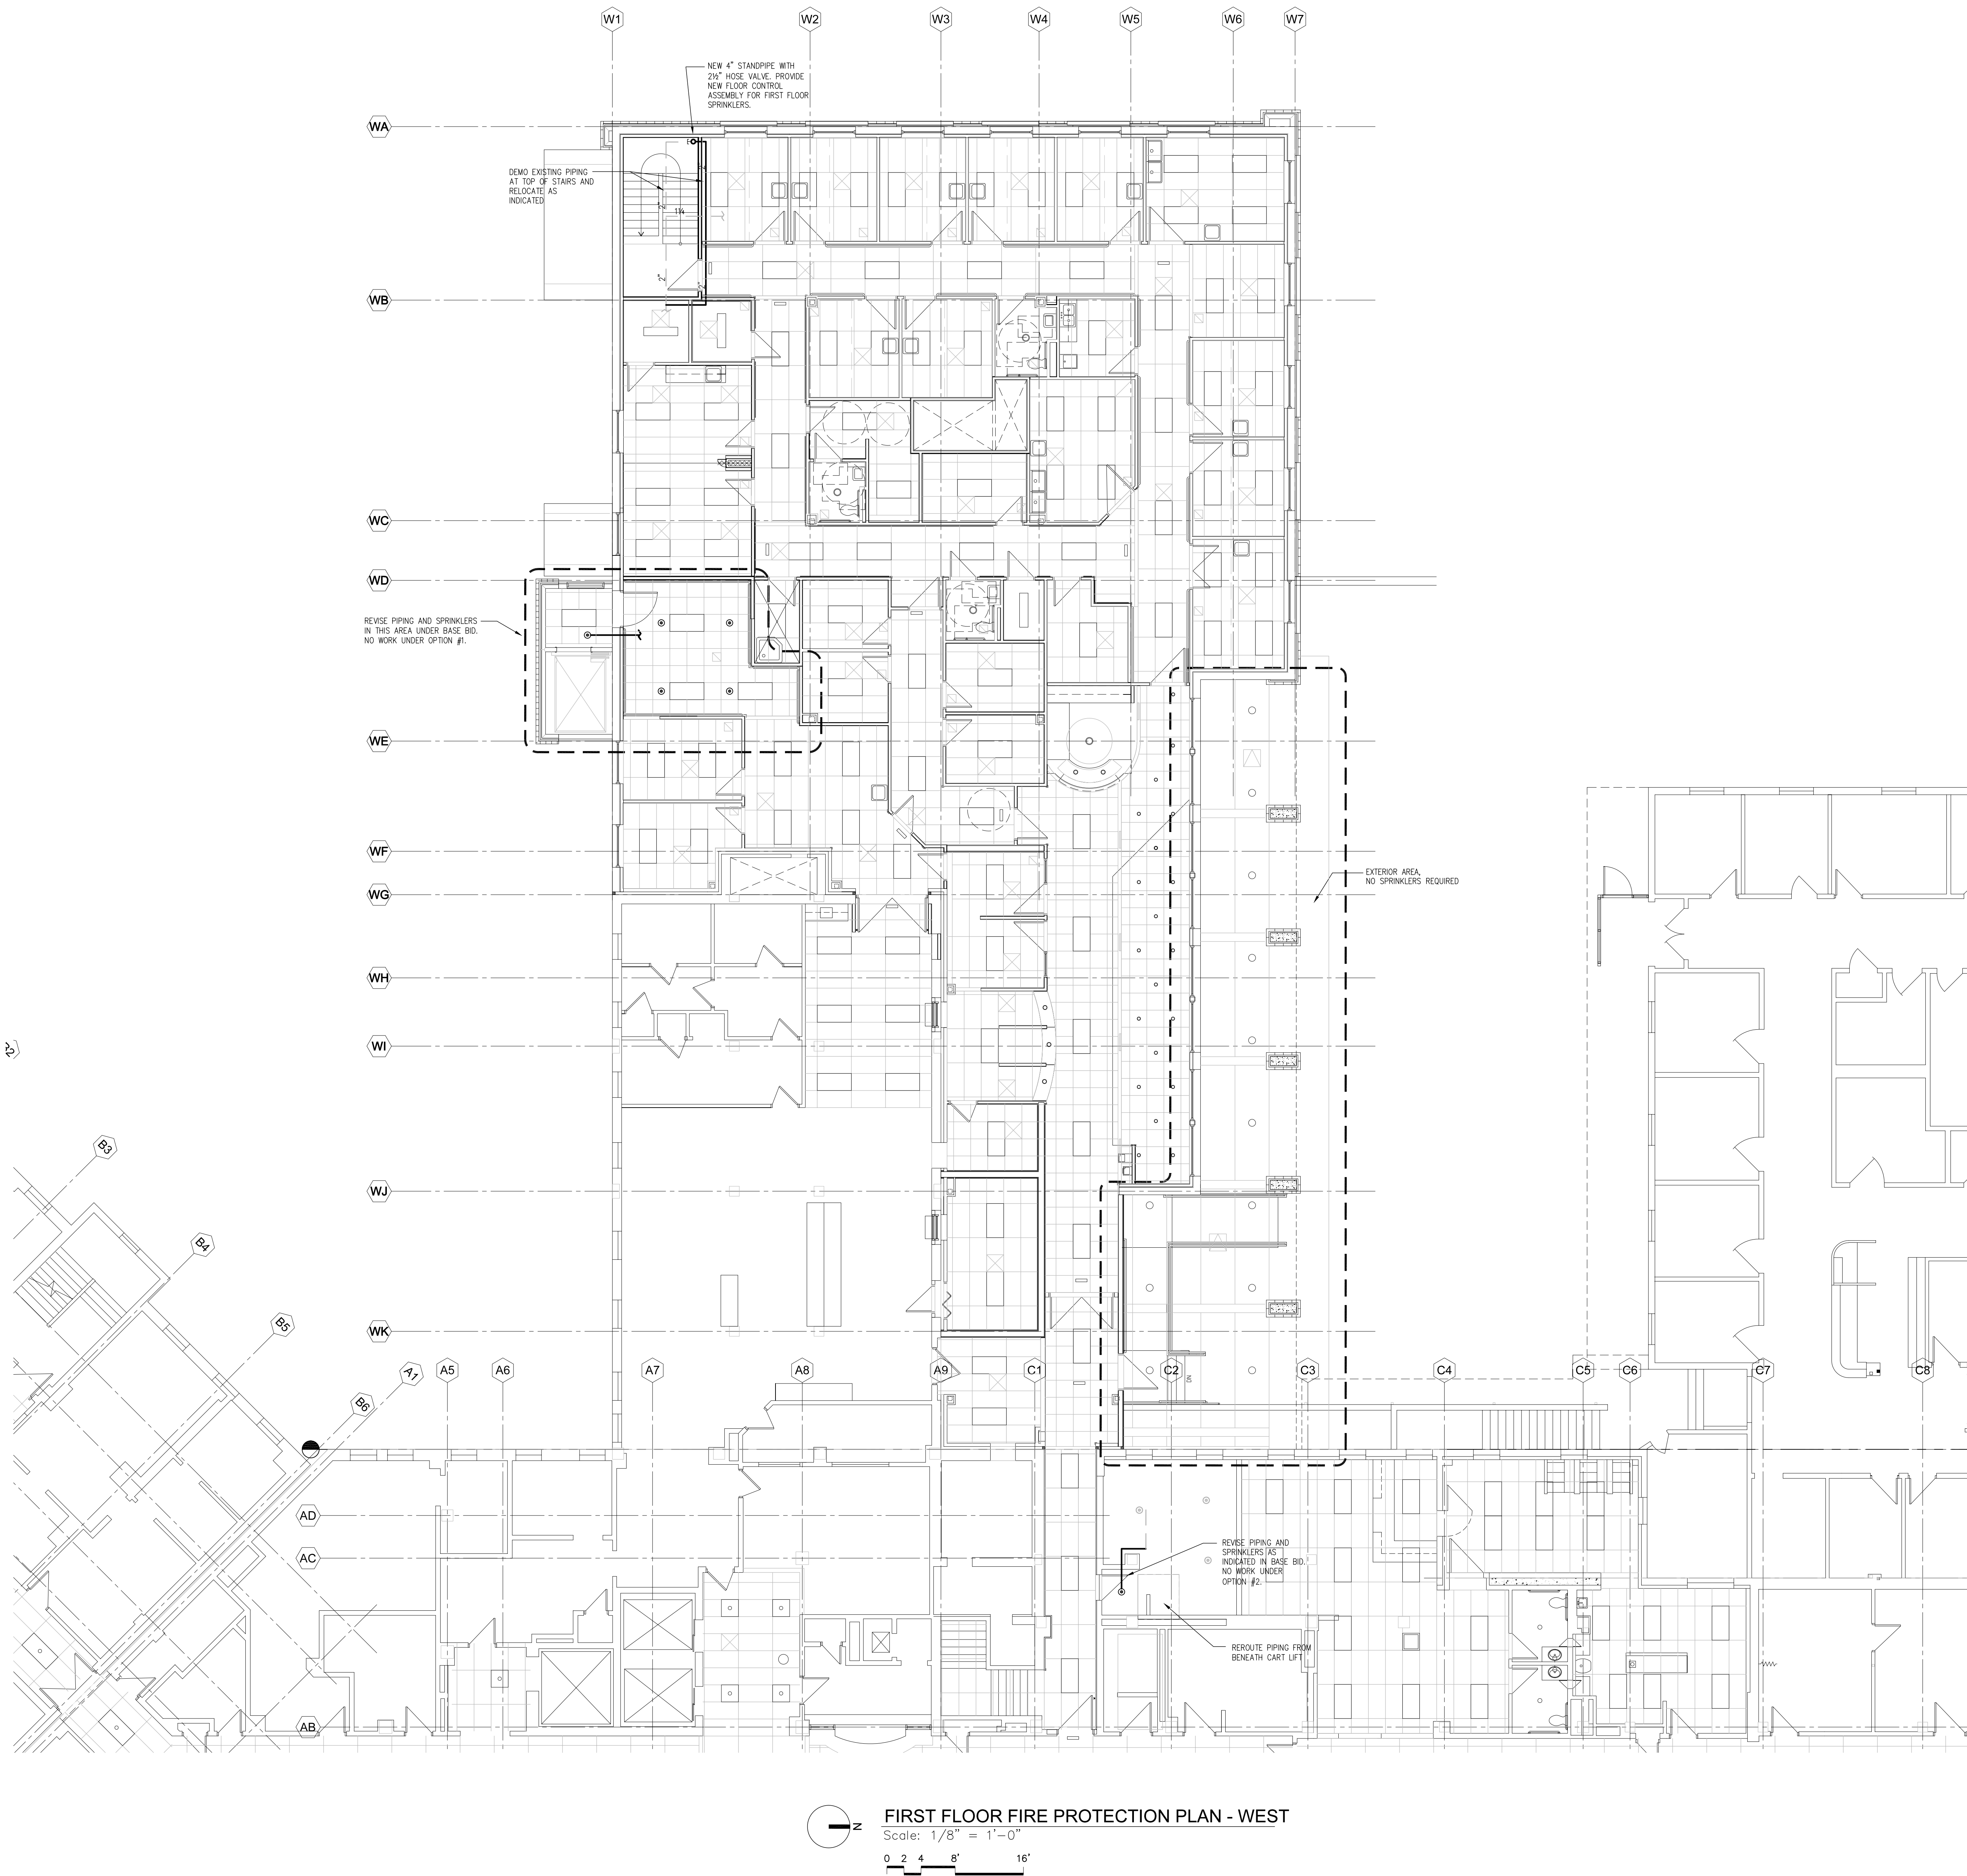

GENERAL NOTES


1. PROVIDE ALL SHOP DRAWINGS, SPRINKLERS, PIPE, FITTINGS, OFFSETS, HANGERS, EARTHQUAKE BRACING, DEVICES AND APPURTENANCES NECESSARY FOR A COMPLETE SYSTEM AS COORDINATED WITH ALL OTHER TRADES AND AS APPROVED BY THE AUTHORITY HAVING JURISDICTION.
2. ALL PIPING IS CONCEALED ABOVE CEILINGS, WHERE CEILINGS OCCUR, UNO.
3. SPRINKLERS IN 2X4 CEILING TILES SHALL BE LOCATED AT THE QUARTER POINTS OF THE TILE +/- 1". SPRINKLERS IN OTHER TYPES OF CEILINGS SHALL BE ALIGNED WITH OTHER CEILING ELEMENTS.

SPRINKLER LEGEND

- ⊙ = 1/2" OR PENDENT, WHITE RECESSED
 - = 1/2" OR BRASS UPRIGHT SPRINKLER
 - = 1/2" OR SIDEWALL, RECESSED, CHROME
- NOTE: ALL SPRINKLERS SHALL BE FM APPROVED

KEY NOTES

- ① UNDER BASE BID, REROUTE EXISTING PIPING AROUND NEW CART LIFT AS NECESSARY. NO WORK IF BID OPTION 2 IS TAKEN.
- ② WORK SHOWN IN THIS AREA IS UNDER BASE BID. ARRANGEMENTS WILL DIFFER SLIGHTLY IF BID OPTION 4 IS TAKEN.

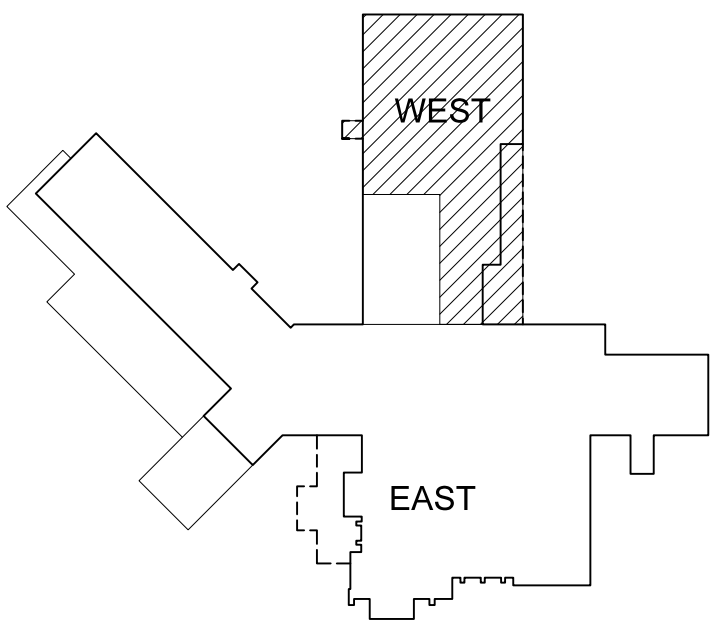

KEY PLAN
NOT TO SCALE

NAC | ARCHITECTURE

DEPARTMENT OF VETERANS AFFAIRS
MEDICAL CENTER

CONSTRUCT ENDOSCOPY &
CENTRAL PROCESSING ADDITION,
VAMC SPOKANE
PROJECT NUMBER
668-309
SHEET TITLE
1ST FLOOR FIRE PROTECTION PLAN - WEST



DESIGN GWS
DRAWN GWS
APPROVED GWS
DATE 1-19-2012
FILE NO.
NAC# 111-10028

SHEET NO.
**FP
103**
SHEET 149 OF 199

1203 N RIVERSIDE AVE | SPOKANE, WA 99201-1107 | P: 509.338.8240 | F: 509.338.8261



GENERAL NOTES


1. PROVIDE ALL SHOP DRAWINGS, SPRINKLERS, PIPE, FITTINGS, OFFSETS, HANGERS, EARTHQUAKE BRACING, DEVICES AND APPURTENANCES NECESSARY FOR A COMPLETE SYSTEM AS COORDINATED WITH ALL OTHER TRADES AND AS APPROVED BY THE AUTHORITY HAVING JURISDICTION.
2. ALL PIPING IS CONCEALED ABOVE CEILINGS, WHERE CEILINGS OCCUR, UNO.
3. SPRINKLERS IN 2X4 CEILING TILES SHALL BE LOCATED AT THE QUARTER POINTS OF THE TILE +/- 1". SPRINKLERS IN OTHER TYPES OF CEILINGS SHALL BE ALIGNED WITH OTHER CEILING ELEMENTS.

SPRINKLER LEGEND

- ⊙ = 1/2" OR PENDENT, WHITE RECESSED
○ = 1/2" OR BRASS UPRIGHT SPRINKLER
▶ = 1/2" OR SIDEWALL, RECESSED, CHROME
NOTE: ALL SPRINKLERS SHALL BE FM APPROVED


KEY NOTES

- ① UNDER BASE BID, REROUTE EXISTING PIPING AROUND NEW CART LIFT AS NECESSARY. NO WORK IF BID OPTION 2 IS TAKEN.
- ② WORK SHOWN IN THIS AREA IS UNDER BASE BID. ARRANGEMENTS WILL DIFFER SLIGHTLY IF BID OPTION 4 IS TAKEN.

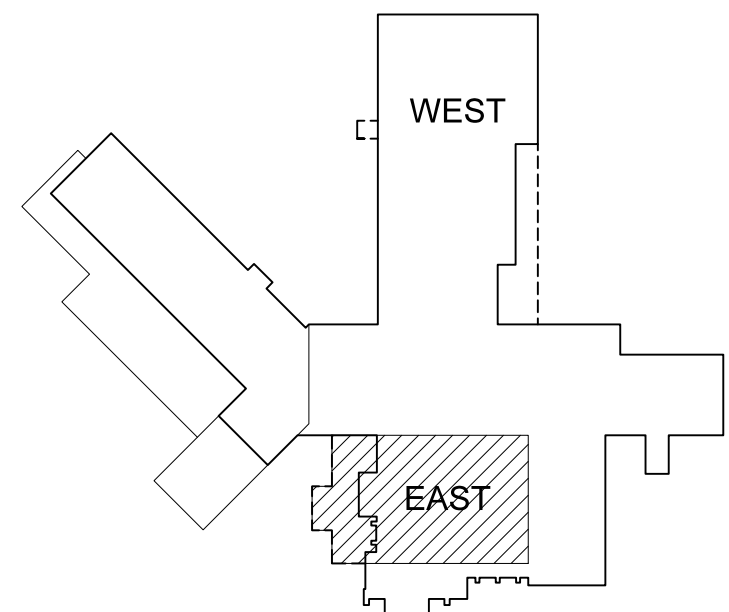

DEPARTMENT OF VETERANS AFFAIRS
MEDICAL CENTER

CONSTRUCT ENDOSCOPY &
CENTRAL PROCESSING ADDITION,
VAMC SPOKANE
PROJECT NUMBER
668-309
SHEET TITLE
2ND FLOOR FIRE PROTECTION PLAN - EAST

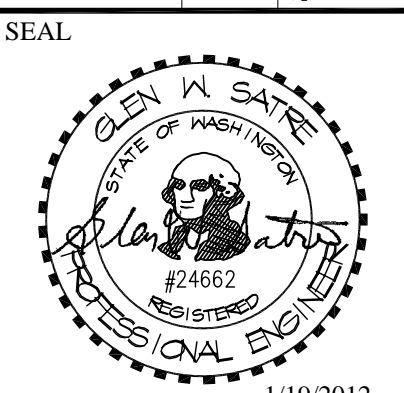


DESIGN	GWS
DRAWN	GWS
APPROVED	GWS
DATE	1-19-2012
FILE NO.	NAC# 111-10028


SHEET NO.
FP 104
SHEET 150 OF 199


NAC ARCHITECTURE


1203 W RIVERSIDE AVE SPOKANE WA 99201-1107 P: 509.338.8240 F: 509.338.8261

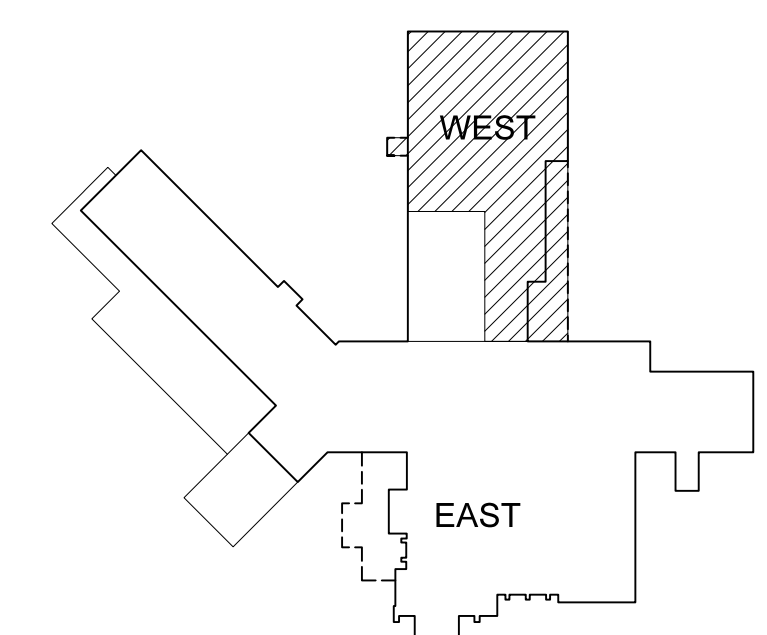


 **KEY PLAN**
NOT TO SCALE XKEYPLAN

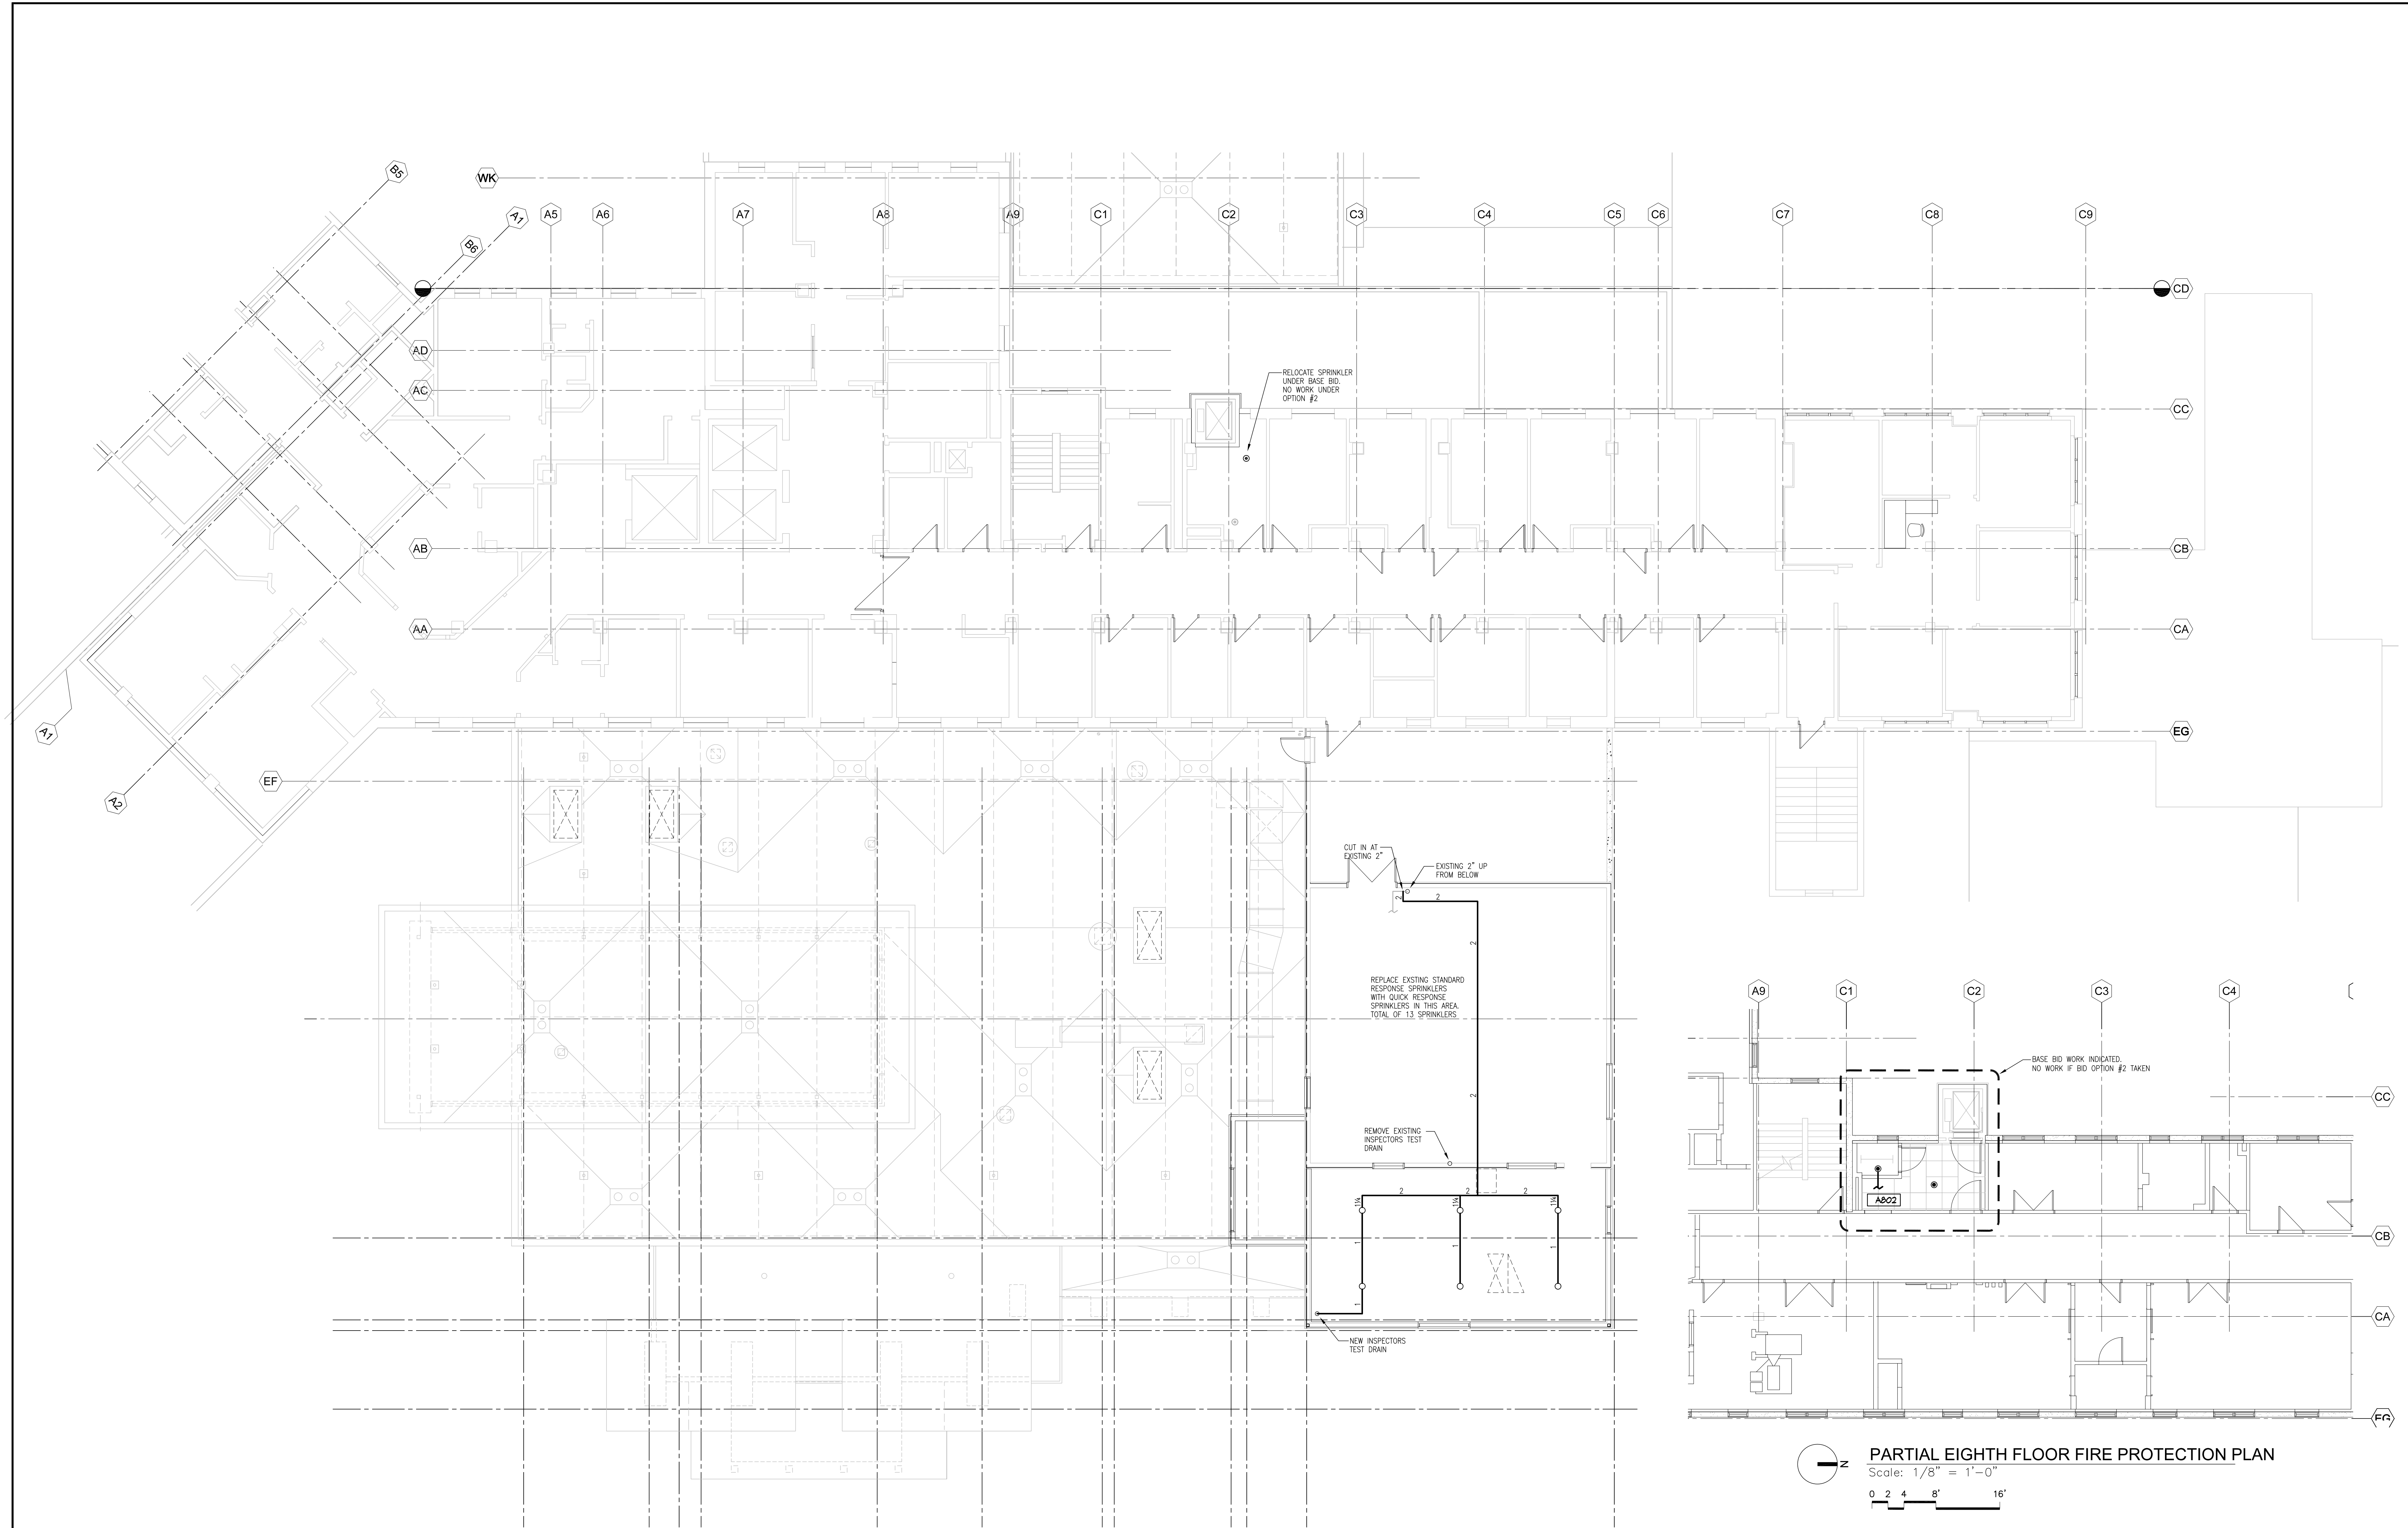

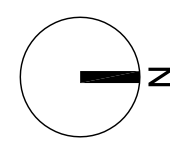
 **THIRD FLOOR FIRE PROTECTION PLAN - EAST**
Scale: 1/8" = 1'-0"
0 2 4 8' 16'

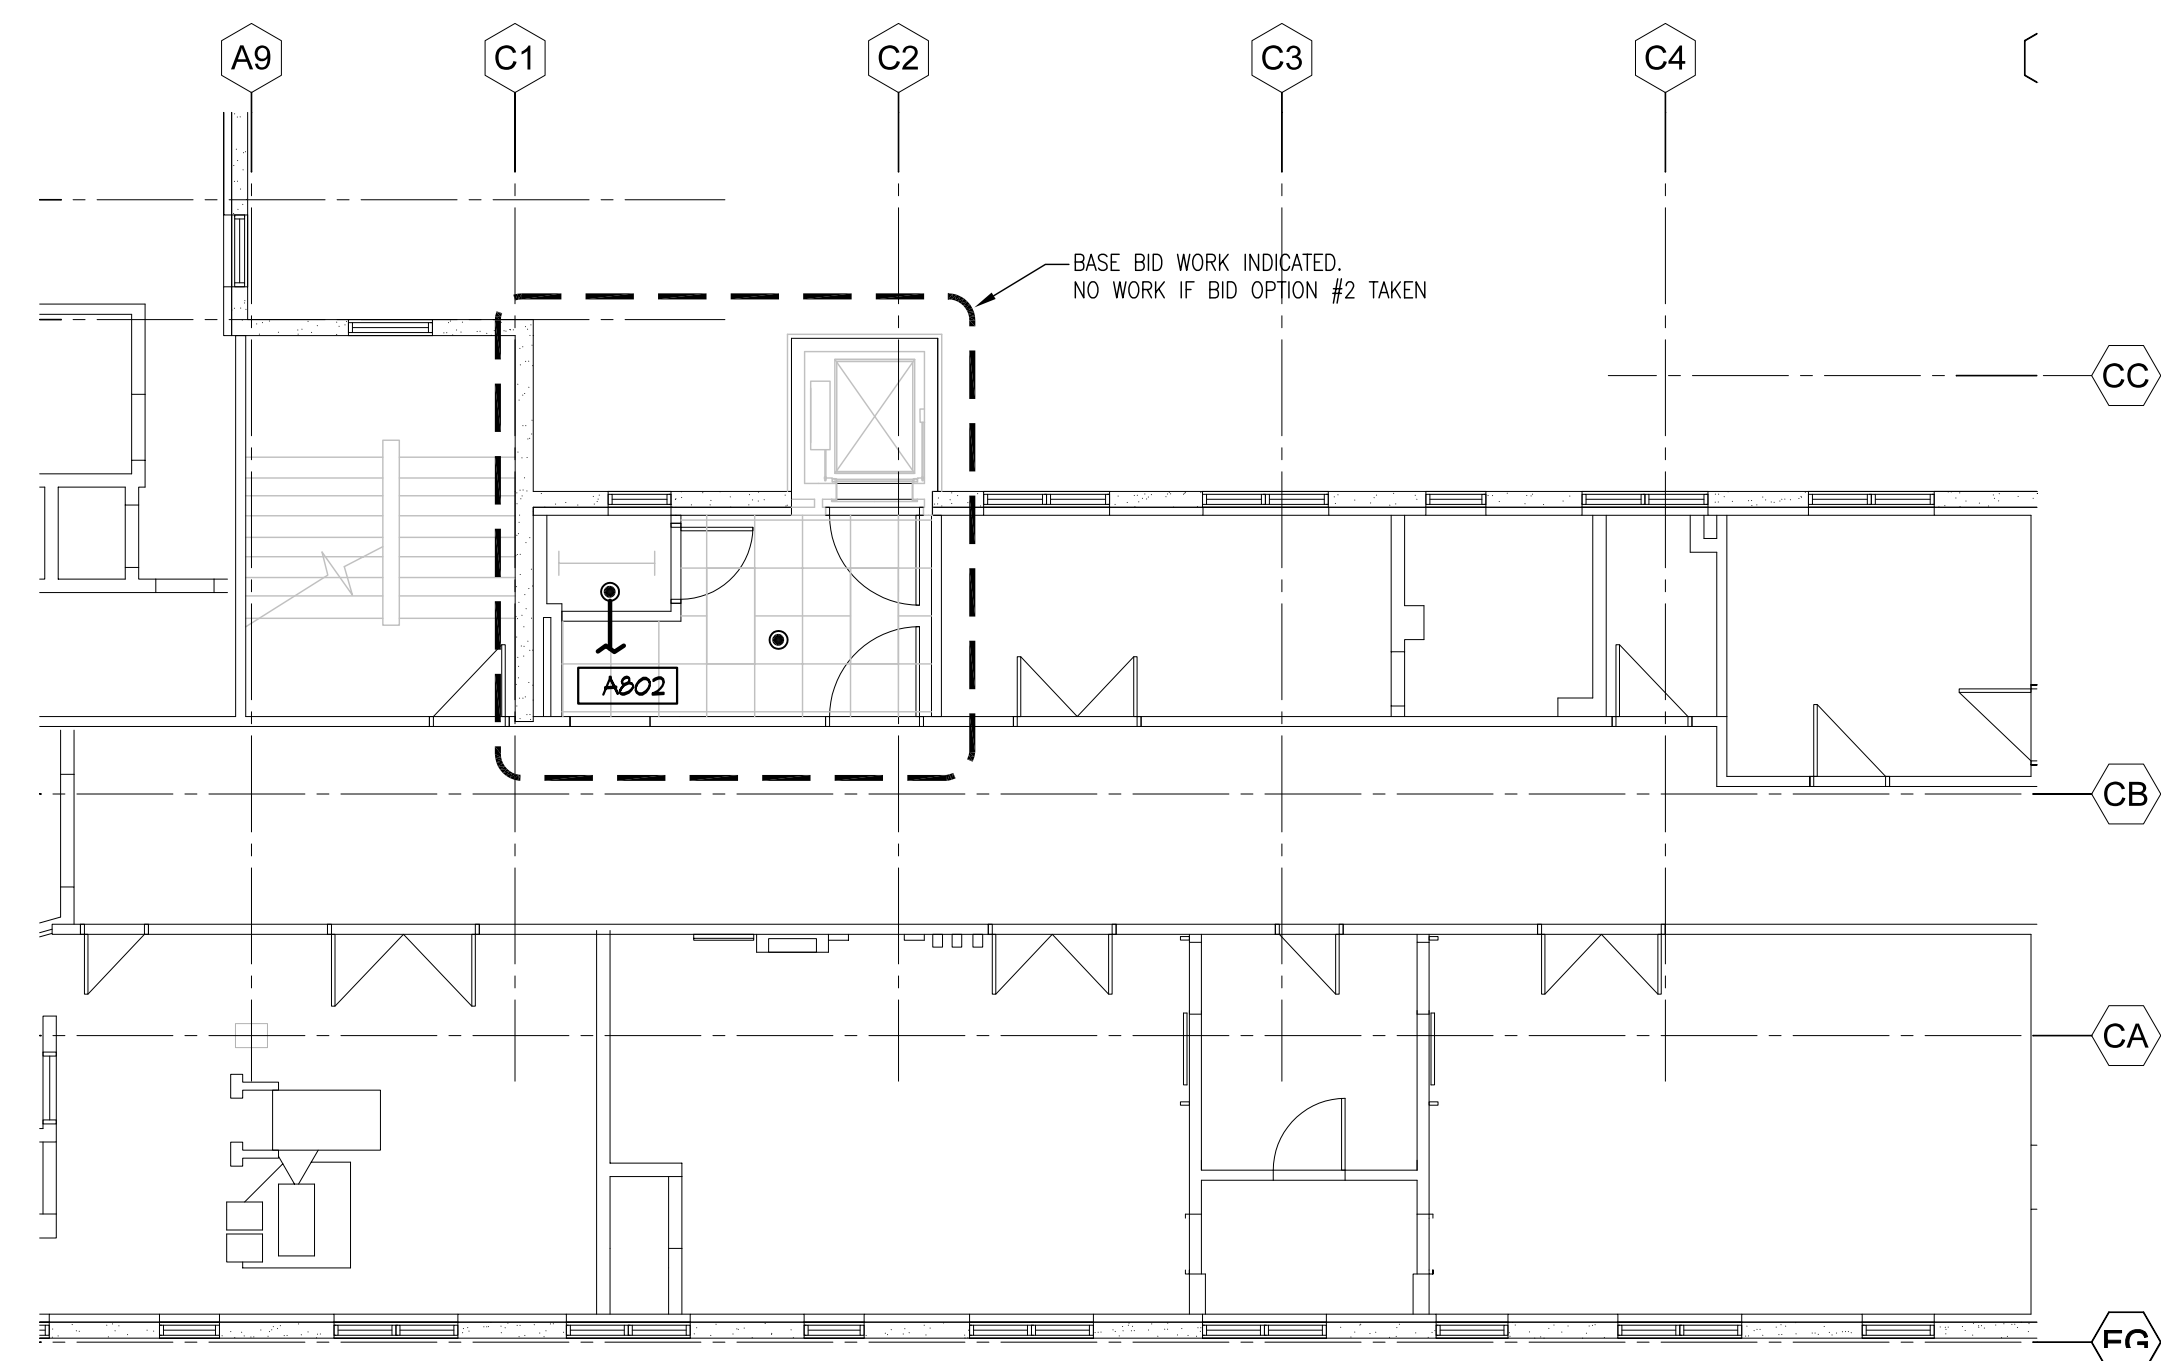

 **PARTIAL EIGHTH FLOOR FIRE PROTECTION PLAN**
Scale: 1/8" = 1'-0"
0 2 4 8' 16'

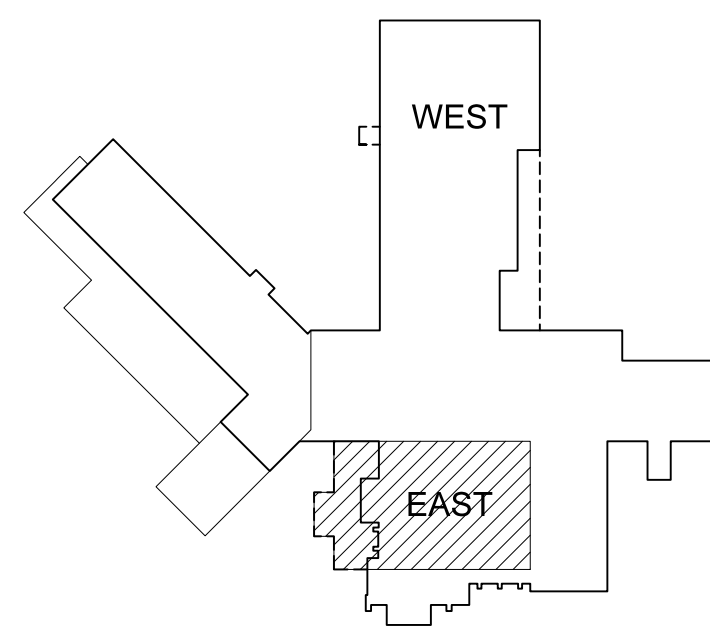

 **KEY PLAN**
NOT TO SCALE XKEYPLAN

NAC ARCHITECTURE 1203 W RIVERSIDE AVE SPOKANE, WA 99201-1107 P: 509.338.8240 F: 509.338.8261	
DEPARTMENT OF VETERANS AFFAIRS MEDICAL CENTER	
DEPARTMENT OF ENGINEERING OPERATIONS SPOKANE, WA 99205-6197 MAIN OFFICE: 509-434-7900	
CONSTRUCT ENDOSCOPY & CENTRAL PROCESSING ADDITION, VAMC SPOKANE PROJECT NUMBER 668-309	
SHEET TITLE 3RD AND 8TH FLOORS FIRE PROT. PLANS	
SEAL  1/19/2012	
DESIGN	GWS
DRAWN	GWS
APPROVED	GWS
DATE	1-19-2012
FILE NO.	NAC# 111-10028
SHEET NO.	FP 106
SHEET 152 OF 199	