



BUILDING INDEX	
No.	BUILDING
1	ETSU MED. SCHOOL, VA
2	VA OFFICE/EDUCATION (CONST.)
3	VA MED. LAB (CONST.)
4	VA RESEARCH LAB (CONST.)
5	VA RESEARCH LAB (FUTURE)
6	ETSU RESEARCH LAB (FUTURE)
7	ETSU RESEARCH LAB (FUTURE)
8	EYE CLINICS, AMM. SVC./ FISCAL
10	BANDSTAND
13	CHAPEL
15	HOSPITAL GUEST HOUSE (LEASED)
16	SINGLE QTRS. (LEASED)
17	SINGLE QTRS. (LEASED)
18	SINGLE QTRS. (LEASED)
20	HUMAN RESOURCE MGT.
34	MUSEUM/ETSU LABS/BOOKSTORE
35	ENGSHOF'S/CAVIEEN
36	MEMORIAL HALL, THEATER
37	PSYCH. BLDG.
39	DUPLEX QUARTERS
40	RESIDENT ENGINEERS
41	FM ADMIN. OFFICES
42	FM PLANNING/DESIGN
43	(VACANT)
44	SINGLE QUARTERS
45	SINGLE QUARTERS
46	SINGLE QUARTERS
47	SINGLE QUARTERS
52	ETSU MED. SCHOOL
53	U.S. POST OFFICE
60	ETSU (VACANT)
69	HOSPITAL ADMIN. BLDG.
77	CLINICAL SUPPORT BLDG.
83	4-CAR GARAGE
85	2-CAR GARAGE
96	FLAGPOLE
98	3-CAR GARAGE
99	2-CAR GARAGE
100	WATER TOWER/VALVE HOUSE
107	WATER TOWER
108	MHEC BOILER PLANT
115	MAIN ELECT. SWITCHGEAR
116	EMER. GEN. BLDG.
117	NAT'L. CEMETERY ADMIN.
118	NAT'L. CEMETERY STOR.
119	ETSU MED. SCHOOL LAB BLDG.
120	EMER. GEN. BLDG.1,4,119
160	DOMICILIARY/PRIMARY CARE
161	EMER. GEN BLDG.160
162	NHCU
178	ETSU RESEARCH BLDG.
200	HOSPITAL
201	FM MAINT.
204	OUT-PATIENT CLINIC/ER
206	LAUNDRY/WAREHOUSE
208	GROUNDKEEPING FACILITY
209	MHEC CO-GEN ENERGY CTR
209	MHEC THERMAL STOR. TANK

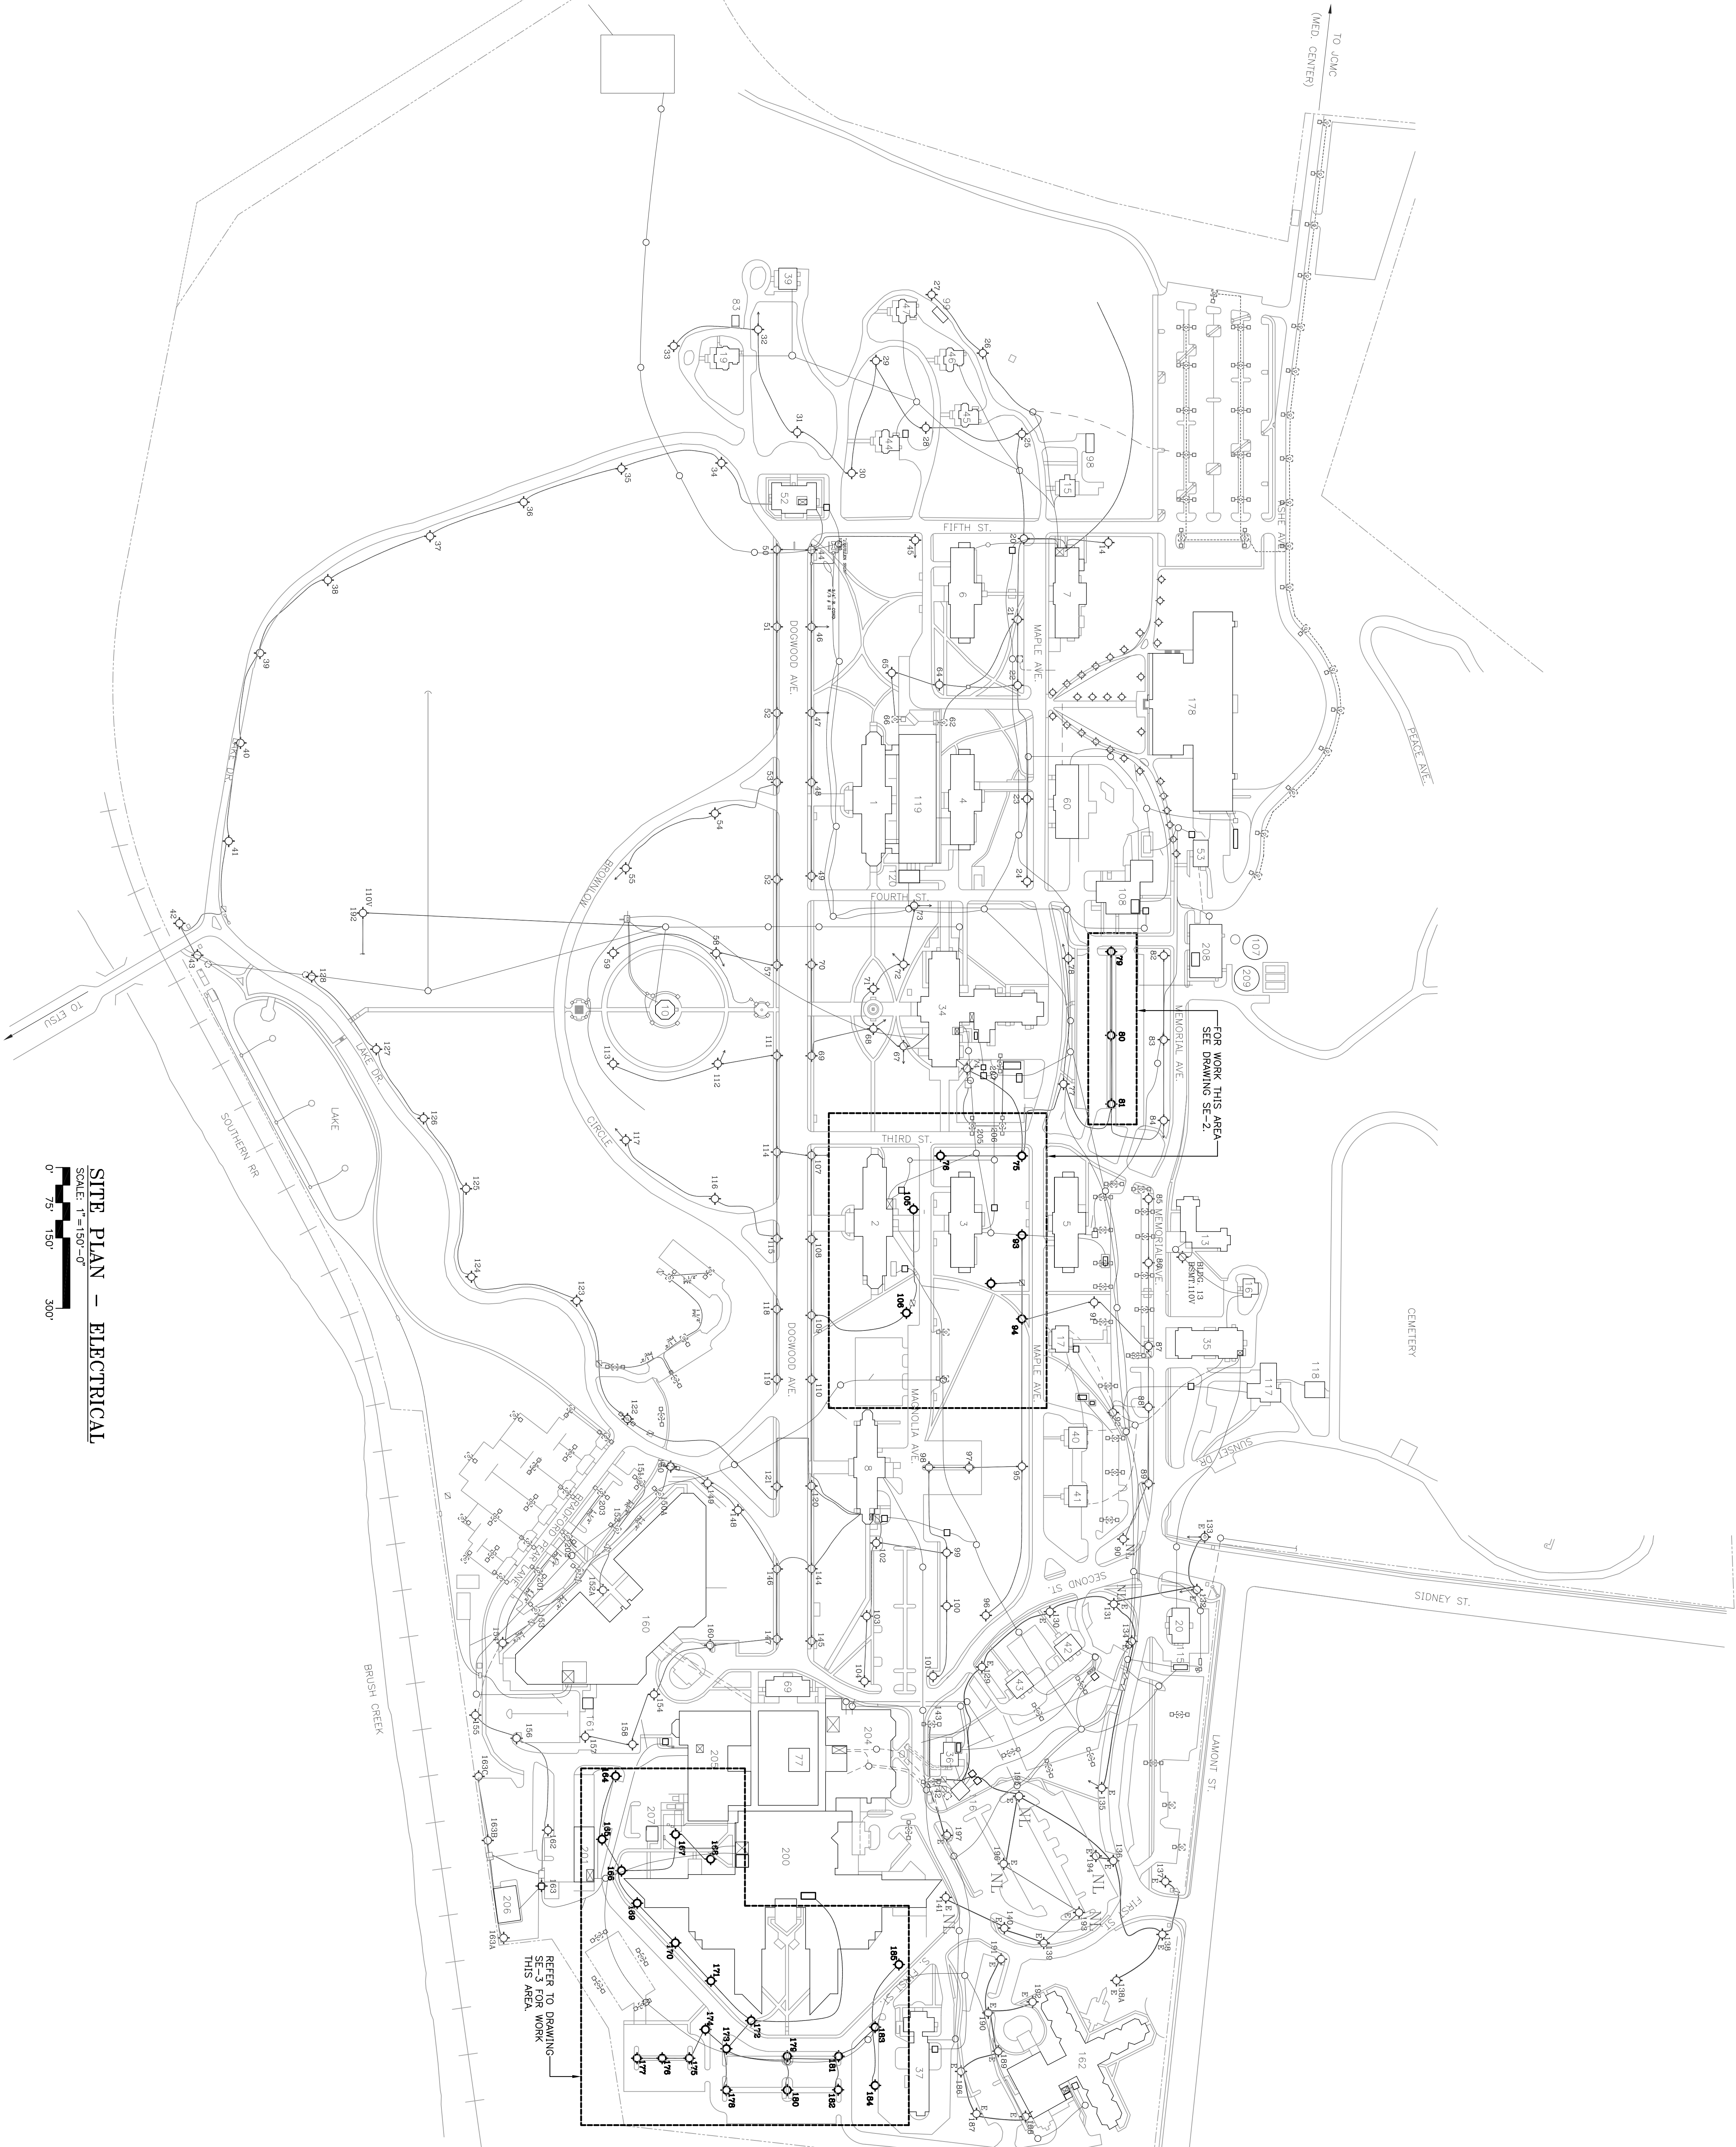

SE-1 - VA Replacement Site Lighting - Site Plan - Electrical.dwg
M.L.H. 07/15/08 4:03 PM CL6143(CL)

Revisions

Date

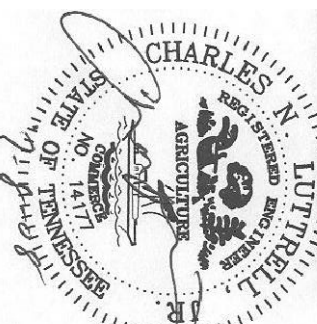

Vreeland Engineers Inc.

Site: 1000 S. Main St., P.O. Box 10048, Knoxville, TN 37931
Tel: (606) 627-4448
Fax: (606) 627-4448
www.vreelandengineers.com

Drawing Title

Project Title

Date

SITE PLAN - ELECTRICAL

VETERANS ADMINISTRATION
REPLACEMENT SITE LIGHTING

JULY 8, 2008

Approved: Chief Engineering Svc.
Daniel B. Snyder III, P.E. MBA

Building Number

Project No.

SITE PLAN

CL

621-07-126

Approved: Asst. Chief Engineering Svc.
Kevin Miliken

Location

Dwg. 2 of 6

SE-1

Veteran's Administration