




B1 NORTH ELEVATION SCOPE STERILIZATION ROOM
3/8" – 1'-0"

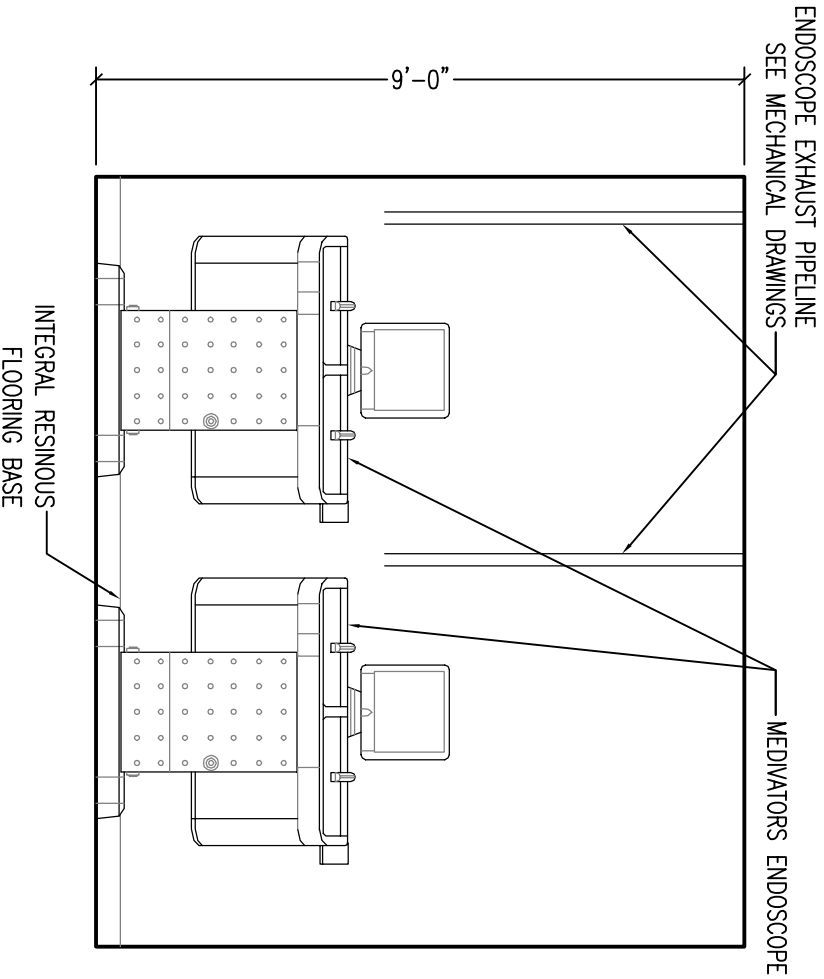


B3 SOUTH ELEVATION SCOPE STERILIZATION ROOM
3/8" – 1'-0"

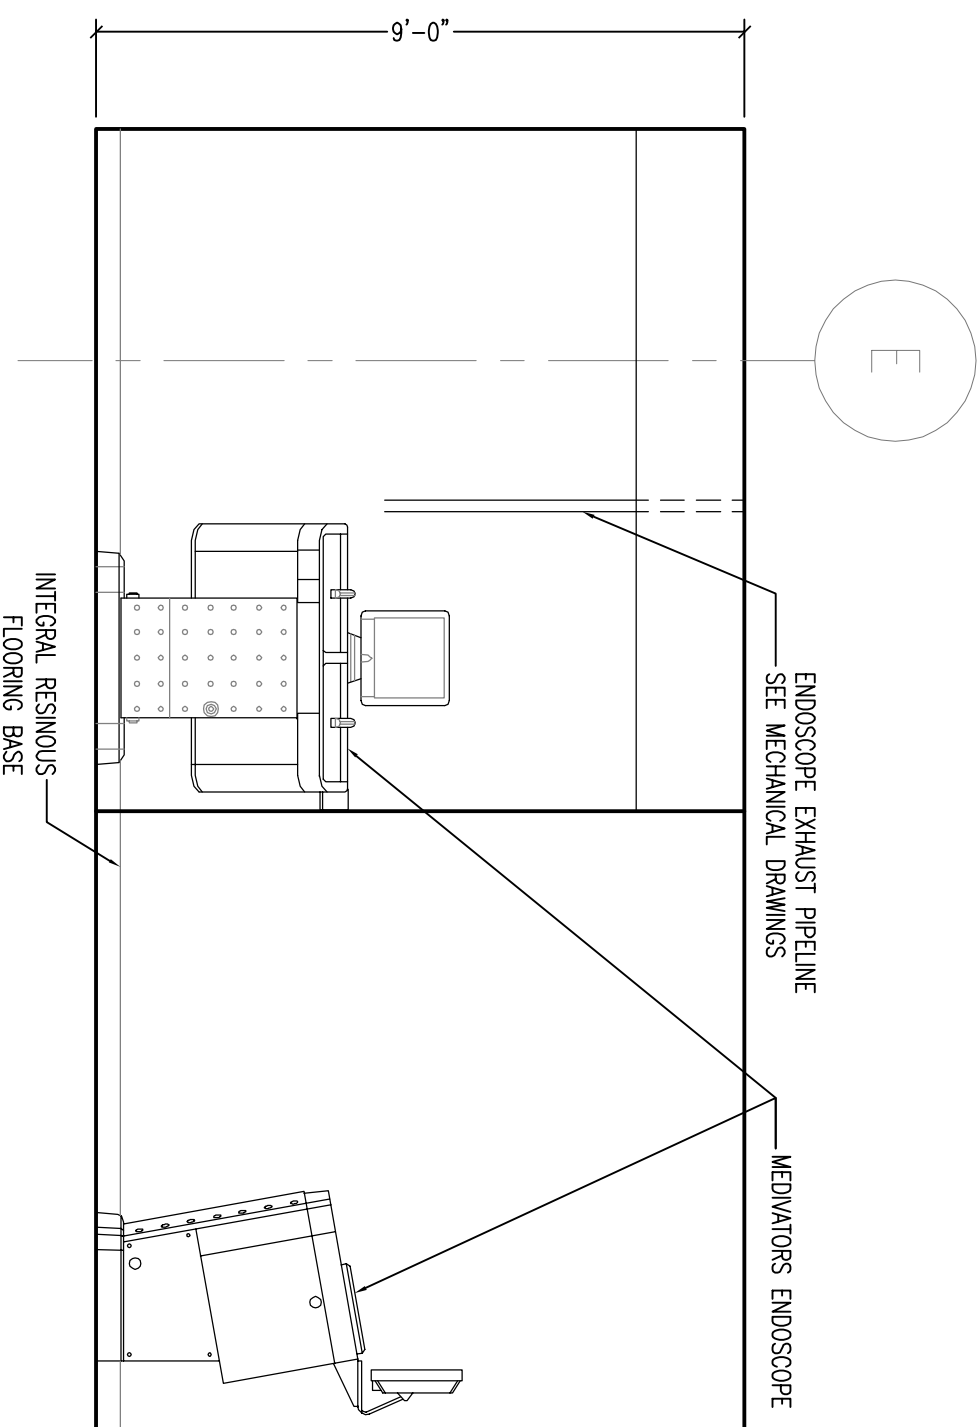


B6 EAST ELEVATION SCOPE STERILIZATION ROOM
3/8" – 1'-0"

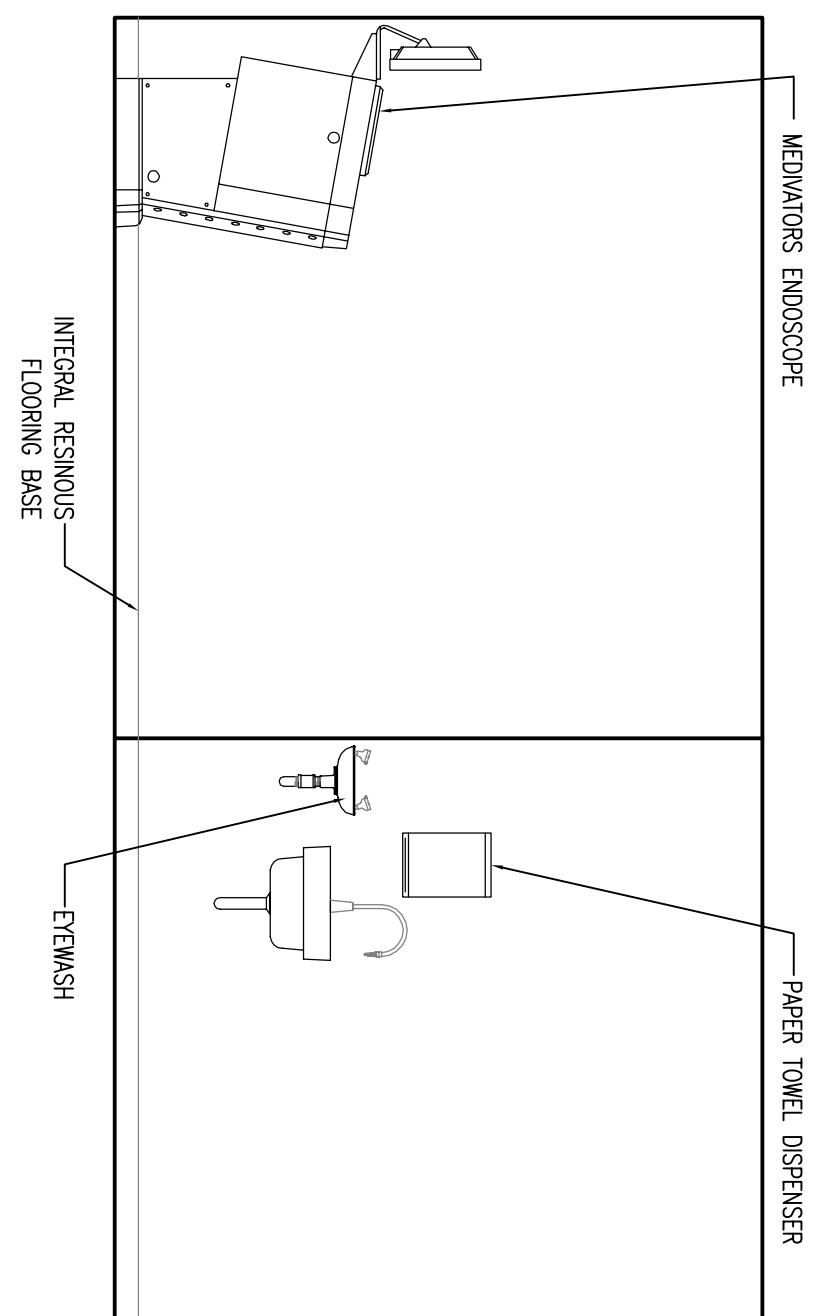


C1 WEST ELEVATION SCOPE STERILIZATION ROOM
3/8" – 1'-0"

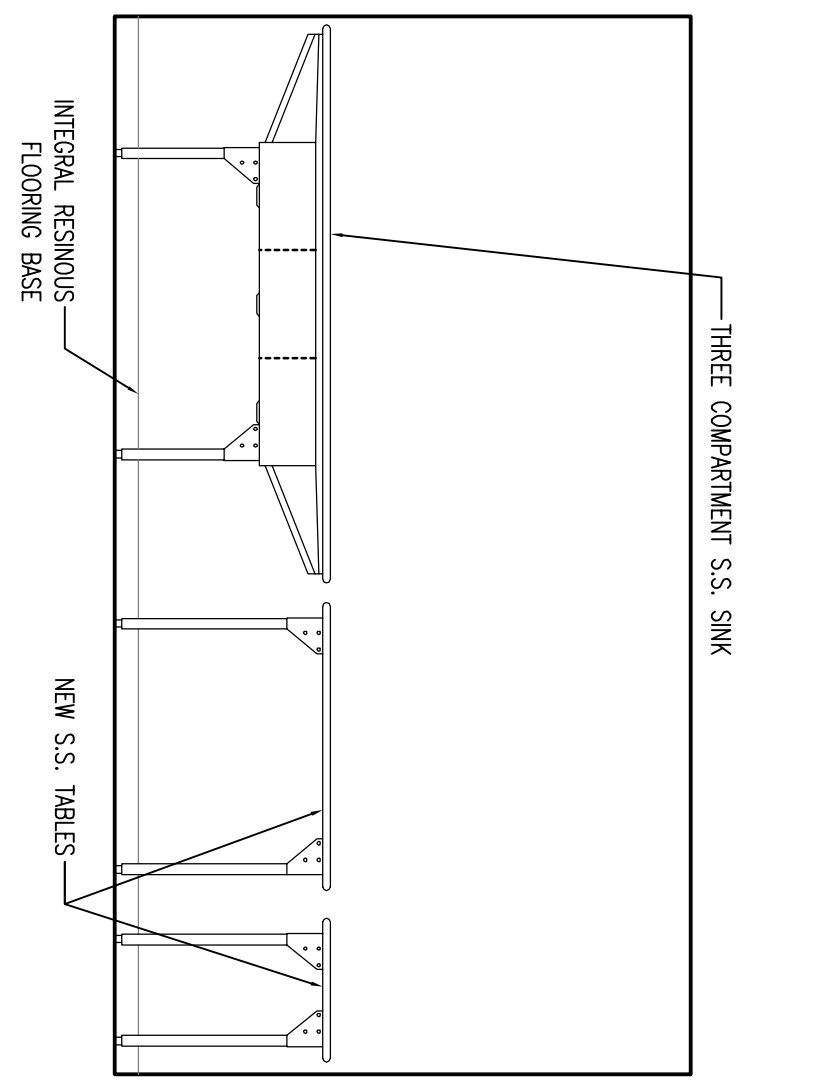


C3 NORTH ELEVATION SCOPE CLEANING ROOM
3/8" – 1'-0"

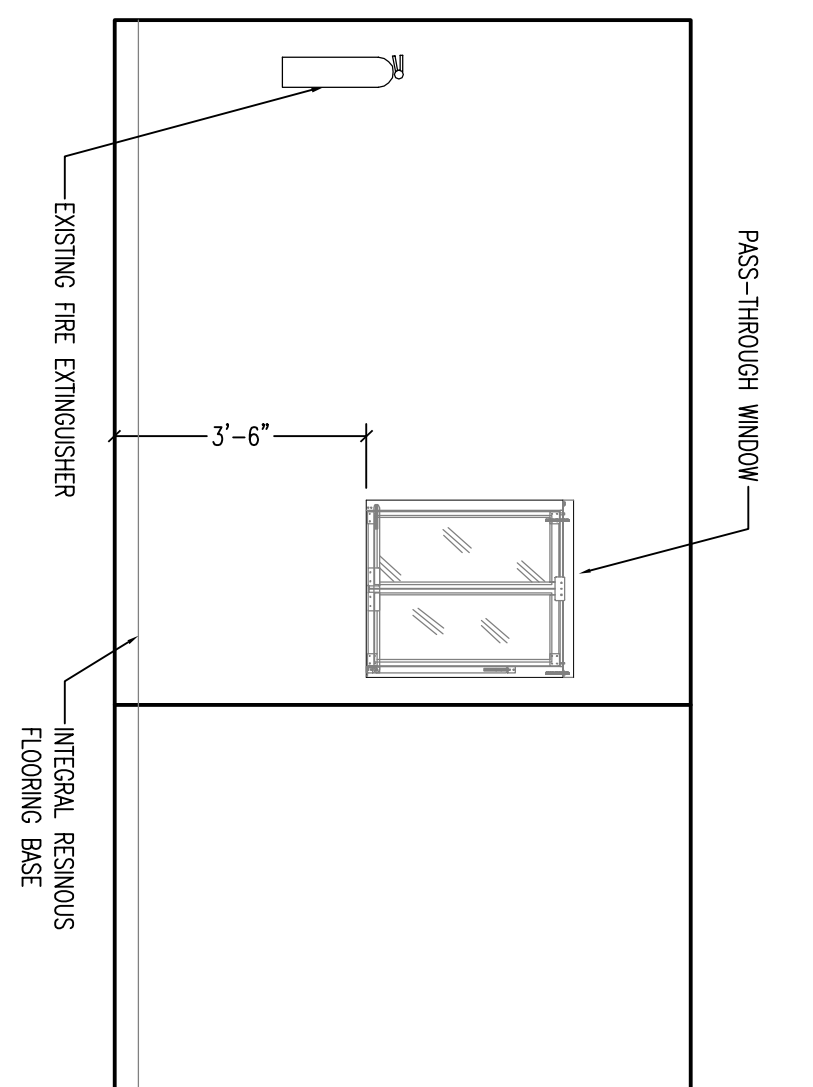

C6 SOUTH ELEVATION SCOPE CLEANING ROOM
3/8" – 1'-0"

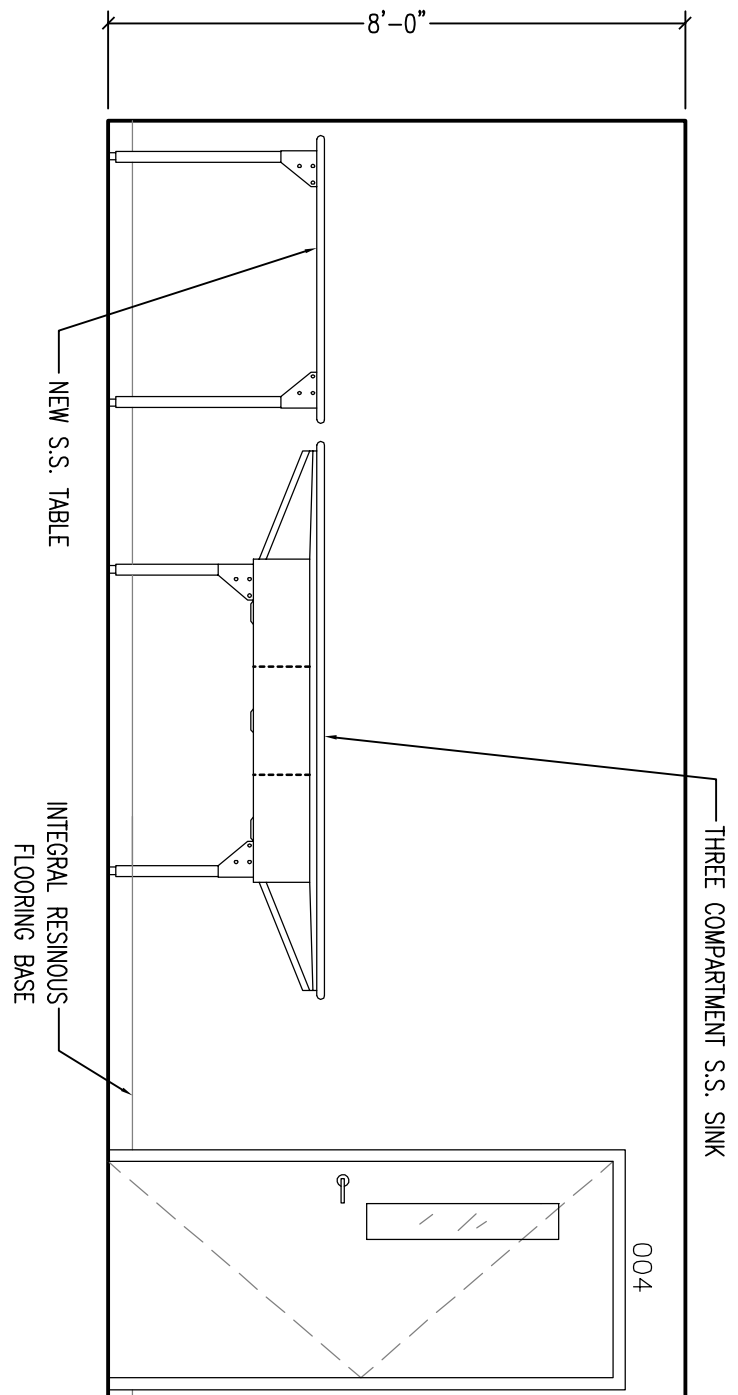

E1 EAST ELEVATION SCOPE CLEANING ROOM
3/8" – 1'-0"

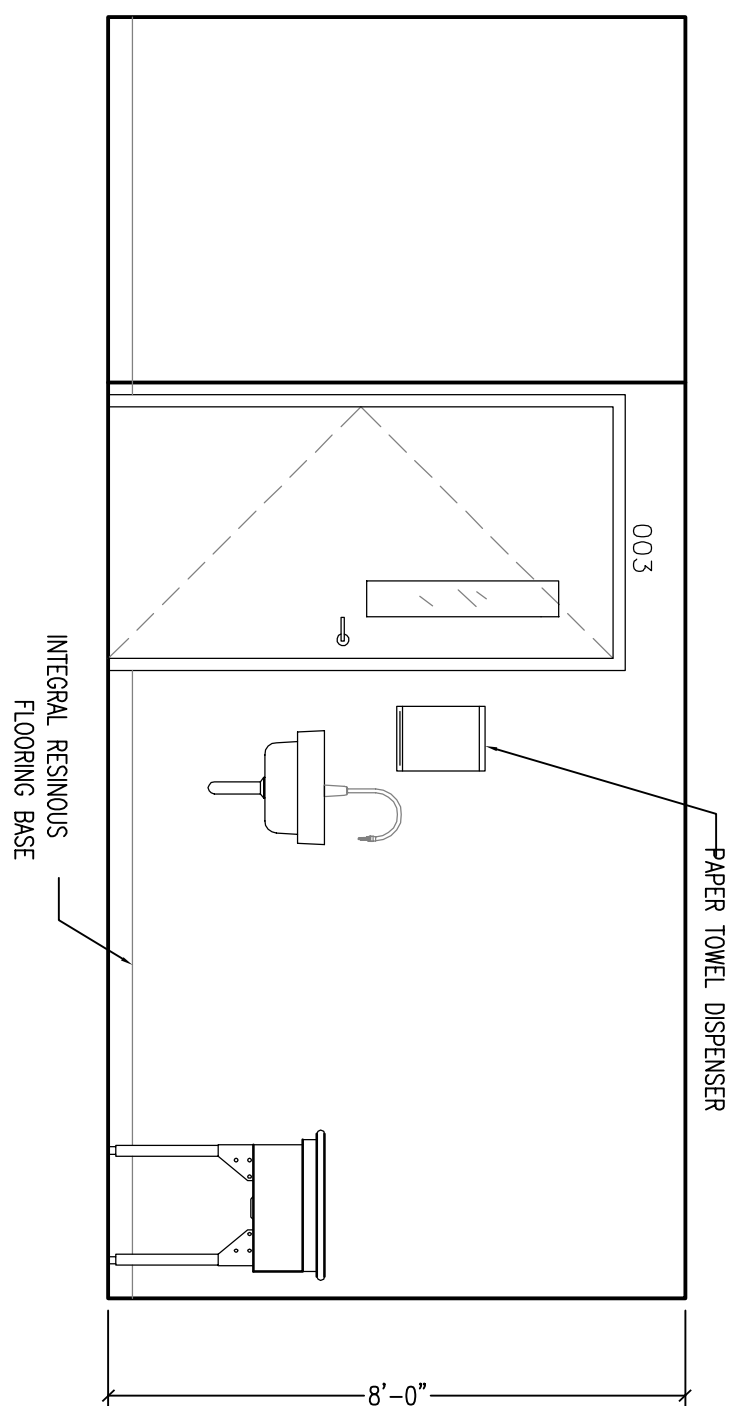

E3 WEST ELEVATION SCOPE CLEANING ROOM
3/8" – 1'-0"

GENERAL NOTES:

SHEET NOTES:

LEGEND:

	DEMO WALL
	CMU INFILL
	NEW GYP. WALL
	TEMPORARY CONSTRUCTION BARRIER
	LIGHT FIXTURE
	SUPPLY DIFFUSERS
	EXHAUST DIFFUSERS
	ACCESS PANEL
	SPRINKLER HEAD (CEILING MOUNTED)
	SMOKE DETECTOR (CEILING MOUNTED)
	FLOOR DRAIN
	PARTITION TYPE

100% ISSUED FOR CONSTRUCTION
COMPLETION ITEM NO. 3
FULLY SPRINKLERED

Revisions	Date

Dept. of Veterans Affairs
Medical Center
1670 Clairmont Road
Decatur, Georgia 30033

PROFESSIONAL SEAL

ARCHITECT/ENGINEERS:
VETERAN ENGINEERING GROUP, INC.
4411 Suwanee Dam, Ste 230 Suwanee, GA, 30024
ARCHITECTURE ENGINEERING PLANNING
1123 Zonolite Road, Suite 25, Atlanta, GA 30306

Drawing Title
ARCHITECTURAL
INTERIOR ELEVATIONS

Project Title
RENOVATION OF EXISTING
STERILE PROCESSING SERVICE (SPS)

Project Number
509-10-113
Building Number
1
Drawing Number
AS201
Dwg. 8 of 27

Office of
Facilities
Management
Department of
Veterans Affairs