

**GENERAL SHEET NOTES**

A. EMERGENCY EGRESS LIGHTING FIXTURES SHALL BE UNINTERRUPTED WITH EXCEPTION OF FIXTURES MOUNTED UNDER EXTERIOR CANOPIES.

B. UTILIZE SCENE PREPARATORS CREATED WITH BRANCH CIRCUITS REMOVED IN DEMOLITION FOR NEWLY ASSIGNED CIRCUITS.

**SHEET KEYNOTES**

01. LIGHTING WORK IN EXISTING ELECTRICAL ROOM OR IT CLOSET SHALL REMAIN EXISTING CIRCUIT.

02. SEE DIMENSION ON PLAN E-501 FOR WIRING OF TWO LEVEL LIGHTING WITH OCCUPANCY IN SAME AREA.

03. CONTROL EXTERIOR LED EGRESS LIGHTING FROM PHOTO CONTROL MOUNTED ON ROOF, FACING NORTH, VERY EXACT FUTURE MOUNTING HEIGHT WITH ARCHITECTURAL ELEVATIONS PRIOR TO ROUGH-IN.

04. SWITCH IN WEATHERTIGHT ENCLOSURE SHALL BE MOUNTED ON FIXED STRUCTURE.

05. INTENSITY CONTROL FOR PROCEDURE LIGHT, 60" AFF, VERIFY EXACT LOCATION AND INSTALLATION REQUIREMENTS WITH OWNER AND EQUIPMENT VENDOR PRIOR TO ROUGH-IN. ELECTRICAL CONTRACTOR SHALL MAKE ALL FINAL CONNECTIONS.

**COORDINATION DRAWINGS**

THE MECHANICAL CONTRACTOR SHALL TAKE THE LEAD IN PREPARATION OF COORDINATION DRAWINGS. SUCH DRAWINGS SHALL BE PREPARED AND DESIGNED THROUGHOUT AND FROM COORDINATION WITH ALL OTHER MAJOR AND MINOR SUBCONTRACTORS AND THE GENERAL CONTRACTOR. ALL COORDINATION DRAWINGS SHALL BE SUBMITTED TO THE ARCHITECT FOR REVIEW AND APPROVAL. ALL NEW WORK WITH EXISTING CONDITIONS SHALL BE TO SCALE (AT NOT LESS THAN 3/8" = 1'-0"). DRAWINGS SHALL SHOW, BUT NOT BE LIMITED TO: ALL WALL PARTITIONS, ALL DUCTWORK, ALL AIR DISTRIBUTION, MECHANICAL EQUIPMENT, MECHANICAL PIPING, FIRE PROTECTION PIPING, ALL PLUMBING PIPING, CABLE TRAYS AND CEILING HEIGHT, MAJOR BEAMS AND JOISTS WITH ELEVATIONS MARKED, FIRE AND ALARM DEVICES AND SPEAKERS (WHERE CEILING MOUNTED), ELECTRICAL CONDUITS, LARGER THAN 2-INCH DIAMETER, ELECTRICAL BUNDLES AND REQUIRED CLEARANCES, THE LOCATION OR ACCESS TO ABOVE CEILING PIPING, DUCTWORK OF OTHER EQUIPMENT SECTIONS SHALL BE CUT THROUGH AREAS SHOWING MATERIALS AND SYSTEMS OF ALL CONTRACTS. IF THERE ARE ANY OUTSTANDING ISSUES THAT CANNOT BE RESOLVED, CONSULT WITH THE ARCHITECT AND/OR ENGINEER (THROUGH THE VA COTR) FOR IMPORTANT TO NOTE THAT FABRICATION CANNOT BEGIN UNTIL COORDINATION DRAWINGS HAVE BEEN APPROVED. ANY MATERIAL, EQUIPMENT, SYSTEMS, ETC., PROCEDURE OR INSTALLATION COMMENCED PRIOR TO APPROVAL IS TAKEN AT THE CONTRACTOR'S OWN RISK AND SHALL BE MODIFIED, MOVED AND/OR RECOMMENDED AT THE CONTRACTOR'S COST.

**TYPICAL SYMBOLS**

EXISTING WALL, DOOR, WINDOW, MILLWORK, FIXTURE OR OTHER FIXTURE OR ASSEMBLY TO BE REMOVED

NEW WALL

SHOULDER FIRE RATED WALL


1-HOUR FIRE RATED WALL

2-HOUR FIRE RATED WALL

1-HOUR FIRE SMOKE RATED WALL

PROJECT LIMITS OF WORK

NO SIGNIFICANT DUCTWORK SHALL BE ROUTED THROUGH ELECTRICAL AND/OR DATA ROOMS.

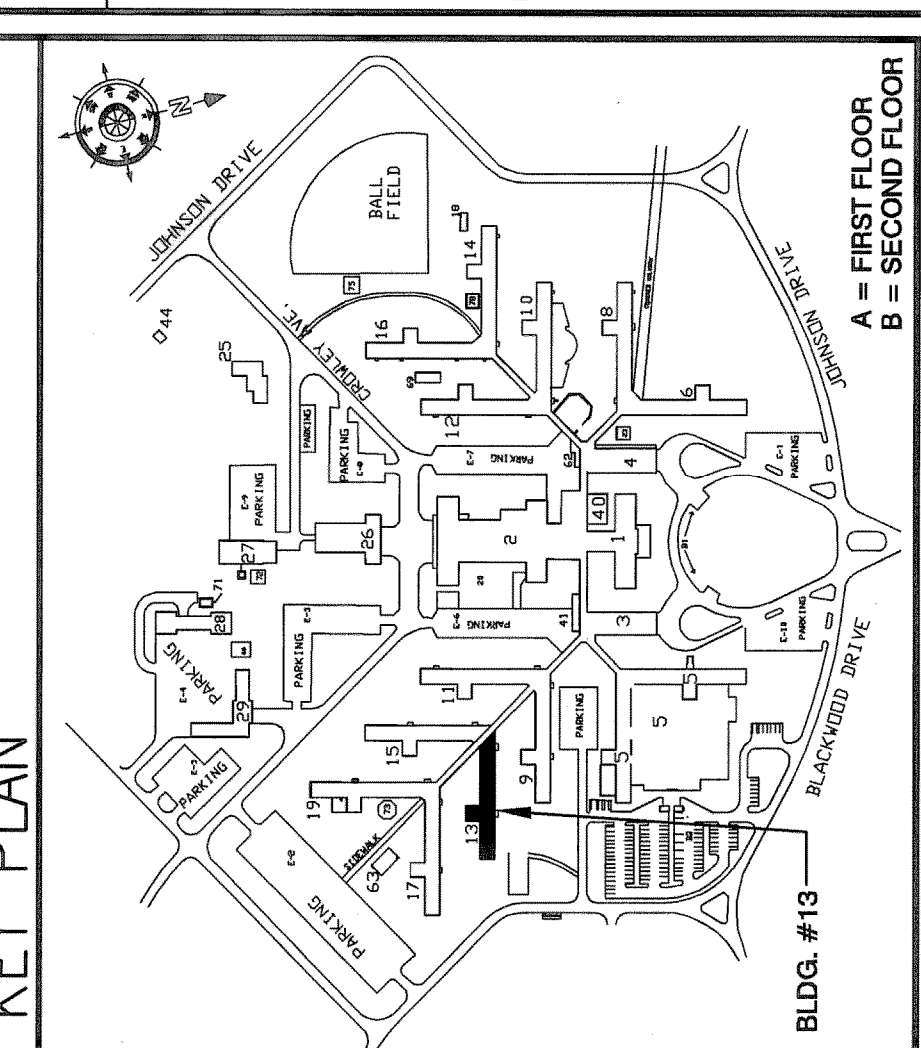

**ENLARGED PROCEDURE ROOM - LIGHTING TYPICAL**

(B7) SCALE: 1/4" = 1'-0"

**ELECTRICAL FLOOR PLAN - LIGHTING**

(F7) SCALE: 1/8" = 1'-0"

**100% SUBMITTAL**

<b>Department of Veterans Affairs</b>		<b>Medical Center</b>		<b>1826 Veterans Blvd.</b>		<b>Dublin, Ga. 31021</b>	
<b>Architect/Engineer Address</b>		<b>Hamrell, Saltrick &amp; Hopper</b>		<b>Design &amp; Management Solutions for the Built Environment</b>		<b>150 LOCUST STREET, SUITE 400</b>	
<b>Atlanta, Georgia 30303</b>		<b>Atlanta, Georgia 30303</b>		<b>Atlanta, Georgia 30303</b>		<b>Atlanta, Georgia 30303</b>	
<b>Phone: 404.525.1000</b>		<b>Phone: 404.525.1000</b>		<b>Phone: 404.525.1000</b>		<b>Phone: 404.525.1000</b>	
<b>Fax: 404.525.1001</b>		<b>Fax: 404.525.1001</b>		<b>Fax: 404.525.1001</b>		<b>Fax: 404.525.1001</b>	
<b>Copyright © 2011 Hamrell, Saltrick &amp; Hopper, PC</b>		<b>Copyright © 2011 Hamrell, Saltrick &amp; Hopper, PC</b>		<b>Copyright © 2011 Hamrell, Saltrick &amp; Hopper, PC</b>		<b>Copyright © 2011 Hamrell, Saltrick &amp; Hopper, PC</b>	
<b>Project Title</b>		<b>RENOVATE 13A FOR ENDOSCOPY SUITE</b>		<b>Project Number</b>		<b>557-10-108</b>	
<b>Date</b>		<b>June 10, 2011</b>		<b>Drawing No.</b>		<b>EL-101</b>	
<b>Recommended Approvals:</b>		<b>1. MEDICAL DIRECTOR</b>		<b>6. OPERATIONS SERVICE LINE MANAGER</b>		<b>Building Number</b>	
<b>2. ASSOCIATE DIRECTOR</b>		<b>7. INFECTION CONTROL SAFETY MANAGER</b>		<b>8. SAFETY MANAGER</b>		<b>13A</b>	
<b>3. CHIEF OF STAFF</b>		<b>9. GENERAL ENGINEER</b>		<b>10. COTR</b>		<b>Const. Contract No.</b>	
<b>4. ASSOC. DIRECTOR</b>		<b>5. SERVICE LINE MGRS.</b>		<b>Checked</b>		<b>Reviewed</b>	
<b>5. SERVICE LINE MGRS.</b>		<b>6. OPERATIONS SERVICE LINE MANAGER</b>		<b>7. INFECTION CONTROL SAFETY MANAGER</b>		<b>8. SAFETY MANAGER</b>	
<b>8. SAFETY MANAGER</b>		<b>9. GENERAL ENGINEER</b>		<b>10. COTR</b>		<b>11. PROJECT # 100A</b>	
<b>11. PROJECT # 100A</b>		<b>12. PROJECT # 100A</b>		<b>13. PROJECT # 100A</b>		<b>14. PROJECT # 100A</b>	
<b>14. PROJECT # 100A</b>		<b>15. PROJECT # 100A</b>		<b>16. PROJECT # 100A</b>		<b>17. PROJECT # 100A</b>	
<b>17. PROJECT # 100A</b>		<b>18. PROJECT # 100A</b>		<b>19. PROJECT # 100A</b>		<b>20. PROJECT # 100A</b>	
<b>314. PROJECT # 100A</b>		<b>315. PROJECT # 100A</b>		<b>316. PROJECT # 100A</b>		<b>317. PROJECT # 100A</b>	
<b>317. PROJECT # 100A</b>		<b>318. PROJECT # 100A</b>					